

WHEEL WASH SYSTEM GAD


Tolerance Where Not Specified							Drawn	Check	Appr.	
Over	Up To	Tol.		Over	Up To	Tol.	By.	SAHIL	MD	NS
--	10	±0.1		300	500	±2.0	Date.	15-12-25	15-12-25	15-12-25
10	30	±0.2		500	1000	±5.0	Sign.			
30	300	±0.3		1000	5000	±10.0	Note: All Dimension are in MM otherwise specified			
THIS DRAWING IS THE PROPERTY OF NISSAN CLEAN INDIA PVT. LTD. ANY PART OF THIS DRAWINGS SHOULD NOT BE COPIED OR LENT WITHOUT AUTHORITY OF NISSAN CLEAN INDIA PVT. LTD.							Drawing No.:			
							Product:			
							Material:			

NISSAN
CLEAN INDIA
INNOVATIVE WASH SYSTEM




Client : MORBI MUNICIPAL CORPORATION


Scale : 1:100
Title : G.A.D

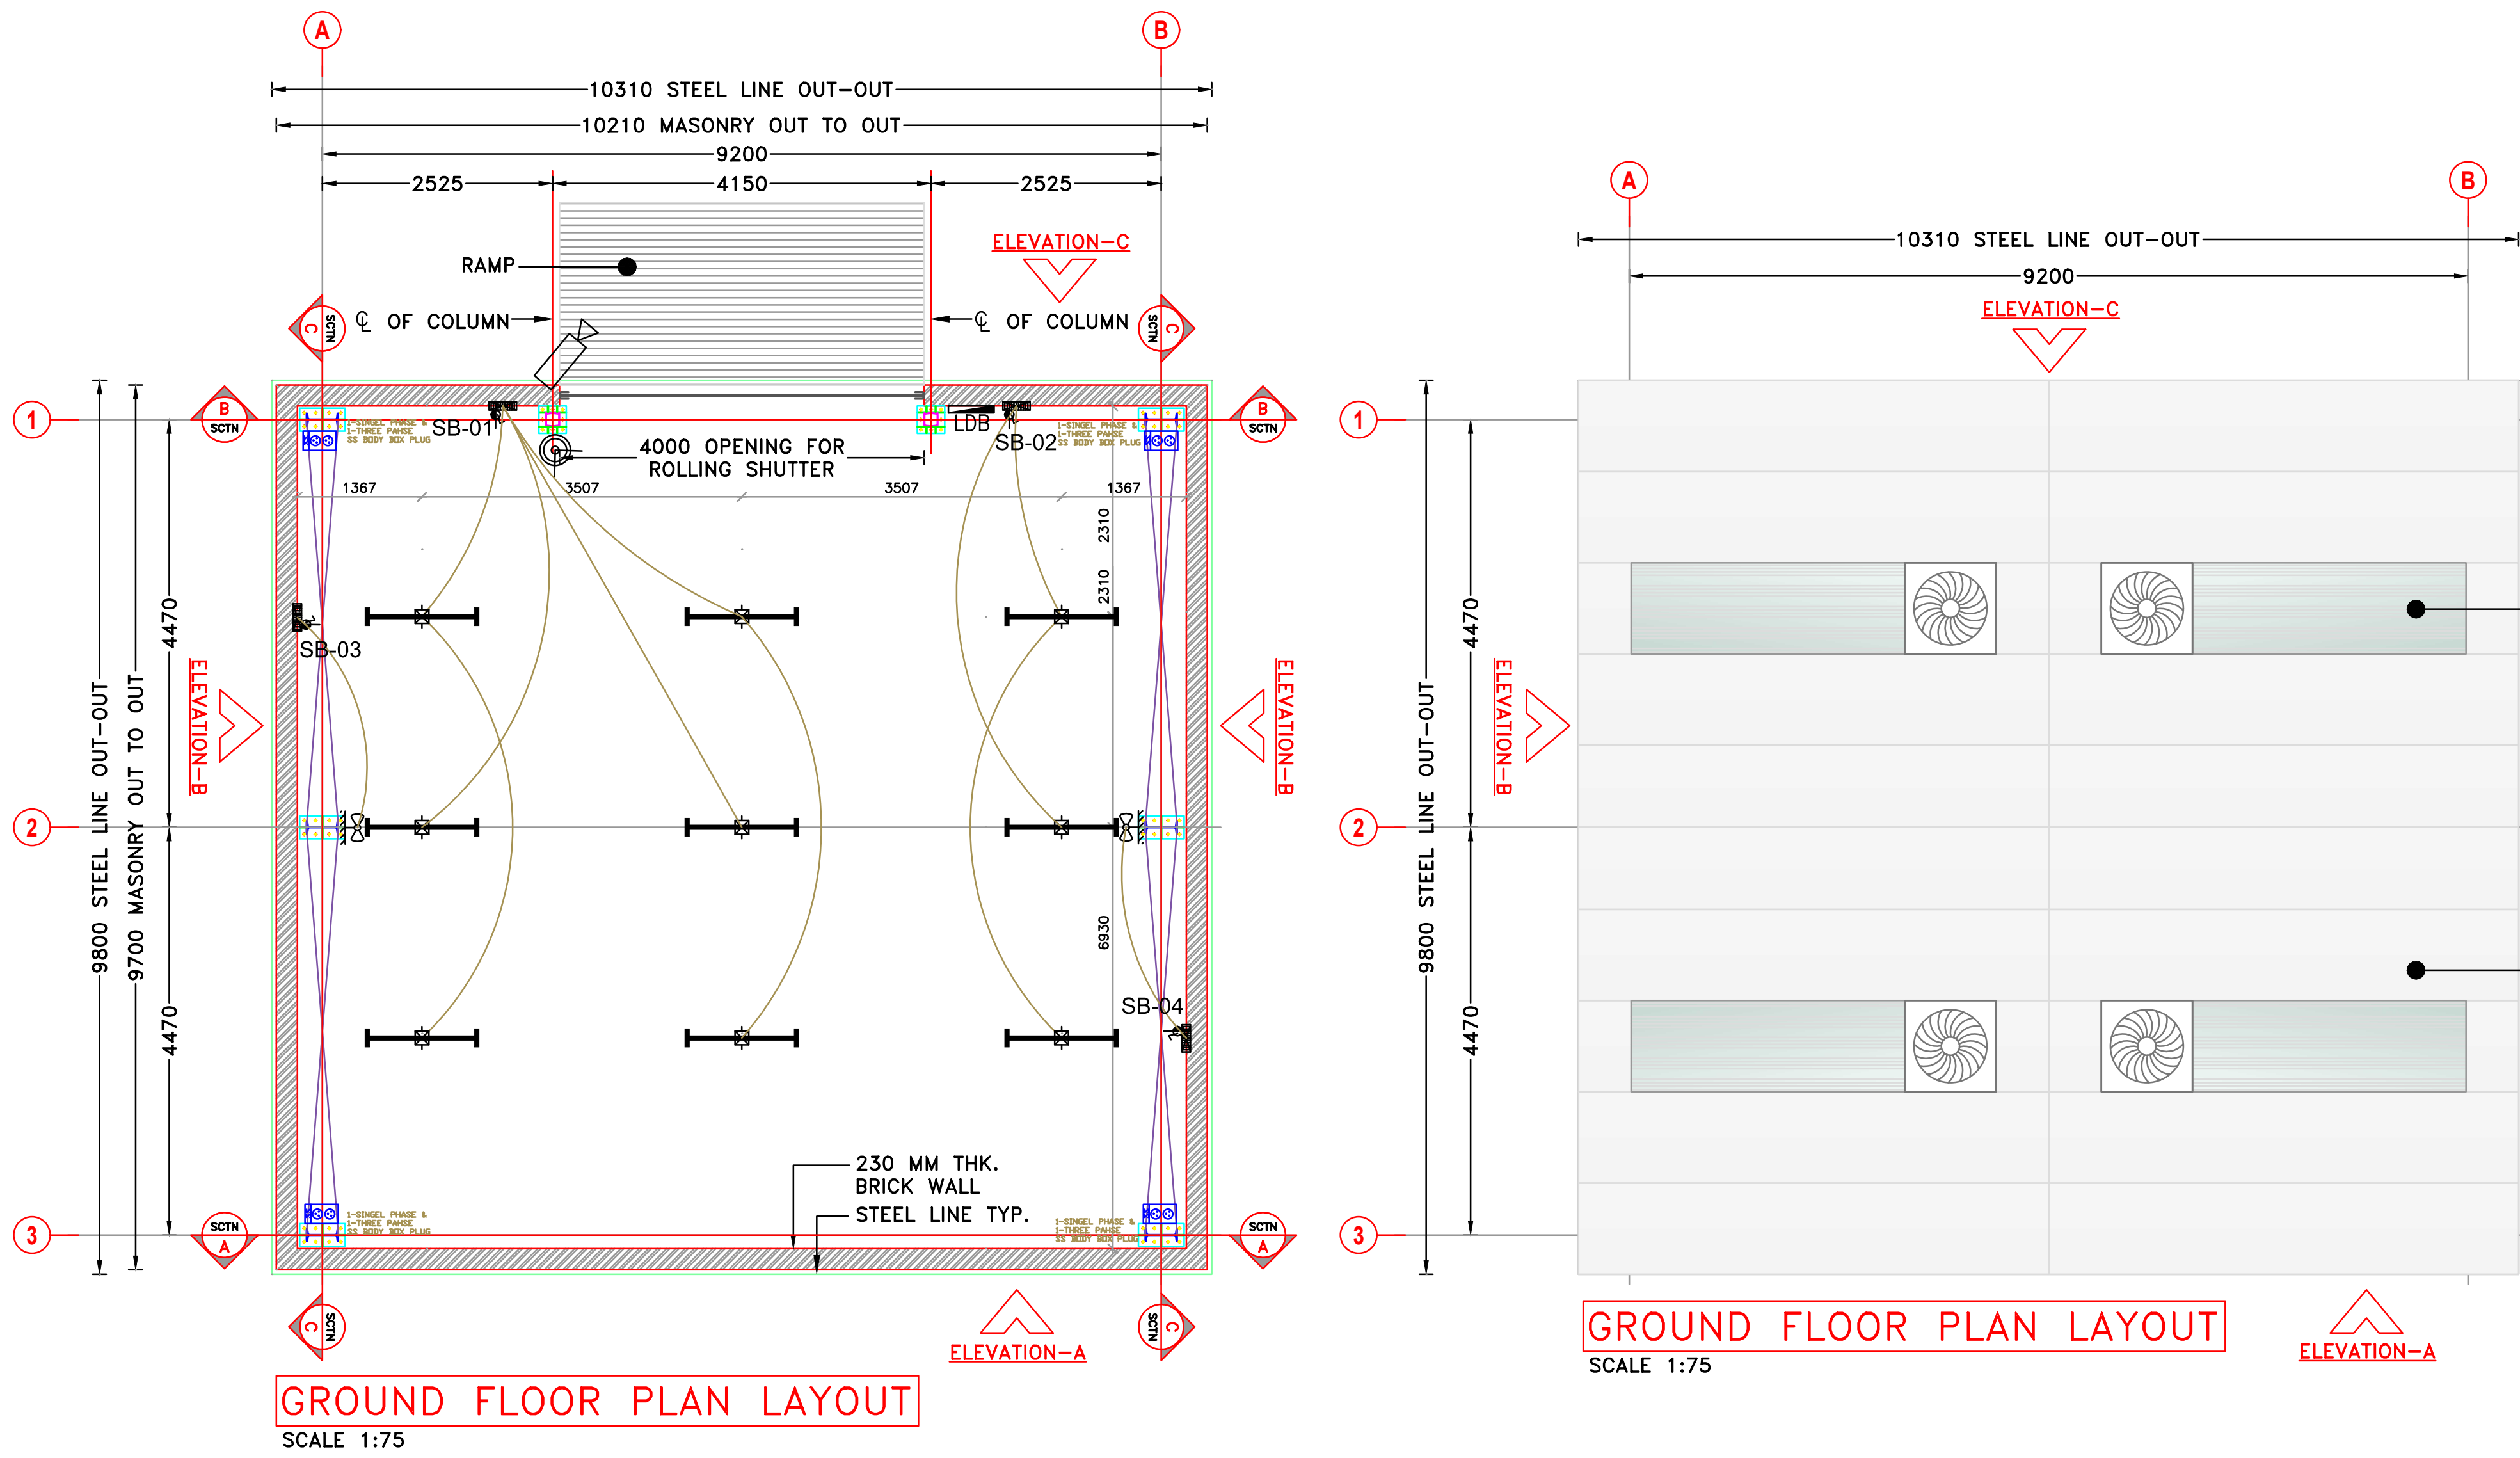


GROUND FLOOR PLAN LAYOUT
SCALE 1:75

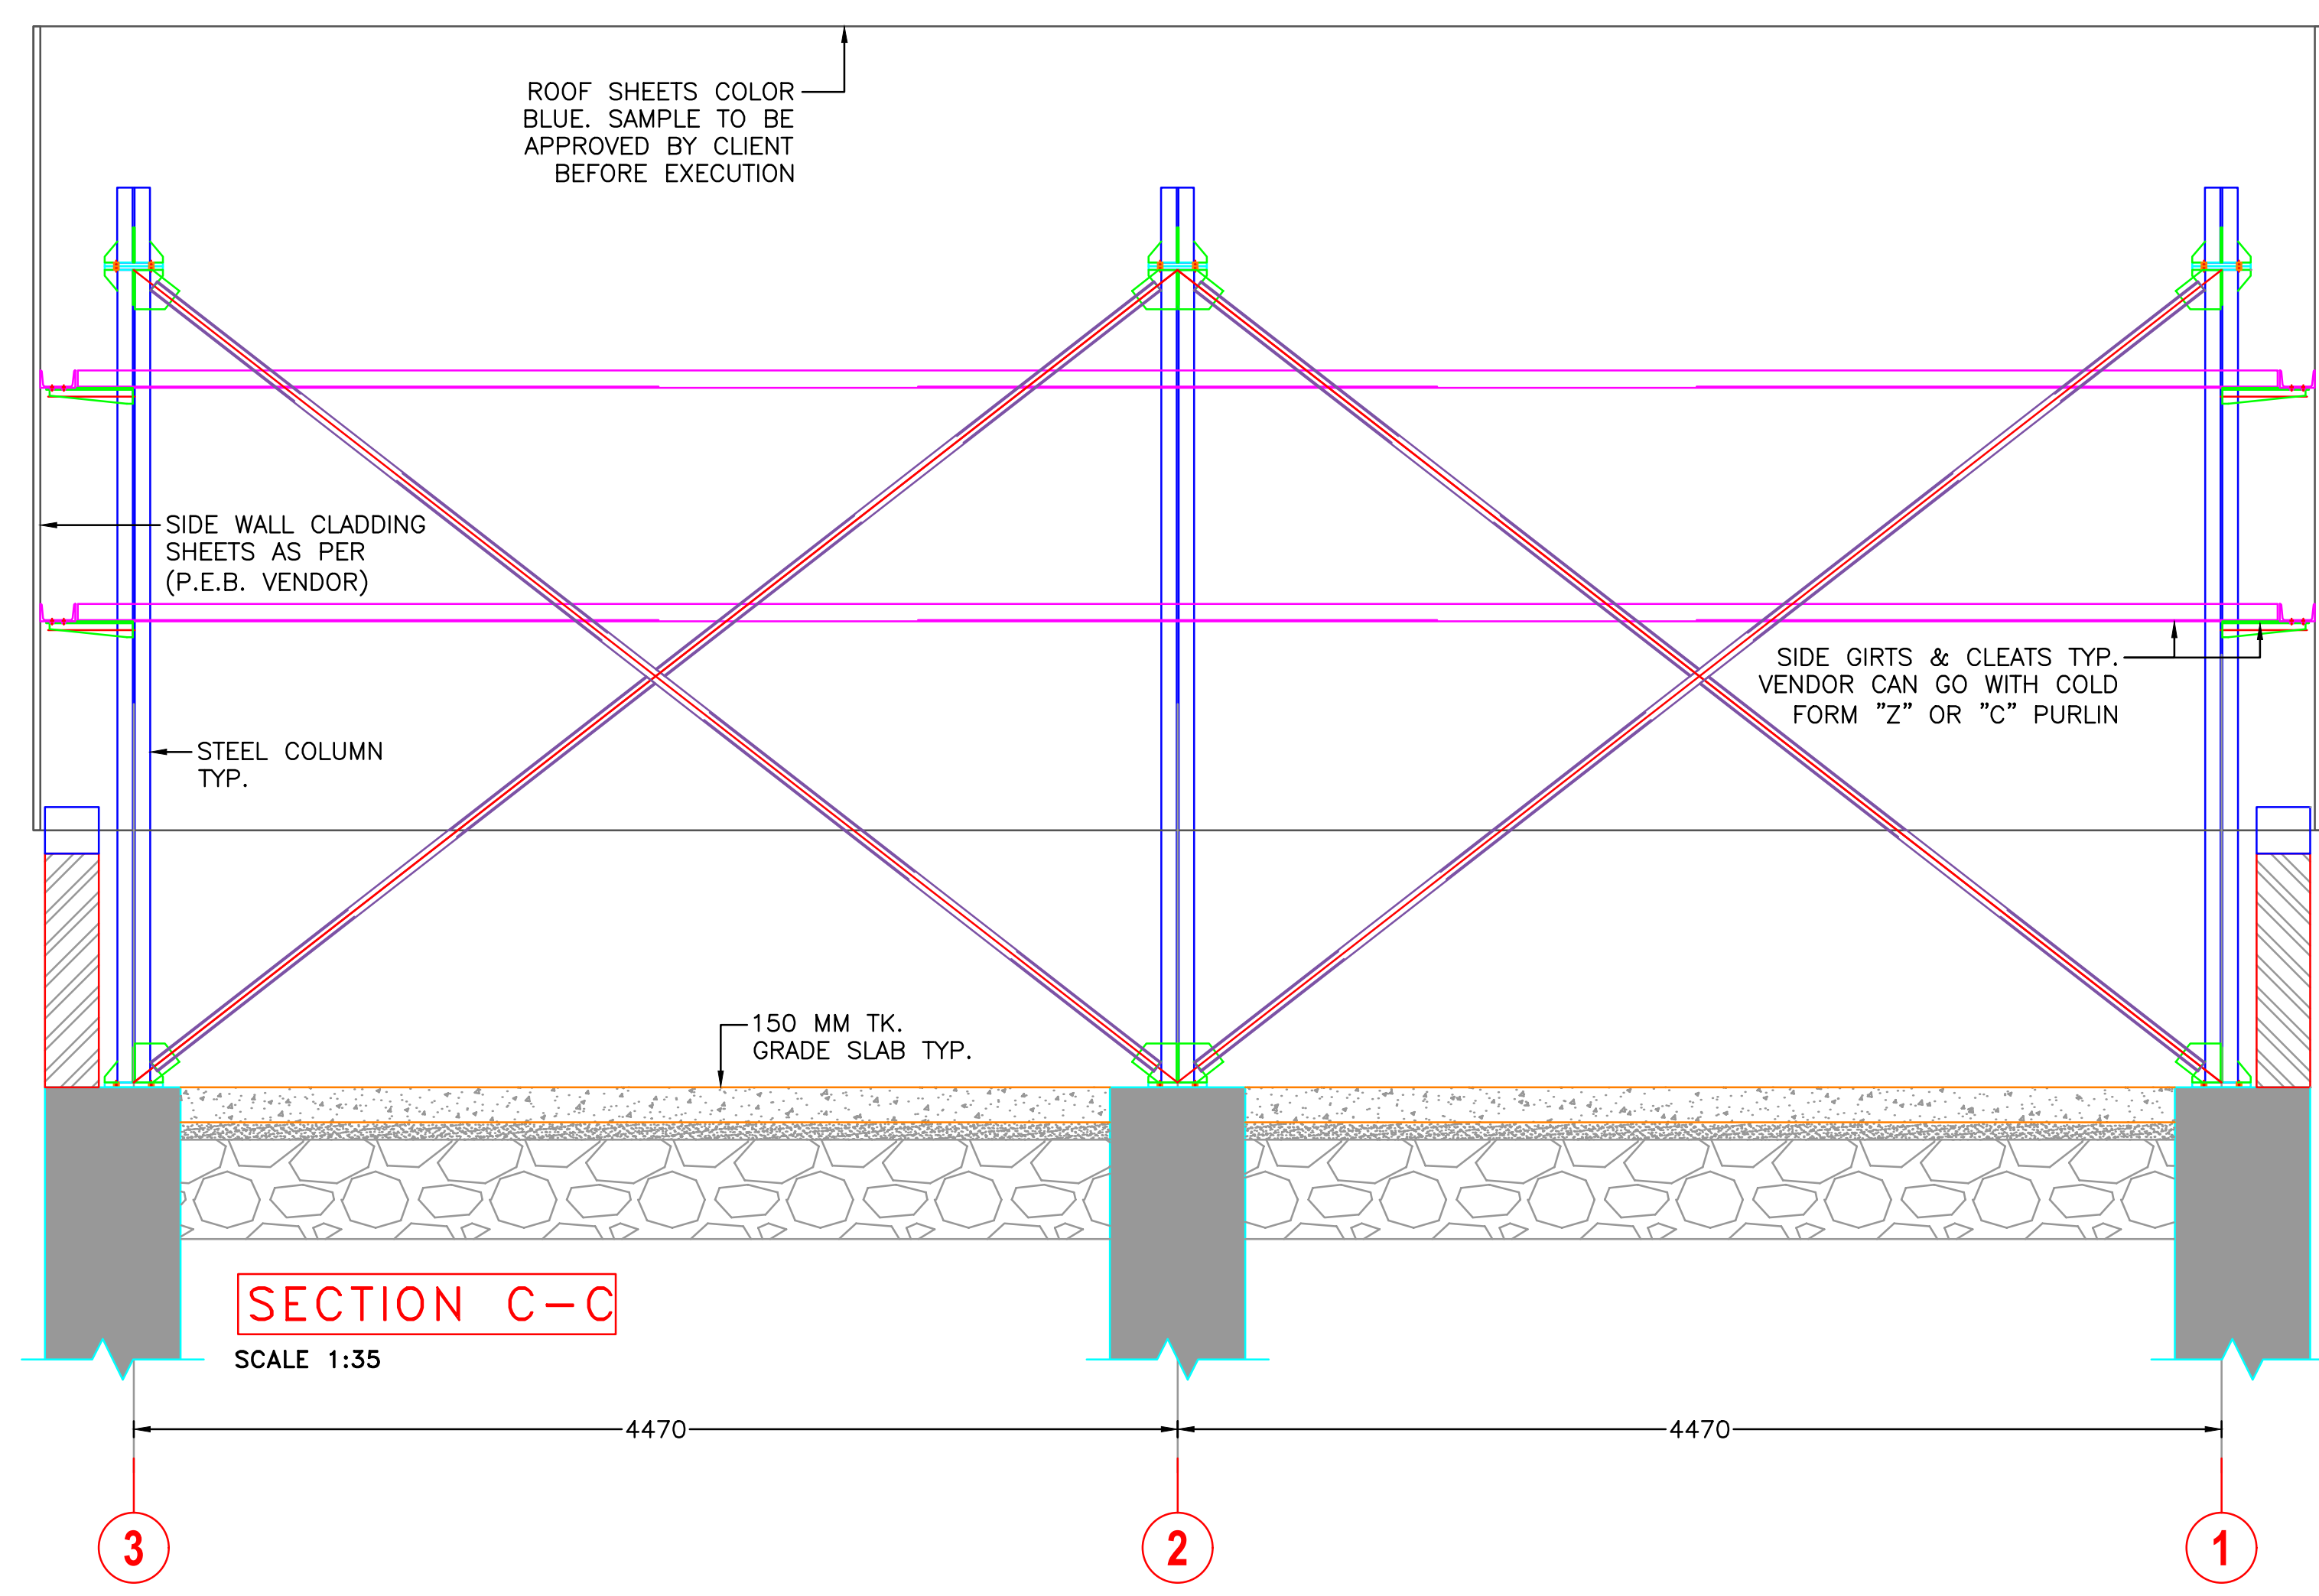

SECTION C-C
SCALE 1:35

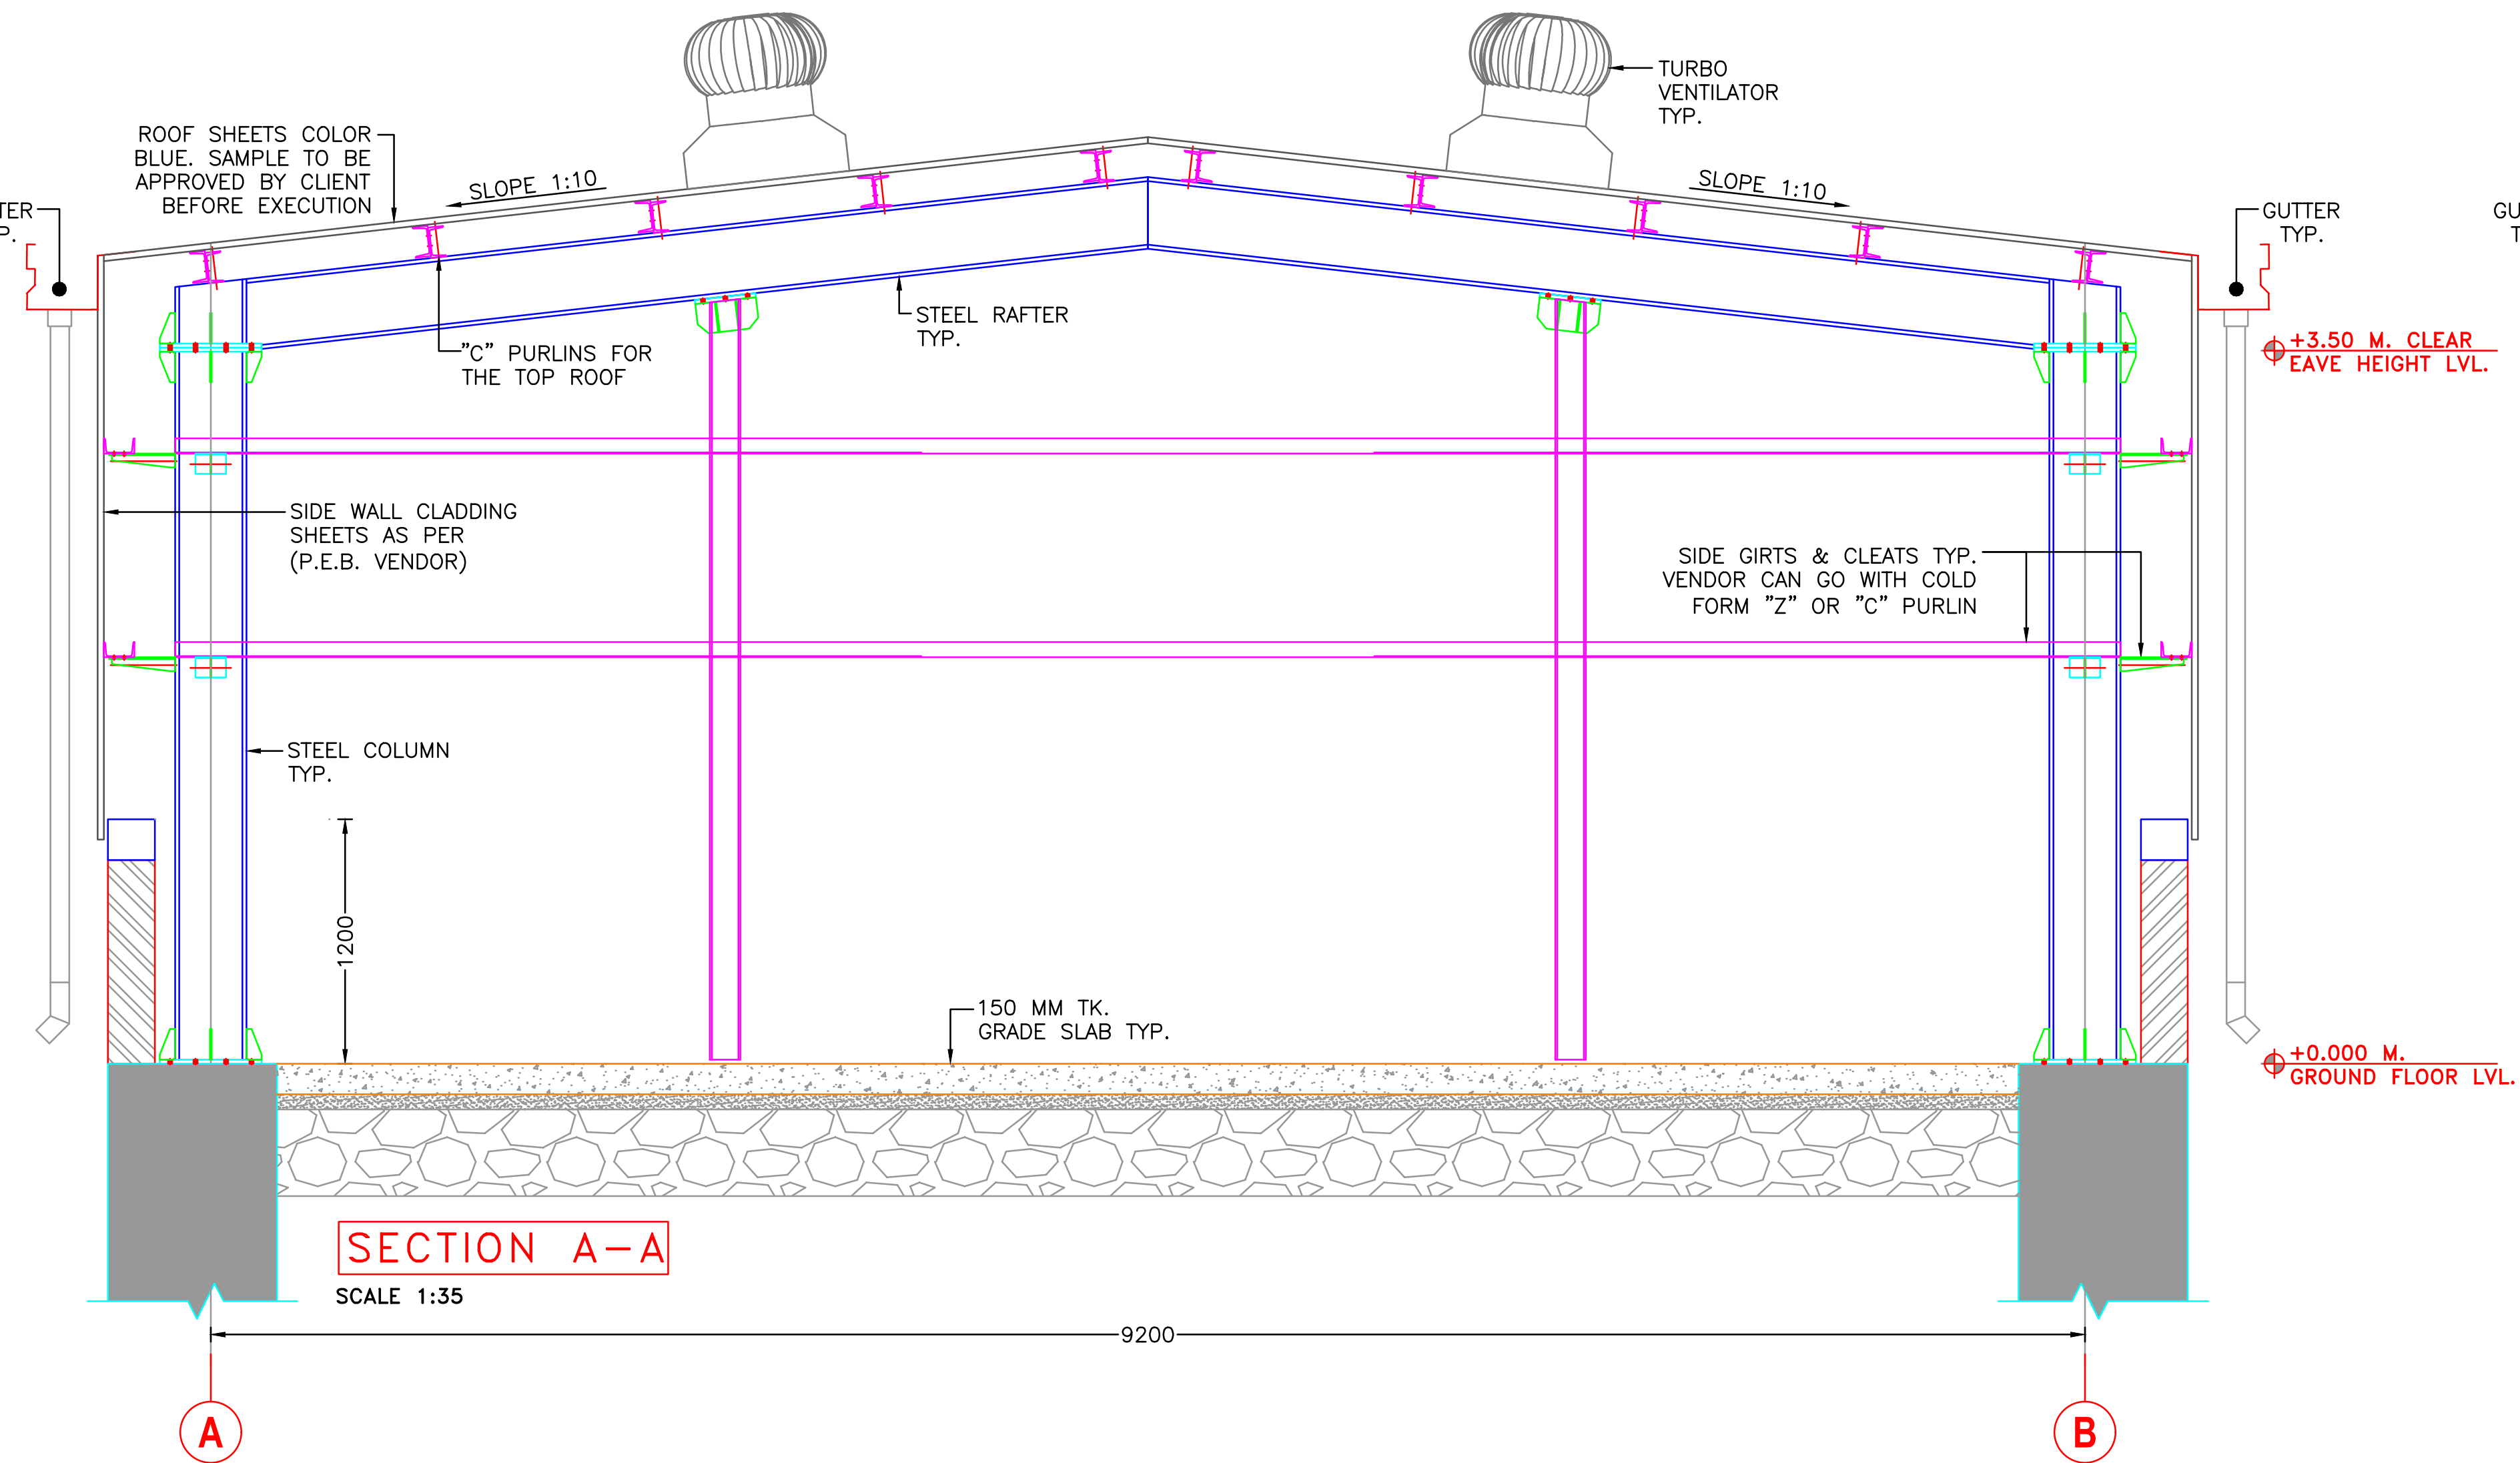

SECTION A-A
SCALE 1:35

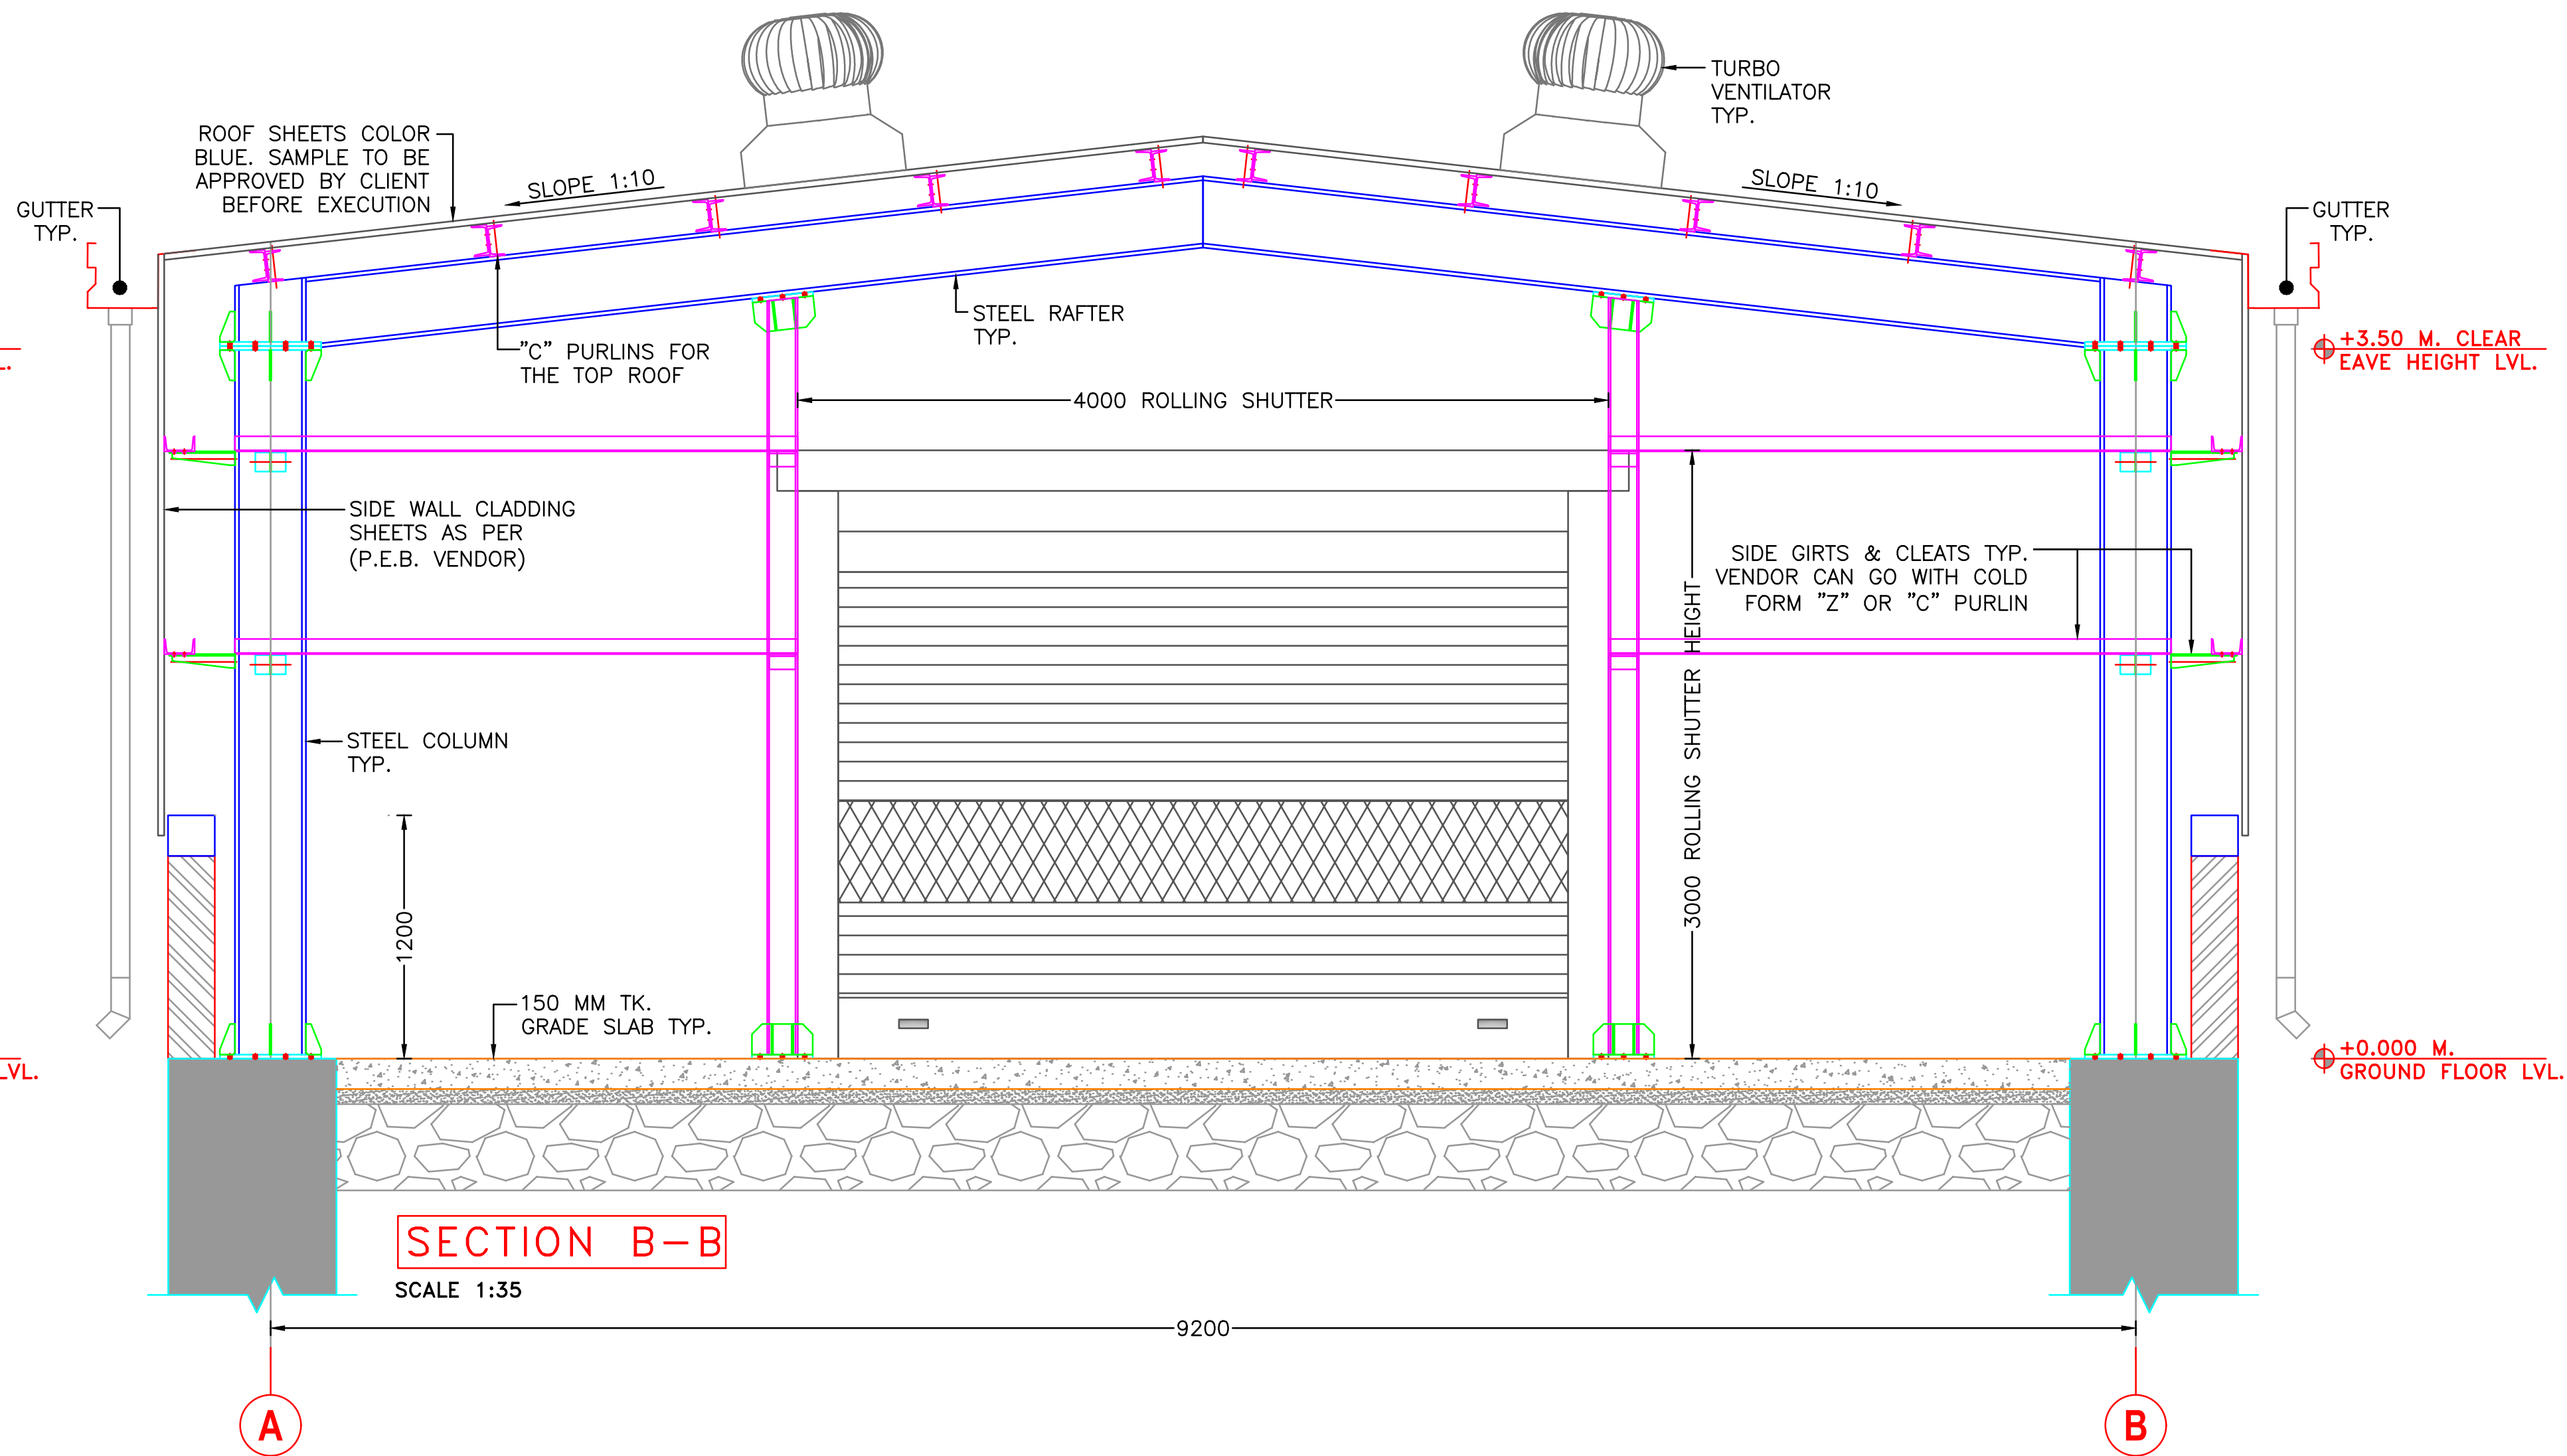

SECTION B-B
SCALE 1:35

LEGENDS :

T.Y.P.	= TYPICAL.
SCTN.	= SECTION.
H.	= HEIGHT.
W.	= WIDE.
M.	= METER.
D00	= DOOR.
W00	= WINDOW.
V00	= VENTILATION.

GRAPHICS LEGEND :

	R.C.C. FOR COLUMN
	R.C.C. FOR SLAB & PCC
	230 MM TK. MAIN WALL
	115 MM TK. PARTITION WALL
	115 MM TK. PLUMBING WALL
	300 X 300/600 X 600 MM TILING WORK
	GRANITE PLATFORM

LAYERS :

	COLUMN LINE
	SLAB LINE
	GRADE LINE
	CENTER LINE
	BEAM LINE
	MASONRY LINE
	GLASS LINE
	GRANITE STONE MARBLE TILE LINE

LEVELS :

	+FINISHED LVL.
	+UNFINISHED LVL.

WINDOW / VENTILATION / DOOR INDICATES OF NO.

	WINDOW / VENTILATION / DOOR INDICATES OF NO.
--	--

DEMANSIONS INDICATES OF ALPHABETS.

	DEMANSIONS INDICATES OF ALPHABETS.
--	------------------------------------

INDICATE OF LVL. DROP.

	INDICATE OF LVL. DROP.
--	------------------------

ELEVATION SYMBOL

	ELEVATION SYMBOL
--	------------------

CONFIDENTIAL STATEMENT:-
THIS DRAWING IS THE PROPERTY OF GERMI. THIS INFORMATION IS CONFIDENTIAL AND IS TO BE USED IN CONNECTION WITH WORK DESCRIBED BY GERMI. NO PART IS TO BE DISCLOSED OR COPY TO OTHER WITHOUT WRITTEN PERMISSION FROM GERMI.

- GENERAL NOTES:-**
- ALL DIMENSIONS ARE IN MILLIMETER AND ALL LEVELS ARE IN Meter UNLESS AND OTHERWISE SPECIFIED.
 - ALL THE DIMENSIONS SHALL BE READ & NOT TO BE MEASURED.
 - DRIP MOLD IS TO BE PROVIDED AT EXTERNAL WINDOW LINTELS.
 - ARCHITECTURAL DRAWINGS MUST ALWAYS BE READ IN CONJUNCTION WITH ALL OTHER RELEVANT SERVICES DRAWINGS AND CONTRACT DOCUMENTS. ANY DISCREPANCY BETWEEN THESE DRAWING SAND DOCUMENTS SHOULD BE REPORTED TO THE ENGINEER FOR CLARIFICATION AND VERIFICATION.
 - OR ALL FLOORING MUST BE (KOTA STONE).
 - FOR TOILET FLOORING MUST BE (ANTI SKID TILES).
 - FOR TERRACE FLOORING MUST BE (CHINA MOSAIC).

CLIENT

ADDRESS:
MORBI MUNICIPAL CORPORATION
15, Vasant Plot Main Road,
Sardar Nagar, Morbi-363641

CONSULTANTS

ADDRESS:
GUJARAT ENERGY RESEARCH & MANAGEMENT INSTITUTE
1st FLOOR, ENERGY BUILDING PDPU CAMPUS, RAISAN VILLAGE, GANDHINAGAR, GUJARAT-382 007
CONTACT:
+91-9601986496,
pvorastructure@gmail.com
www.pvora.in

REV.	DATE	PURPOSE	BY
R0	12-01-26	ISSUE FOR TENDER PURPOSE	RD

REVISION HISTORY

PROJECT NUMBER:-	6225
BUILDING NAME:-	ENGINEERING STORE
PROJECT NAME:-	NEW SLF FOR LALPUR SITE, MORBI

DRAWN:-	RAVINDRA	DATE:-	12-01-2026
CHECK:-	YOGENDU		
APPROVE:-	P.S.RAO	SCALE:-	AS SHOWN

DRAWING TITLE:-
ENGINEERING STORE ELECTRICAL LAYOUT

DRAWING NO	REVISION	SHEET	FOR
TATVA-M-02	R0	A1	T TENDER

THIS IS ONLY FOR TENDER NOT FOR CONSTRUCTION. BEFORE STARTING CONSTRUCTION ALL DRAWING TO BE VERIFIED BY CONCERN AUTHORITY

THIS IS ONLY FOR TENDER NOT FOR
CONSTRUCTION. BEFORE STARTING
CONSTRUCTION ALL DRAWING TO BE
VERIFIED BY CONCERN AUTHORITY

LEGENDS :	
T.Y.P.	= TYPICAL.
SCTN.	= SECTION
H.	= HEIGHT.
W.	= WIDE.
M.	= METER.
D00	= DOOR.
W00	= WINDOW.
V00	= VENTILATION.

GRAPHICS LEGEND :	
	R.C.C. FOR COLUMN
	R.C.C. FOR SLAB & PCC
	230 MM TK. MAIN WALL
	115 MM TK. PARTION WALL
	115 MM TK. PLUMBING WALL
	300 X 300/600 X 600 MM TILING WORK
	GRANITE PLATFORM
LAYERS :	
	COLUMN LINE
	SLAB LINE
	GRIDE LINE
	CENTER LINE
	BEAM LINE
	MASONARY LINE
	GLASS LINE
	GRANITE STONE MARBOLE TILE LINE
	±FINISHED LVL.
	+UNFINISHED LVL.
	±FINISHED LVL.
	+UNFINISHED LVL.
	WINDOW / VENTILATION / DOOR INDICATES OF NO.
	DEMANIONS INDICATES OF ALPHABETS.
	INDICATE OF LVL. DROP.
	ELEVATION SYMBOL

LEGEND	QUANTITY
SMD BAYSTORM-2 LED Highbay Luminaire 70LPW	8
(WF) WALL MOUNTED FAN POINT	3
INDOOR CAMERA POINT	2
DOME CAMERA POINT	2
SWITCH CIRCUIT CONTROL	
1-SINGEL PHASE&	15M
1-THREE PAHSE SS BODY BOX PLUG	32M
(SB) SWITCH BOARD	1200 mm 4' 0"
(P) 5A SWITCH SOCKET OUTLET	1200 mm 4' 0"
LIGHTING DISTRIBUTION BOARD	2400 mm 8 FT

CONFIDENTIAL STATEMENT:-

THIS DRAWING IS THE PROPERTY OF GERMI. THIS INFORMATION IS CONFIDENTIAL AND IS TO BE USED IN CONNECTION WITH WORK DESCRIBED BY GERMI. NO PART IS TO BE DISCLOSED OR COPY TO OTHER WITHOUT WRITTEN PERMISSION FROM GERMI.

GENERAL NOTES:-

- ALL DIMENSIONS ARE IN MILLIMETER AND ALL LEVELS ARE IN Meter UNLESS AND OTHERWISE SPECIFIED.
- ALL THE DIMENSIONS SHALL BE READ & NOT TO BE MEASURED.
- DRIP MOLD IS TO BE PROVIDED AT EXTERNAL WINDOW LINTELS.
- ARCHITECTURAL DRAWINGS MUST ALWAYS BE READ IN CONJUNCTION WITH ALL OTHER RELEVANT SERVICES DRAWINGS AND CONTRACT DOCUMENTS. ANY DISCREPANCY BETWEEN THESE DRAWING SAND DOCUMENTS SHOULD BE REPORTED TO THE ENGINEER FOR CLARIFICATION AND VERIFICATION.
- OR ALL FLOORING MUST BE (KOTA STONE).
- FOR TOILET FLOORING MUST BE (ANTI SKID TILES).
- FOR TERRACE FLOORING MUST BE (CHINA MOSAIC).

CLIENT



ADDRESS:

MORBI MUNICIPAL CORPORATION
15, Vasant Plot Main Road,
Sardar Nagar, Morbi-363641

CONSULTANTS



ADDRESS:

GUJARAT ENERGY RESEARCH &
MANAGEMENT INSTITUTE
1st FLOOR, ENERGY BUILDING PDP
CAMPUS, RAISAN VILLAGE,
GANDHINAGAR,
GUJARAT-382 007
CONTACT:
+91-9601986496,
pvorastructure@gmail.com
www.pvora.in

REV.	DATE	PURPOSE	BY
R0	12-01-2026	-	RD
REVI.	DATE	PURPOSE	BY

REVISION HISTORY

PROJECT NUMBER:- 6225

BUILDING NAME:- ENGINEERING STORE

PROJECT NAME:-

NEW SLF FOR LALPUR SITE, MORBI

DRAWN:- RAVINDRA

DATE:-

12-01-2026

CHECK:-

YOGENDU

APPROVE:-


P.S.RAO

SCALE:- AS SHOWN

DRAWING TITLE:-

PRE-TREATMENT GRINDER SHED ELECTRICAL
_LAYOUT

DRAWING NO	REVISION	SHEET	FOR
TATVA-M-03	R0	A1	T TENDER

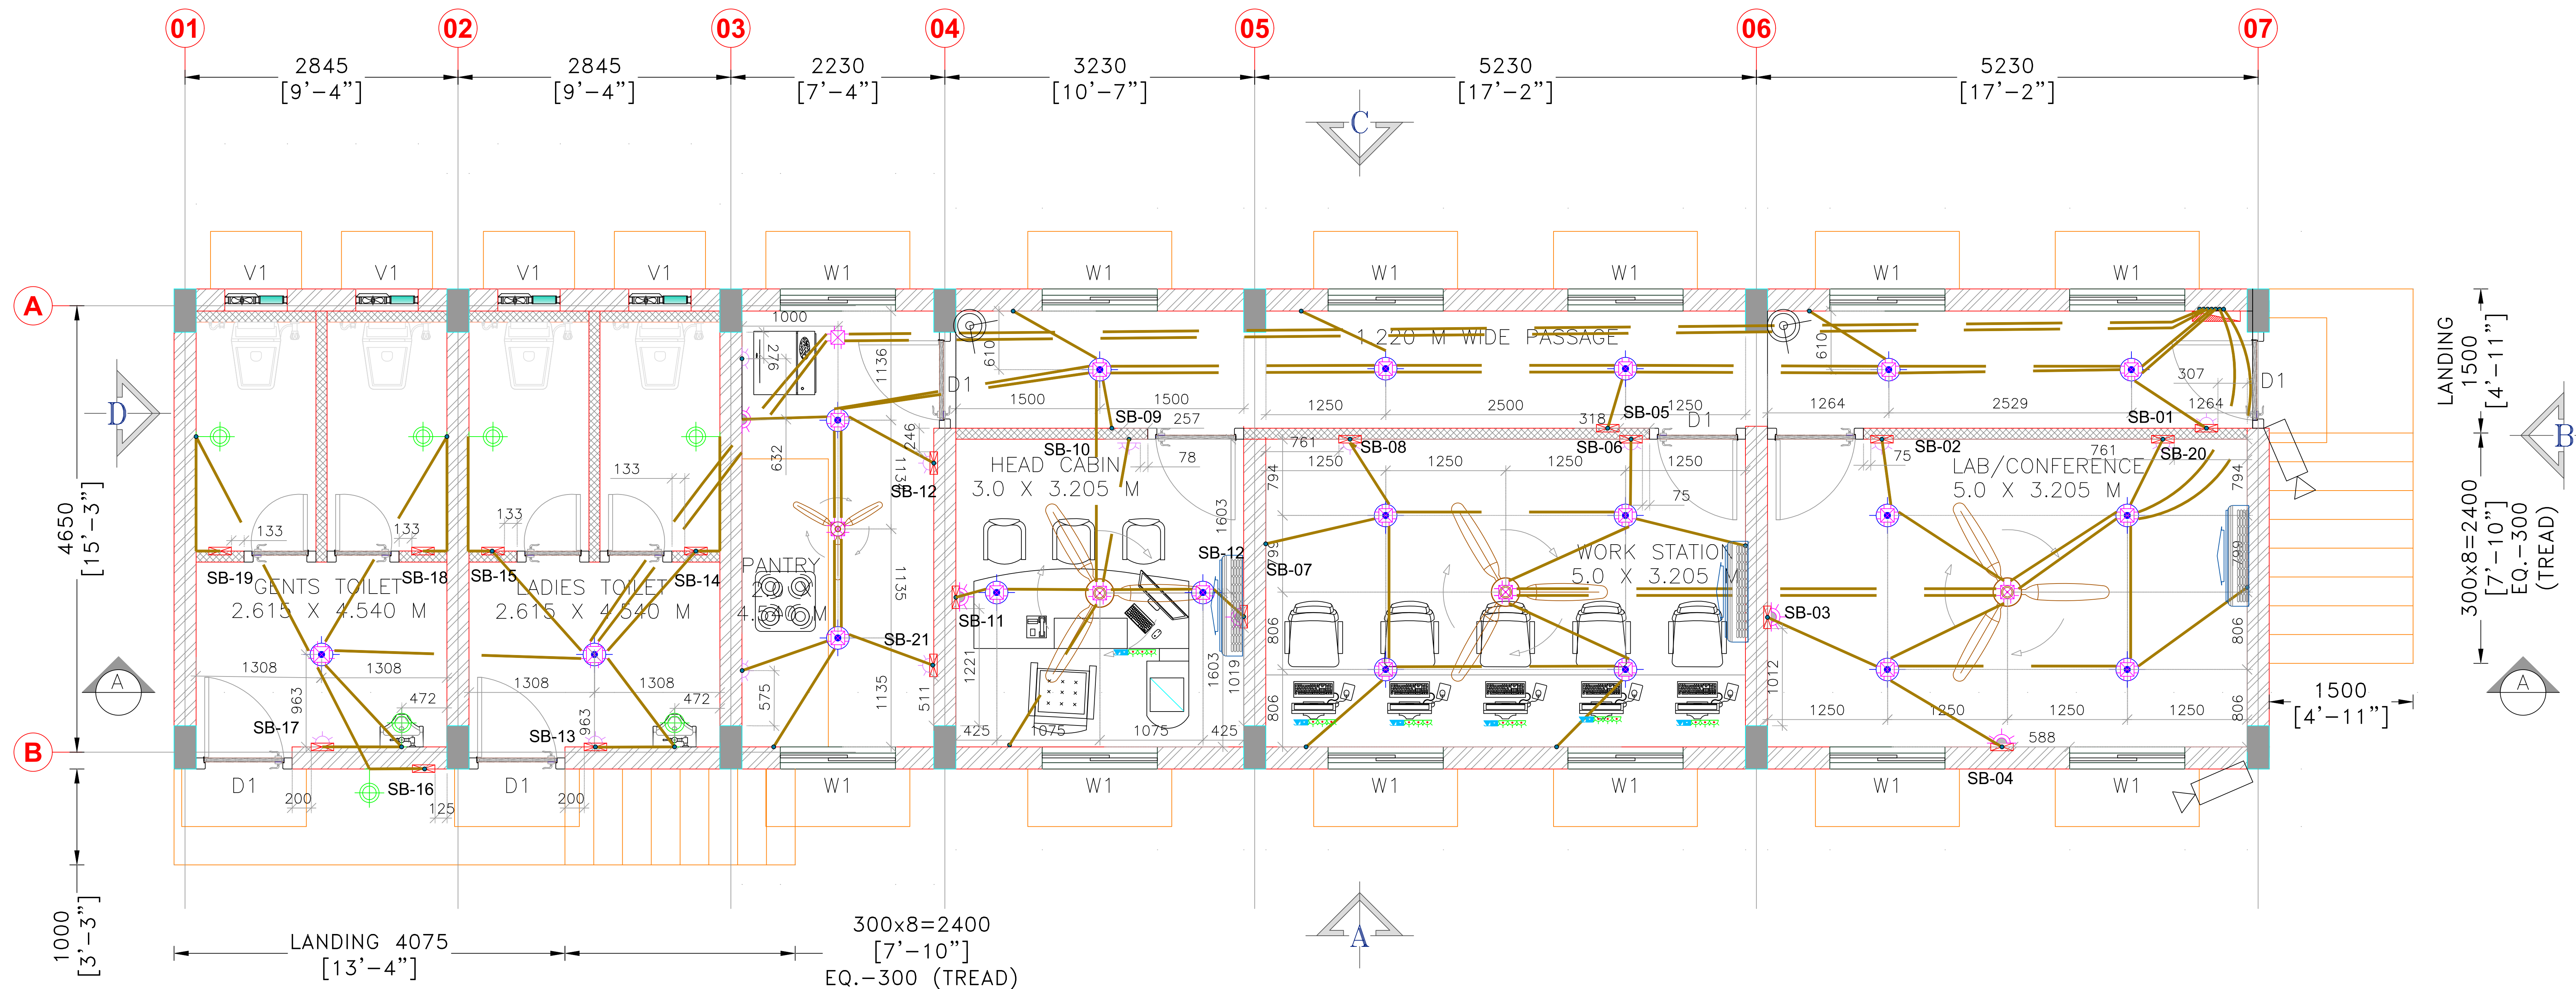

GROUND FLOOR PLAN LAYOUT @ (±00.00 M. LVL.)

SCALE 1:75

LEGEND	QTY.	HEIGHT
CEILING FAN	01	
BRACKET LIGHT POINT	07	
SWITCHBOARD	21	1200 MM
SA PLUG POINT	14	
15A PLUG POINT	05	
LIGHTING DISTRIBUTION BOARD	01	2100 MM
CONDUIT VERTICAL DROP	41	
TRAY JUNCTION BOX	01	
25MM DIA PVC CONDUIT		
WORK STATION (1 No. 6A RP SSD + 2 Nos. 6A UPS SSD + 1 No. DATA + 1 TELEPHONE)	06	
CEILING POINT	19	
A.C. POINT	03	
BULLET CAMERA	02	
DOME CAMERA	02	

CONFIDENTIAL STATEMENT:-
THIS DRAWING IS THE PROPERTY OF P.VORA DESIGN AND ENGINEERING CONSULTANTS. THIS INFORMATION IS CONFIDENTIAL AND IS TO BE USED IN CONNECTION WITH WORK DESCRIBED BY P.VORA DESIGN AND ENGINEERING CONSULTANTS. NO PART IS TO BE DISCLOSED OR COPY TO OTHER WITHOUT WRITTEN PERMISSION FROM P.VORA DESIGN AND ENGINEERING CONSULTANTS.

- GENERAL NOTES:-**
- ALL DIMENSIONS ARE IN MILLIMETER AND ALL LEVELS ARE IN Meter UNLESS OTHERWISE SPECIFIED.
 - ALL THE DIMENSIONS SHALL BE READ & NOT TO BE MEASURED.
 - DRIP MOLD IS TO BE PROVIDED AT EXTERNAL WINDOW LINTELS.
 - ARCHITECTURAL DRAWINGS MUST ALWAYS BE READ IN CONJUNCTION WITH ALL OTHER RELEVANT SERVICES DRAWINGS AND CONTRACT DOCUMENTS ANY DISCREPANCY BETWEEN THESE DRAWING SAND DOCUMENTS SHOULD BE REPORTED TO THE ENGINEER FOR CLARIFICATION AND VERIFICATION.
 - FOR ALL FLOORING MUST BE (KOTA STONE)
 - FOR TOILET FLOORING MUST BE (ANTI SKID TILES)
 - FOR TERRACE FLOORING MUST BE (CHINA MOSAIC)
 - PARKING AND DRIVE MUST BE IN TRIMIX FINISH.

ADDRESS:
MORBI MUNICIPAL CORPORATION
15, Vasant Plot Main Road,
Sardar Nagar, Morbi-363641

CONSULTANTS
GUJARAT ENERGY RESEARCH & MANAGEMENT INSTITUTE
1st FLOOR, ENERGY BUILDING PDRU CAMPUS, RAISAN VILLAGE, GANDHINAGAR, GUJARAT-382 007
CONTACT:
+91-9601986496,
pvorastructure@gmail.com
www.pvora.in


R0	00-00-00		PJV
DATE	PURPOSE	BY	

PROJECT NUMBER:-	6225
BUILDING NAME:-	ADMIN BUILDING
PROJECT NAME:-	NEW SLF FOR LALPUR SITE, MORBI

DRAWN:-	RAVINDRA	DATE:-	11-12-2025
CHECK:-	YOGENDU		
APPROVE:-	P.S.RAO	SCALE:-	VARY

DRAWING TITLE:-
ADMIN BUILDING_CONDUIT_LAYOUT

DRAWING NO	REVISION	SHEET	FOR
TATVA-M-04	R0	A1	T APPROVAL

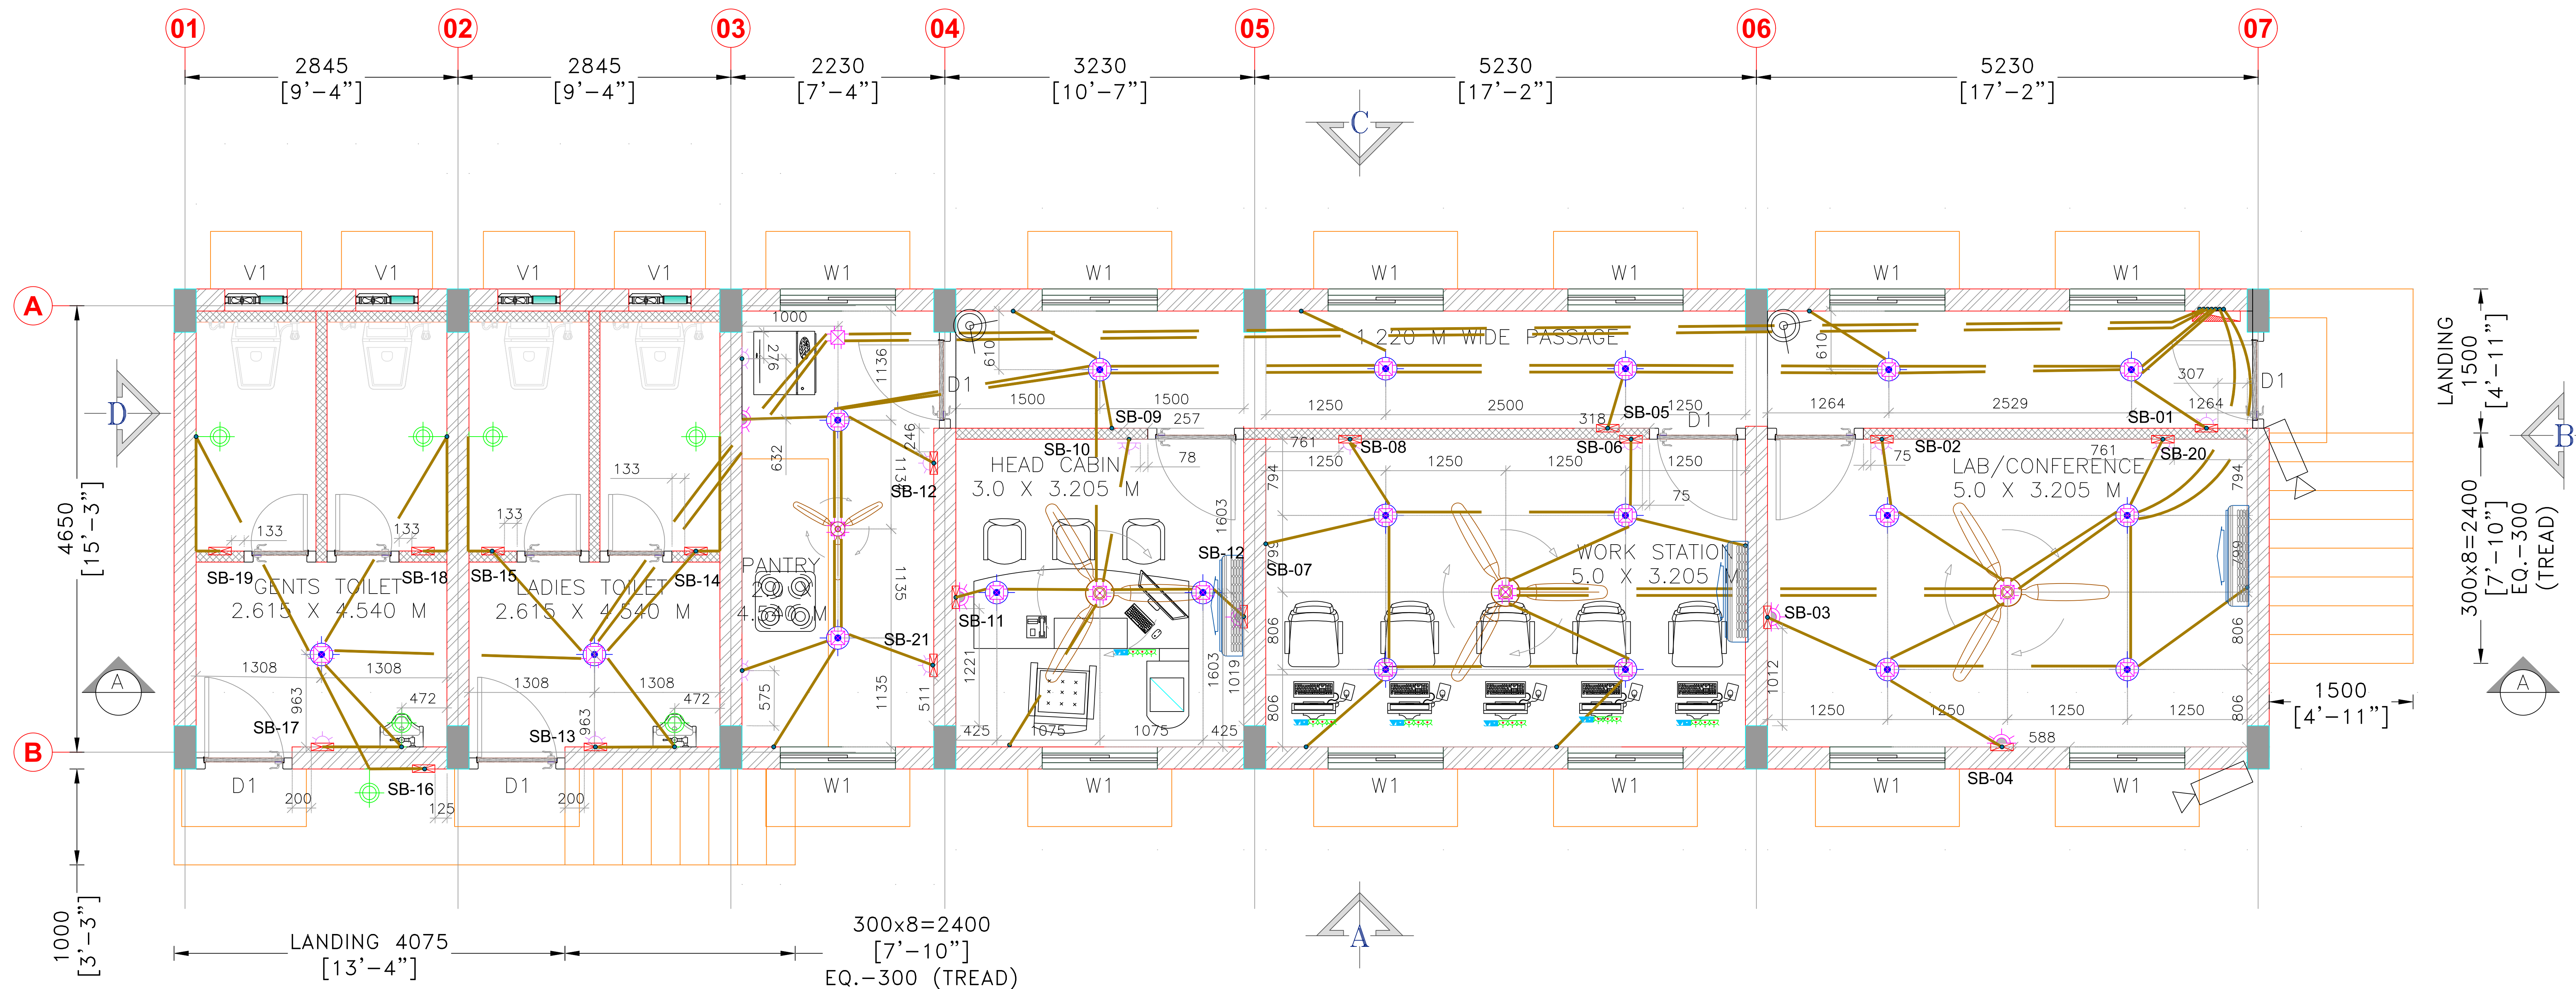

GROUND FLOOR PLAN LAYOUT @ (±00.00 M. LVL.)

SCALE 1:75

LEGEND	QTY.	HEIGHT
CEILING FAN	01	
BRACKET LIGHT POINT	07	
SWITCHBOARD	21	1200 MM
SA PLUG POINT	14	
15A PLUG POINT	05	
LIGHTING DISTRIBUTION BOARD	01	2100 MM
CONDUIT VERTICAL DROP	41	
FAN JUNCTION BOX	01	
25MM DIA PVC CONDUIT		
WORK STATION (1 No. 6A RP SSD + 2 Nos. 6A UPS SSD + 1 No. DATA + 1 TELEPHONE)	06	
CEILING POINT	19	
A.C. POINT	03	
BULLET CAMERA	02	
DOME CAMERA	02	

CONFIDENTIAL STATEMENT:-
THIS DRAWING IS THE PROPERTY OF P.VORA DESIGN AND ENGINEERING CONSULTANTS. THIS INFORMATION IS CONFIDENTIAL AND IS TO BE USED IN CONNECTION WITH WORK DESCRIBED BY P.VORA DESIGN AND ENGINEERING CONSULTANTS. NO PART IS TO BE DISCLOSED OR COPY TO OTHER WITHOUT WRITTEN PERMISSION FROM P.VORA DESIGN AND ENGINEERING CONSULTANTS.

- GENERAL NOTES:-**
- ALL DIMENSIONS ARE IN MILLIMETER AND ALL LEVELS ARE IN Meter UNLESS OTHERWISE SPECIFIED.
 - ALL THE DIMENSIONS SHALL BE READ & NOT TO BE MEASURED.
 - DRIP MOLD IS TO BE PROVIDED AT EXTERNAL WINDOW LINTELS.
 - ARCHITECTURAL DRAWINGS MUST ALWAYS BE READ IN CONJUNCTION WITH ALL OTHER RELEVANT SERVICES DRAWINGS AND CONTRACT DOCUMENTS ANY DISCREPANCY BETWEEN THESE DRAWING SAND DOCUMENTS SHOULD BE REPORTED TO THE ENGINEER FOR CLARIFICATION AND VERIFICATION.
 - FOR ALL FLOORING MUST BE (KOTA STONE)
 - FOR TOILET FLOORING MUST BE (ANTI SKID TILES)
 - FOR TERRACE FLOORING MUST BE (CHINA MOSAIC)
 - PARKING AND DRIVE MUST BE IN TRIMIX FINISH.

ADDRESS:
MORBI MUNICIPAL CORPORATION
15, Vasant Plot Main Road,
Sardar Nagar, Morbi-363641

CONSULTANTS
GUJARAT ENERGY RESEARCH & MANAGEMENT INSTITUTE
1st FLOOR, ENERGY BUILDING PDRU CAMPUS, RAISAN VILLAGE, GANDHINAGAR, GUJARAT-382 007
CONTACT:
+91-9601986496,
pvorastructure@gmail.com
www.pvora.in


DATE	PURPOSE	BY
R0	12-01-26	RD

PROJECT NUMBER:- 6225
BUILDING NAME:- ADMIN BUILDING
PROJECT NAME:- NEW SLF FOR LALPUR SITE, MORBI

DRAWN:- RAVINDRA
CHECK:- YOGENDU
APPROVE:- P.S.RAO


DATE:- 12-01-2026
SCALE:- VARY

DRAWING NO	REVISION	SHEET	FOR
TATVA-M-04	R0	A1	T APPROVAL

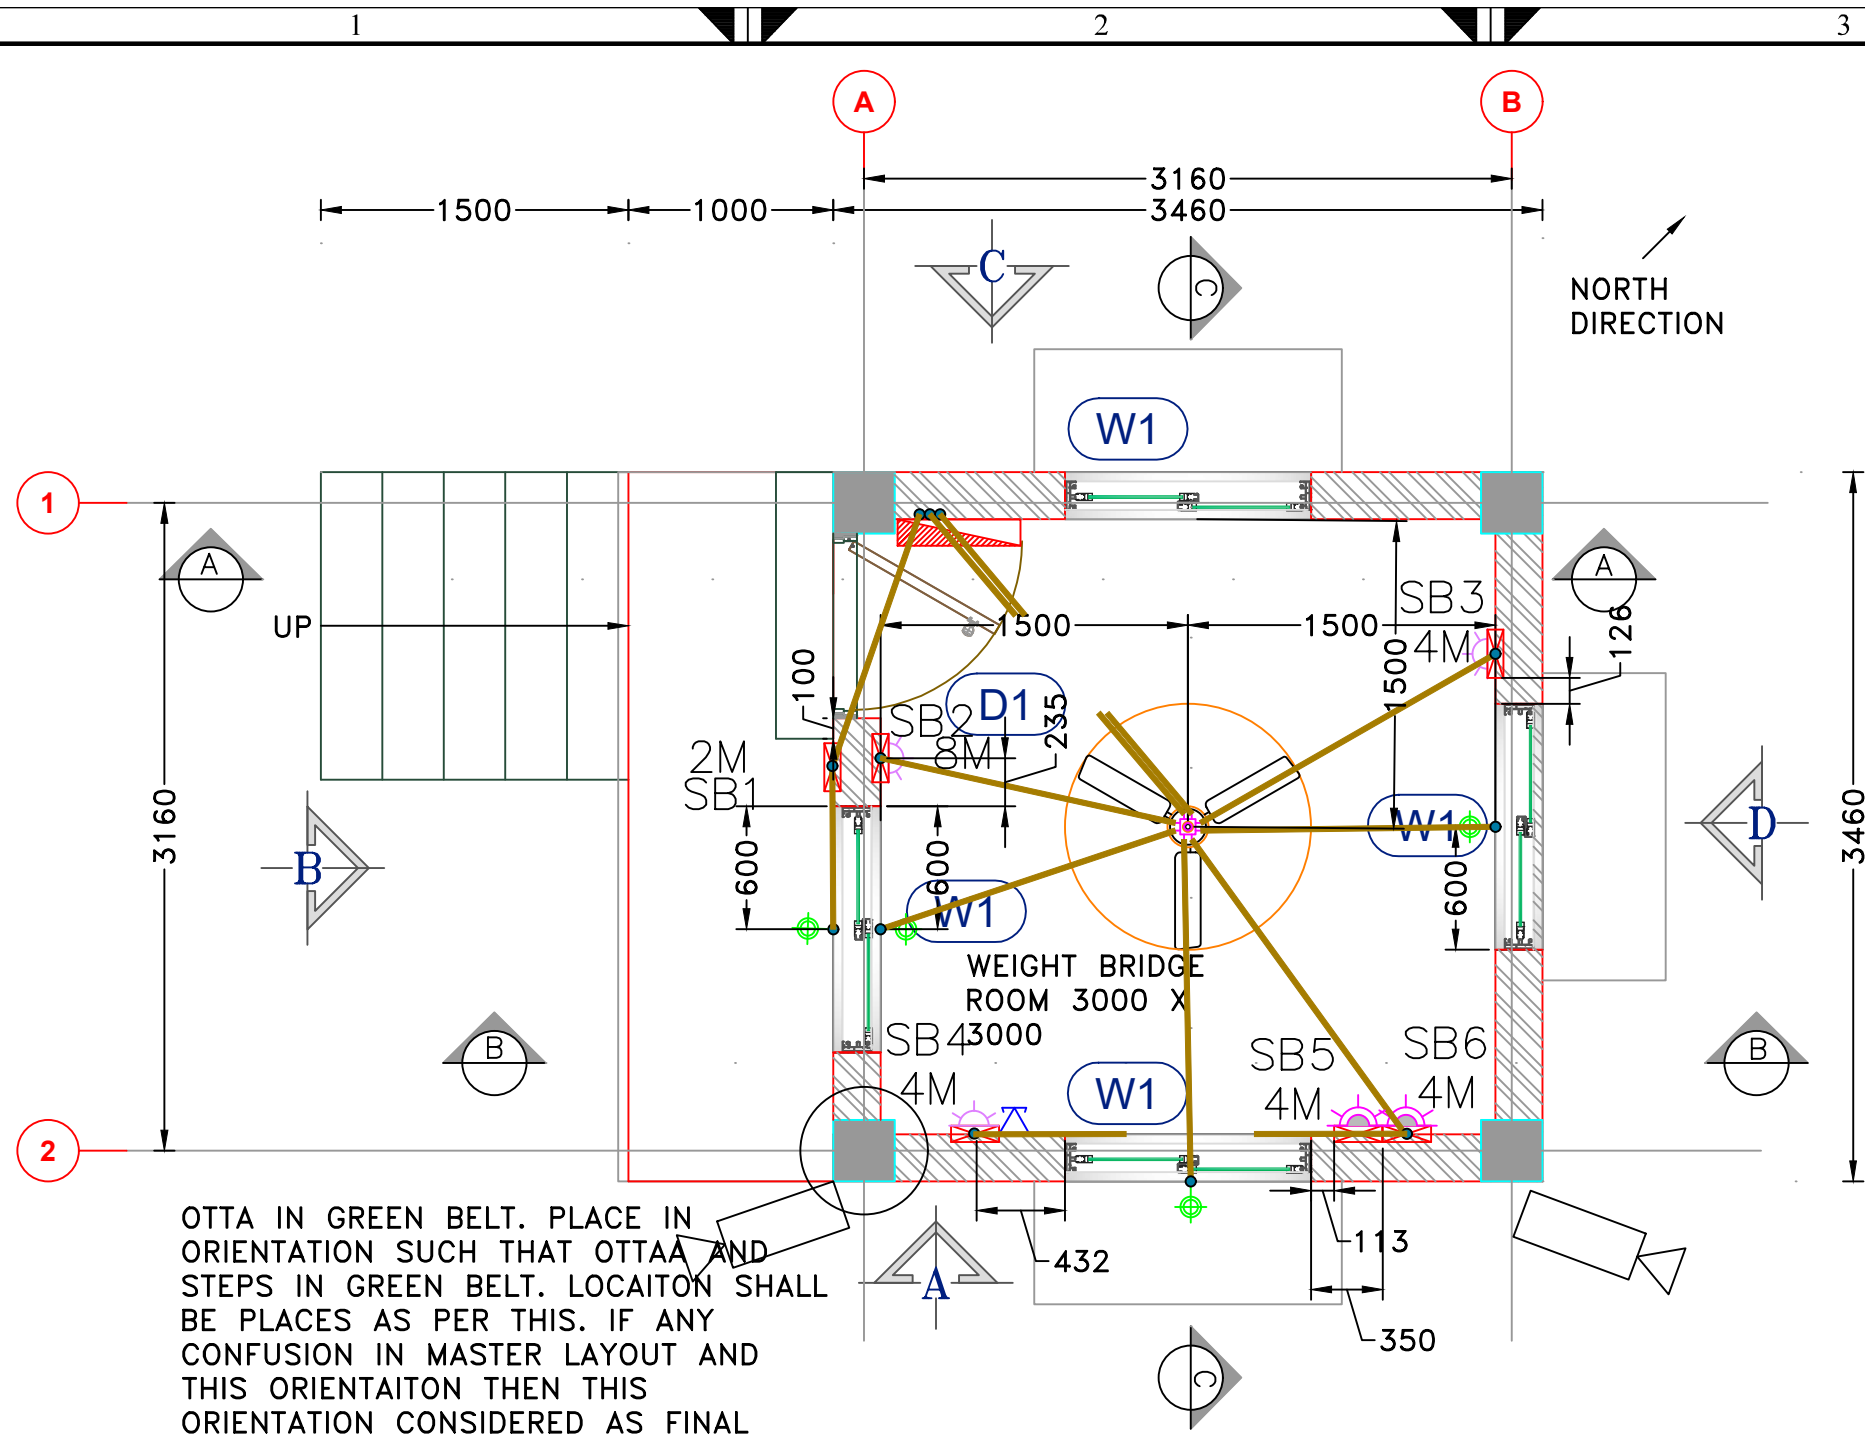


GROUND FLOOR PLAN LAYOUT

SCALE 1:50

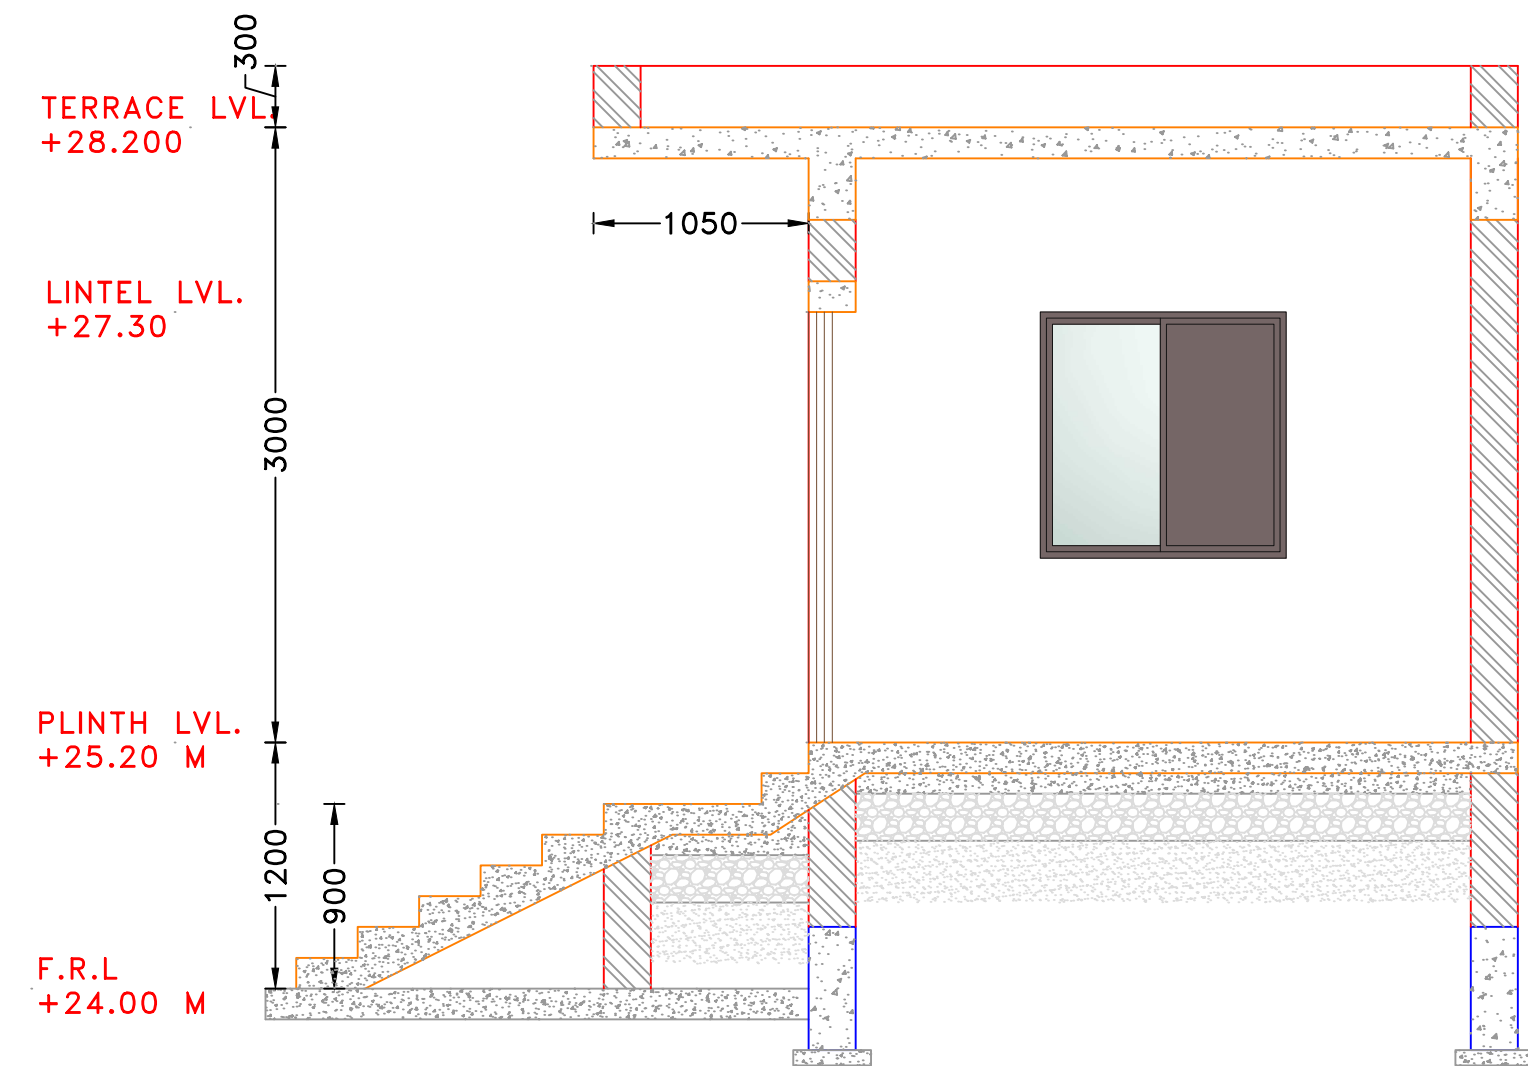


SECTION-A

SCALE 1:50

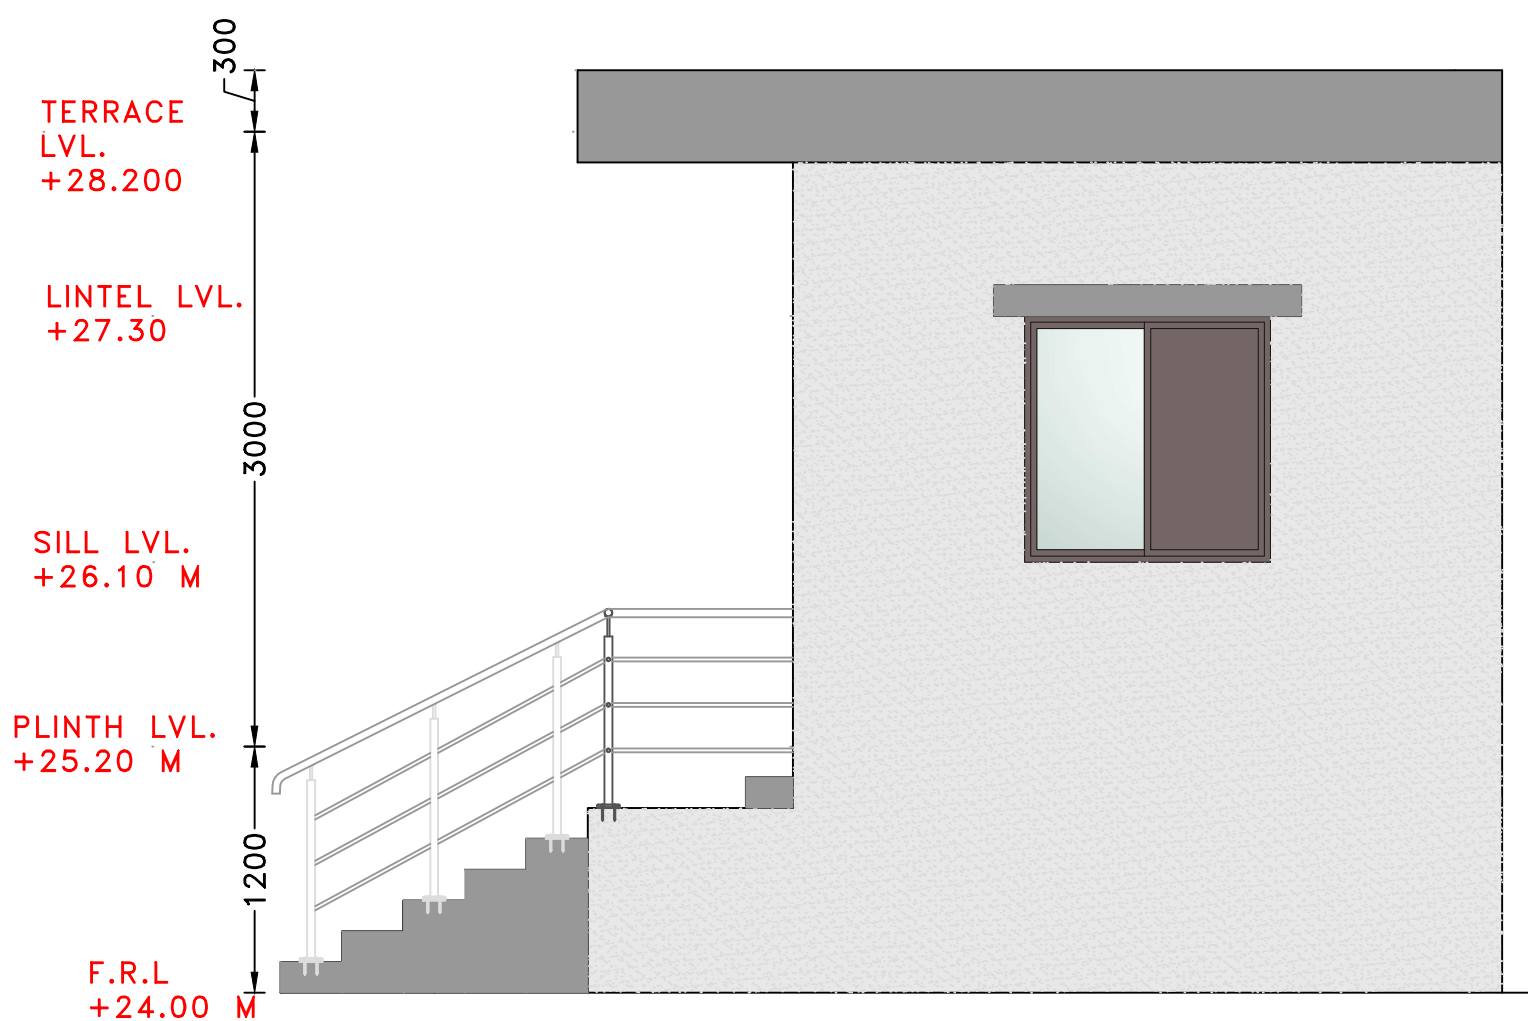


ELEVATION-A

SCALE 1:50

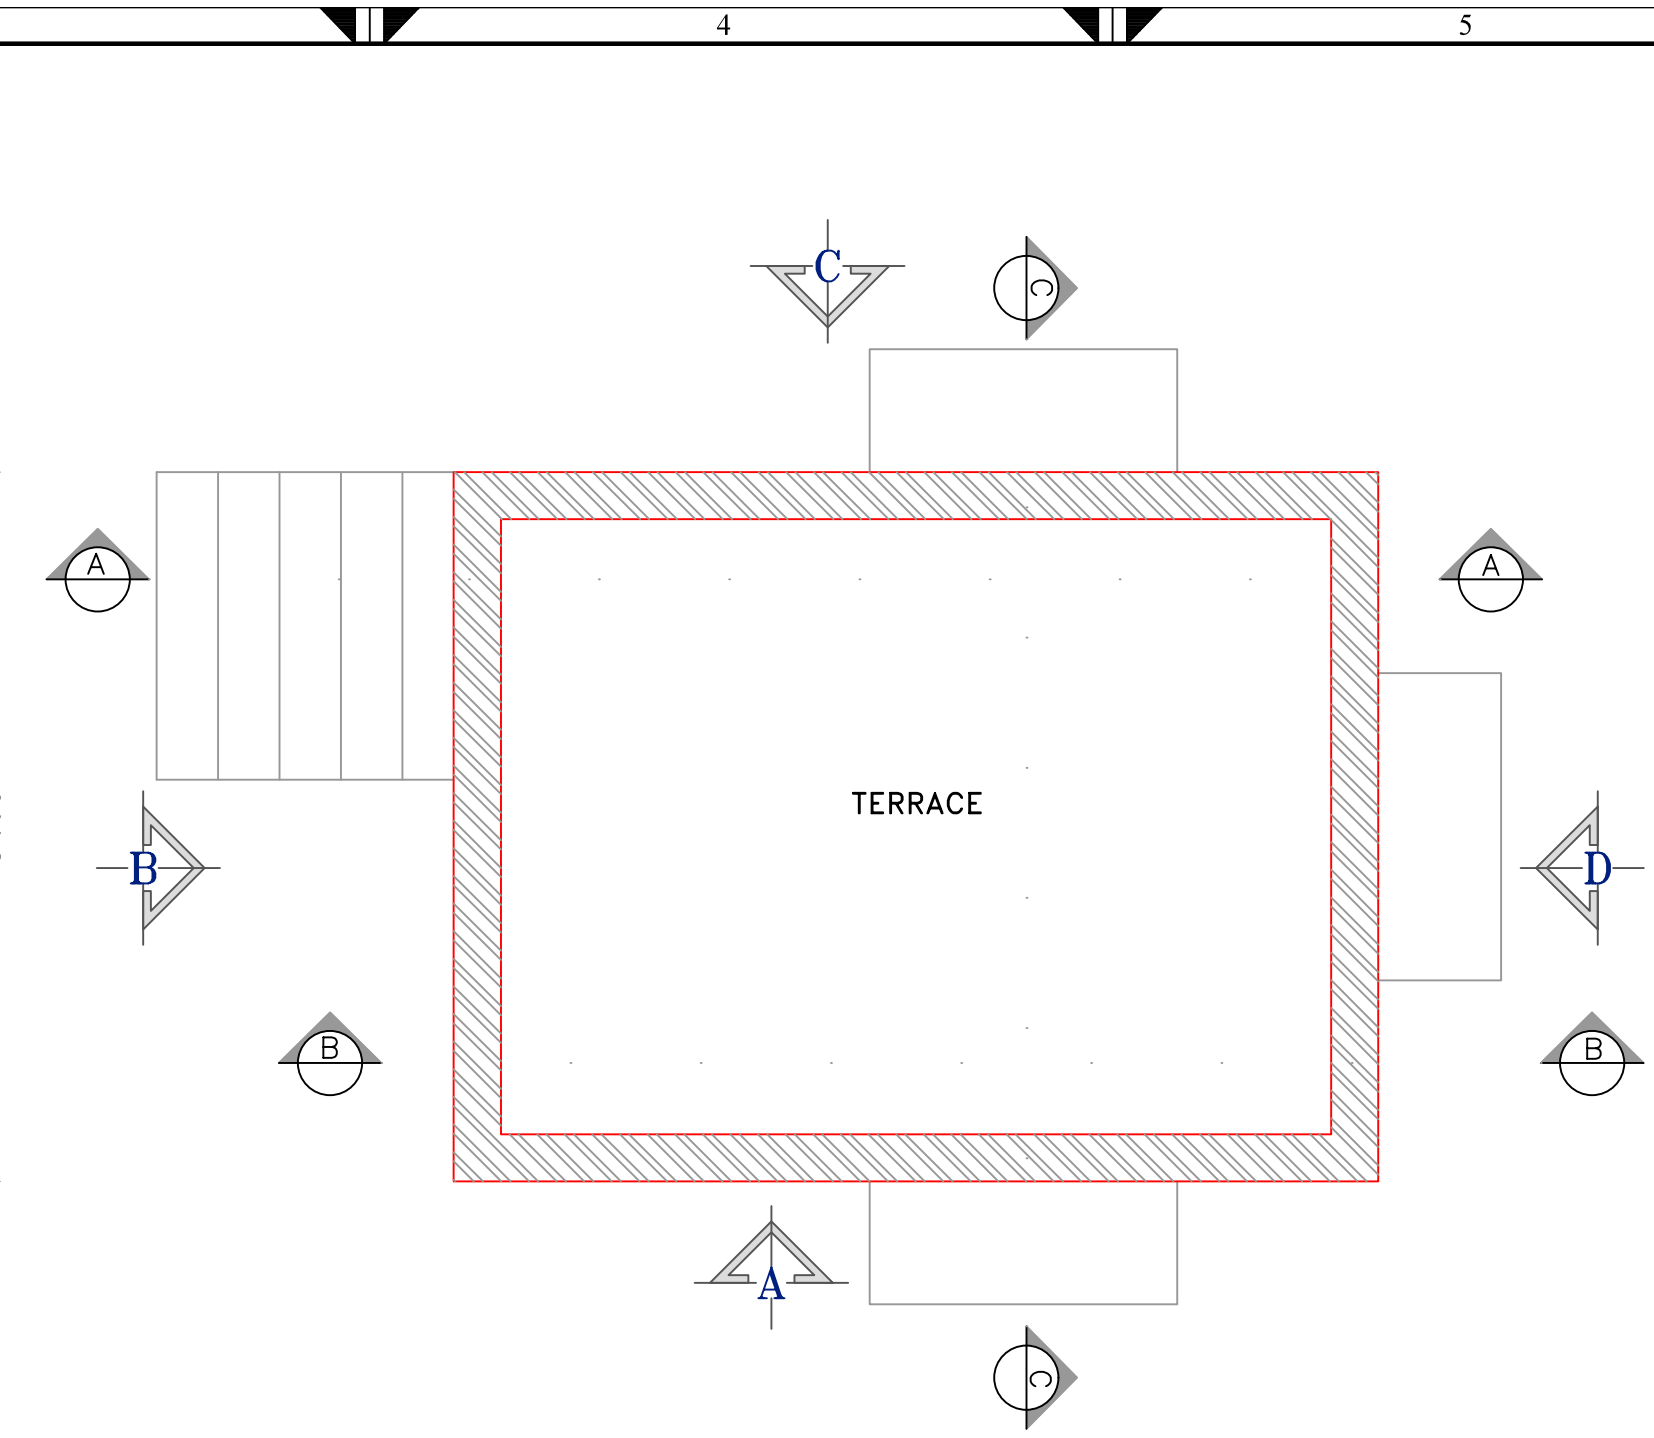


TERRACE FLOOR PLAN LAYOUT

SCALE 1:50

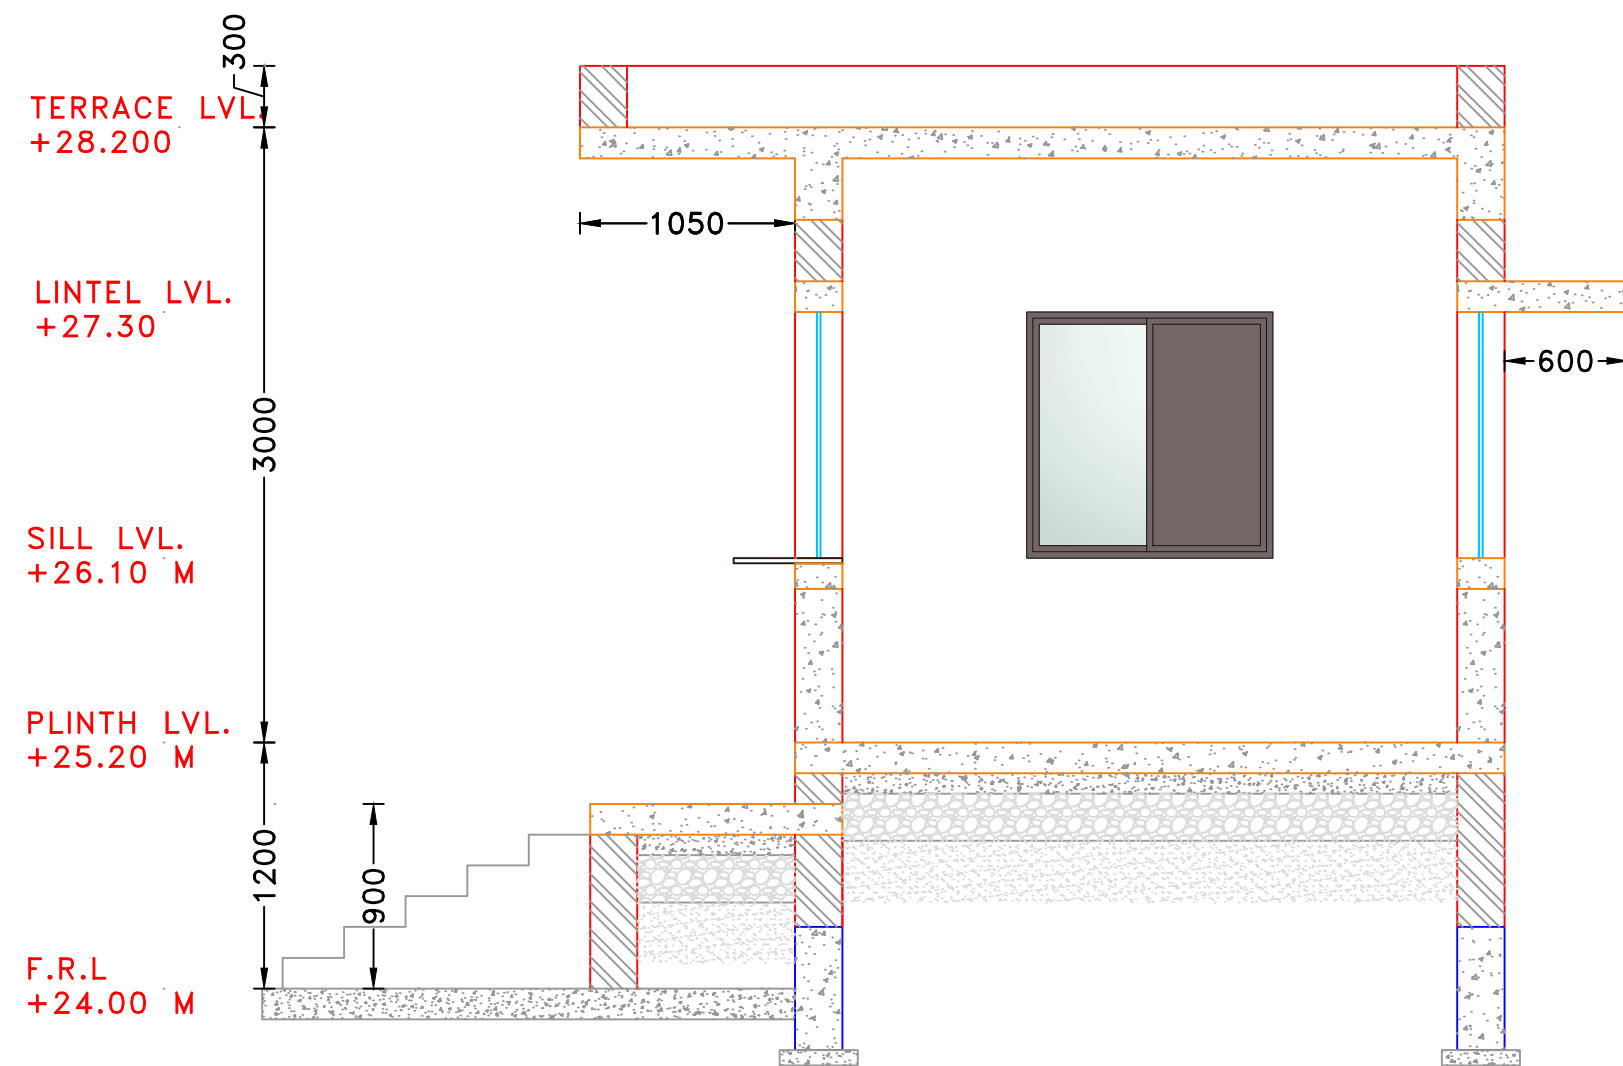


SECTION-B

SCALE 1:50

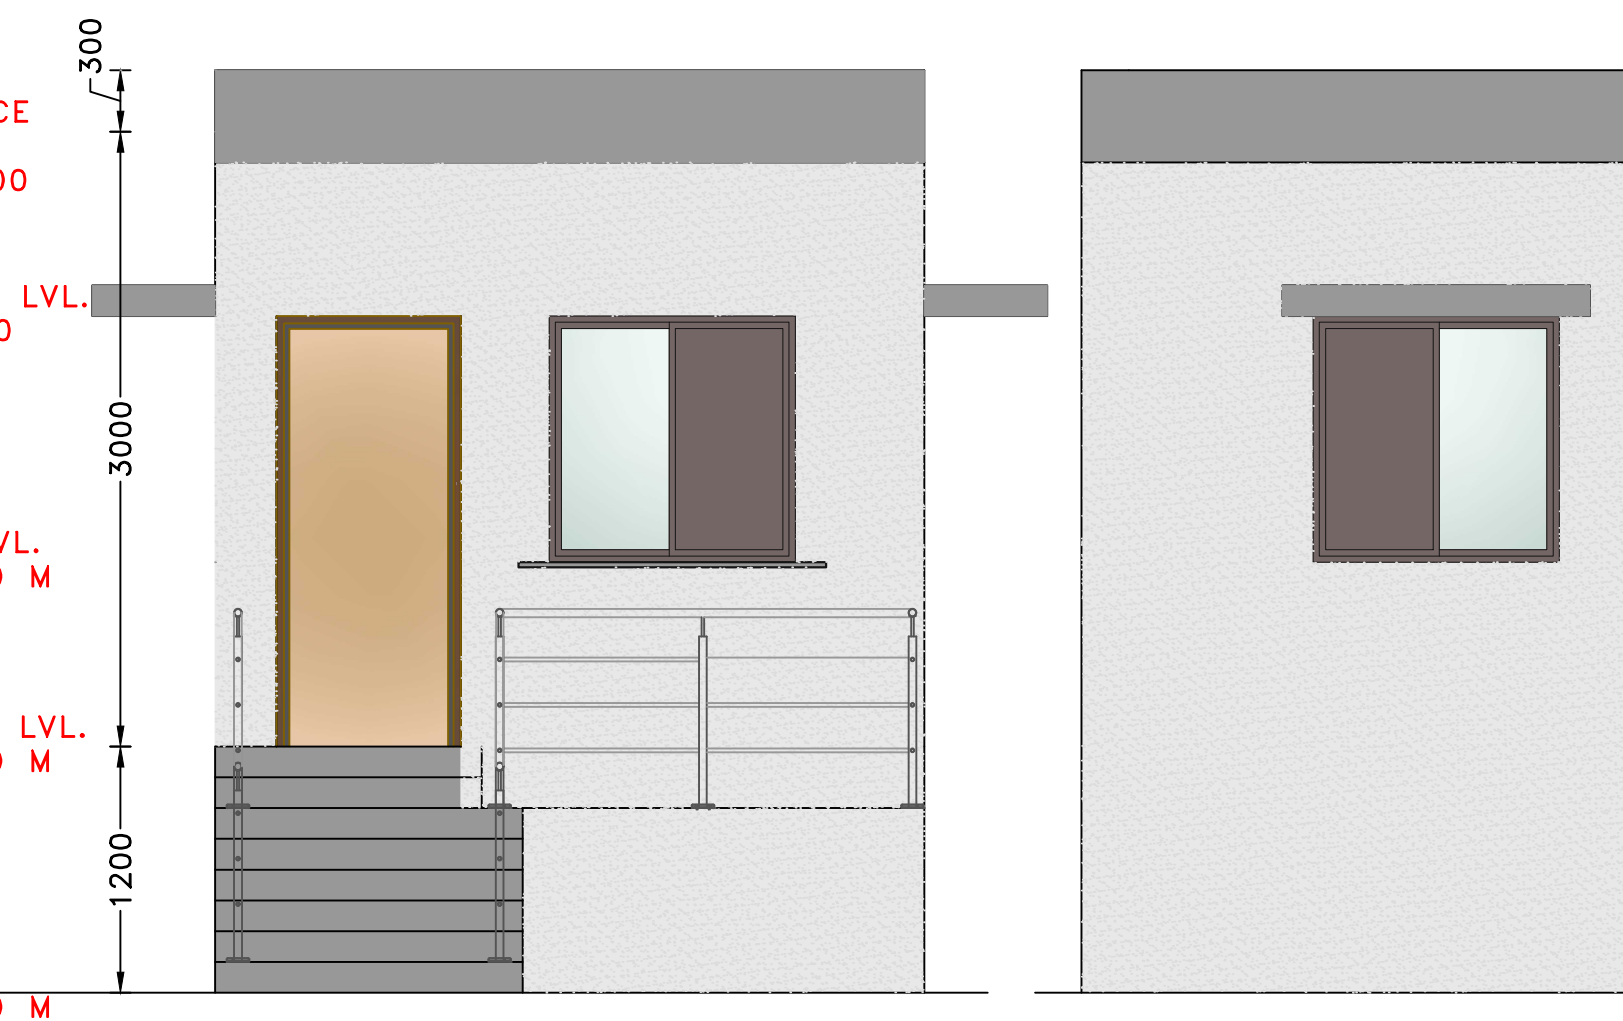


ELEVATION-B

SCALE 1:50

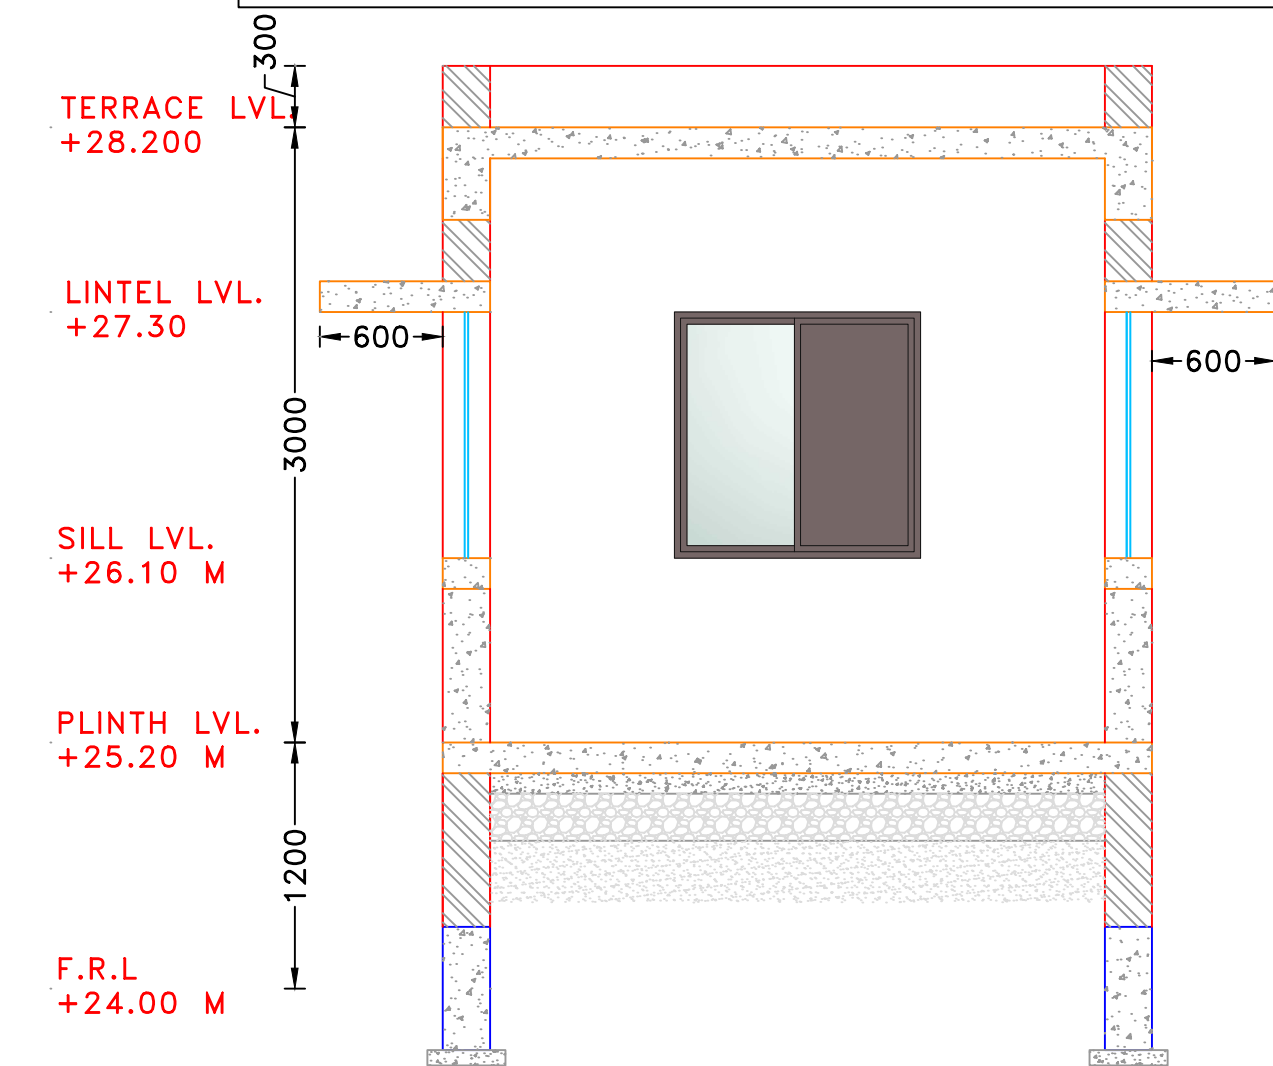

SECTION-C

SCALE 1:50

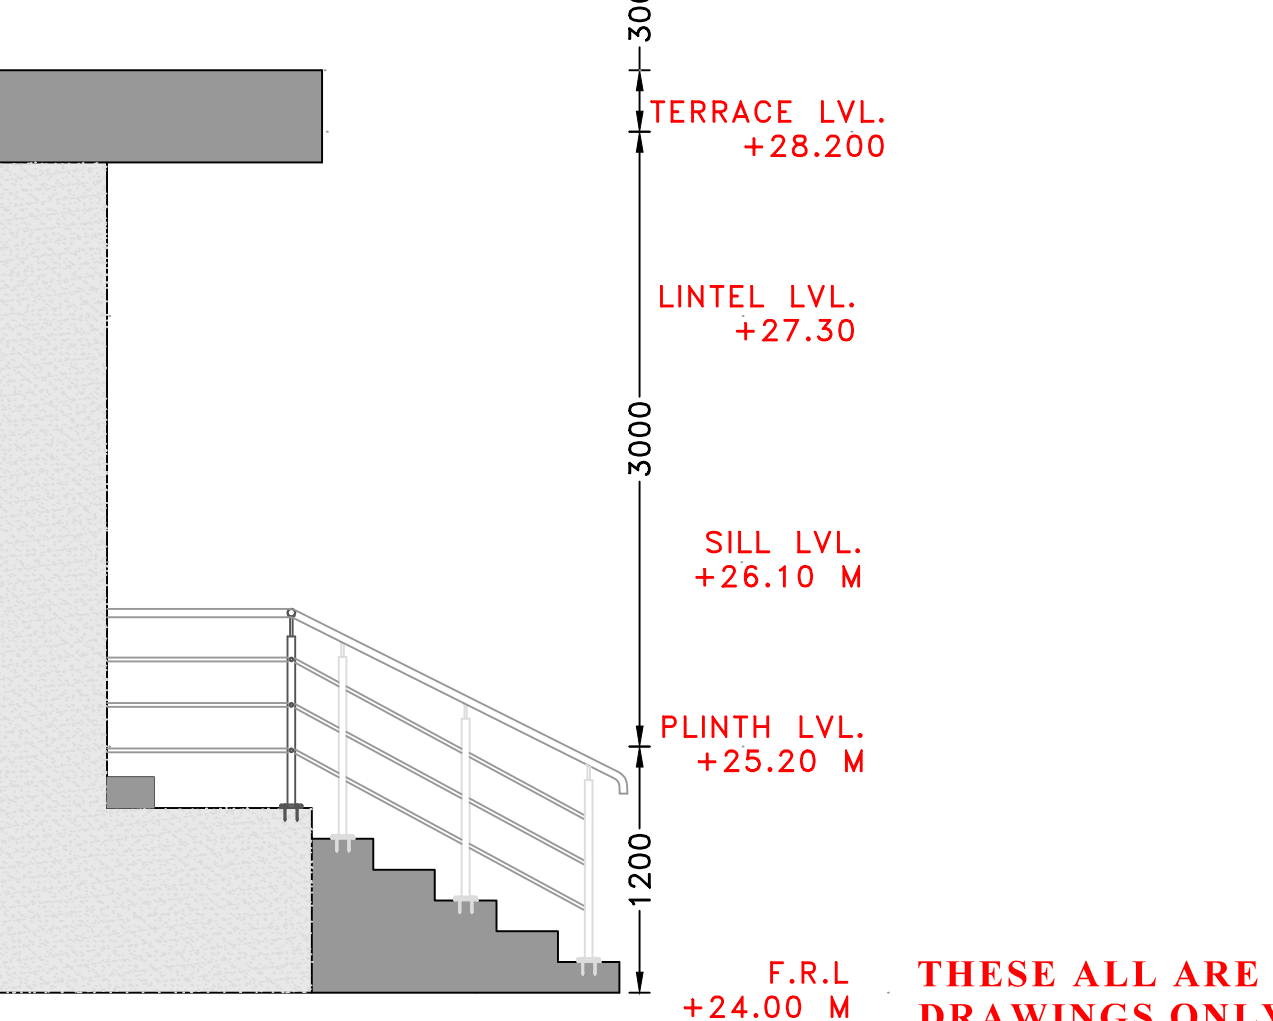

ELEVATION-C

SCALE 1:50

LEGEND		QTY.	HE
	CEILING FAN	01	
	BRACKET LIGHT POINT	04	
	SWITCHBOARD	06	12
	5A PLUG POINT	03	
	15A PLUG POINT	02	
	LIGHTING DISTRIBUTION BOARD	01	21
	CONDUIT VERTICAL DROP	12	
	FAN JUNCTION BOX	01	
	25MM DIA PVC CONDUIT		
	DATA POINT OR TV POINT		
	BULLET CAMERA POINT	02	

GENERAL NOTES:-

1. ALL DIMENSIONS ARE IN MILLIMETER AND ALL LEVELS ARE IN Meter UNLESS AND OTHERWISE SPECIFIED.
2. ALL THE DIMENSIONS SHALL BE READ & NOT TO BE MEASURED.
3. DRIP MOLD IS TO BE PROVIDED AT EXTERNAL WINDOW LINTELS.
4. ARCHITECTURAL DRAWINGS MUST ALWAYS BE READ IN CONJUNCTION WITH ALL OTHER RELEVANT SERVICES DRAWINGS AND CONTRACT DOCUMENTS ANY DISCREPANCY BETWEEN THESE DRAWING SAND DOCUMENTS SHOULD BE REPORTED TO THE ENGINEER FOR CLARIFICATION AND VERIFICATION.
5. FOR ALL FLOORING MUST BE (KOTA STONE)
6. FOR TOILET FLOORING MUST BE (ANTI SKID TILES)
7. FOR TERRACE FLOORING MUST BE (CHINA MOSAIC)
8. PARKING AND DRIVE MUST BE IN TRIMIX FINISH.

GRAPHICS LEGEND :

- R.C.C. FOR COLUMN
- R.C.C. FOR SLAB & PCC
- 230 MM TK. MAIN WALL

LAYERS :

- COLUMN LINE
- SLAB LINE
- GRIDE LINE
- CENTER LINE
- BEAM LINE
- MASONARY LINE

W/V/D - INDICATES WINDOW / VENTILATION / DOOR


REVI.	DATE	PURPOSE	BY
R1	12-01-26		RD
REVISION HISTORY			

CLIENT



ADDRESS:
MORBI MUNICIPAL CORPORATION
15, Vasant Plot Main Road,
Sardar Nagar, Morbi-363641

CONSULTANTS

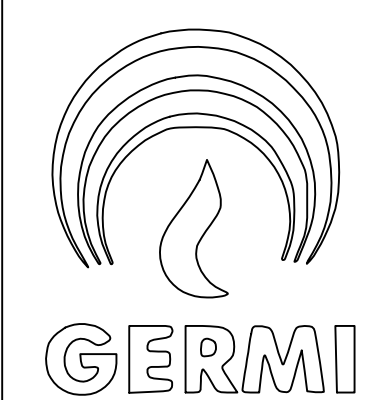

ADDRESS:
GUJARAT ENERGY RESEARCH & MANAGEMENT INSTITUTE
1st FLOOR, ENERGY BUILDING PDP
CAMPUS, RAISAN VILLAGE,
GANDHINAGAR,
GUJARAT-382 007
CONTACT:
information@germi.org

PROJECT NUMBER:-	6225
BUILDING NAME:-	WEIGHT BRIDGE CABIN
PROJECT NAME:-	NEW SLF FOR LALPUR SITE, MORBI

DRAWN:-	RAVINDRA	DATE:-	12-01-2026
CHECK:-	YOGENDU		
APPROVE:-	P.S.RAO	SCALE:-	VERY

DRAWING TITLE:- WEIGHT BRIDGE CABIN_CONDUIT LAYOUT			
DRAWING NO	REVISION	SHEET	FOR
TATVA-M-05	R0	A2	T TENDER

THESE ALL ARE TENDER DRAWINGS ONLY. ONLY FOR TENDER PURPOSE. NOT FOR CONSTRUCTION PURPOSE. BEFORE STARTING THE CONSTRUCTION TAKE AN APPROVAL FROM THE CONCERN AUTHORITY

GENERAL NOTES:-

- ALL DIMENSIONS ARE IN MILLIMETER AND ALL LEVELS ARE IN Meter UNLESS AND OTHERWISE SPECIFIED.
- ALL THE DIMENSIONS SHALL BE READ & NOT TO BE MEASURED.
- DRIP MOLD IS TO BE PROVIDED AT EXTERNAL WINDOW LINTELS.
- ARCHITECTURAL DRAWINGS MUST ALWAYS BE READ IN CONJUNCTION WITH ALL OTHER RELEVANT SERVICES DRAWINGS AND CONTRACT DOCUMENTS ANY DISCREPANCY BETWEEN THESE DRAWING SAND DOCUMENTS SHOULD BE REPORTED TO THE ENGINEER FOR CLARIFICATION AND VERIFICATION.
- FOR ALL FLOORING MUST BE (KOTA STONE)
- FOR TOILET FLOORING MUST BE (ANTI SKID TILES)
- FOR TERRACE FLOORING MUST BE (CHINA MOSAIC)
- PARKING AND DRIVE MUST BE IN TRIMIX FINISH.

GRAPHICS LEGEND :


- R.C.C. FOR COLUMN
- R.C.C. FOR SLAB & PCC
- 230 MM TK. MAIN WALL

LAYERS :

- COLUMN LINE
- SLAB LINE
- GRIDE LINE
- CENTER LINE
- BEAM LINE
- MASONARY LINE


W/V/D - INDICATES WINDOW / VENTILATION / DOOR

LEGEND		QTY.	HEIG
	CEILING FAN	01	
	BRACKET LIGHT POINT	04	
	SWITCHBOARD	06	1200
	5A PLUG POINT	03	
	15A PLUG POINT	02	
	LIGHTING DISTRIBUTION BOARD	01	2100
	CONDUIT VERTICAL DROP	12	
	FAN JUNCTION BOX	01	
	25MM DIA PVC CONDUIT		
	DATA POINT OR TV POINT		
	BULLET CAMERA POINT	02	

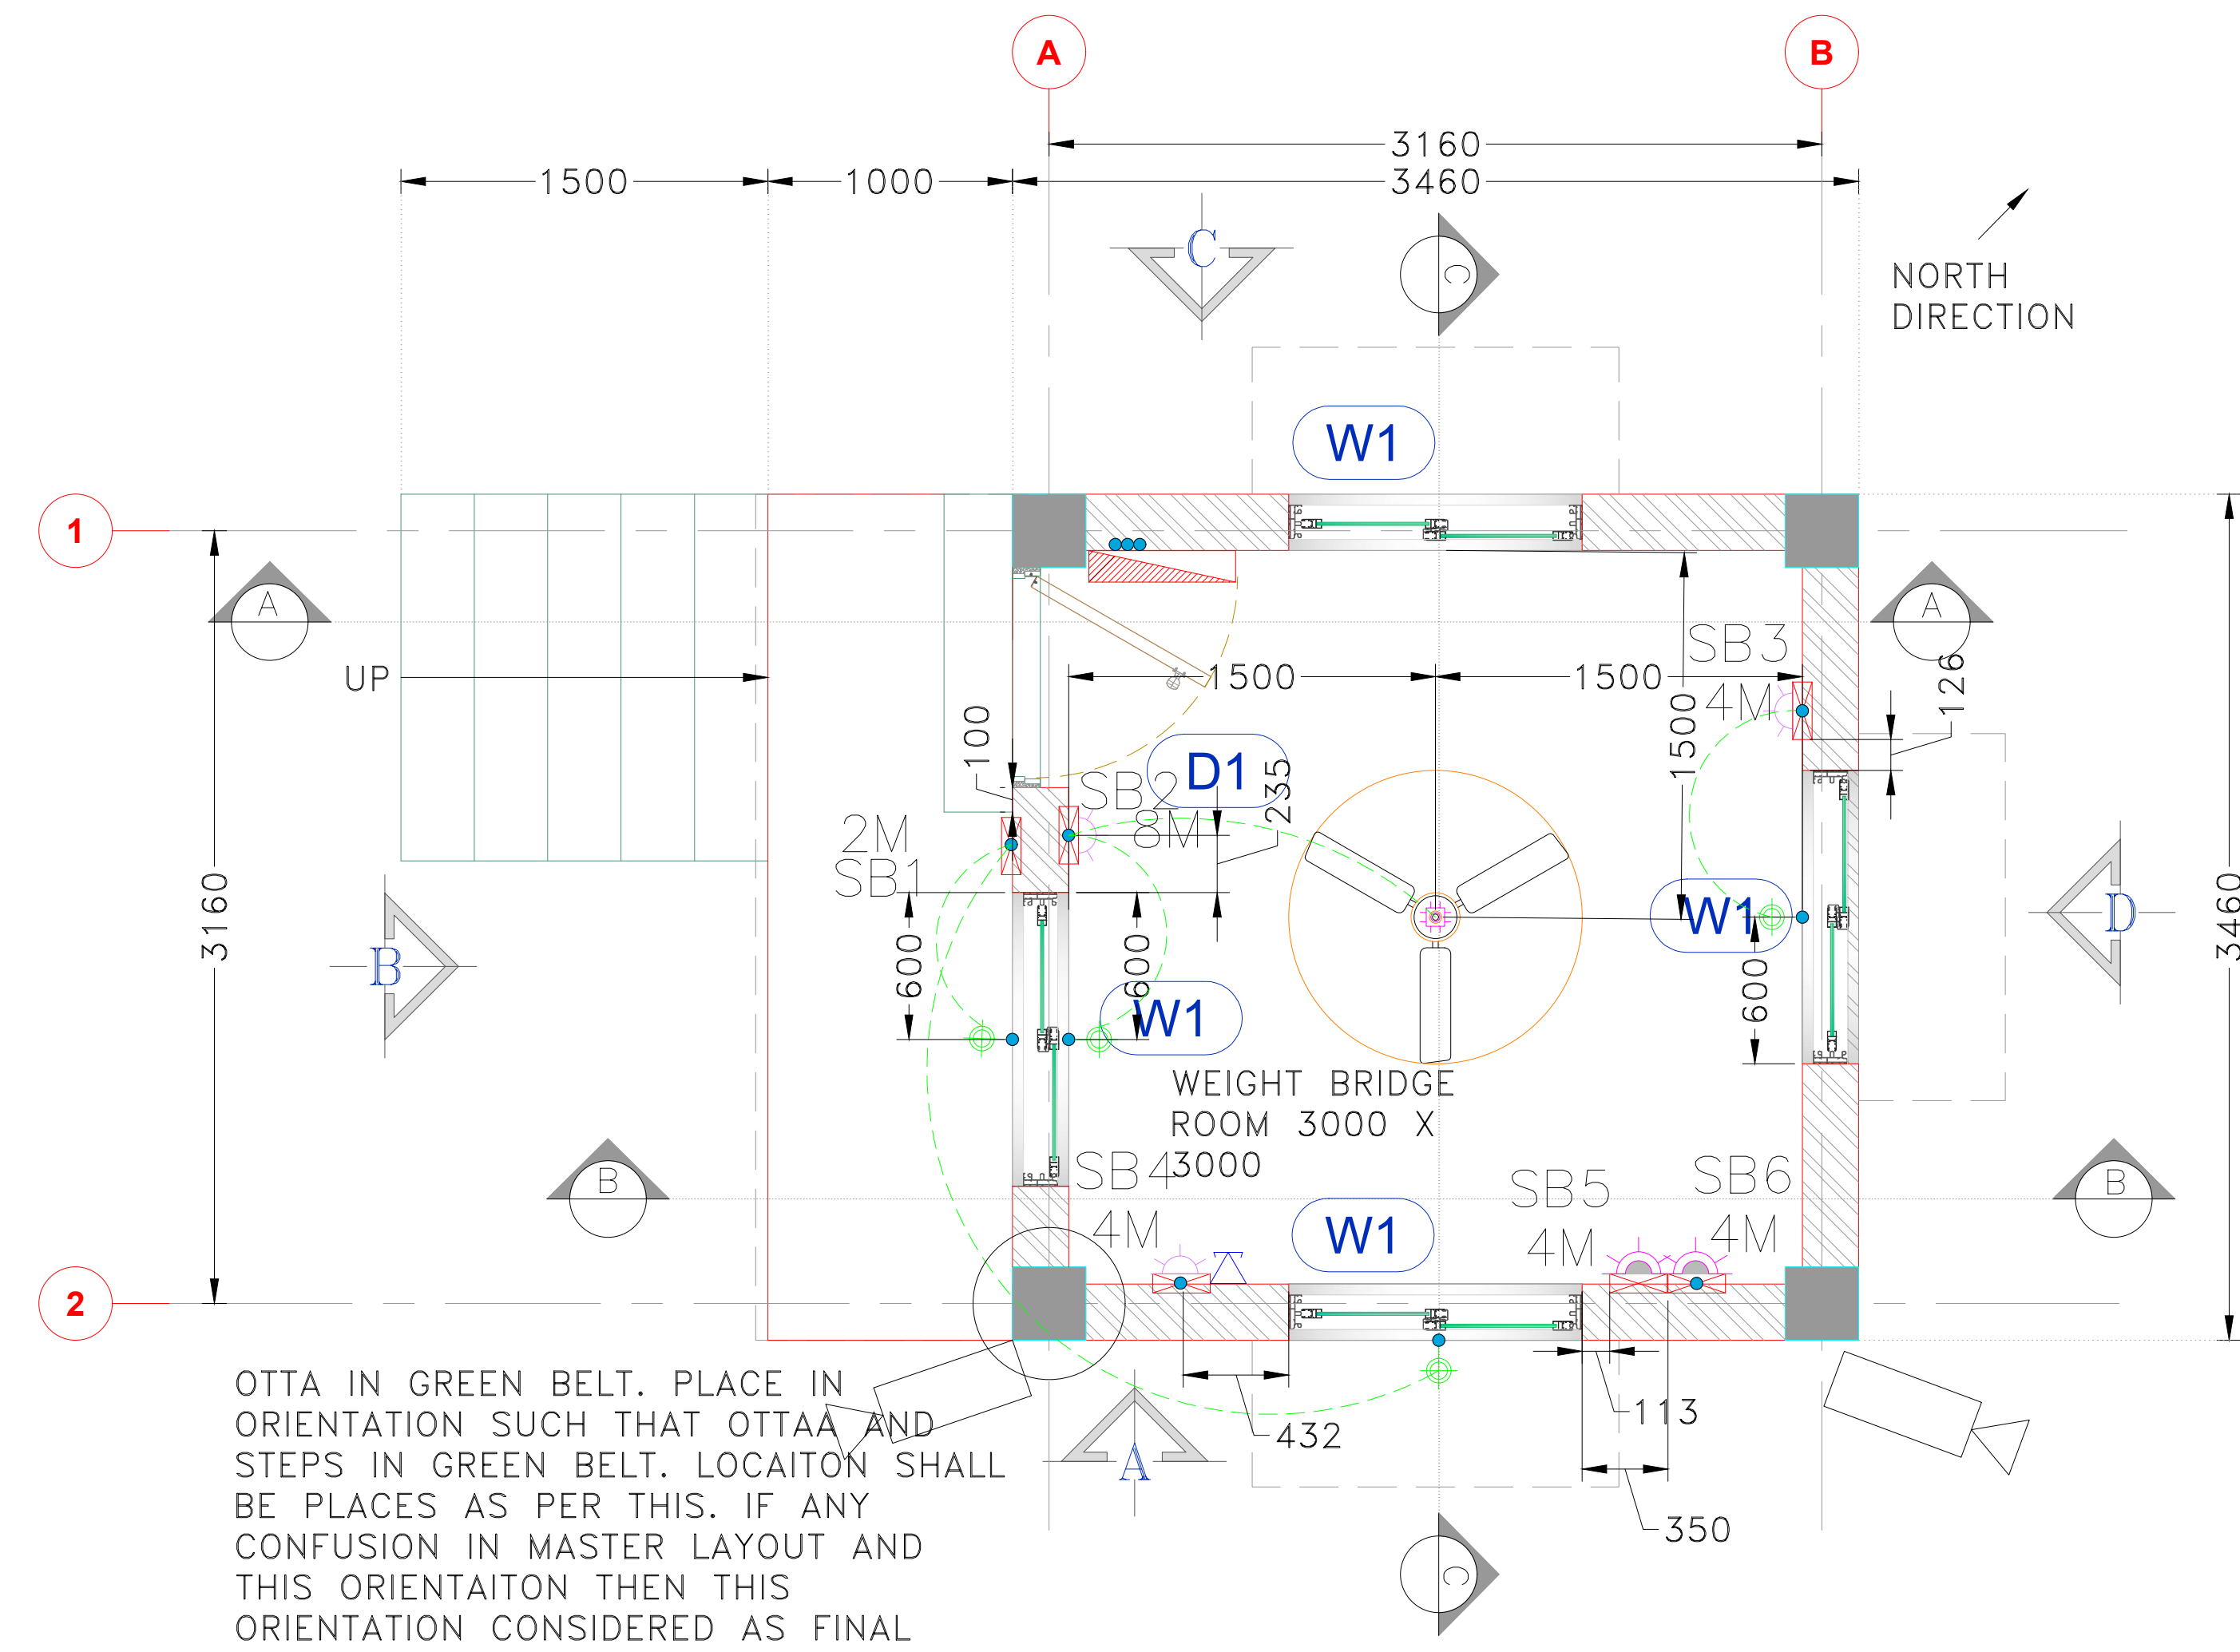


GROUND FLOOR PLAN LAYOUT

SCALE 1:50

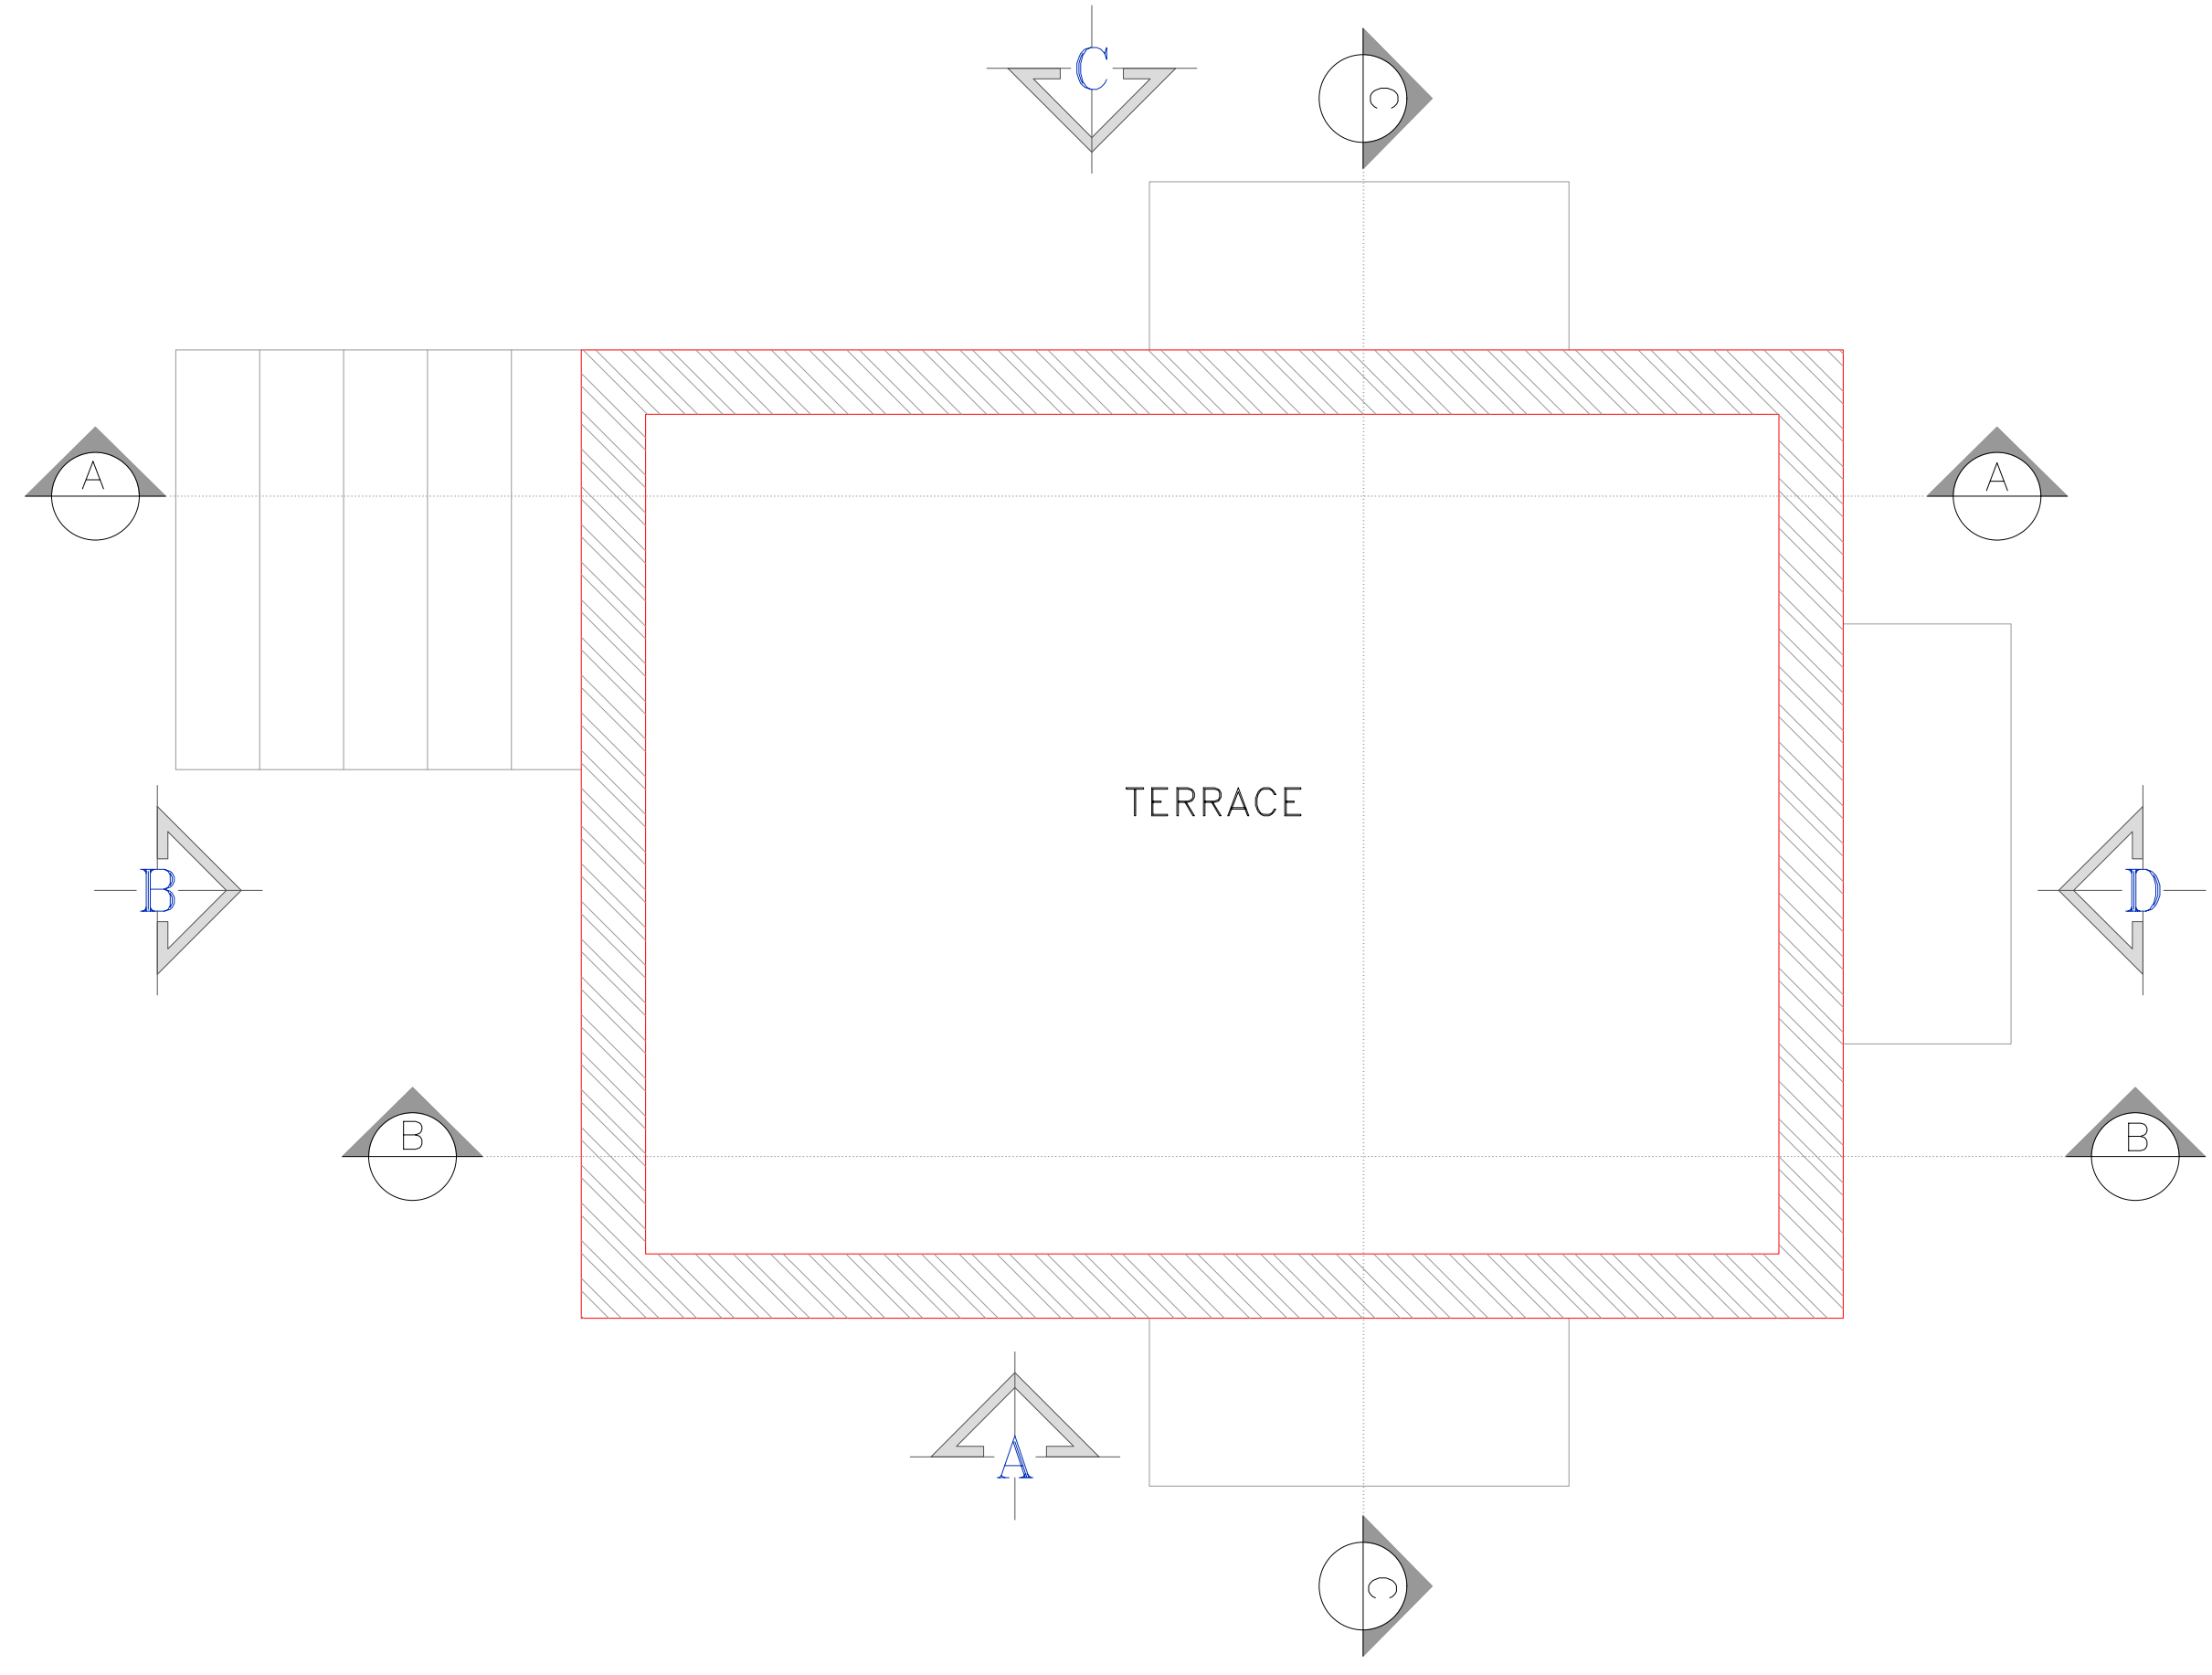


TERRACE FLOOR PLAN LAYOUT

SCALE 1:50

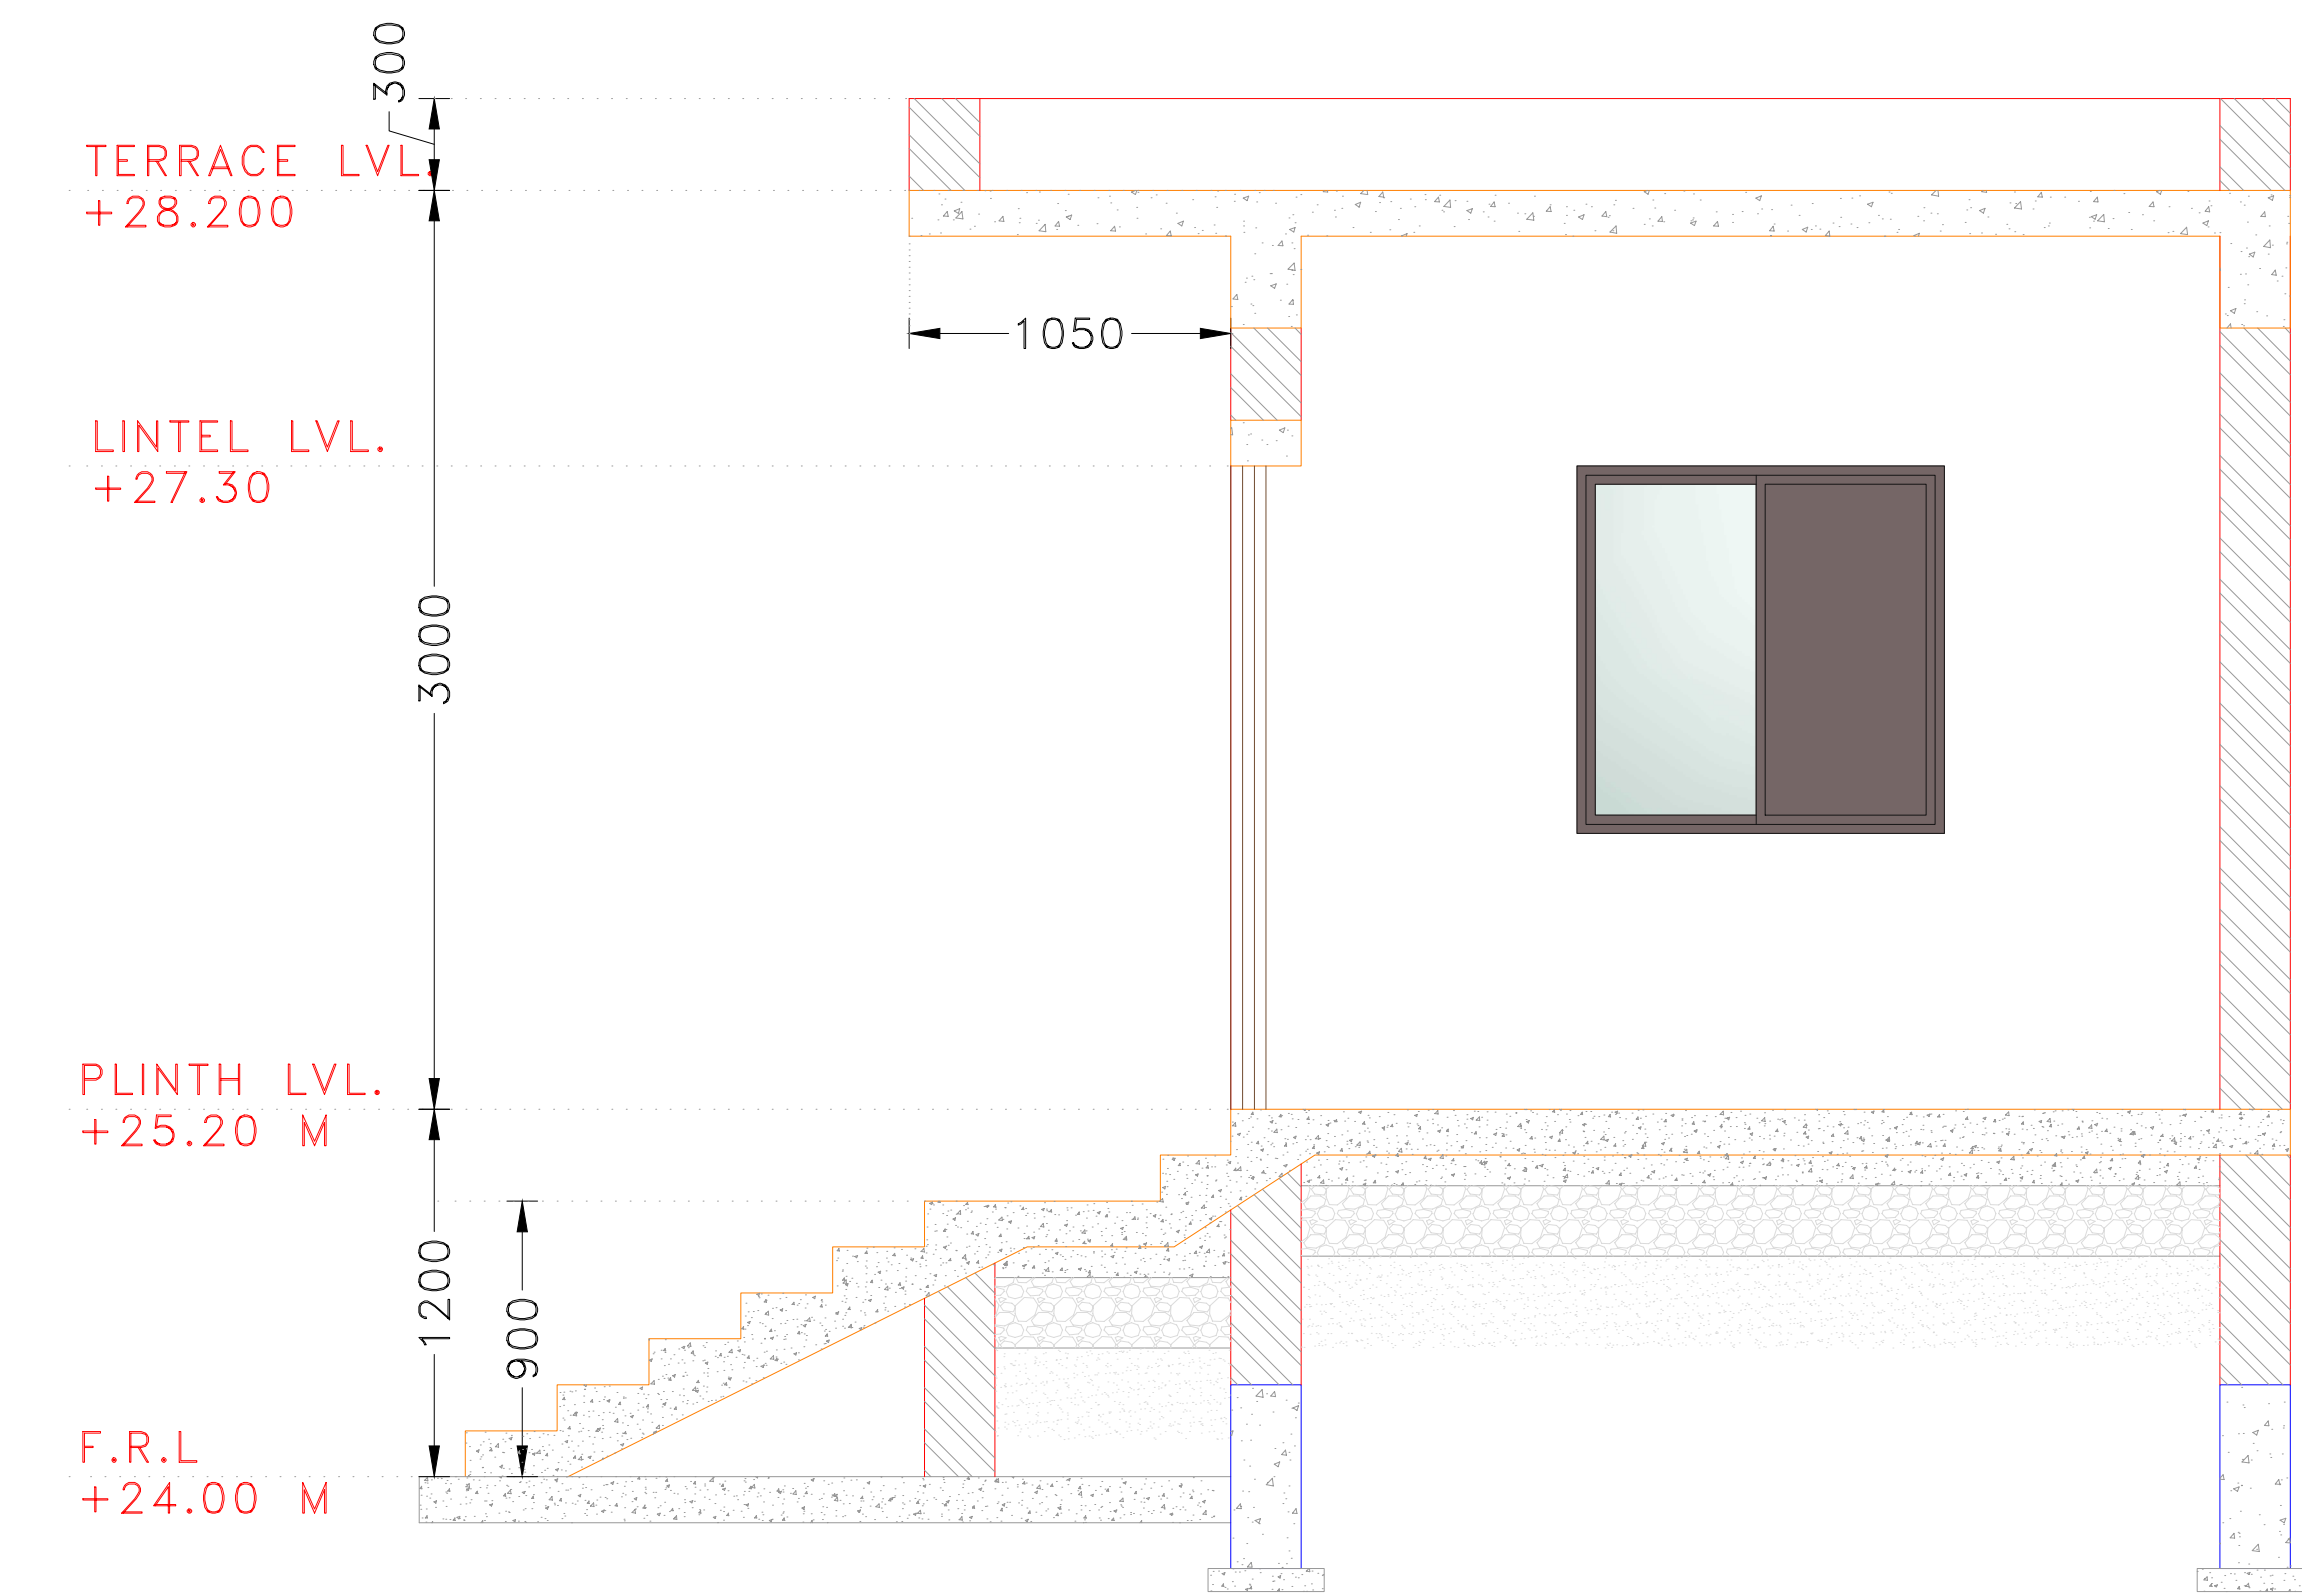


SECTION-A

SCALE 1:50

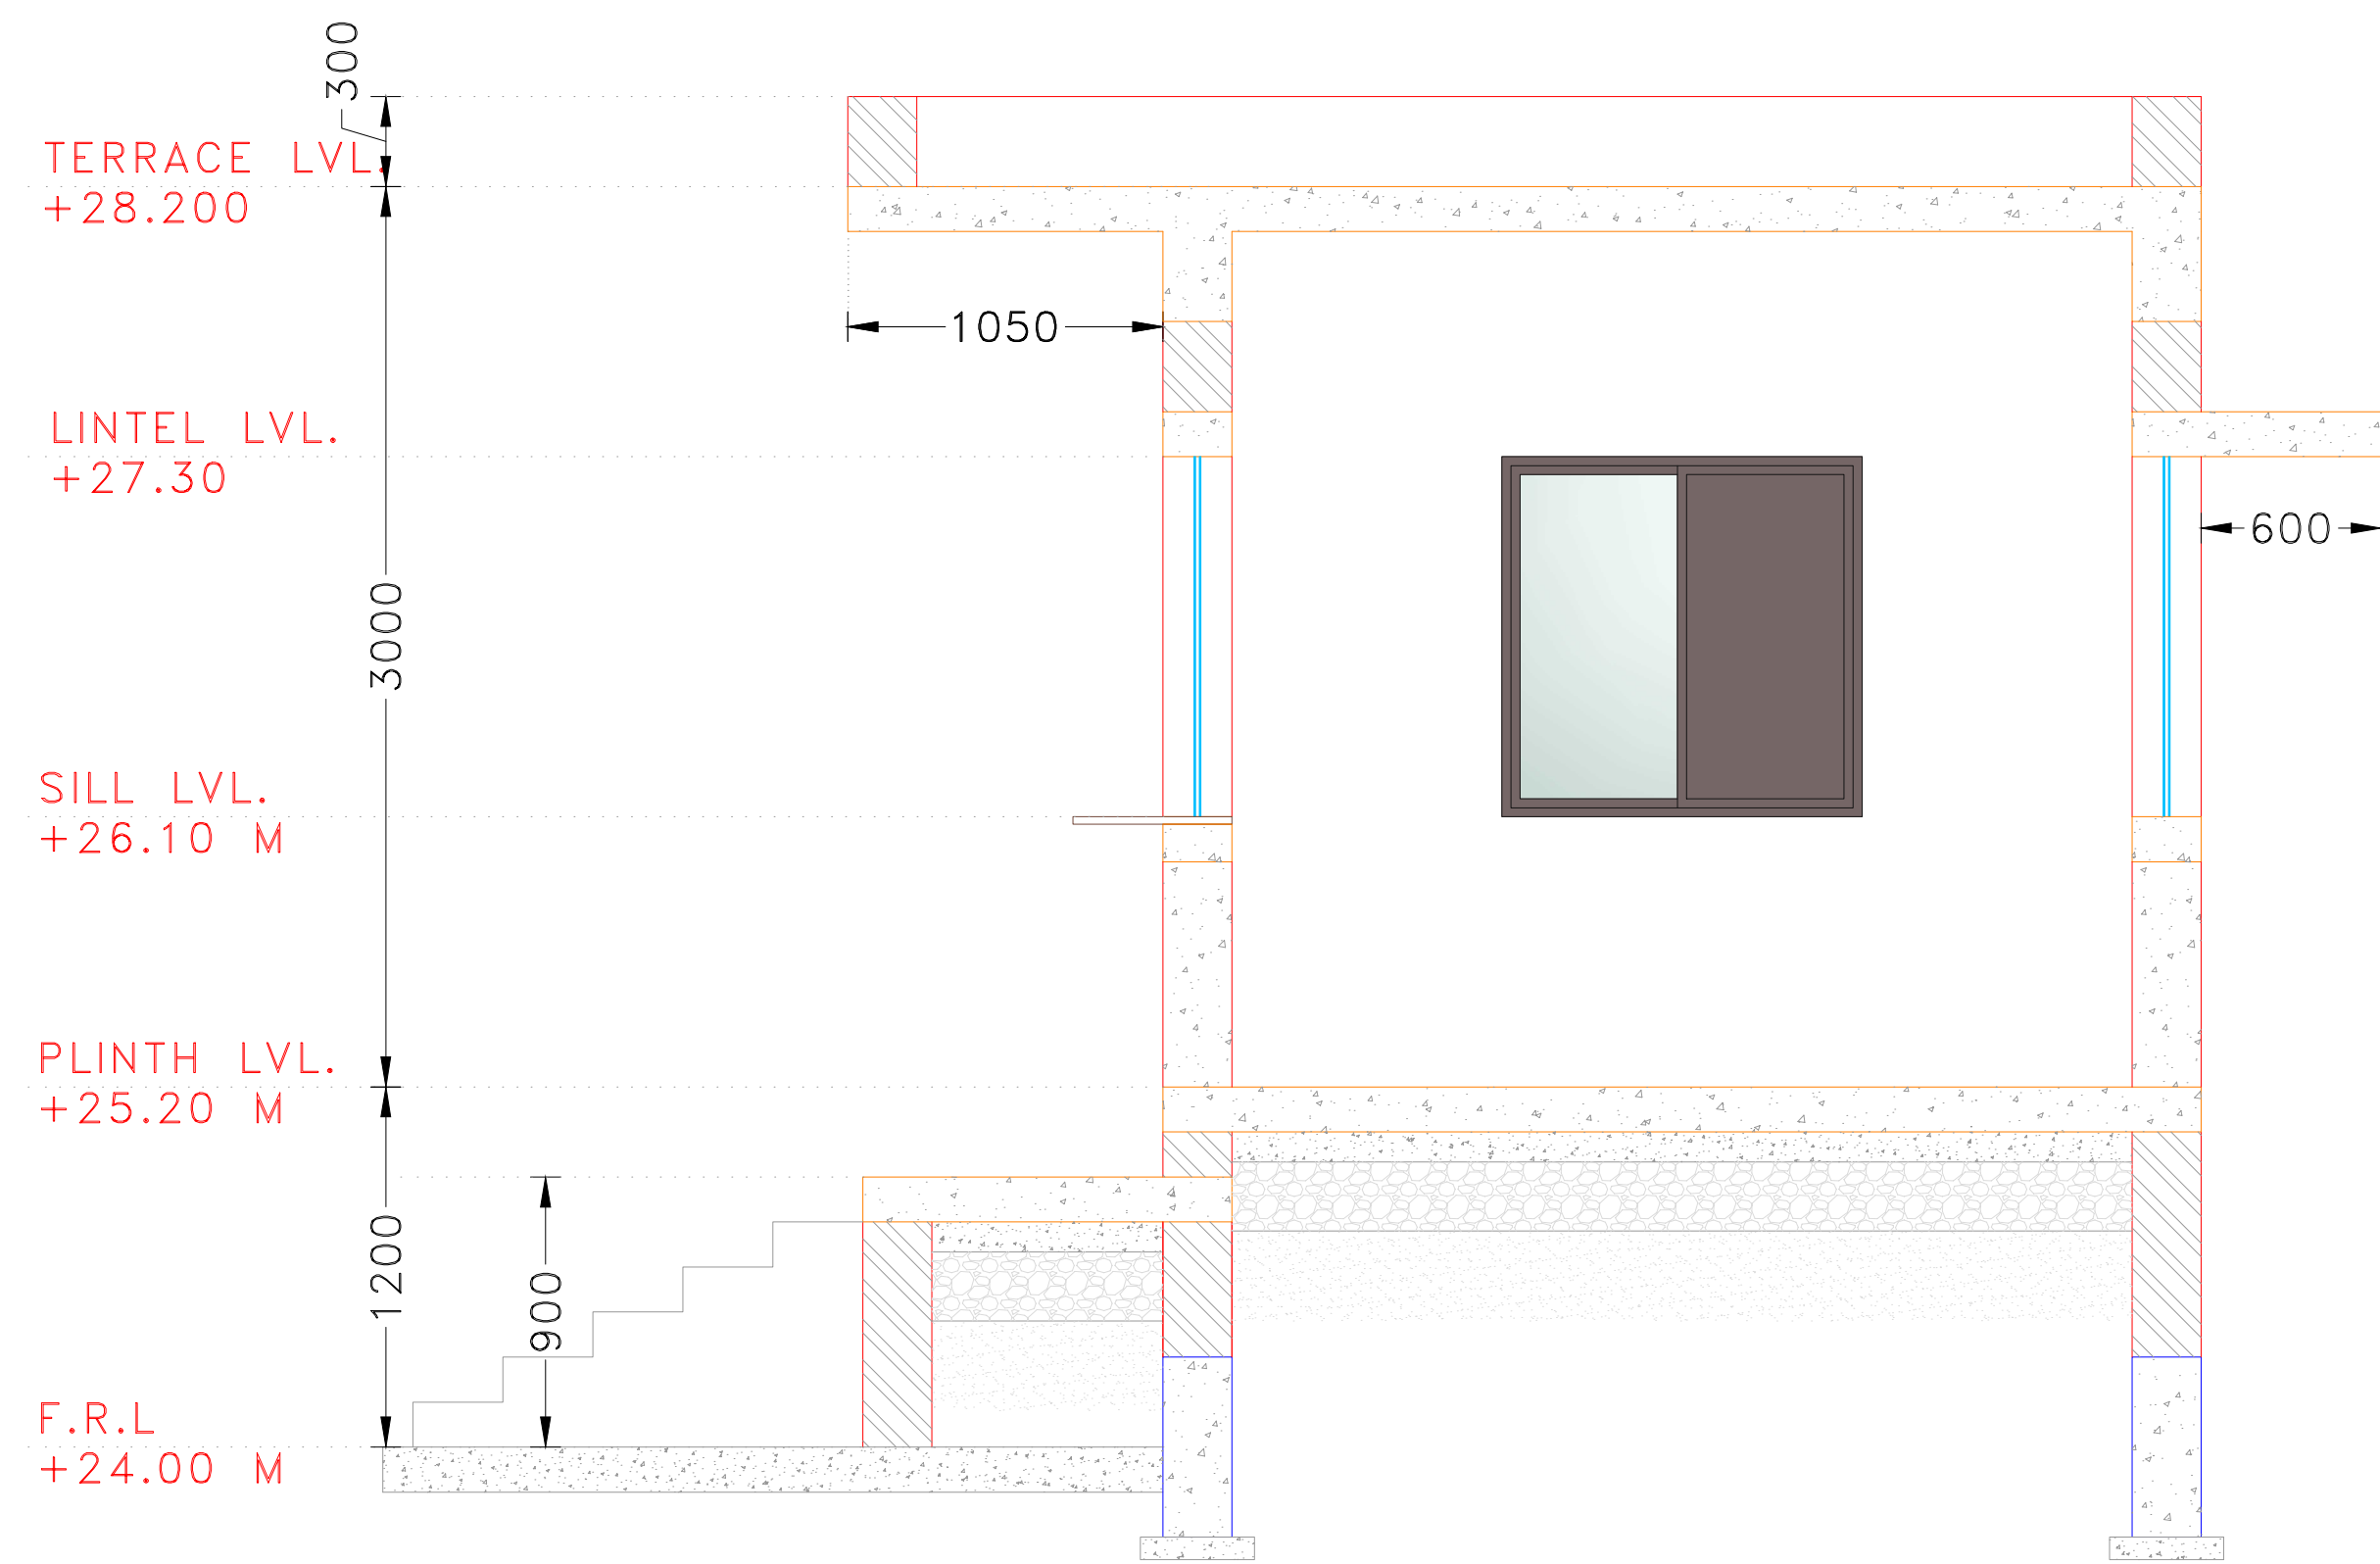


SECTION-B

SCALE 1:50

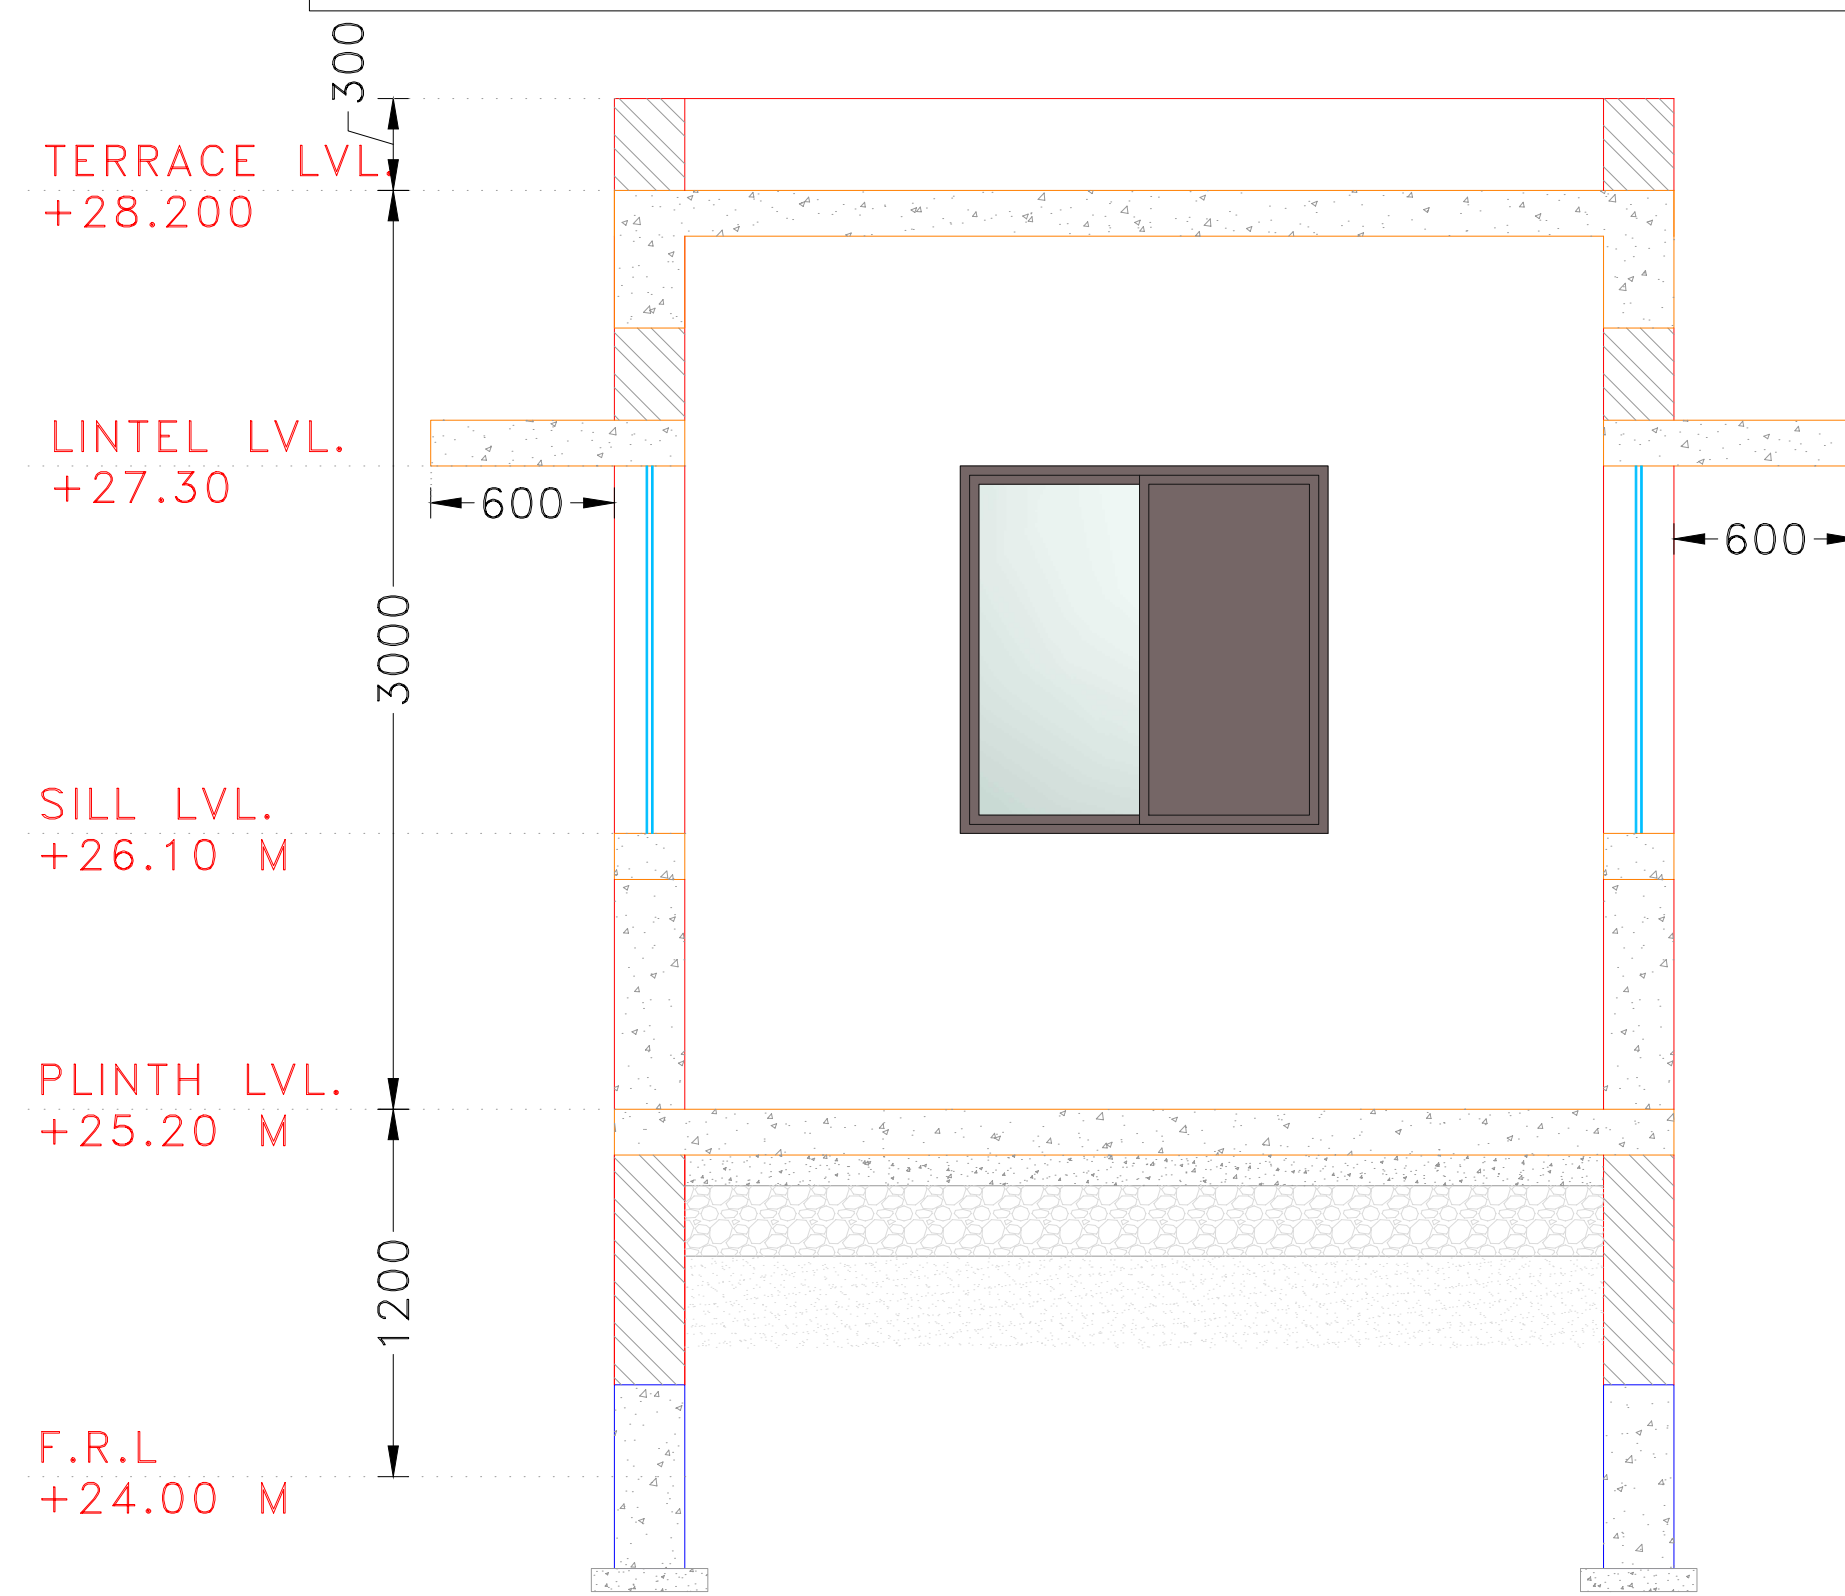


SECTION-C

SCALE 1:50

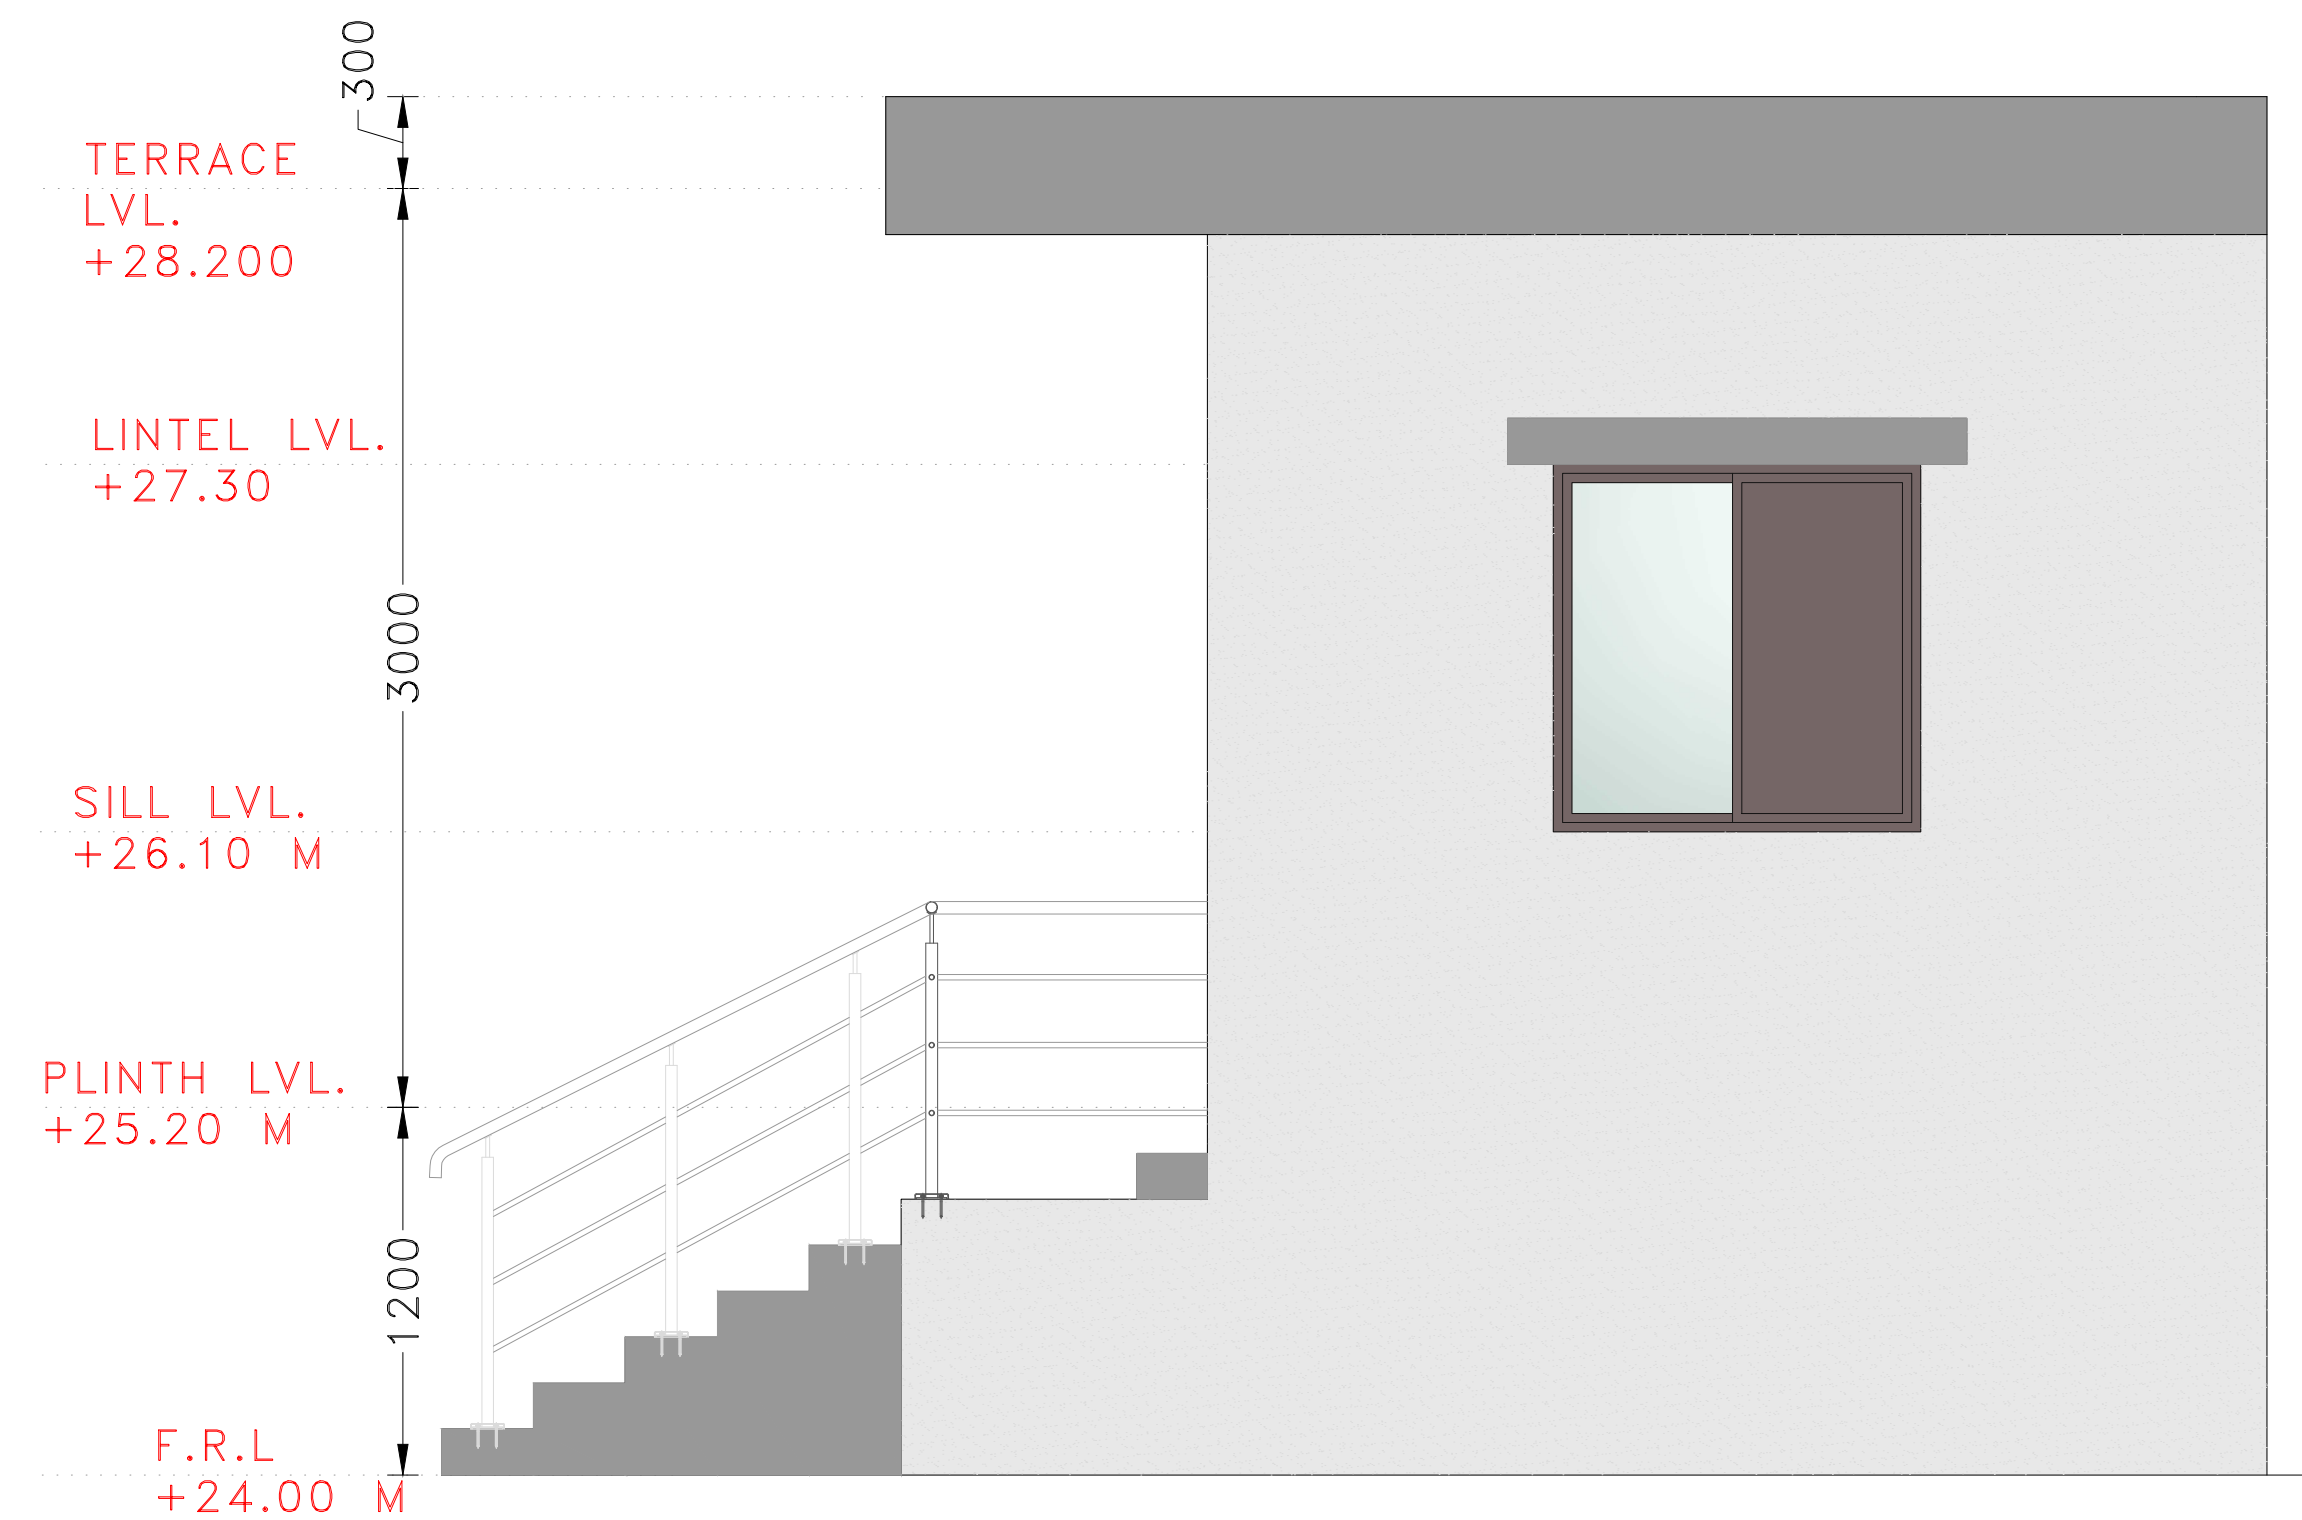


ELEVATION-A

SCALE 1:50

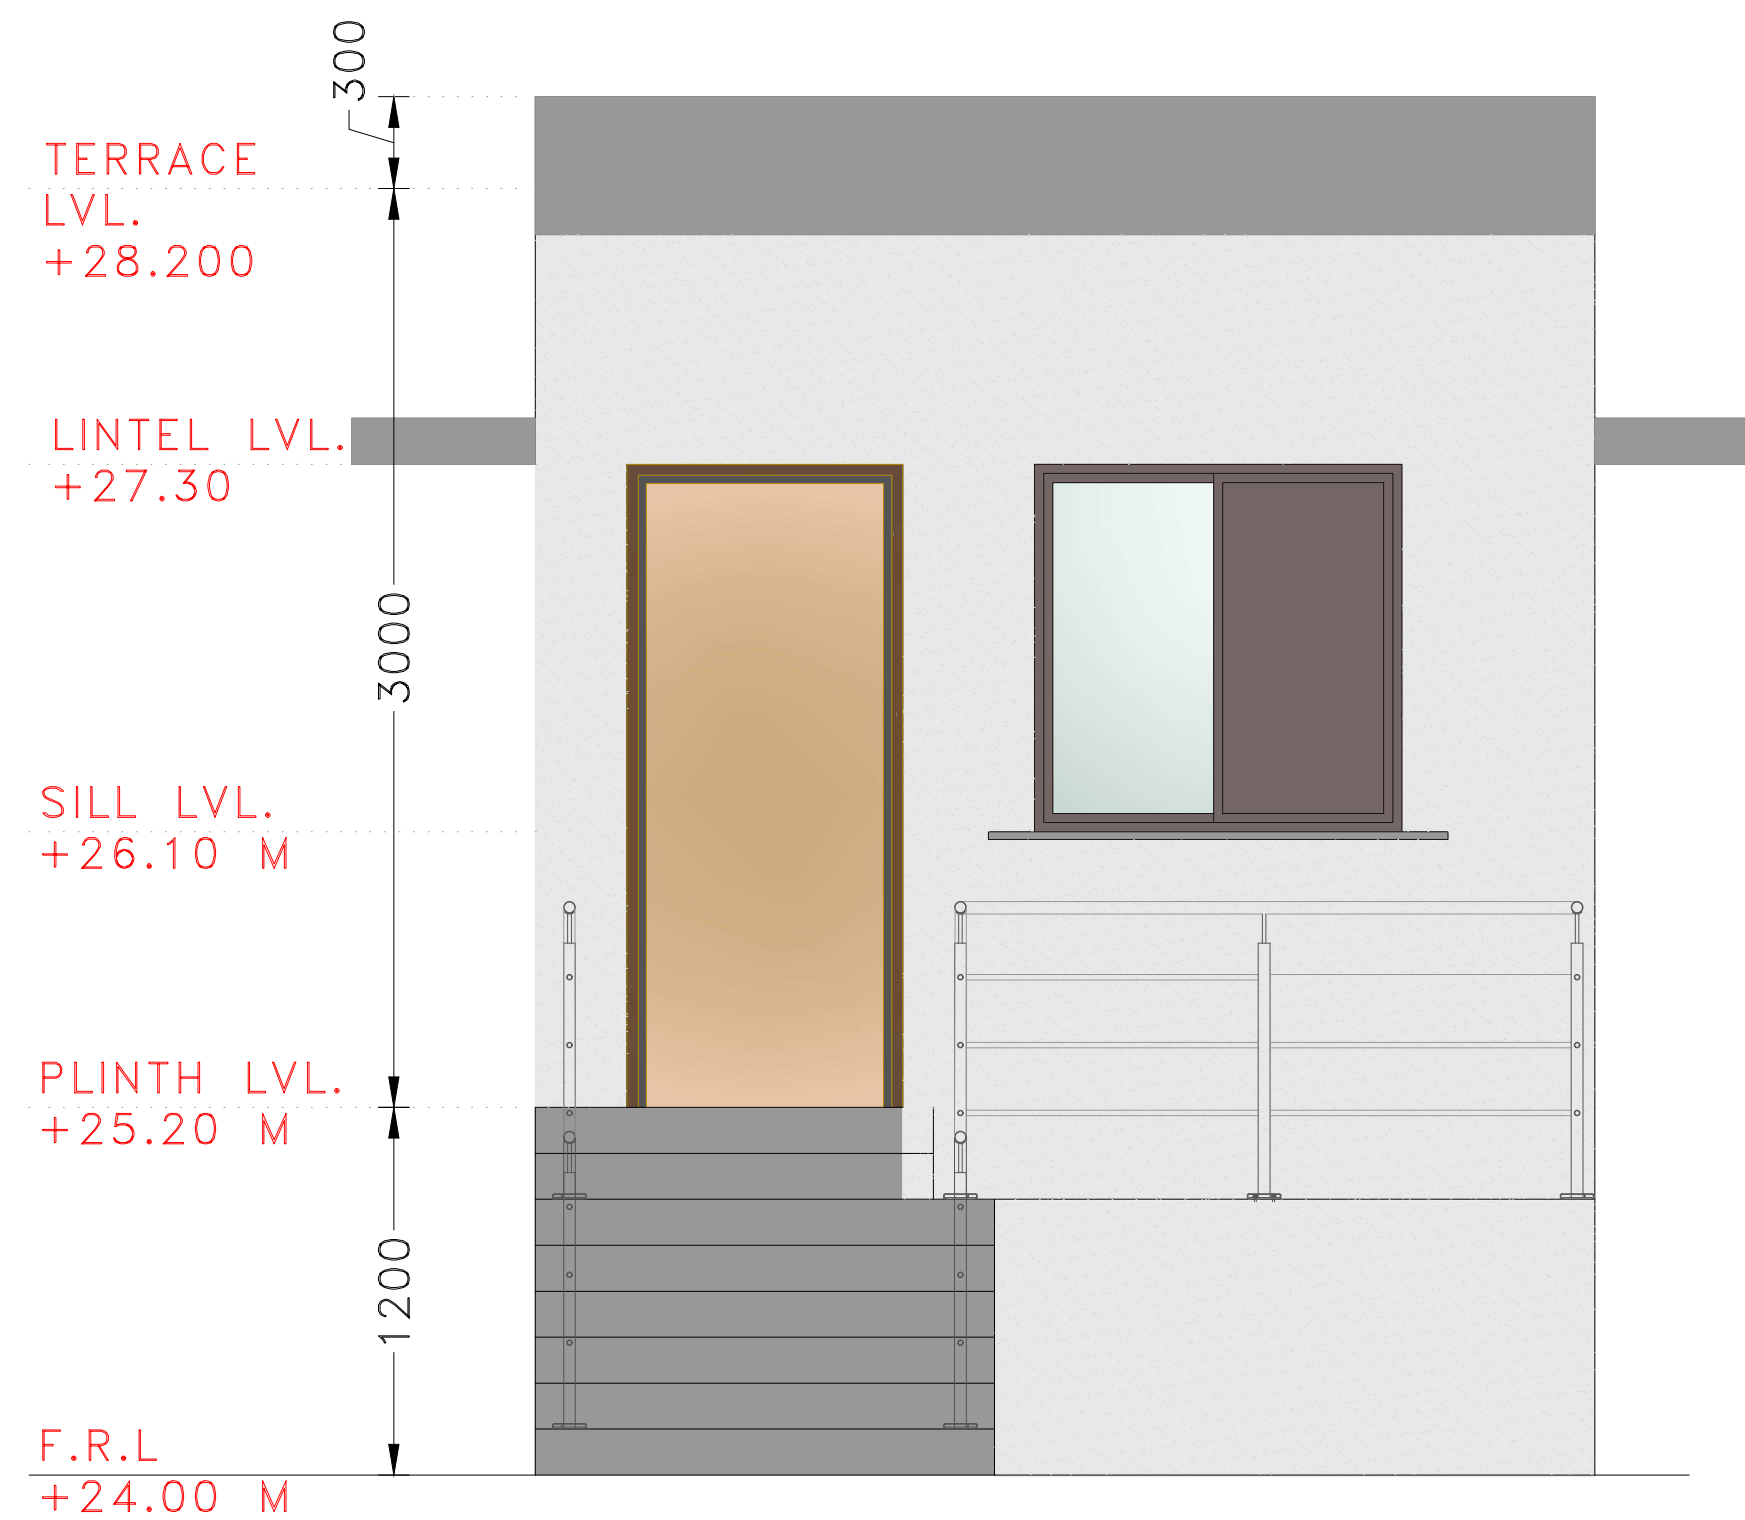

ELEVATION-B

SCALE 1:50

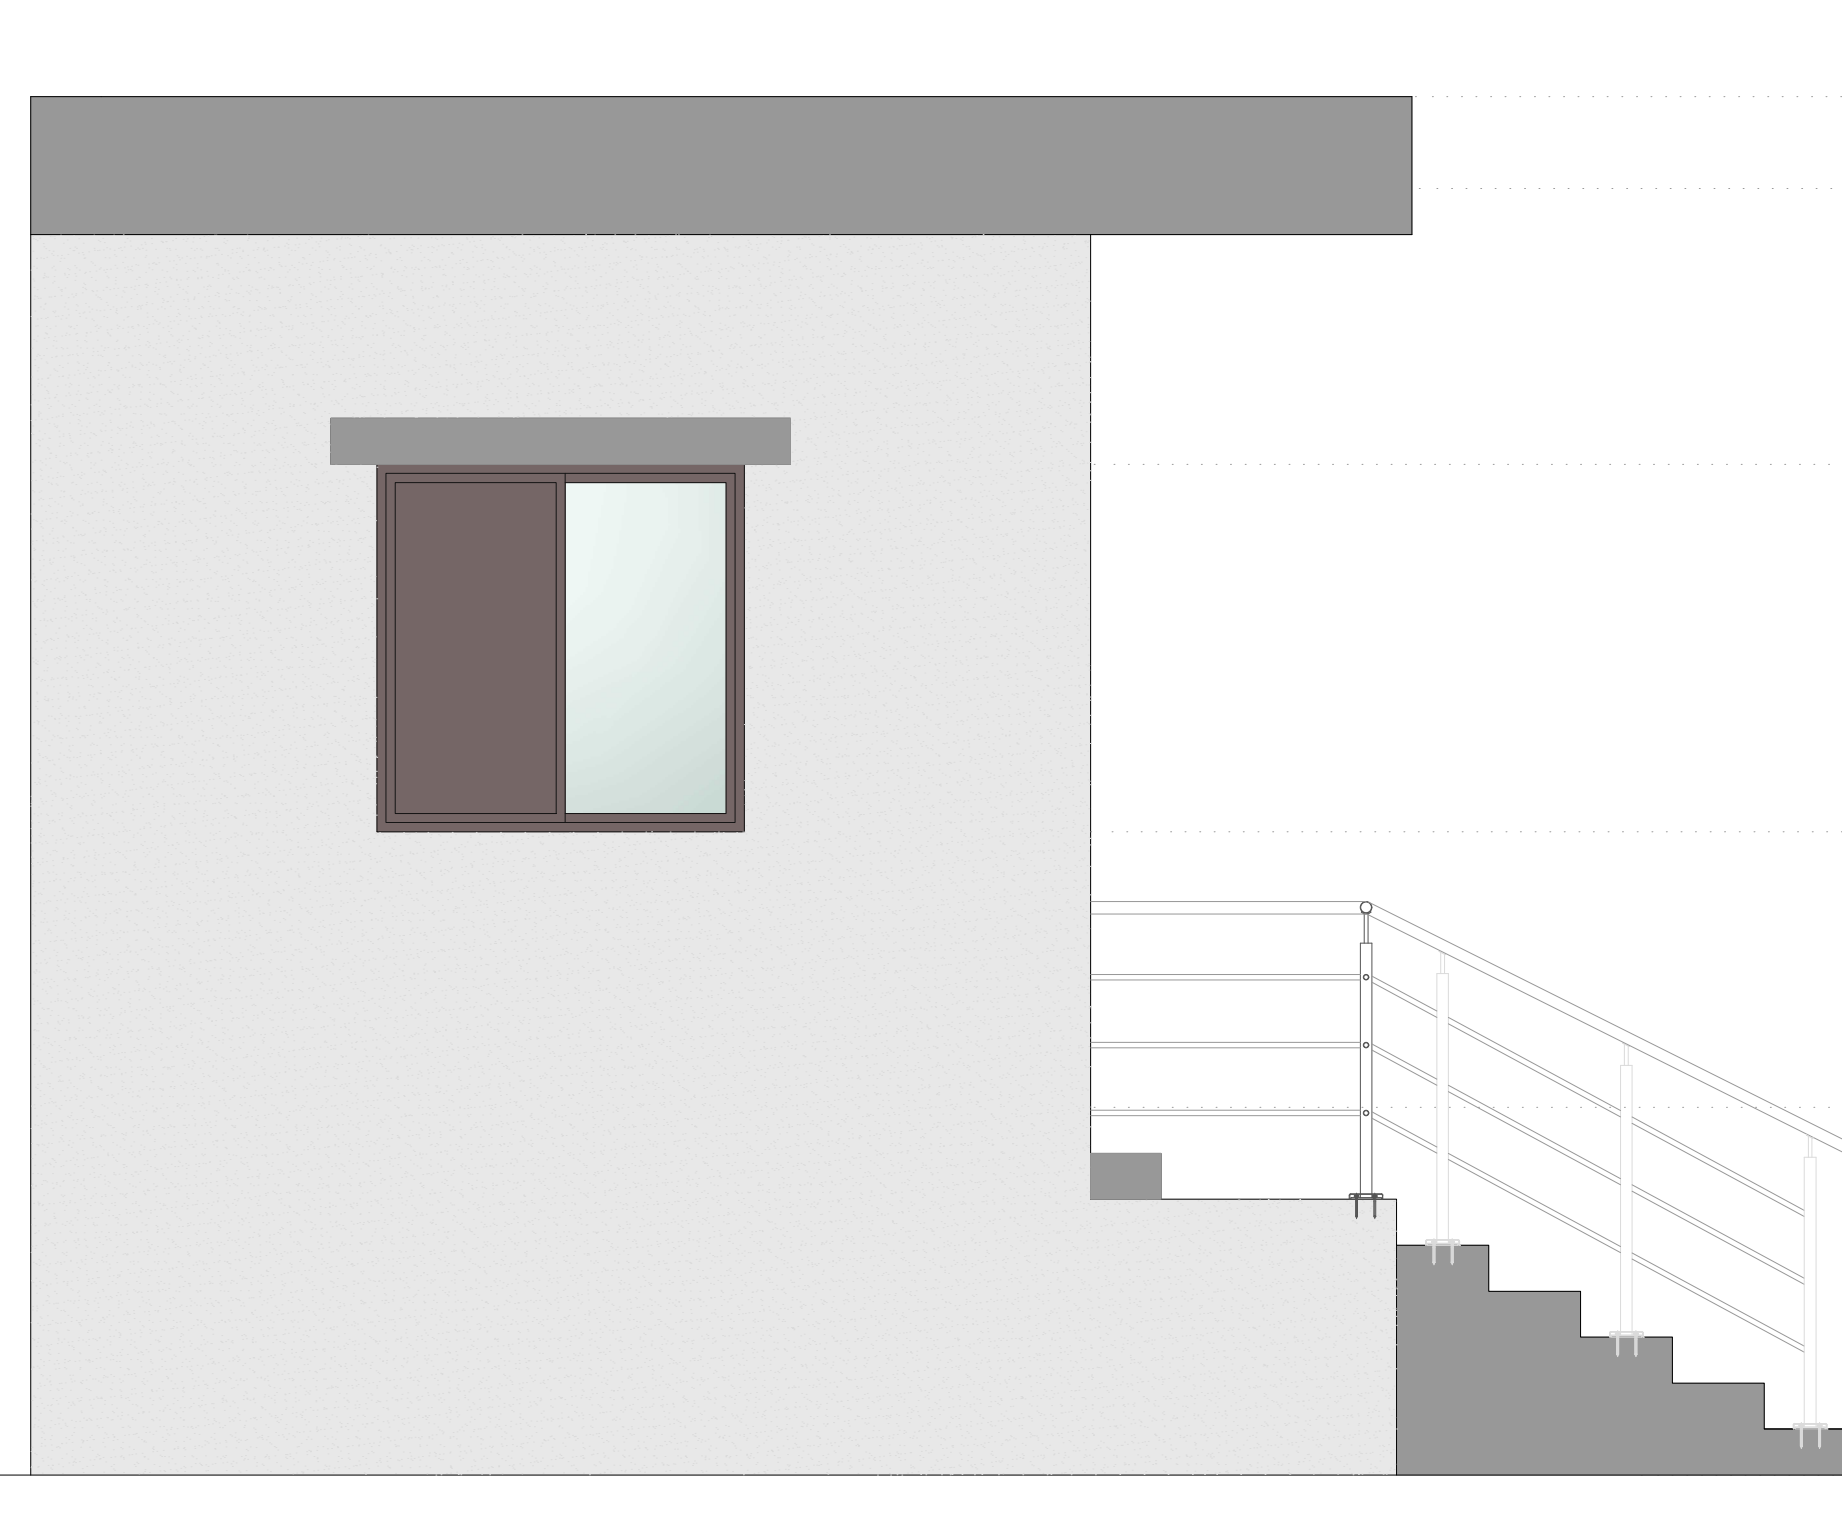

ELEVATION-C

SCALE 1:50

THESE ALL ARE TENDER DRAWINGS ONLY. ONLY FOR TENDER PURPOSE. NOT FOR CONSTRUCTION PURPOSE. BEFORE STARTING THE CONSTRUCTION TAKE AN APPROVAL FROM THE CONCERN AUTHORITY

REVI.	DATE	PURPOSE	BY
R1	12-01-26		RD

REVISION HISTORY

CLIENT



ADDRESS:

MORBI MUNICIPAL CORPORATION
15, Vasant Plot Main Road,
Sardar Nagar, Morbi-363641

CONSULTANTS



ADDRESS:

GUJARAT ENERGY RESEARCH & MANAGEMENT INSTITUTE
1st FLOOR, ENERGY BUILDING PDP
CAMPUS, RAISAN VILLAGE,
GANDHINAGAR,
GUJARAT-382 007

CONTACT:

information@germi.org

PROJECT NUMBER:- 6225

BUILDING NAME:- WEIGHT BRIDGE CABIN

PROJECT NAME:- NEW SLF FOR LALPUR SITE, MORBI

DRAWN:- RAVINDRA

DATE:- 12-01-2026

CHECK:- YOGENDU

APPROVE:- P.S.RAO

SCALE:- VERY

DRAWING TITLE:-
WEIGHT BRIDGE
CABIN_ELECTRICAL_LAYOUT

DRAWING NO	REVISION	SHEET	FOR
TATVA-M-05	R0	A1	T TENDER

CONFIDENTIAL STATEMENT:- THIS DRAWING IS THE PROPERTY OF P.VORA DESIGN AND ENGINEERING CONSULTANTS. THIS INFORMATION IS CONFIDENTIAL AND IS TO BE USED IN CONNECTION WITH WORK DESCRIBED BY P.VORA DESIGN AND ENGINEERING CONSULTANTS. NO PART IS TO BE DISCLOSED OR COPY TO OTHER WITHOUT WRITTEN PERMISSION FROM P.VORA DESIGN AND ENGINEERING CONSULTANTS.