



# PROPOSED BHUJ ARCHEOLOGY OFFICE, AT BHUJ.


**EITHER OR**  
ARCHITECTURE

**EITHER OR**  
ARCHITECTURE  
901, Matrix, Behind Divya Bhaskar,  
S G Highway, Ahmedabad - Gujarat - 54.  
eitheror.architecture@gmail.com, 9724694445

## TENDER DRAWINGS

- Of Bhuj Archeology office
1. General Development Of Study Hall Jamnagar
  2. Architectural Drawings
  3. Flooring Drawings
  4. Plumbing Drawings
  5. Fire Drawing
  6. Electrical Drawings
  7. ELV Drawings
- 20th May\_2026



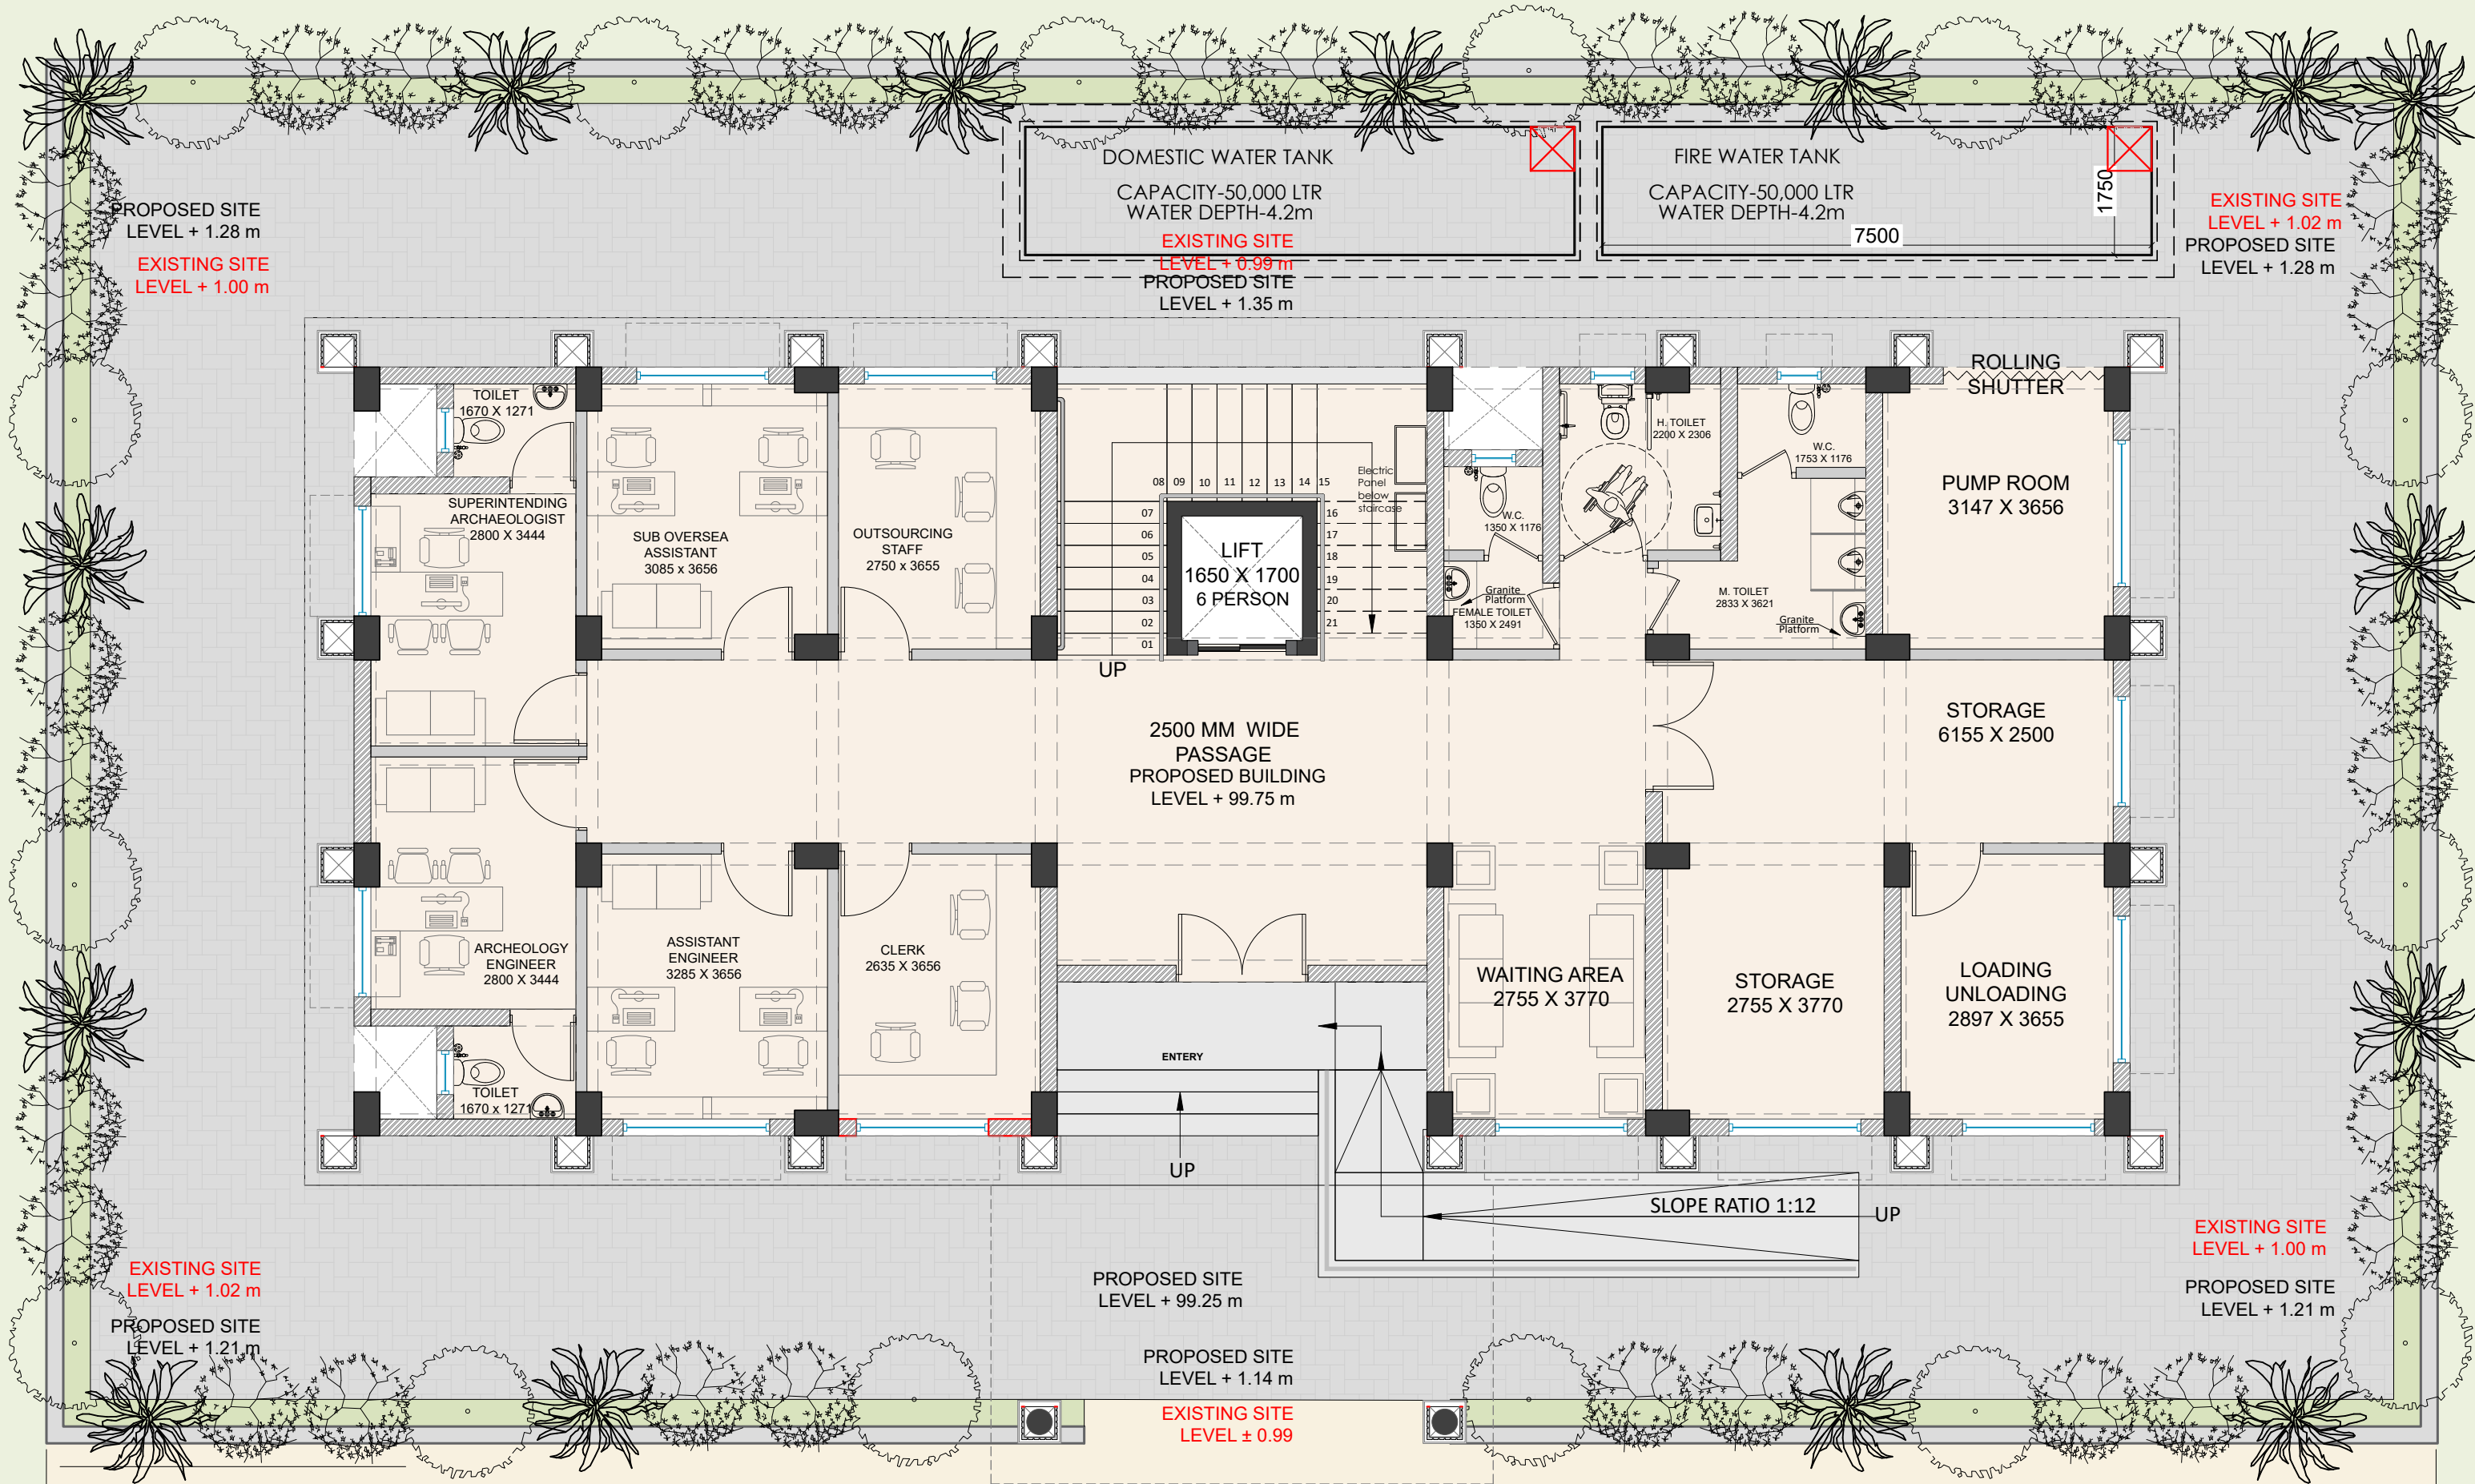






Site Area : 618 Sq.mt.

Sr.no	Floor	Built Up Area (Sq.mt.)
1	Ground Floor	240.0 Sq.mt.
2	First Floor	282 Sq.mt.
3	Second Floor	200 Sq.mt.
4	Terrace Floor	40.8 Sq.mt.
	Total	762.8 Sq.mt.

PROJECT INFORMATION:	SITE ADDRESS :	KEY PLAN :	GENERAL NOTES:	REVISION PARTICULARS:	STRUCTURAL CON	ARCHITECTS / INTERIOR DESIGNERS:	DRAWING TITLE:
ARCHOLOGY	CLIENT : <b>SPORTS AUTHORITY OF GUJARAT</b>		1. All Dimensions Are In MM 2. Do not scale the drawings. 3. This drawing is to be read in conjunction with all other related architectural & others consultants drawings. 4. Any discrepancy found in the drawings must be brought to Architect's office prior of execution.	SR.NO DATE Dwn By Revision	PARAM CONSULTING ENGINEERS B/1111 UNICUS SHYAMAL SHYAMAL CROSS ROAD, AHMEDABAD-15 MO : 9510415231 E mail : kedar.paramconsultant@gmail.com	<b>EITHER OR ARCHITECTURE</b> 901, Matrix, Behind Divya Bhaskar, S G Highway, Ahmedabad - Gujarat - 54. eitheror.architecture@gmail.com, 9724694445	SITE PLAN
					M.E.P CONSULTANT		
						SCALE: N.T.S. DATE : 20-05-2026 REV.NO: R0 PROJ REF: ARC & CIVIL	DWN BY: HARSH SHAH CHECKED BY: APPROVED BY:

LEGENDS	
	FULL AAC BLOCK WALL
	HALF AAC BLOCK WALL
	RCC
	LOW HEIGHTED WALL

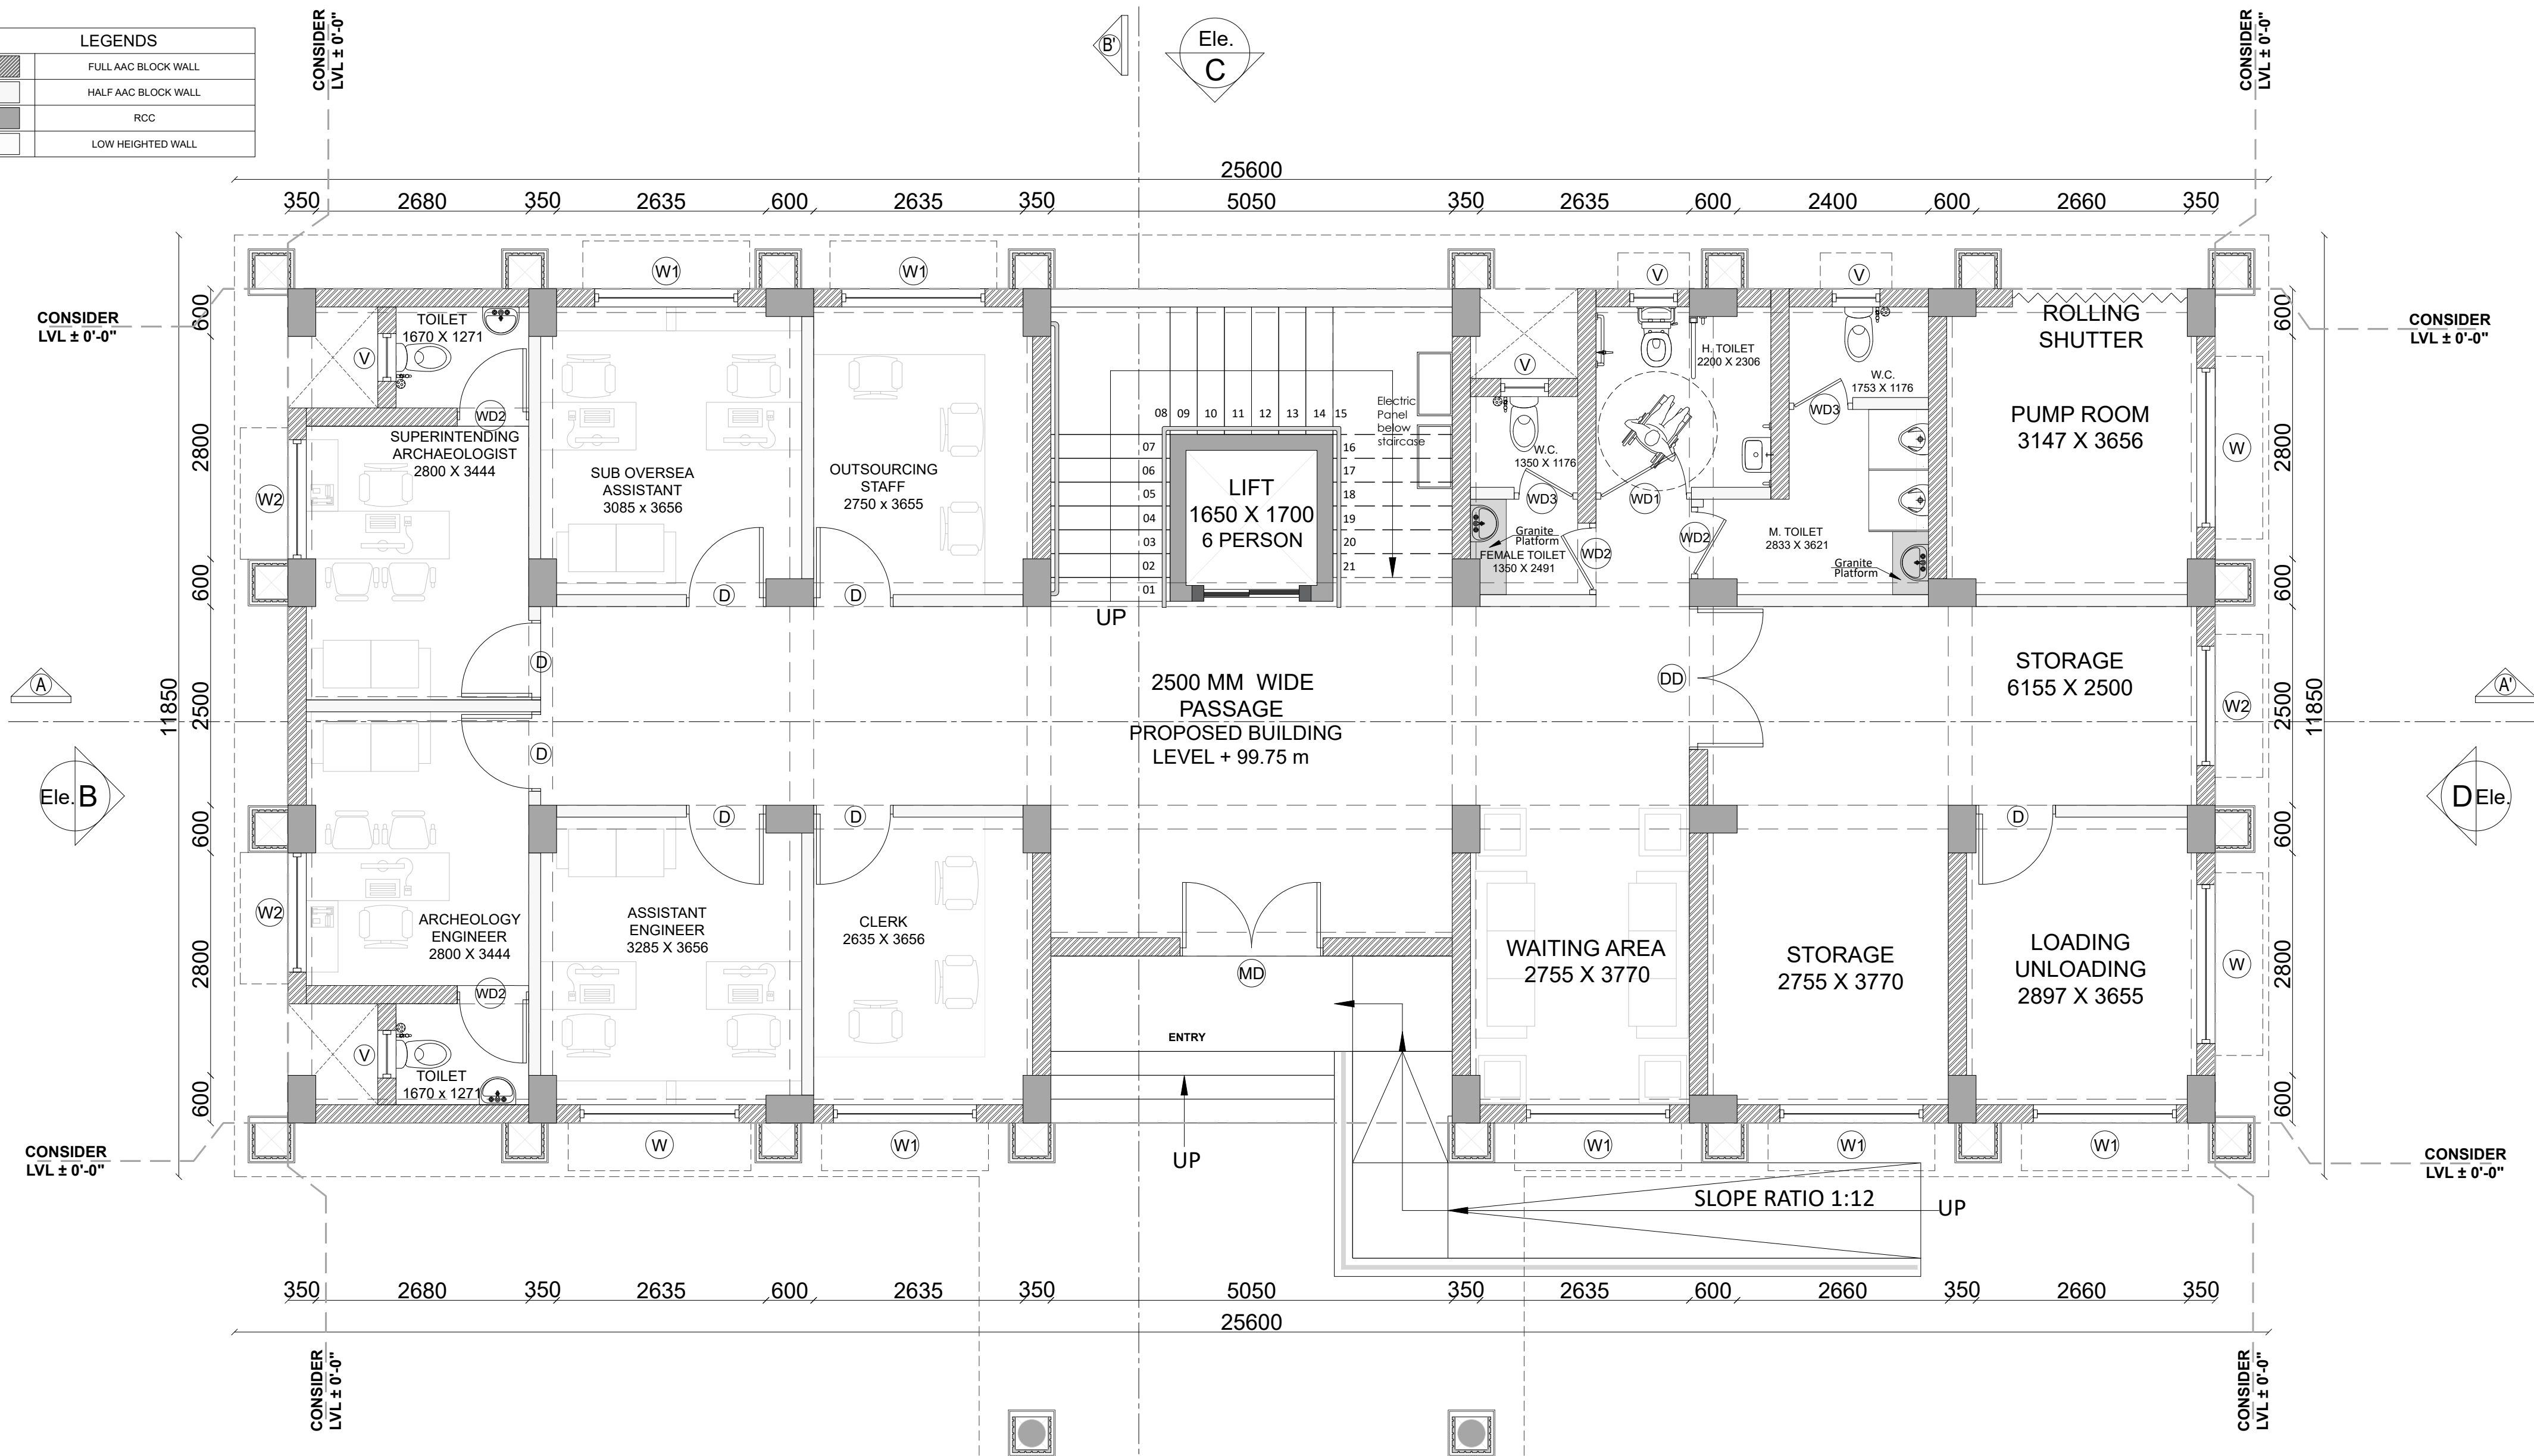


GROUND FLOOR - DOOR & WINDOW SCHEDULE					
FLUSH DOOR WITH LAMINATE FINISH					
CODE	DOOR SIZE	NO. OF DOORS	SILL HT.	LINTEL HT.	TYPE
MD	1800 X 2175	1	-	2175	2 - SHUTTER
DD	1800 X 2175	1	-	2175	2 - SHUTTER
D	1000 X 2175	7	-	2175	1 - SHUTTER

FLUSH DOOR WITH WPC FRAME					
CODE	DOOR SIZE	NO. OF DOORS	SILL HT.	LINTEL HT.	TYPE
WD1	1200 X 2175	1	-	2175	1 - SHUTTER
WD2	900 X 2175	4	-	2175	1 - SHUTTER
WD3	800 X 2175	2	-	2175	1 - SHUTTER

UPVC WINDOW					
CODE	WINDOW SIZE	NO. OF WINDOW	SILL HT.	LINTEL HT.	TYPE
W	2000 X 1275	3	900	2175	2 - SHUTTER
W1	1800 X 1275	6	900	2175	2 - SHUTTER
W2	1500 X 1275	3	900	2175	2 - SHUTTER


VENTILATION					
CODE	VENTILATION SIZE	NO. OF VENTILATI ON	SILL HT.	LINTEL HT.	TYPE
V	600 X 600	5	1575	2175	-

PROJECT INFORMATION:		SITE ADDRESS :		KEY PLAN :		GENERAL NOTES:		REVISION PARTICULARS:				STRUCTURAL CON		ARCHITECTS / INTERIOR DESIGNERS:		DRAWING TITLE:		<div></div>		
BHUJ ARCHEOLOGY OFFICE, AT BHUJ.		CLIENT :  SPORTS AUTHORITY OF GUJARAT				1. All Dimensions Are In MM 2. Do not scale the drawings.  3. This drawing is to be read in conjunction with all other related architectural & others consultants drawings.  4. Any discrepancy found in the drawings must be brought to Architect's office prior of execution.						PARAM CONSULTING ENGINEERS B/1111 UNICUS SHYAMAL SHYAMAL CROSS ROAD, AHMEDABAD-15 MO :- 9510415231 E mail :- kedar.paramconsultant@gmail.com		/ <b>EITHER OR</b> ARCHITECTURE  901, Matrix, Behind Divya Bhaskar, S G Highway, Ahmedabad - Gujarat - 54. eitheror.architecture@gmail.com, 9724694445		GROUND FLOOR PLAN				
												M.E.P CONSULTANT				SCALE: 1:25 DATE : 20-05-2026 SHEET NO : S01 REV.NO: R0 PROJ REF: ARC & CIVIL			DWN BY: HARSH SHAH CHECKED BY: DRAWING NO: A - 101	





LEGENDS	
	FULL AAC BLOCK WALL
	HALF AAC BLOCK WALL
	RCC
	LOW HEIGHTED WALL

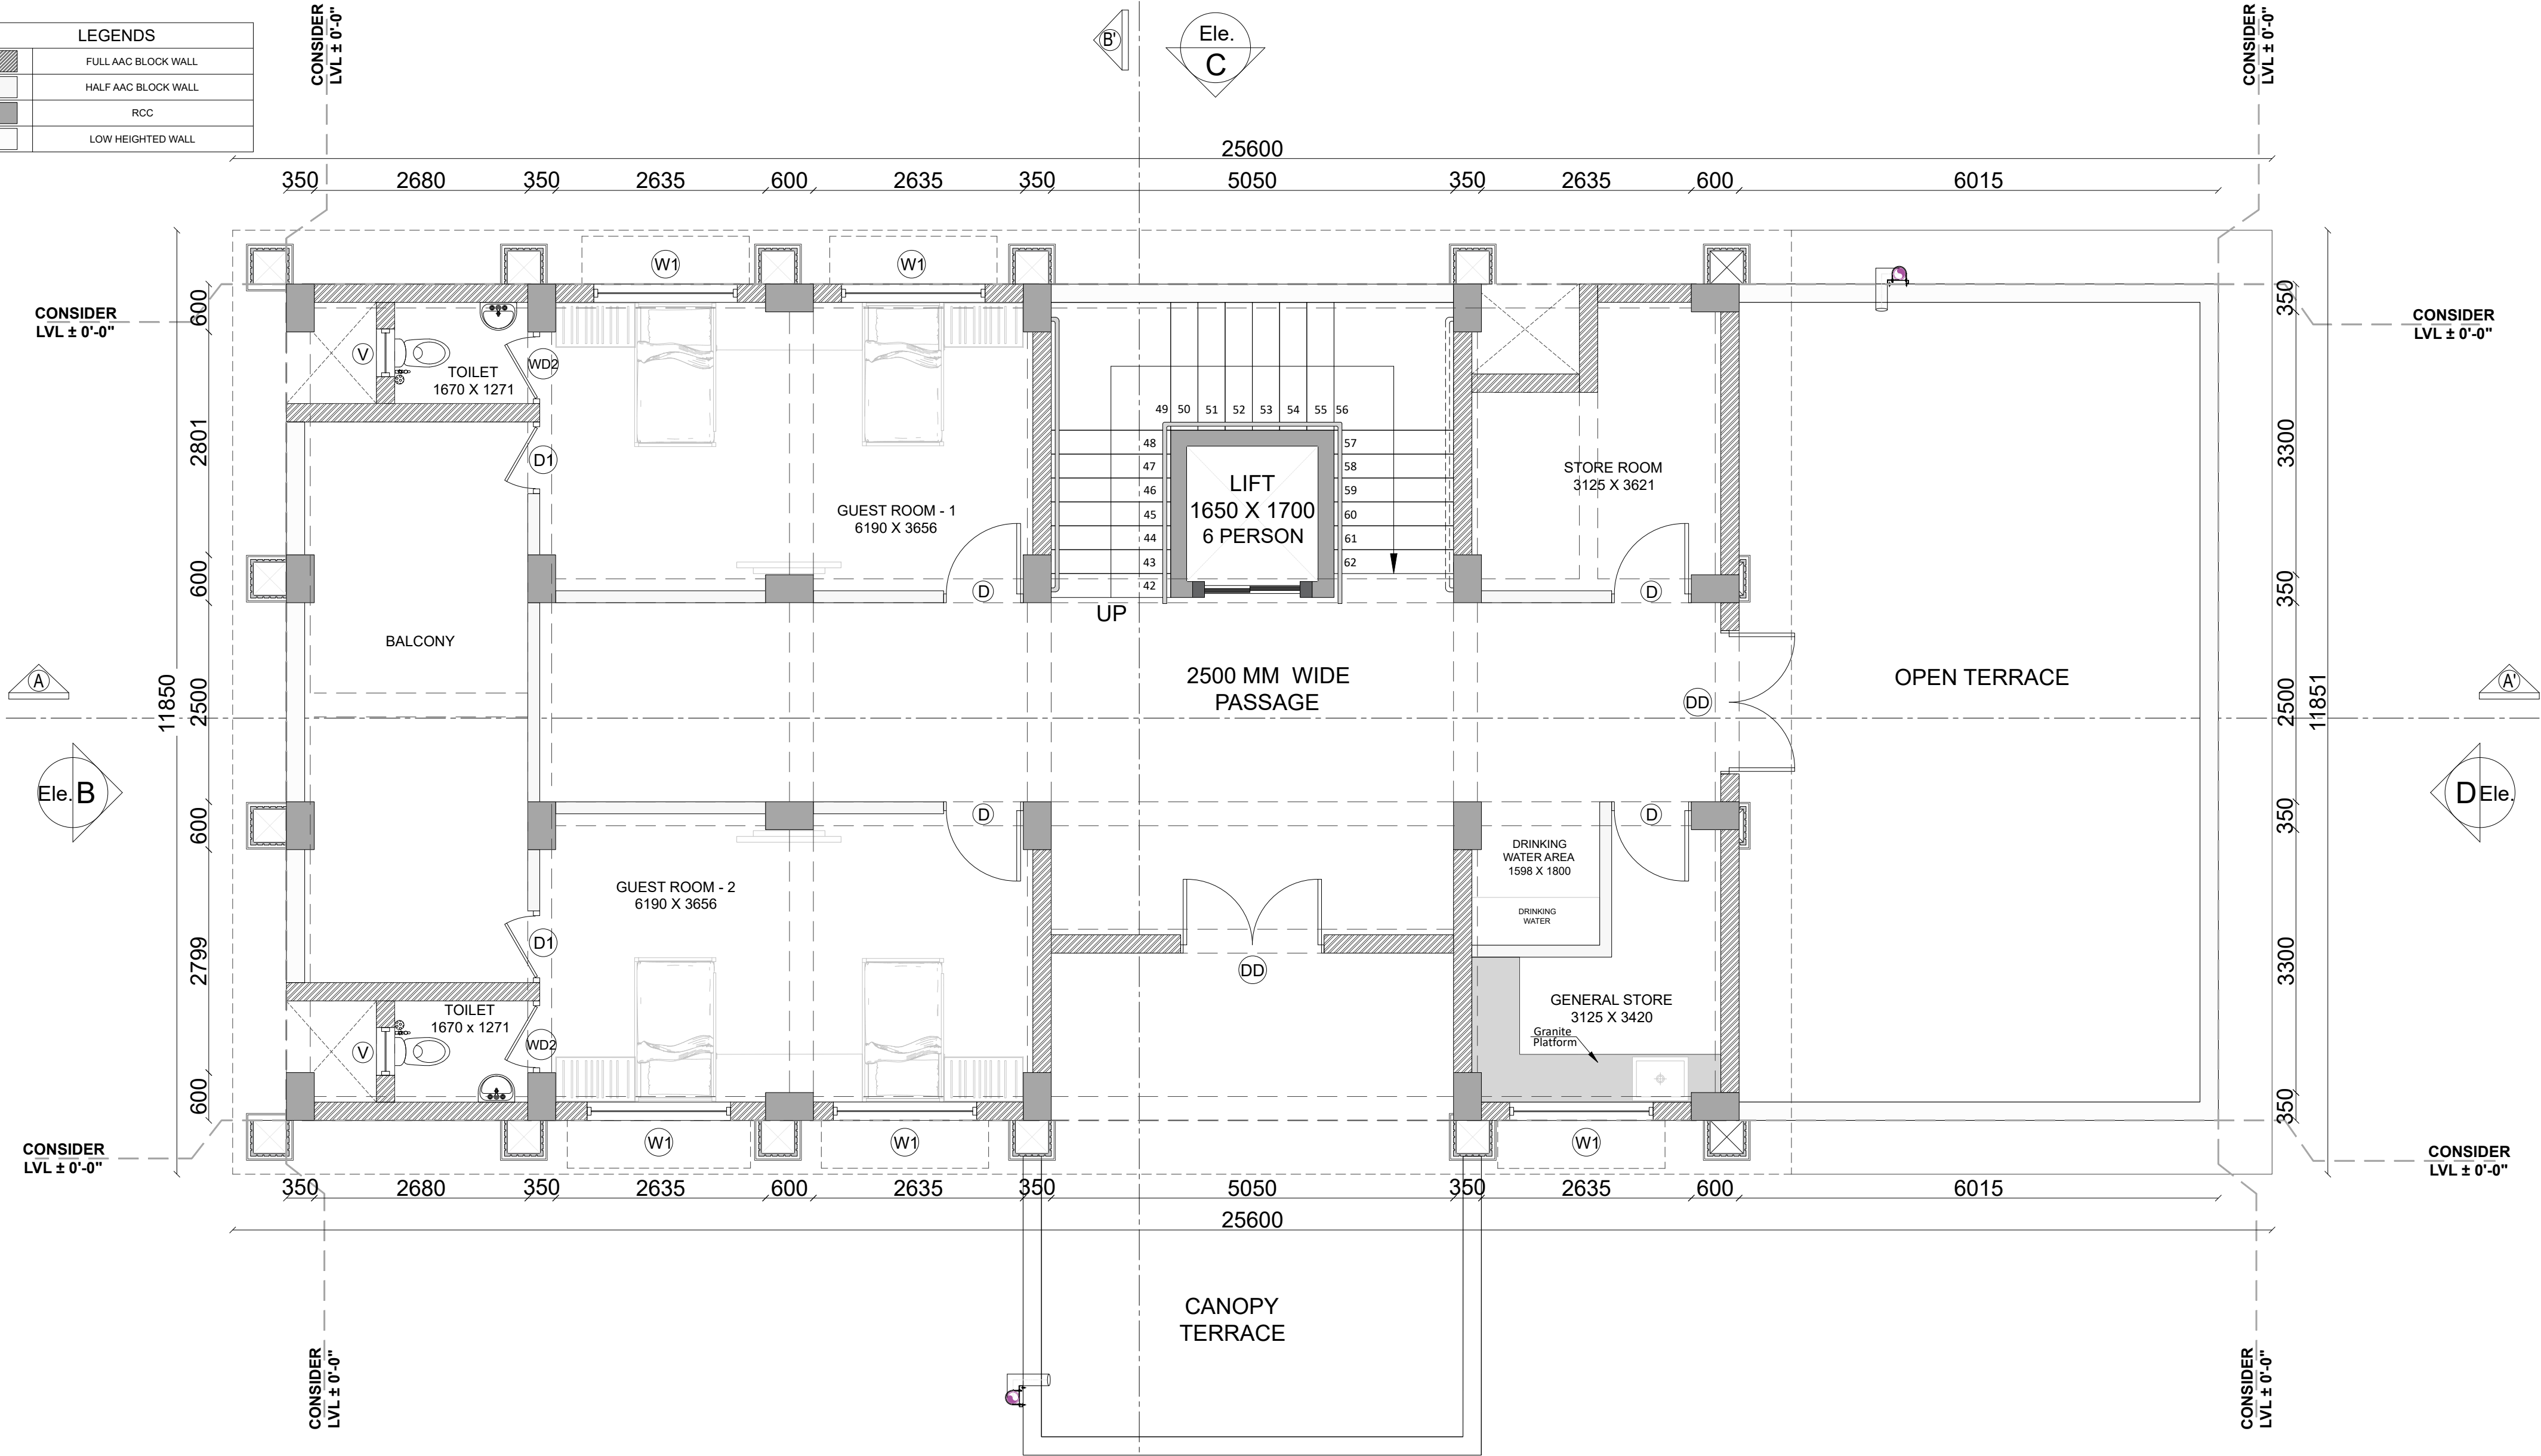


SECOND FLOOR - DOOR & WINDOW SCHEDULE					
FLUSH DOOR WITH LAMINATE FINISH					
CODE	DOOR SIZE	NO. OF DOORS	SILL HT.	LINTEL HT.	TYPE
DD	1800 X 2175	2	-	2175	2 - SHUTTER
D	1000 X 2175	4	-	2175	1 - SHUTTER
D1	900 X 2175	2	-	2175	1 - SHUTTER

FLUSH DOOR WITH WPC FRAME					
CODE	DOOR SIZE	NO. OF DOORS	SILL HT.	LINTEL HT.	TYPE
WD2	900 X 2175	2	-	2175	1 - SHUTTER

UPVC WINDOW					
CODE	WINDOW SIZE	NO. OF WINDOW	SILL HT.	LINTEL HT.	TYPE
W1	1800 X 1275	5	900	2175	2 - SHUTTER


VENTILATION					
CODE	VENTILATION SIZE	NO. OF VENTILATION	SILL HT.	LINTEL HT.	TYPE
V	600 X 600	2	1575	2175	-

PROJECT INFORMATION:		SITE ADDRESS :	KEY PLAN :	GENERAL NOTES:	REVISION PARTICULARS:				STRUCTURAL CON	ARCHITECTS / INTERIOR DESIGNERS:	DRAWING TITLE:						
BHUIJ ARCHEOLOGY OFFICE, AT BHUIJ.				1. All Dimensions Are In MM 2. Do not scale the drawings.  3. This drawing is to be read in conjunction with all other related architectural & others consultants drawings.  4. Any discrepancy found in the drawings must be brought to Architect's office prior of execution.					<div>PARAM</div> <div>CONSULTING ENGINEERS</div> <div>B/1111 UNICUS SHYAMAL</div> <div>SHYAMAL CROSS ROAD, AHMEDABAD-15</div> <div>MO :- 9510415231</div> <div>E mail :-kedar.paramconsultant@gmail.com</div>	<div>EITHER OR</div> <div>ARCHITECTURE</div> <div>901, Matrix, Behind Divya Bhaskar,</div> <div>S G Highway, Ahmedabad - Gujarat - 54.</div> <div>eitheror.architecture@gmail.com, 9724694445</div>	SECOND FLOOR PLAN					<div><div>SCALE:</div><div>1:25</div></div> <div><div>DATE :</div><div>20-05-2026</div></div> <div><div>SHEET NO :</div><div>S03</div></div> <div><div>REV.NO:</div><div>R0</div></div> <div><div>PROJ REF:</div><div>ARC &amp; CIVIL</div></div>	<div><div>DWN BY:</div><div>HARSH SHAH</div></div> <div><div>CHECKED BY:</div><div></div></div> <div><div>APPROVED BY:</div><div></div></div>

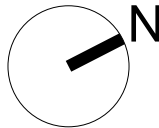






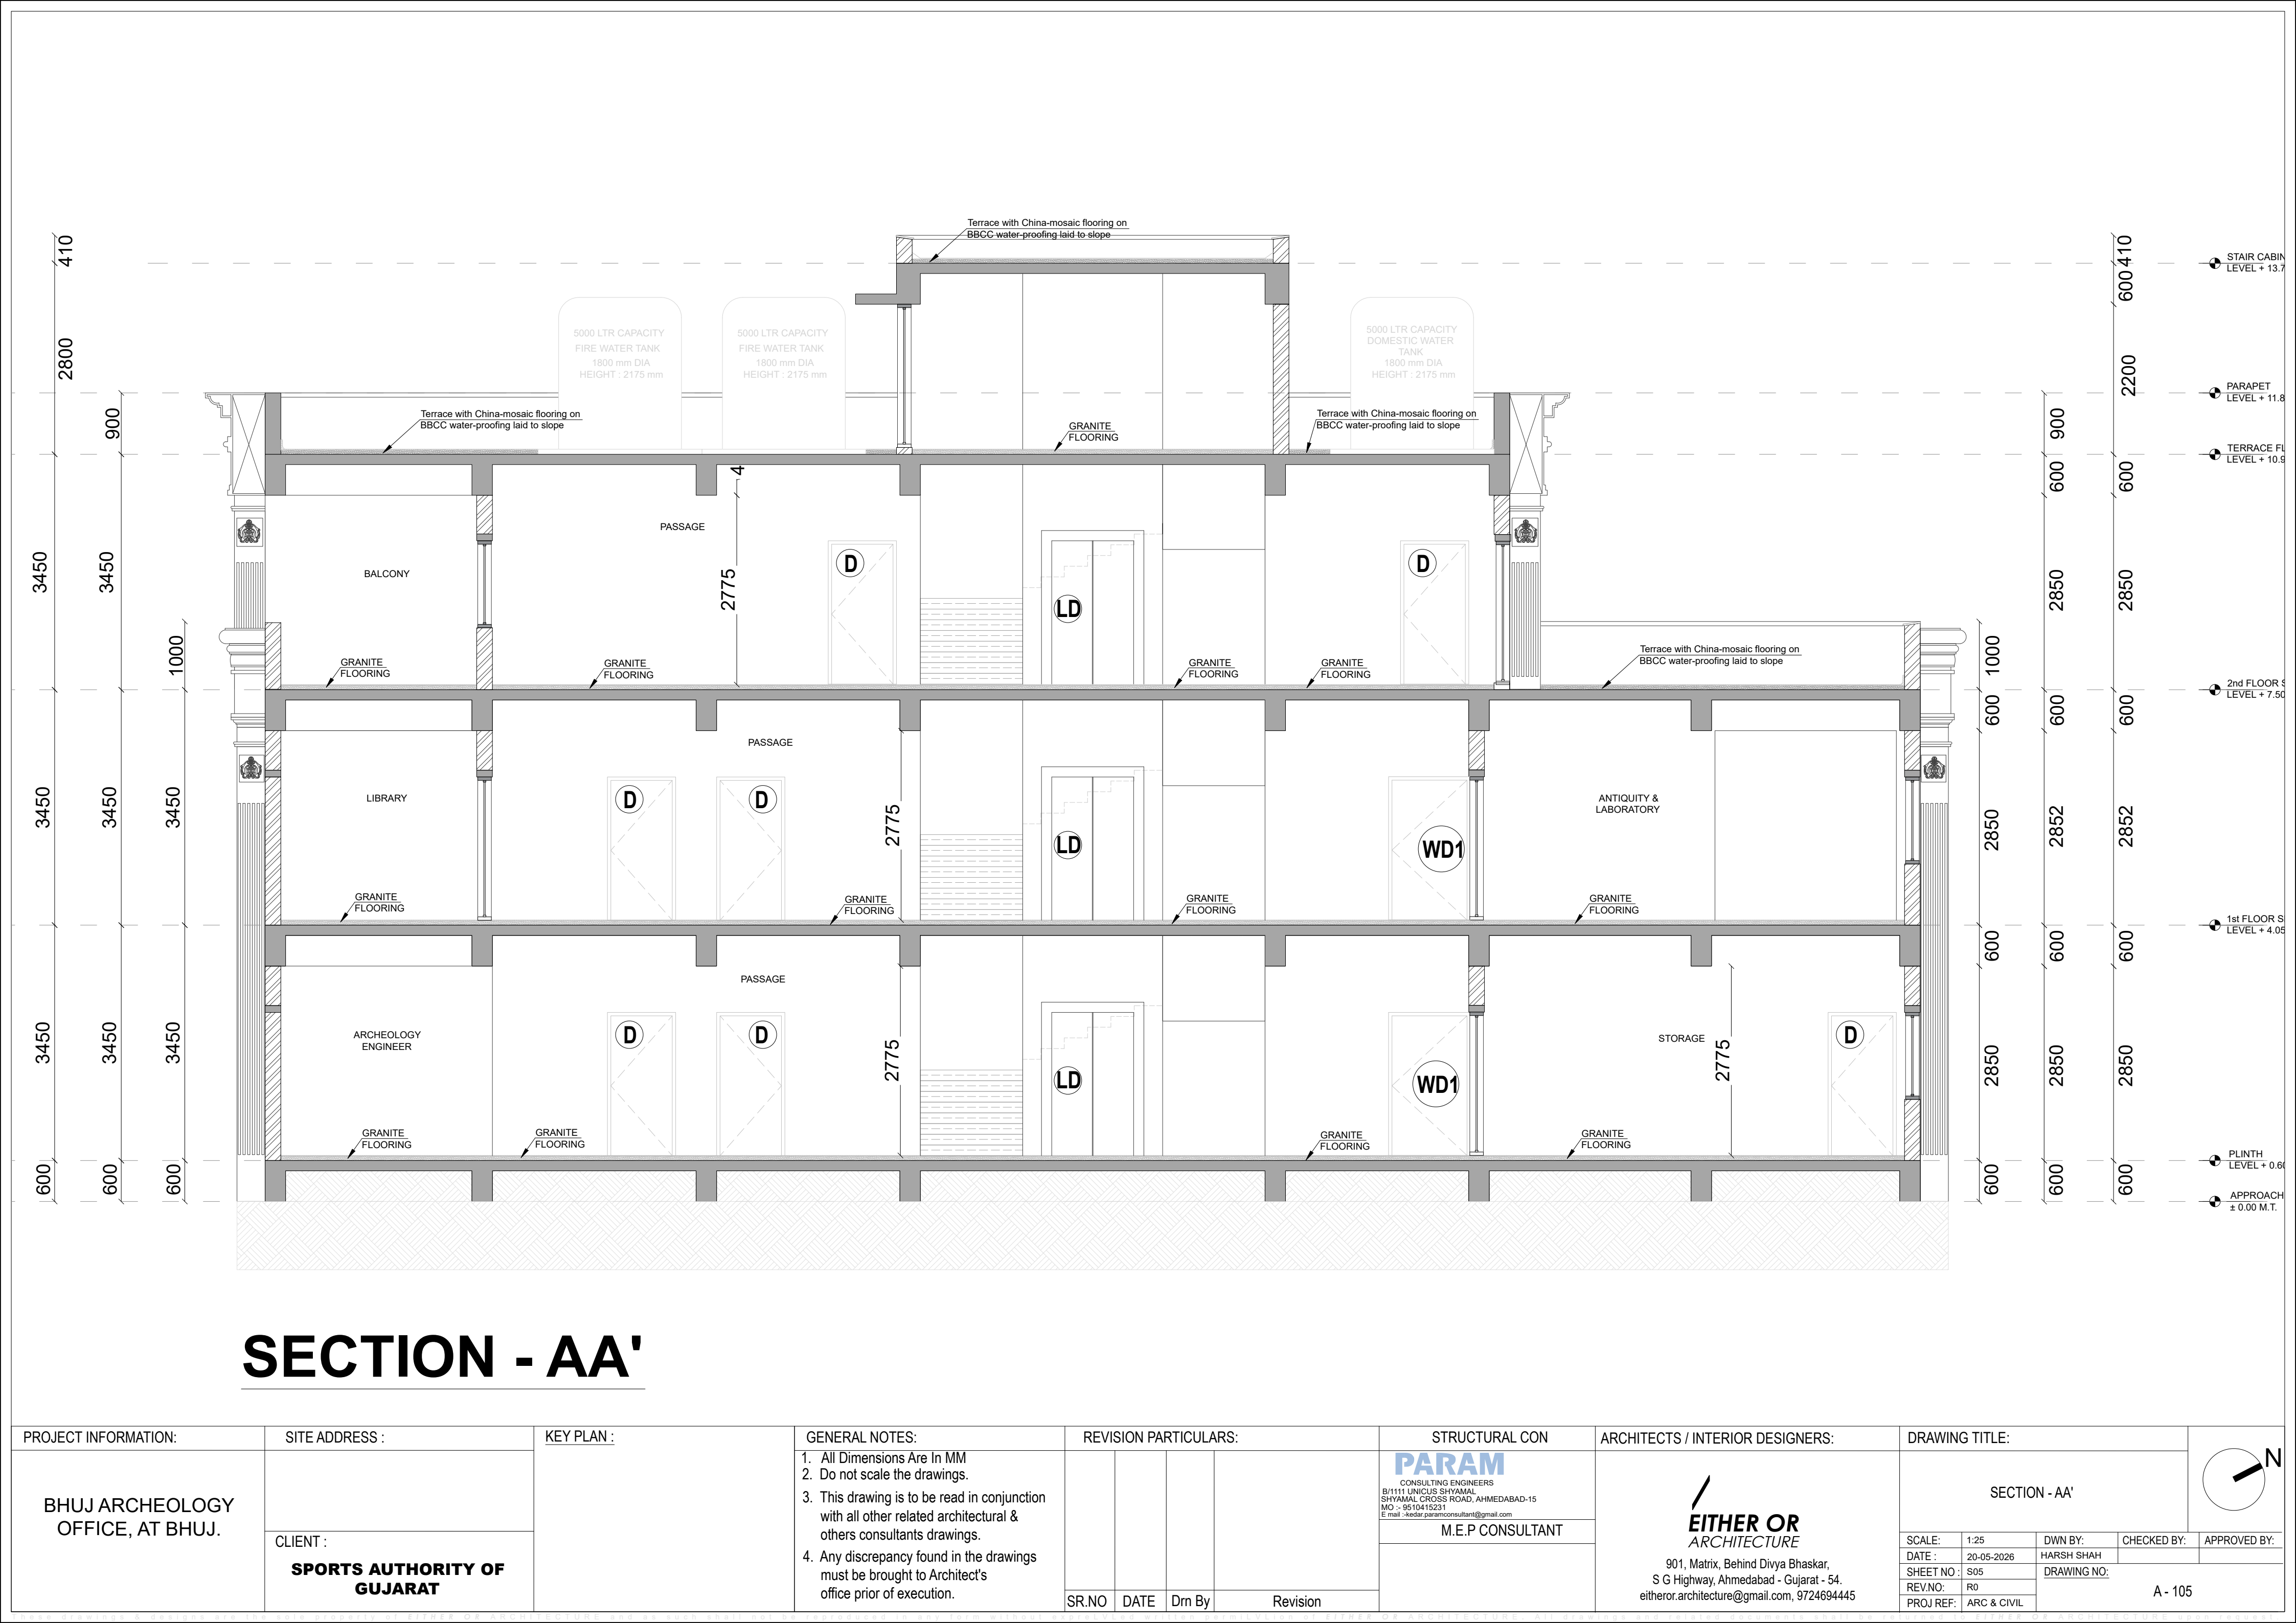

SECTION - AA'


PROJECT INFORMATION:		SITE ADDRESS :	KEY PLAN :	GENERAL NOTES:		REVISION PARTICULARS:		STRUCTURAL CON	ARCHITECTS / INTERIOR DESIGNERS:	DRAWING TITLE:			
BHUIJ ARCHEOLOGY OFFICE, AT BHUIJ.		CLIENT :  <b>SPORTS AUTHORITY OF GUJARAT</b>		1. All Dimensions Are In MM 2. Do not scale the drawings. 3. This drawing is to be read in conjunction with all other related architectural & others consultants drawings. 4. Any discrepancy found in the drawings must be brought to Architect's office prior of execution.		<div>SR.NO</div> <div>DATE</div> <div>Dwn By</div> <div>Revision</div>		<div>PARAM</div> <div>CONSULTING ENGINEERS</div> <div>B/1111 UNICUS SHYAMAL SHYAMAL CROSS ROAD, AHMEDABAD-15</div> <div>MO : 9510415231</div> <div>E mail : kedar.paramconsultant@gmail.com</div>	<div></div> <div><b>EITHER OR</b></div> <div>ARCHITECTURE</div> <div>901, Matrix, Behind Divya Bhaskar, S G Highway, Ahmedabad - Gujarat - 54.</div> <div>eithoror.architecture@gmail.com, 9724694445</div>	SECTION - AA'			
								M.E.P CONSULTANT					
SCALE:		1:25		DWN BY:		HARSH SHAH		CHECKED BY:		APPROVED BY:		A - 105	
DATE :		20-05-2026		SHEET NO :		S05		DRAWING NO:					
REV.NO:		R0		PROJ REF:		ARC & CIVIL							

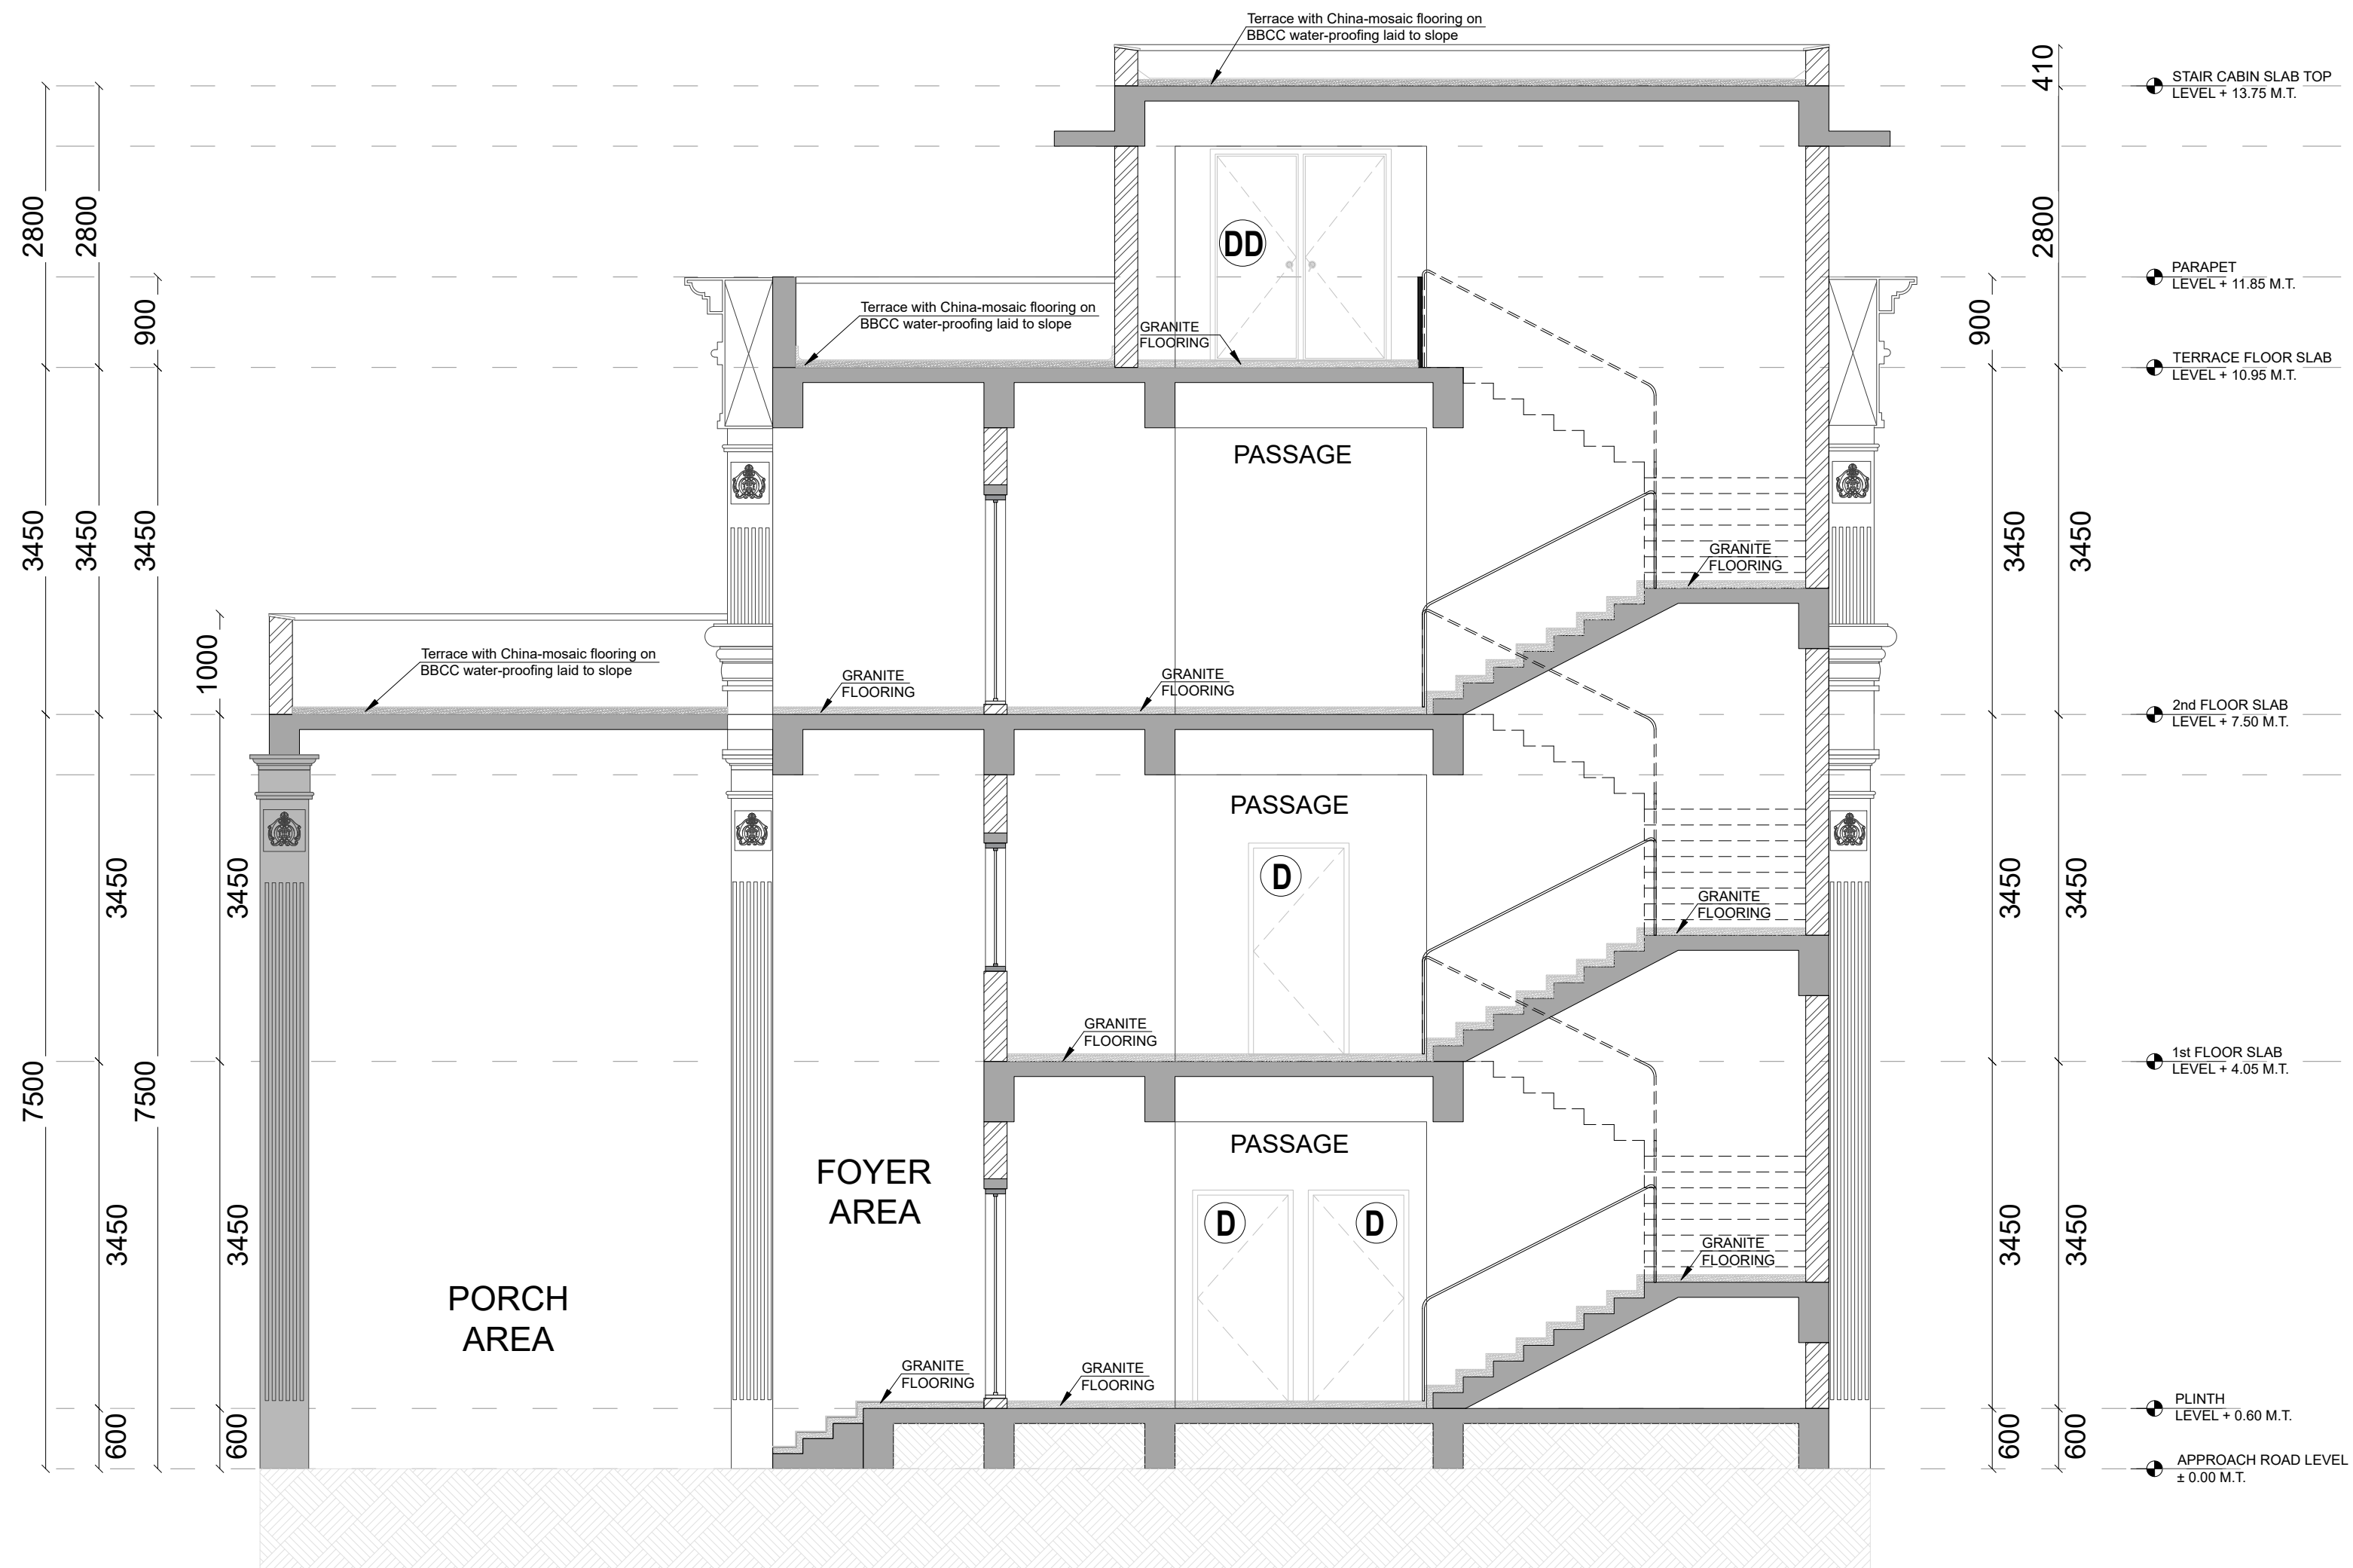

SECTION - BB'


PROJECT INFORMATION:		SITE ADDRESS :		KEY PLAN :		GENERAL NOTES:		REVISION PARTICULARS:				STRUCTURAL CON		ARCHITECTS / INTERIOR DESIGNERS:		DRAWING TITLE:		<div><div></div><div>N</div></div>										
BHUIJ ARCHEOLOGY OFFICE, AT BHUIJ.		CLIENT :  <b>SPORTS AUTHORITY OF GUJARAT</b>				1. All Dimensions Are In MM 2. Do not scale the drawings.  3. This drawing is to be read in conjunction with all other related architectural & others consultants drawings.  4. Any discrepancy found in the drawings must be brought to Architect's office prior of execution.		SR.NO		DATE		Dwn By		Revision		<div><div><div>PARAM</div><div>CONSULTING ENGINEERS</div><div>B/1111 UNICUS SHYAMAL</div><div>SHYAMAL CROSS ROAD, AHMEDABAD-15</div><div>MO :- 9510415231</div><div>E mail :- kedar.paramconsultant@gmail.com</div></div><div>M.E.P CONSULTANT</div></div>			<div><div><div><div></div><div>EITHER OR</div><div>ARCHITECTURE</div></div><div>901, Matrix, Behind Divya Bhaskar,</div><div>S G Highway, Ahmedabad - Gujarat - 54.</div><div>eitheror.architecture@gmail.com, 9724694445</div></div></div>		SECTION - BB'							
																SCALE:					1:25		DWN BY:		CHECKED BY:		APPROVED BY:	
																DATE :					20-05-2026		HARSH SHAH					
																SHEET NO :					S06		DRAWING NO:					
REV.NO:		R0																										
PROJ REF:		ARC & CIVIL																										
														A - 106														



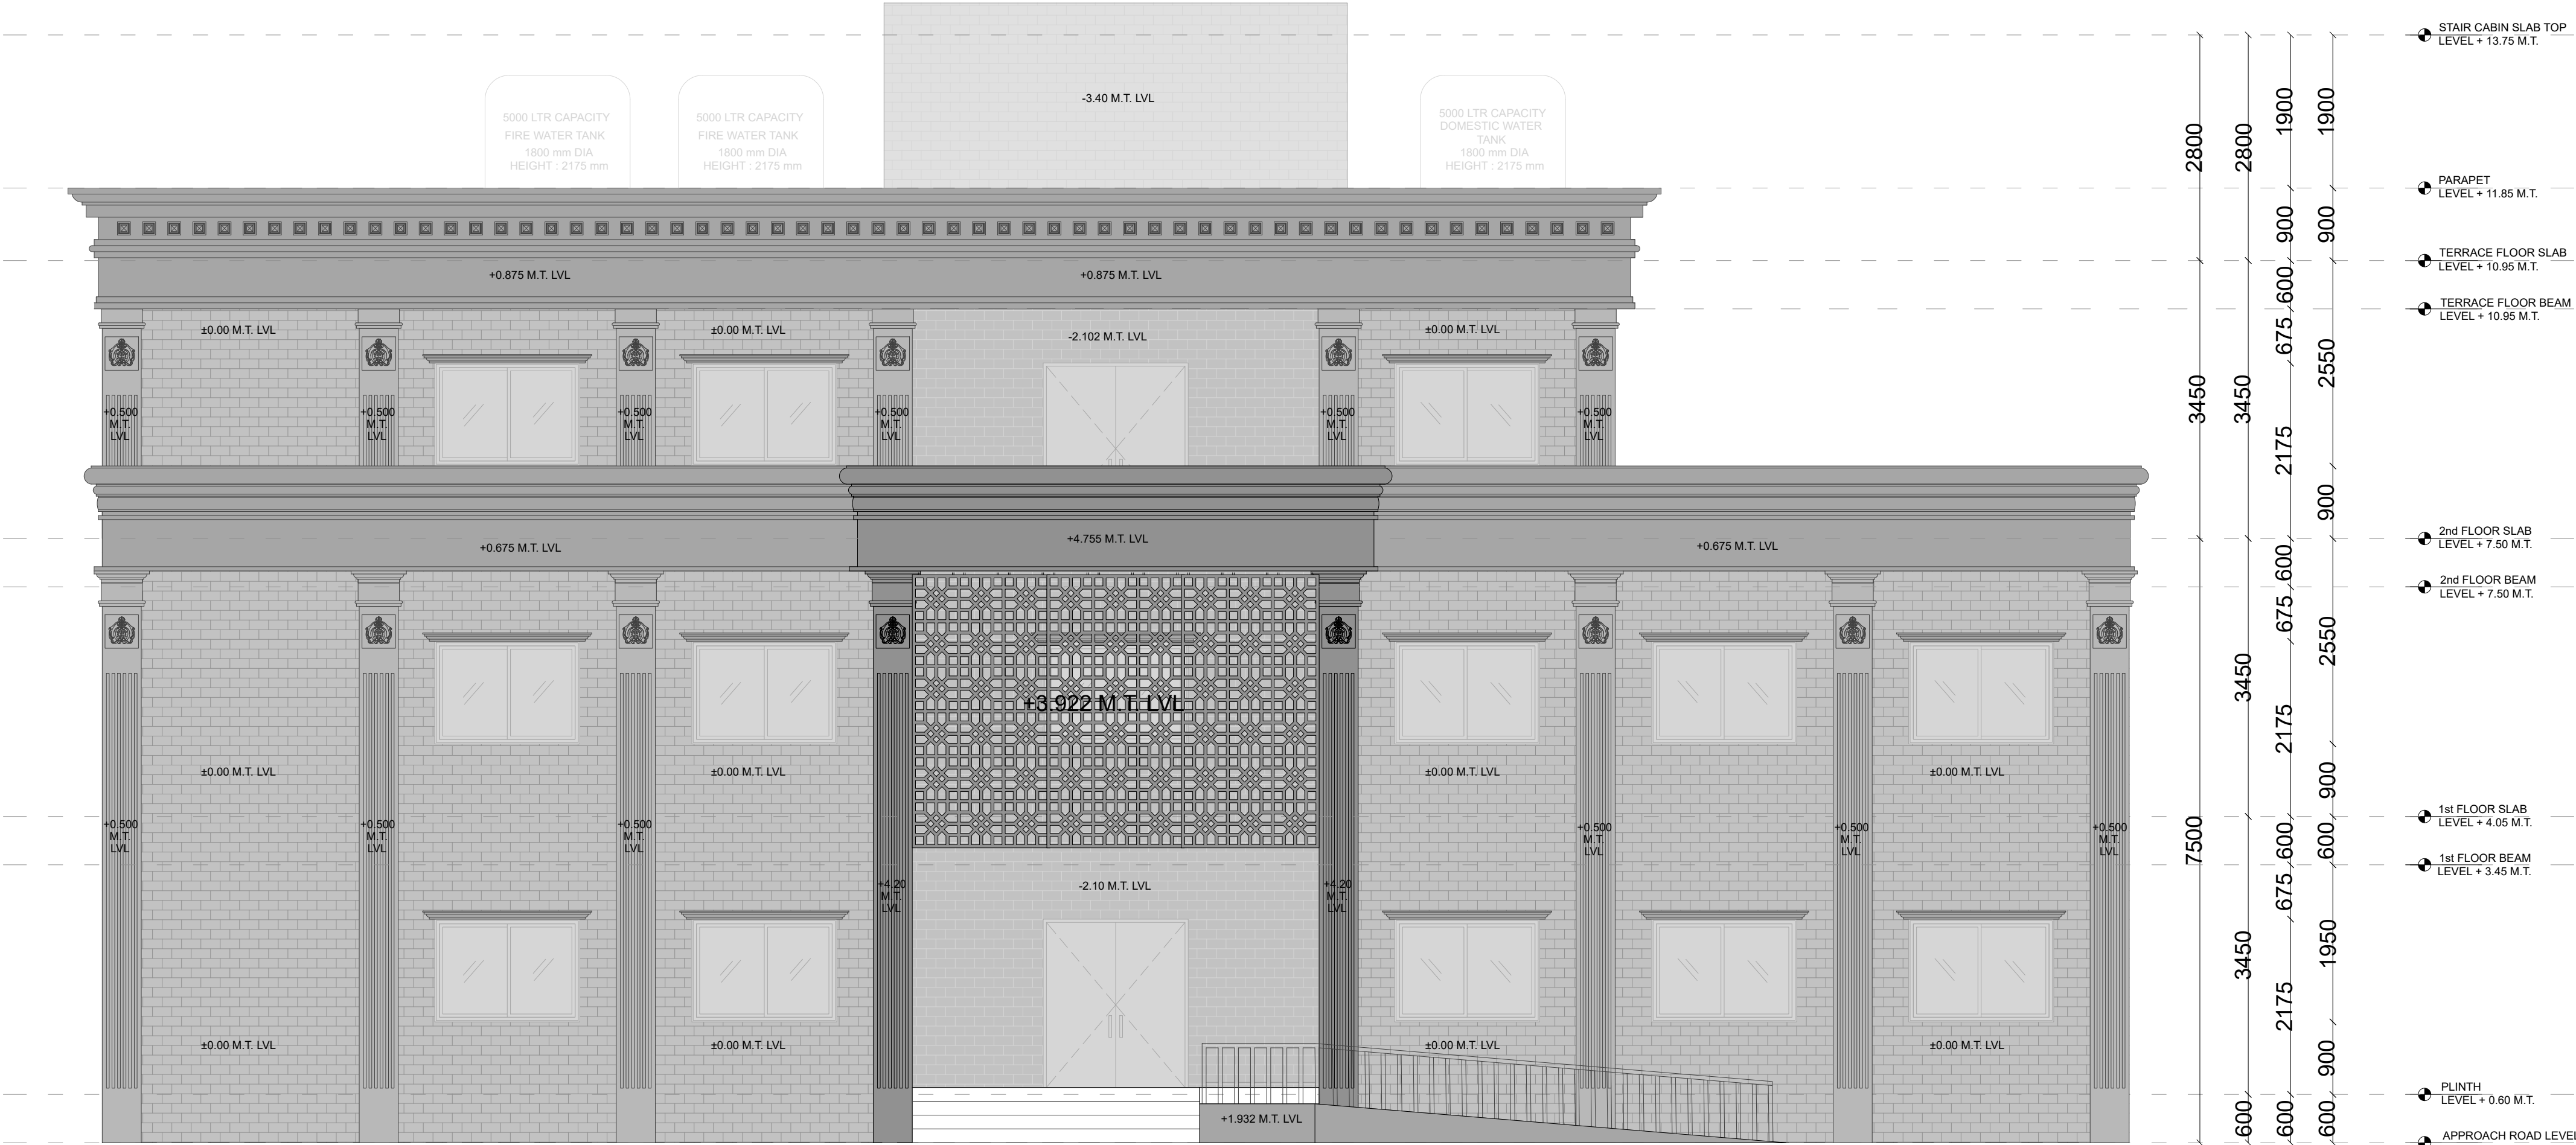

ELEVATION - A


PROJECT INFORMATION:		SITE ADDRESS :		KEY PLAN :		GENERAL NOTES:		REVISION PARTICULARS:				STRUCTURAL CON		ARCHITECTS / INTERIOR DESIGNERS:		DRAWING TITLE:		<div><div></div><div>N</div></div>										
BHUIJ ARCHEOLOGY OFFICE, AT BHUIJ.		CLIENT :  <b>SPORTS AUTHORITY OF GUJARAT</b>				1. All Dimensions Are In MM 2. Do not scale the drawings.  3. This drawing is to be read in conjunction with all other related architectural & others consultants drawings.  4. Any discrepancy found in the drawings must be brought to Architect's office prior of execution.		<div>SR.NO</div> <div>DATE</div> <div>Dm By</div> <div>Revision</div>		<div><div><b>PARAM</b></div><div>CONSULTING ENGINEERS</div><div>B/1111 UNICUS SHYAMAL</div><div>SHYAMAL CROSS ROAD, AHMEDABAD-15</div><div>MO :- 9510415231</div><div>E mail :-kedar.paramconsultant@gmail.com</div></div> <div>M.E.P CONSULTANT</div>		<div><div><b>EITHER OR</b></div><div>ARCHITECTURE</div><div>901, Matrix, Behind Divya Bhaskar,</div><div>S G Highway, Ahmedabad - Gujarat - 54.</div><div>eitheror.architecture@gmail.com, 9724694445</div></div>		ELEVATION - A														
																SCALE:			1:25		DWN BY:		HARSH SHAH		CHECKED BY:		APPROVED BY:	
																DATE :			20-05-2026		SHEET NO :		S07		REV.NO:		R0	
																PROJ REF:			ARC & CIVIL		DRAWING NO:		A - 107					

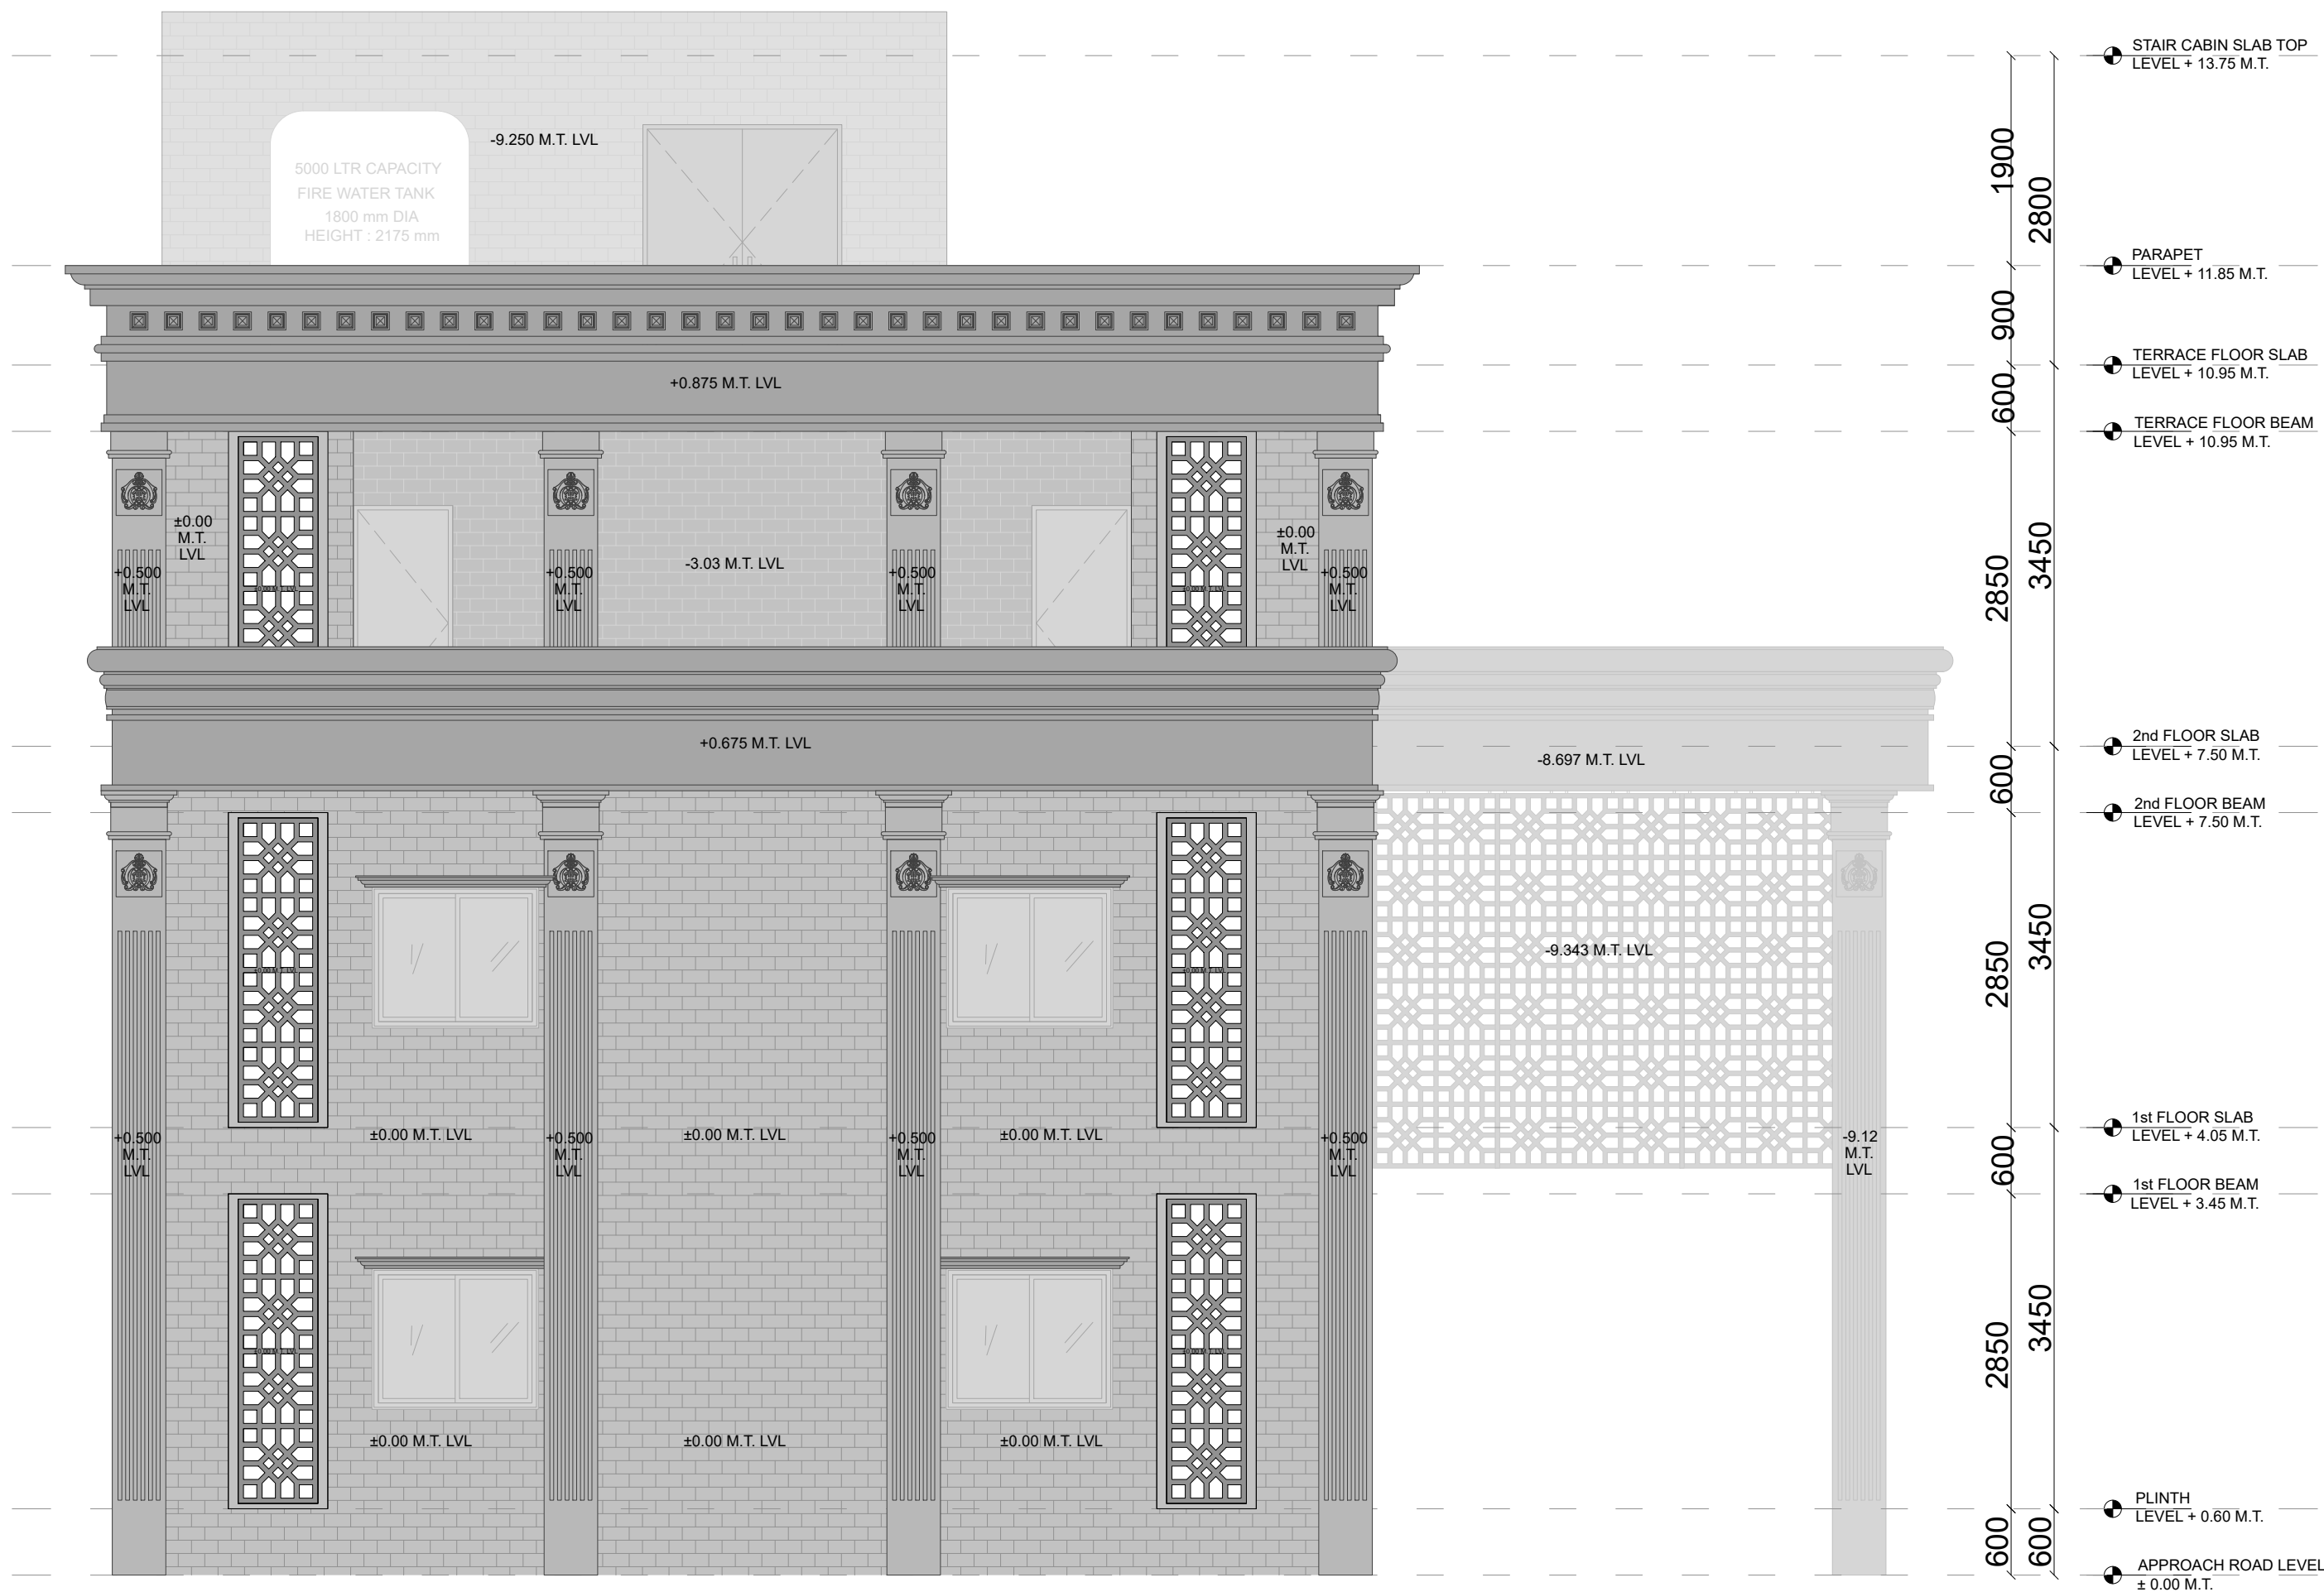

ELEVATION - B

PROJECT INFORMATION:		SITE ADDRESS :		KEY PLAN :		GENERAL NOTES:		REVISION PARTICULARS:				STRUCTURAL CON		ARCHITECTS / INTERIOR DESIGNERS:		DRAWING TITLE:		<div><div></div><div>1N</div></div>	
BHUIJ ARCHEOLOGY OFFICE, AT BHUIJ.		CLIENT :  <b>SPORTS AUTHORITY OF GUJARAT</b>				1. All Dimensions Are In MM 2. Do not scale the drawings.  3. This drawing is to be read in conjunction with all other related architectural & others consultants drawings.  4. Any discrepancy found in the drawings must be brought to Architect's office prior of execution.		<div>SR.NO</div> <div>DATE</div> <div>Dwn By</div> <div>Revision</div>		<div>PARAM</div> <div>CONSULTING ENGINEERS</div> <div>B/1111 UNICUS SHYAMAL</div> <div>SHYAMAL CROSS ROAD, AHMEDABAD-15</div> <div>MO :- 9510415231</div> <div>E mail :-kedar.paramconsultant@gmail.com</div>		<div><div></div><div>EITHER OR</div><div>ARCHITECTURE</div></div> <div>901, Matrix, Behind Divya Bhaskar, S G Highway, Ahmedabad - Gujarat - 54.</div> <div>eitheror.architecture@gmail.com, 9724694445</div>		ELEVATION - B					
										M.E.P CONSULTANT									
												SCALE: 1:25		DWN BY:		CHECKED BY:		APPROVED BY:	
														DATE : 20-05-2026		HARSH SHAH			
														SHEET NO : S08		DRAWING NO:		A - 108	
														REV.NO: R0					
																PROJ REF: ARC & CIVIL			


 
 


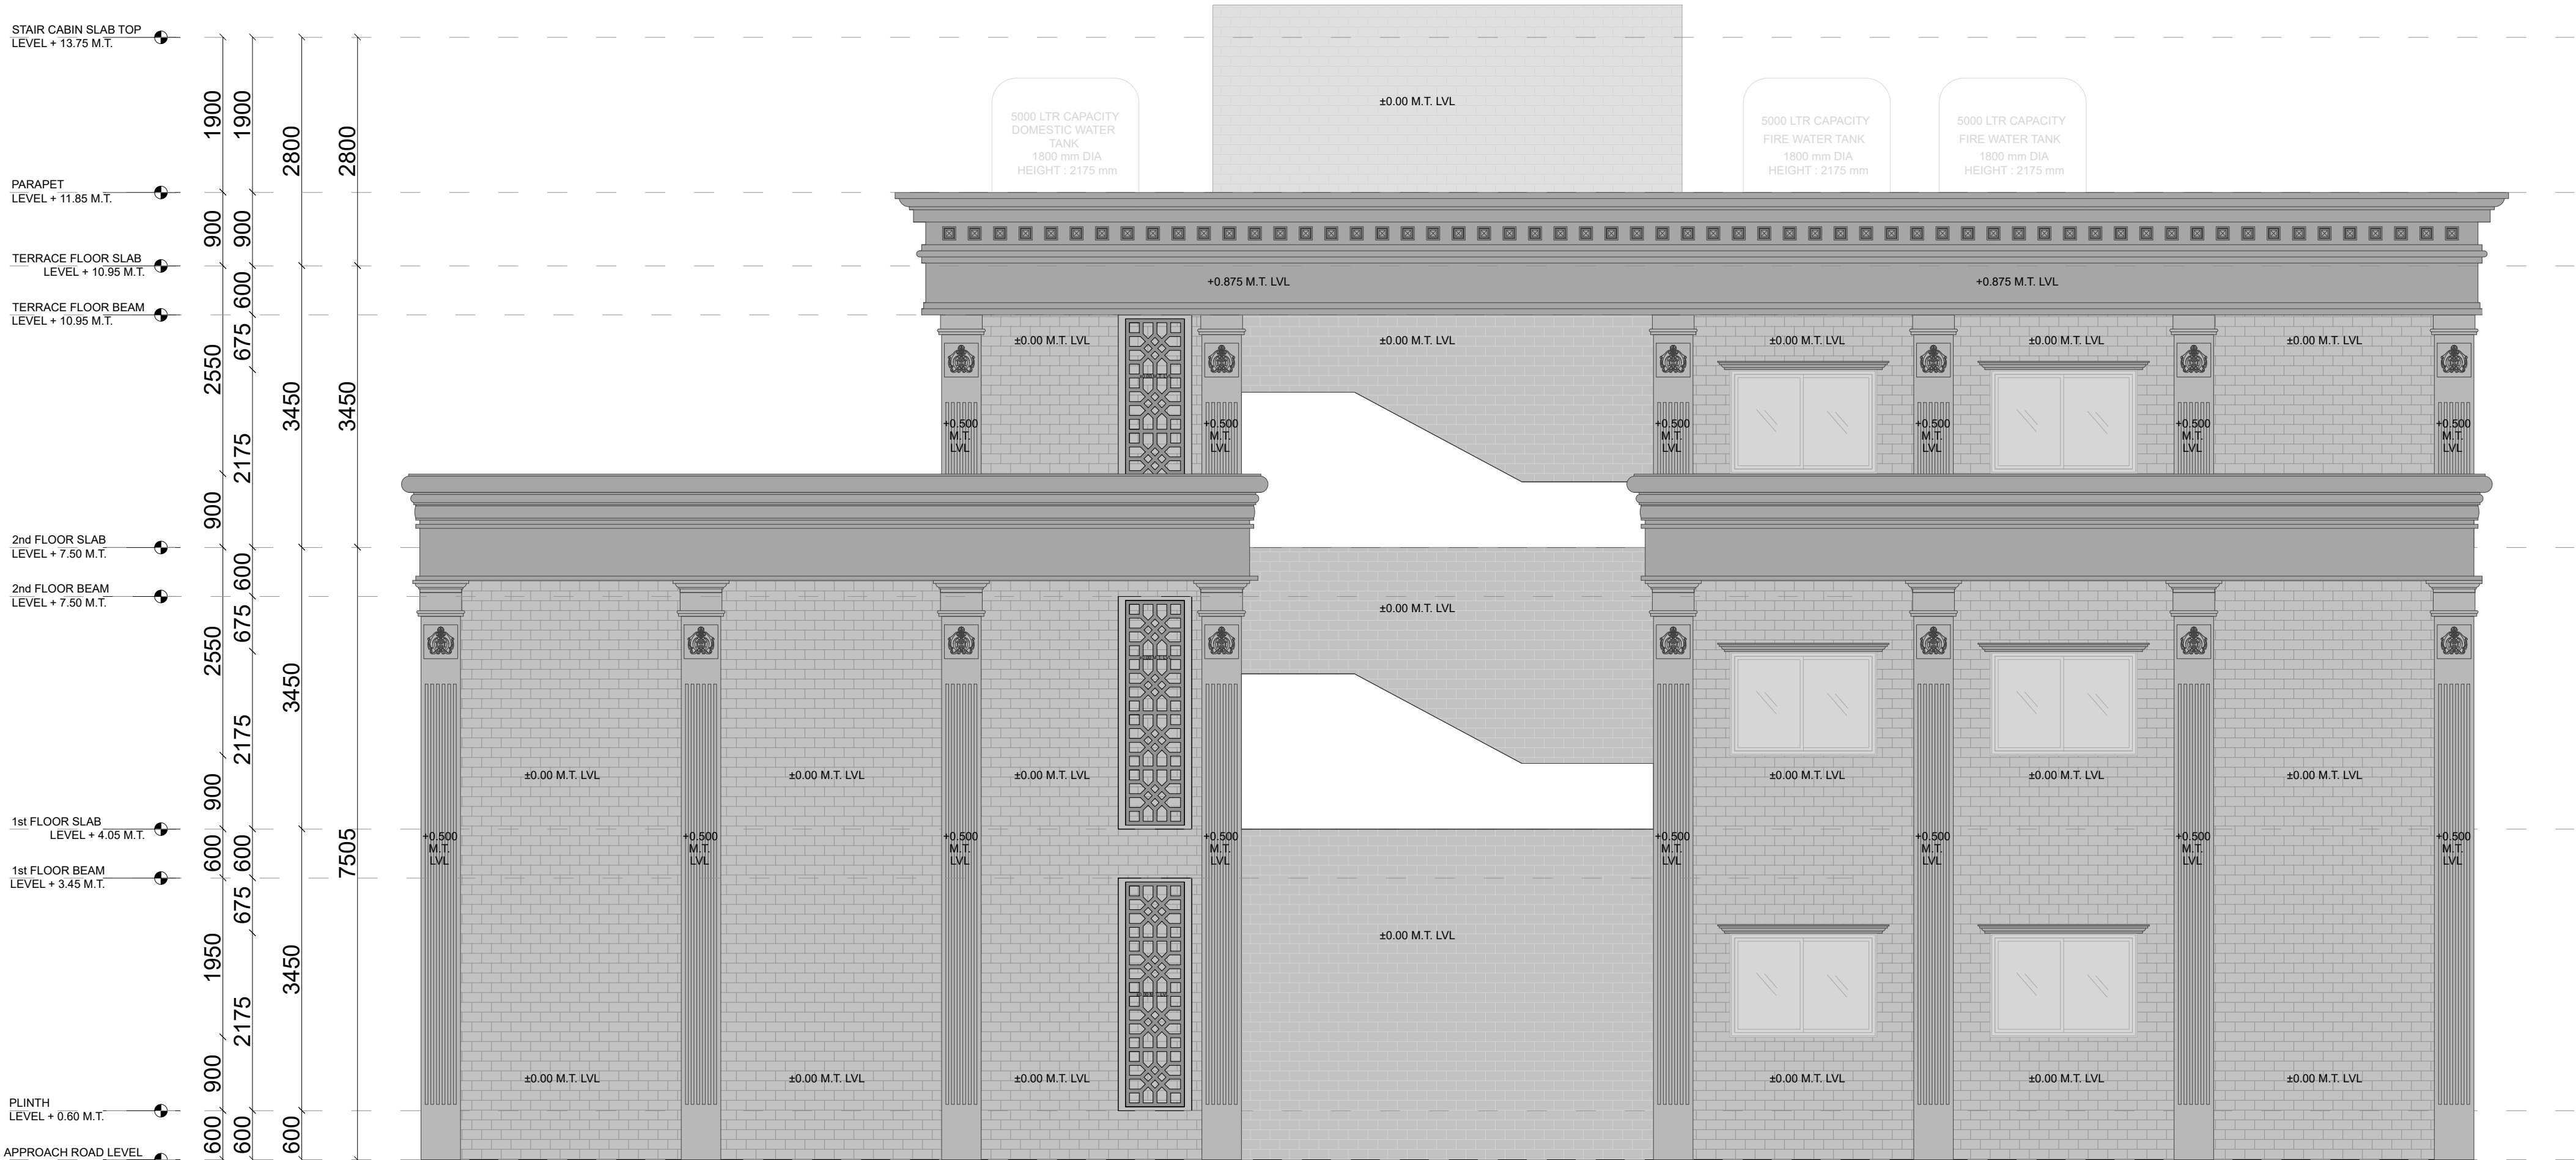



ELEVATION - C


PROJECT INFORMATION:		SITE ADDRESS :		KEY PLAN :		GENERAL NOTES:		REVISION PARTICULARS:				STRUCTURAL CON		ARCHITECTS / INTERIOR DESIGNERS:		DRAWING TITLE:		<div><div></div><div>N</div></div>										
BHUJ ARCHEOLOGY OFFICE, AT BHUJ.		CLIENT :  SPORTS AUTHORITY OF GUJARAT				1. All Dimensions Are In MM 2. Do not scale the drawings.  3. This drawing is to be read in conjunction with all other related architectural & others consultants drawings.  4. Any discrepancy found in the drawings must be brought to Architect's office prior of execution.		SR.NO		DATE		Dm By		Revision		<div><div><div>PARAM</div><div>CONSULTING ENGINEERS B/1111 UNICUS SHYAMAL SHYAMAL CROSS ROAD, AHMEDABAD-15 MO :- 9510415231 E mail :- kedar.paramconsultant@gmail.com</div></div><div>M.E.P CONSULTANT</div></div>			<div><div><div></div><div>EITHER OR</div><div>ARCHITECTURE</div></div><div>901, Matrix, Behind Divya Bhaskar, S G Highway, Ahmedabad - Gujarat - 54. eitheror.architecture@gmail.com, 9724694445</div></div>		ELEVATION - C							
																SCALE:					1:25		DWN BY:		CHECKED BY:		APPROVED BY:	
																DATE :					20-05-2026		HARSH SHAH					
																SHEET NO					09		DRAWING NO:					
REV.NO:		R0														A - 109												
PROJ REF:		ARC & CIVIL																										



PROJECT INFORMATION:	SITE ADDRESS :	KEY PLAN :	GENERAL NOTES:	REVISION PARTICULARS:				STRUCTURAL CON	ARCHITECTS / INTERIOR DESIGNERS:	DRAWING TITLE:		
BHUJ ARCHEOLOGY OFFICE, AT BHUJ.	CLIENT :		1. All Dimensions Are In MM 2. Do not scale the drawings.  3. This drawing is to be read in conjunction with all other related architectural & others consultants drawings.  4. Any discrepancy found in the drawings must be brought to Architect's office prior of execution.	SR.NO	DATE	Drn By	Revision	 CONSULTING ENGINEERS B/1111 UNICUS SHYAMAL SHYAMAL CROSS ROAD, AHMEDABAD-15 MO :- 9610415231 E mail :- shvdr.paramconsultant@gmail.com	 <b>EITHER OR ARCHITECTURE</b>  901, Matrix, Behind Divya Bhaskar, S G Highway, Ahmedabad - Gujarat - 54. eitheror.architecture@gmail.com, 9724694445	ELEVATION - D		
	<b>SPORTS AUTHORITY OF GUJARAT</b>							SCALE: 1:25		DWN BY: HARSH SHAH	CHECKED BY:	
	DATE : 20-05-2026	DRAWING NO:										
	SHEET NO : S10											
	REV.NO: R0											
	PROJ REF: ARC & CIVIL											




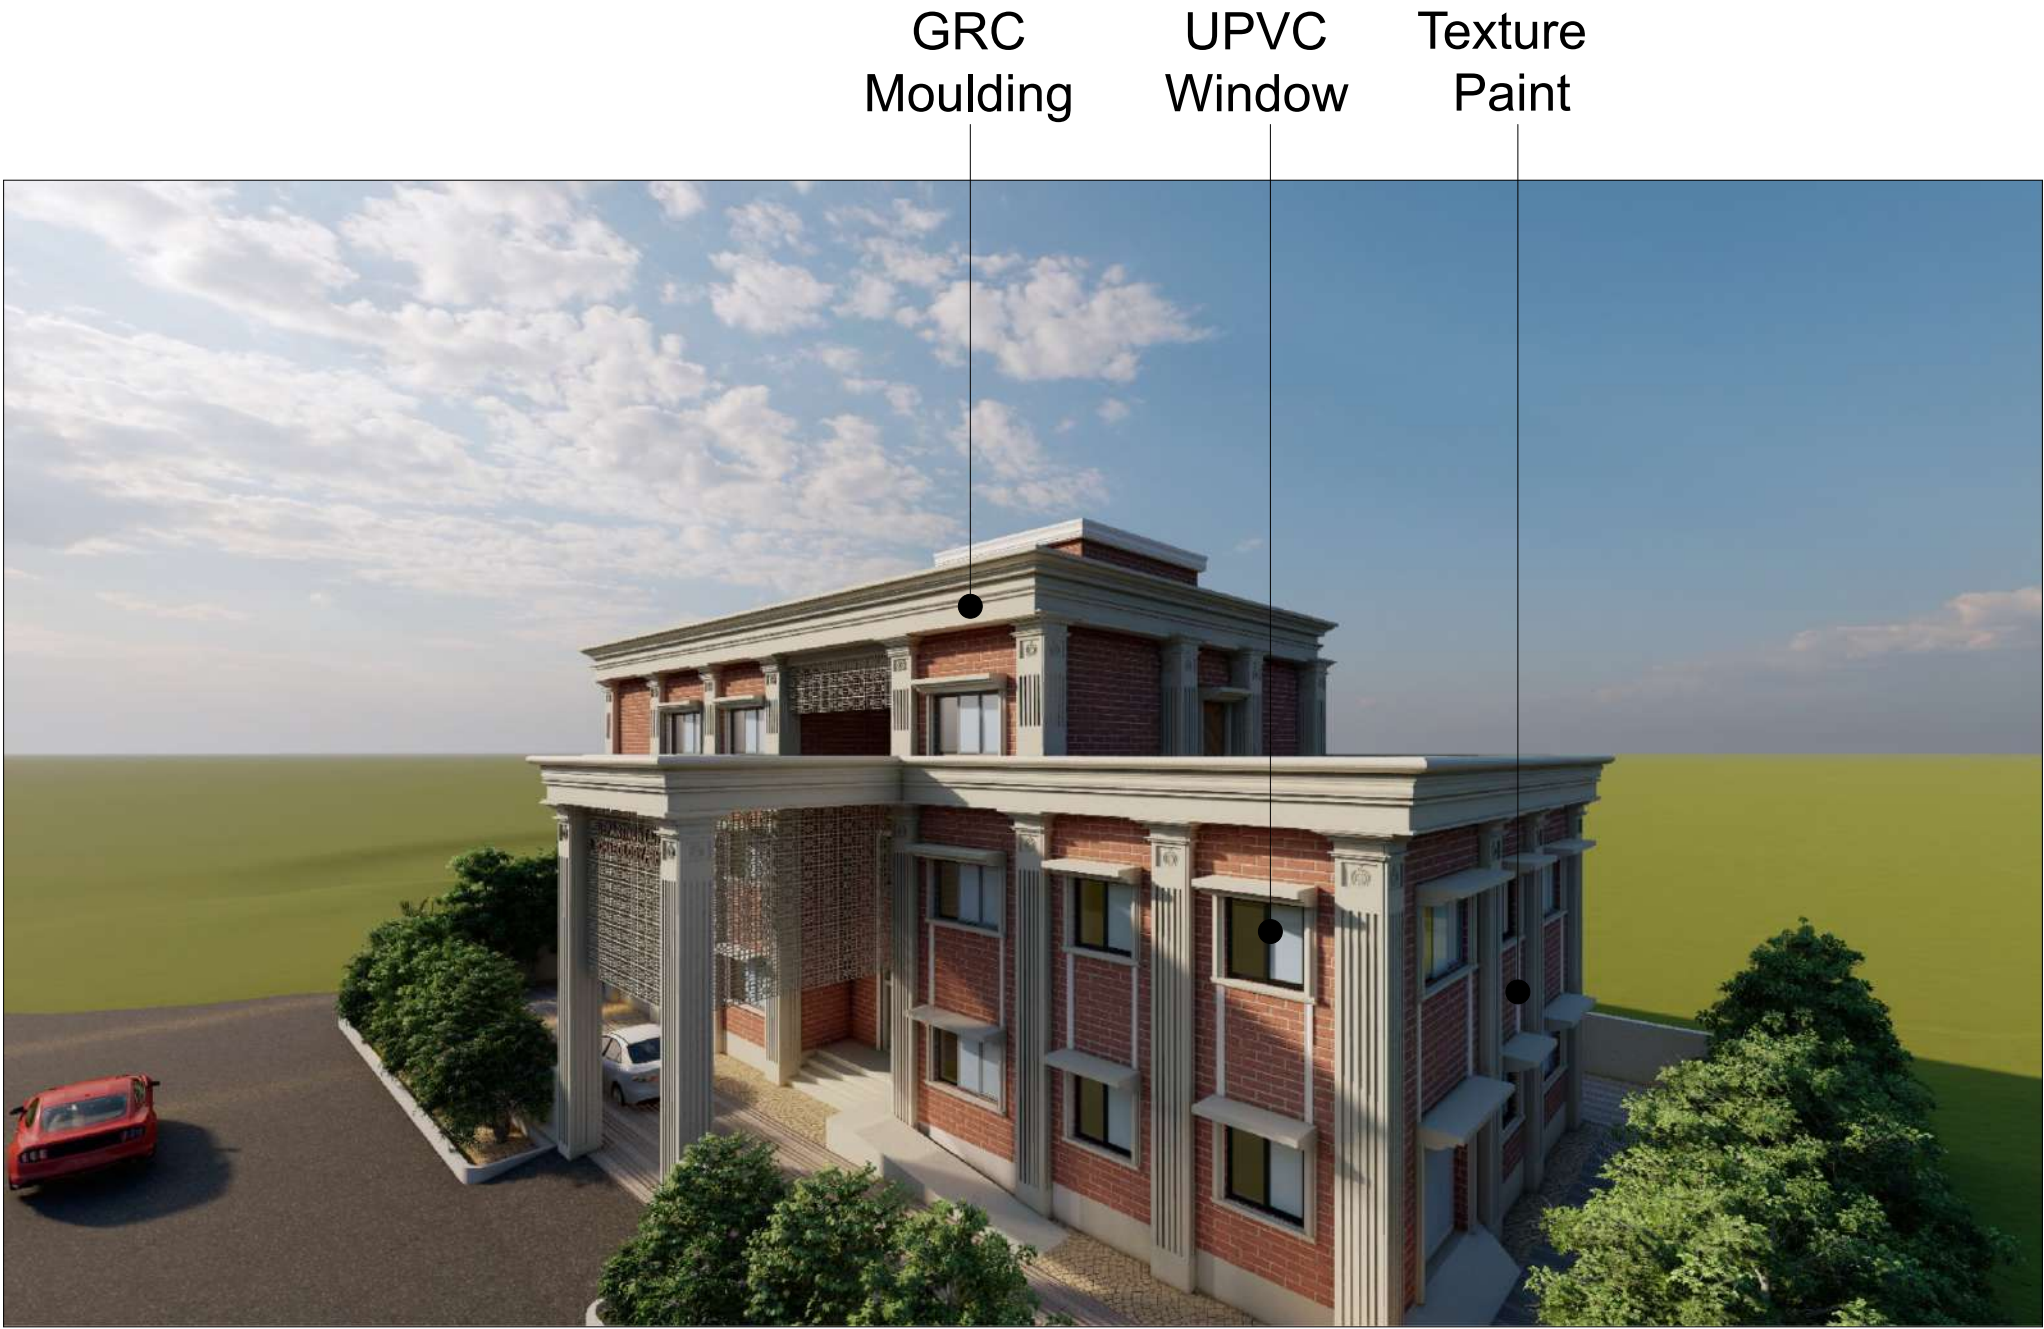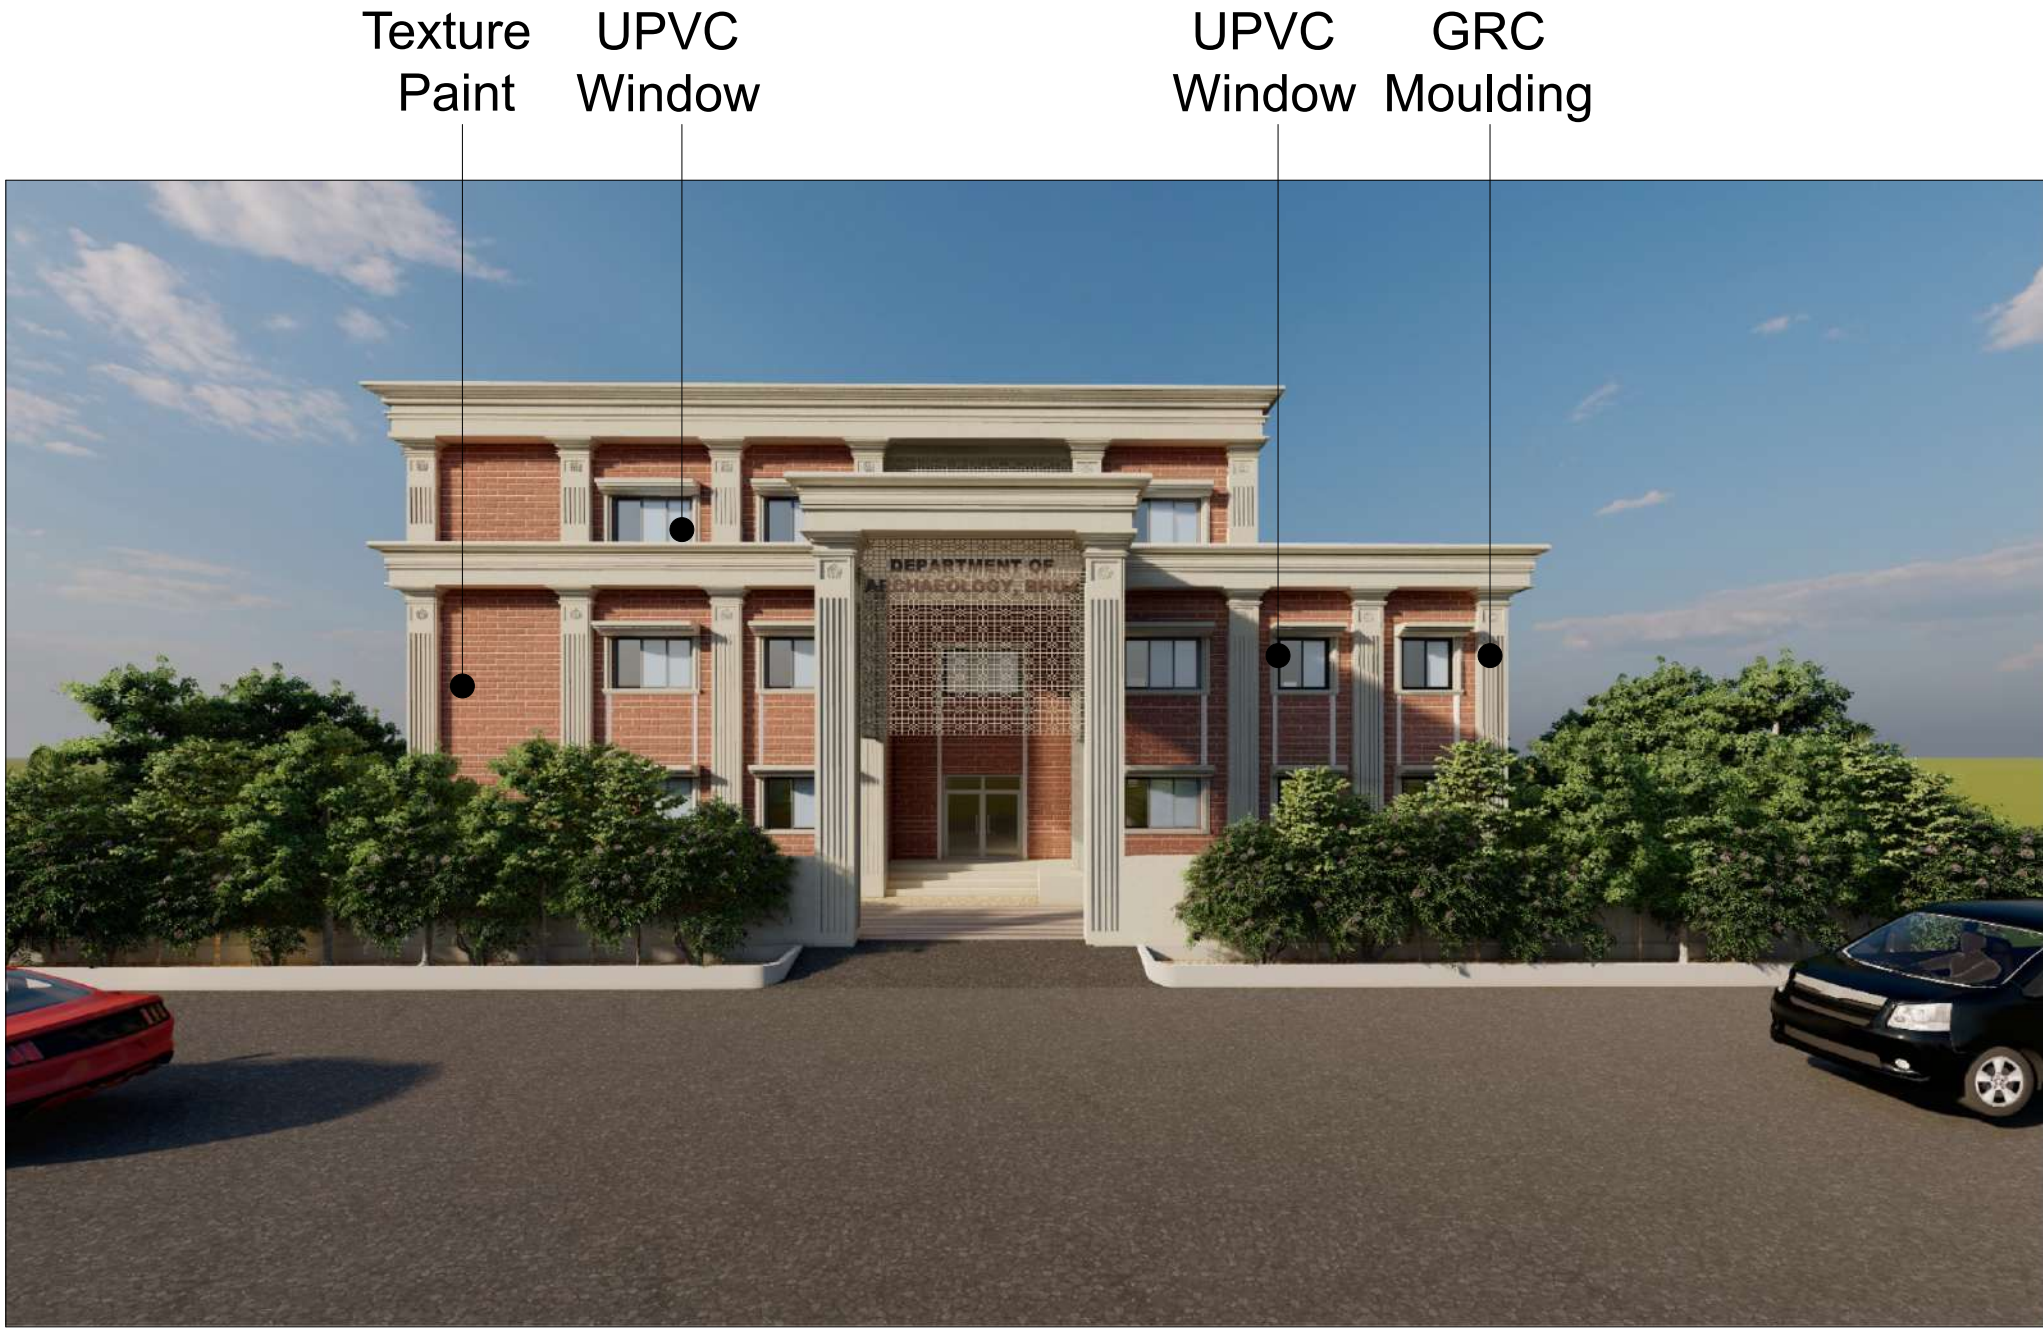

PROJECT INFORMATION:		SITE ADDRESS :		KEY PLAN :		GENERAL NOTES:		REVISION PARTICULARS:				STRUCTURAL CON		ARCHITECTS / INTERIOR DESIGNERS:		DRAWING TITLE:			
ARCHOLOGY		CLIENT :  <b>SPORTS AUTHORITY OF GUJARAT</b>				1. All Dimensions Are In MM 2. Do not scale the drawings.  3. This drawing is to be read in conjunction with all other related architectural & others consultants drawings.  4. Any discrepancy found in the drawings must be brought to Architect's office prior of execution.						PARAM CONSULTING ENGINEERS B/1111 UNICUS SHYAMAL SHYAMAL CROSS ROAD, AHMEDABAD-15 MO :- 9510415231 E mail :-kedar.paramconsultant@gmail.com		<div></div> <b>EITHER OR</b> ARCHITECTURE  901, Matrix, Behind Divya Bhaskar, S G Highway, Ahmedabad - Gujarat - 54. eitheror.architecture@gmail.com, 9724694445		PROPOSED 3D VIEWS			
												M.E.P CONSULTANT							
SR.NO		DATE		Dm By		Revision													



LEGENDS	
	FULL AAC BLOCK WALL
	HALF AAC BLOCK WALL
	RCC
	LOW HEIGHTED WALL
LEGENDS	
	(A) GRANITE ONE SIDE POLISHED
	(B) ANTI SKIT VITRIFIED TILE
	(C) CHINA MOSAIC

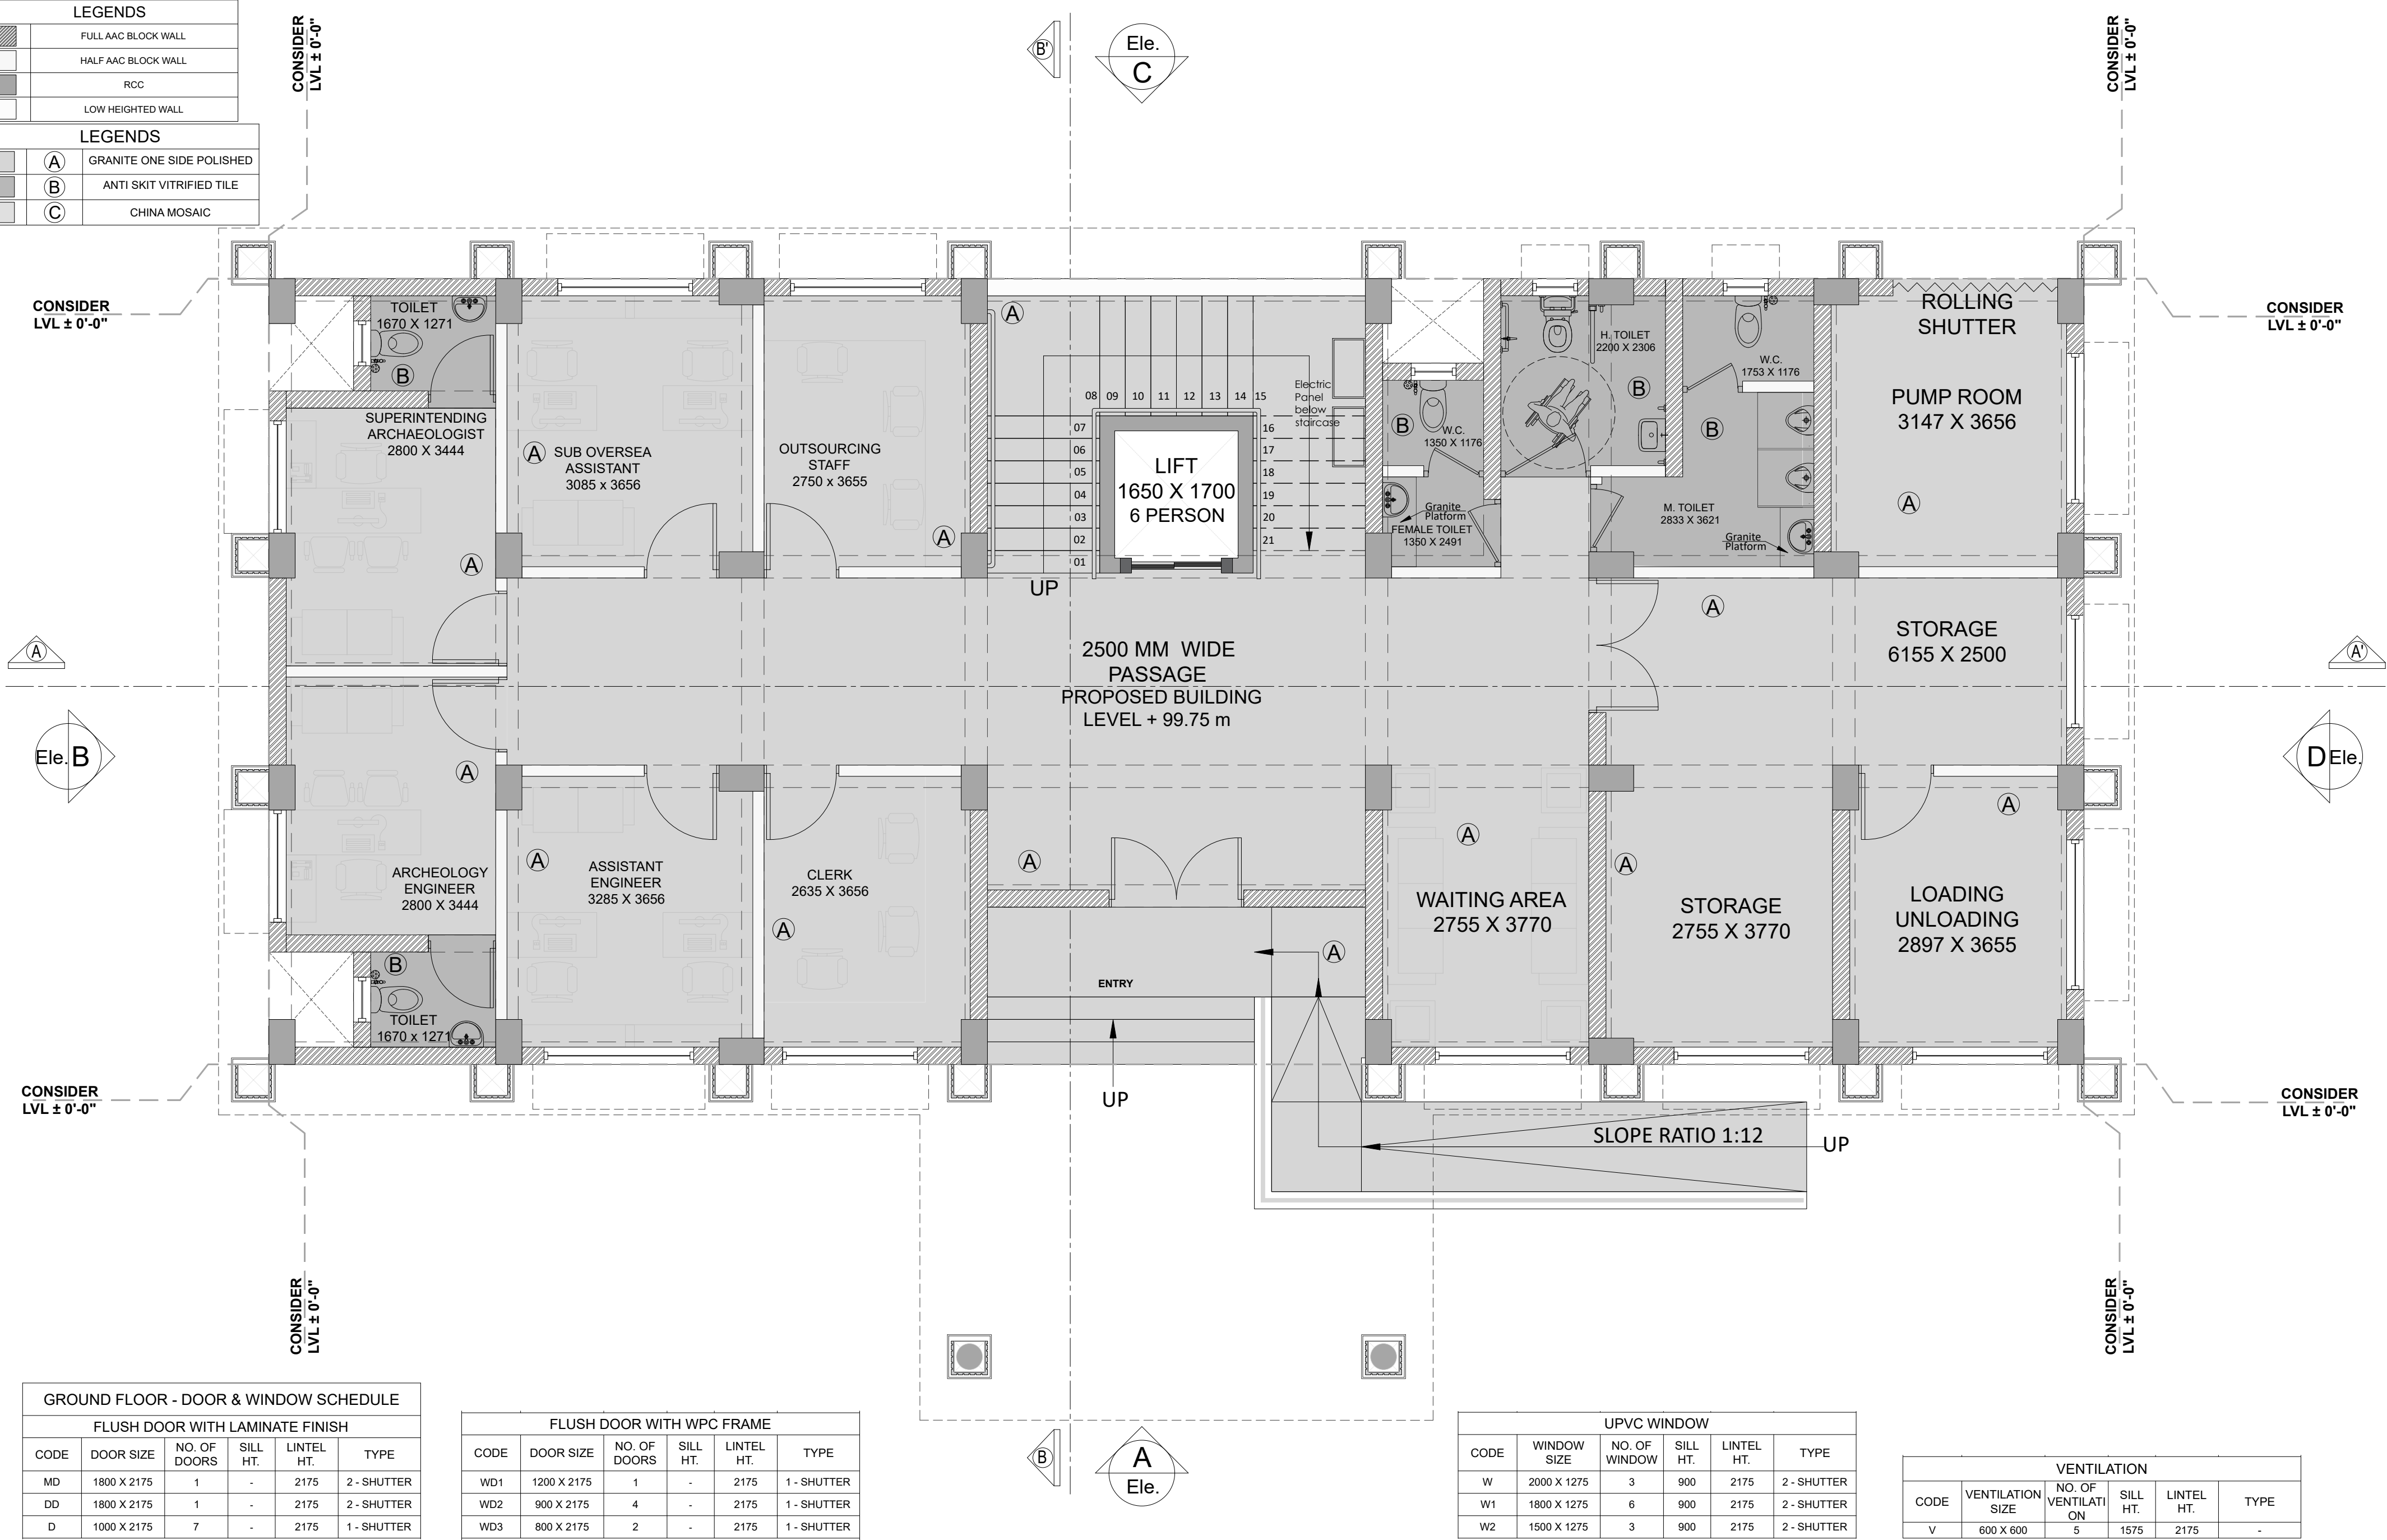




GROUND FLOOR - DOOR & WINDOW SCHEDULE					
FLUSH DOOR WITH LAMINATE FINISH					
CODE	DOOR SIZE	NO. OF DOORS	SILL HT.	LINTEL HT.	TYPE
MD	1800 X 2175	1	-	2175	2 - SHUTTER
DD	1800 X 2175	1	-	2175	2 - SHUTTER
D	1000 X 2175	7	-	2175	1 - SHUTTER

FLUSH DOOR WITH WPC FRAME					
CODE	DOOR SIZE	NO. OF DOORS	SILL HT.	LINTEL HT.	TYPE
WD1	1200 X 2175	1	-	2175	1 - SHUTTER
WD2	900 X 2175	4	-	2175	1 - SHUTTER
WD3	800 X 2175	2	-	2175	1 - SHUTTER


UPVC WINDOW					
CODE	WINDOW SIZE	NO. OF WINDOW	SILL HT.	LINTEL HT.	TYPE
W	2000 X 1275	3	900	2175	2 - SHUTTER
W1	1800 X 1275	6	900	2175	2 - SHUTTER
W2	1500 X 1275	3	900	2175	2 - SHUTTER

VENTILATION					
CODE	VENTILATION SIZE	NO. OF VENTILATION	SILL HT.	LINTEL HT.	TYPE
V	600 X 600	5	1575	2175	-

PROJECT INFORMATION:		SITE ADDRESS :		KEY PLAN :		GENERAL NOTES:		REVISION PARTICULARS:				STRUCTURAL CON		ARCHITECTS / INTERIOR DESIGNERS:		DRAWING TITLE:		
BHUIJ ARCHEOLOGY OFFICE, AT BHUIJ.		CLIENT :  <b>SPORTS AUTHORITY OF GUJARAT</b>				1. All Dimensions Are In MM 2. Do not scale the drawings.  3. This drawing is to be read in conjunction with all other related architectural & others consultants drawings.  4. Any discrepancy found in the drawings must be brought to Architect's office prior of execution.		<div> CONSULTING ENGINEERS B/1111 UNICUS SHYAMAL SHYAMAL CROSS ROAD, AHMEDABAD-15 MO :- 9510415231 E mail :-kedar.paramconsultant@gmail.com</div> <div>M.E.P CONSULTANT</div>		<div> 901, Matrix, Behind Divya Bhaskar, S G Highway, Ahmedabad - Gujarat - 54. eitheror.architecture@gmail.com, 9724694445</div>		GROUND FLOOR FLOORING PLAN						
SR.NO		DATE		Dm By		Revision								SCALE: 1:25		A - 201		
														DATE : 20-05-2026				
														SHEET NO : S12				
														REV.NO: R0				
														PROJ REF: ARC & CIVIL				



LEGENDS	
	FULL AAC BLOCK WALL
	HALF AAC BLOCK WALL
	RCC
	LOW HEIGHTED WALL
LEGENDS	
	(A) GRANITE ONE SIDE POLISHED
	(B) ANTI SKIT VITRIFIED TILE
	(C) CHINA MOSAIC

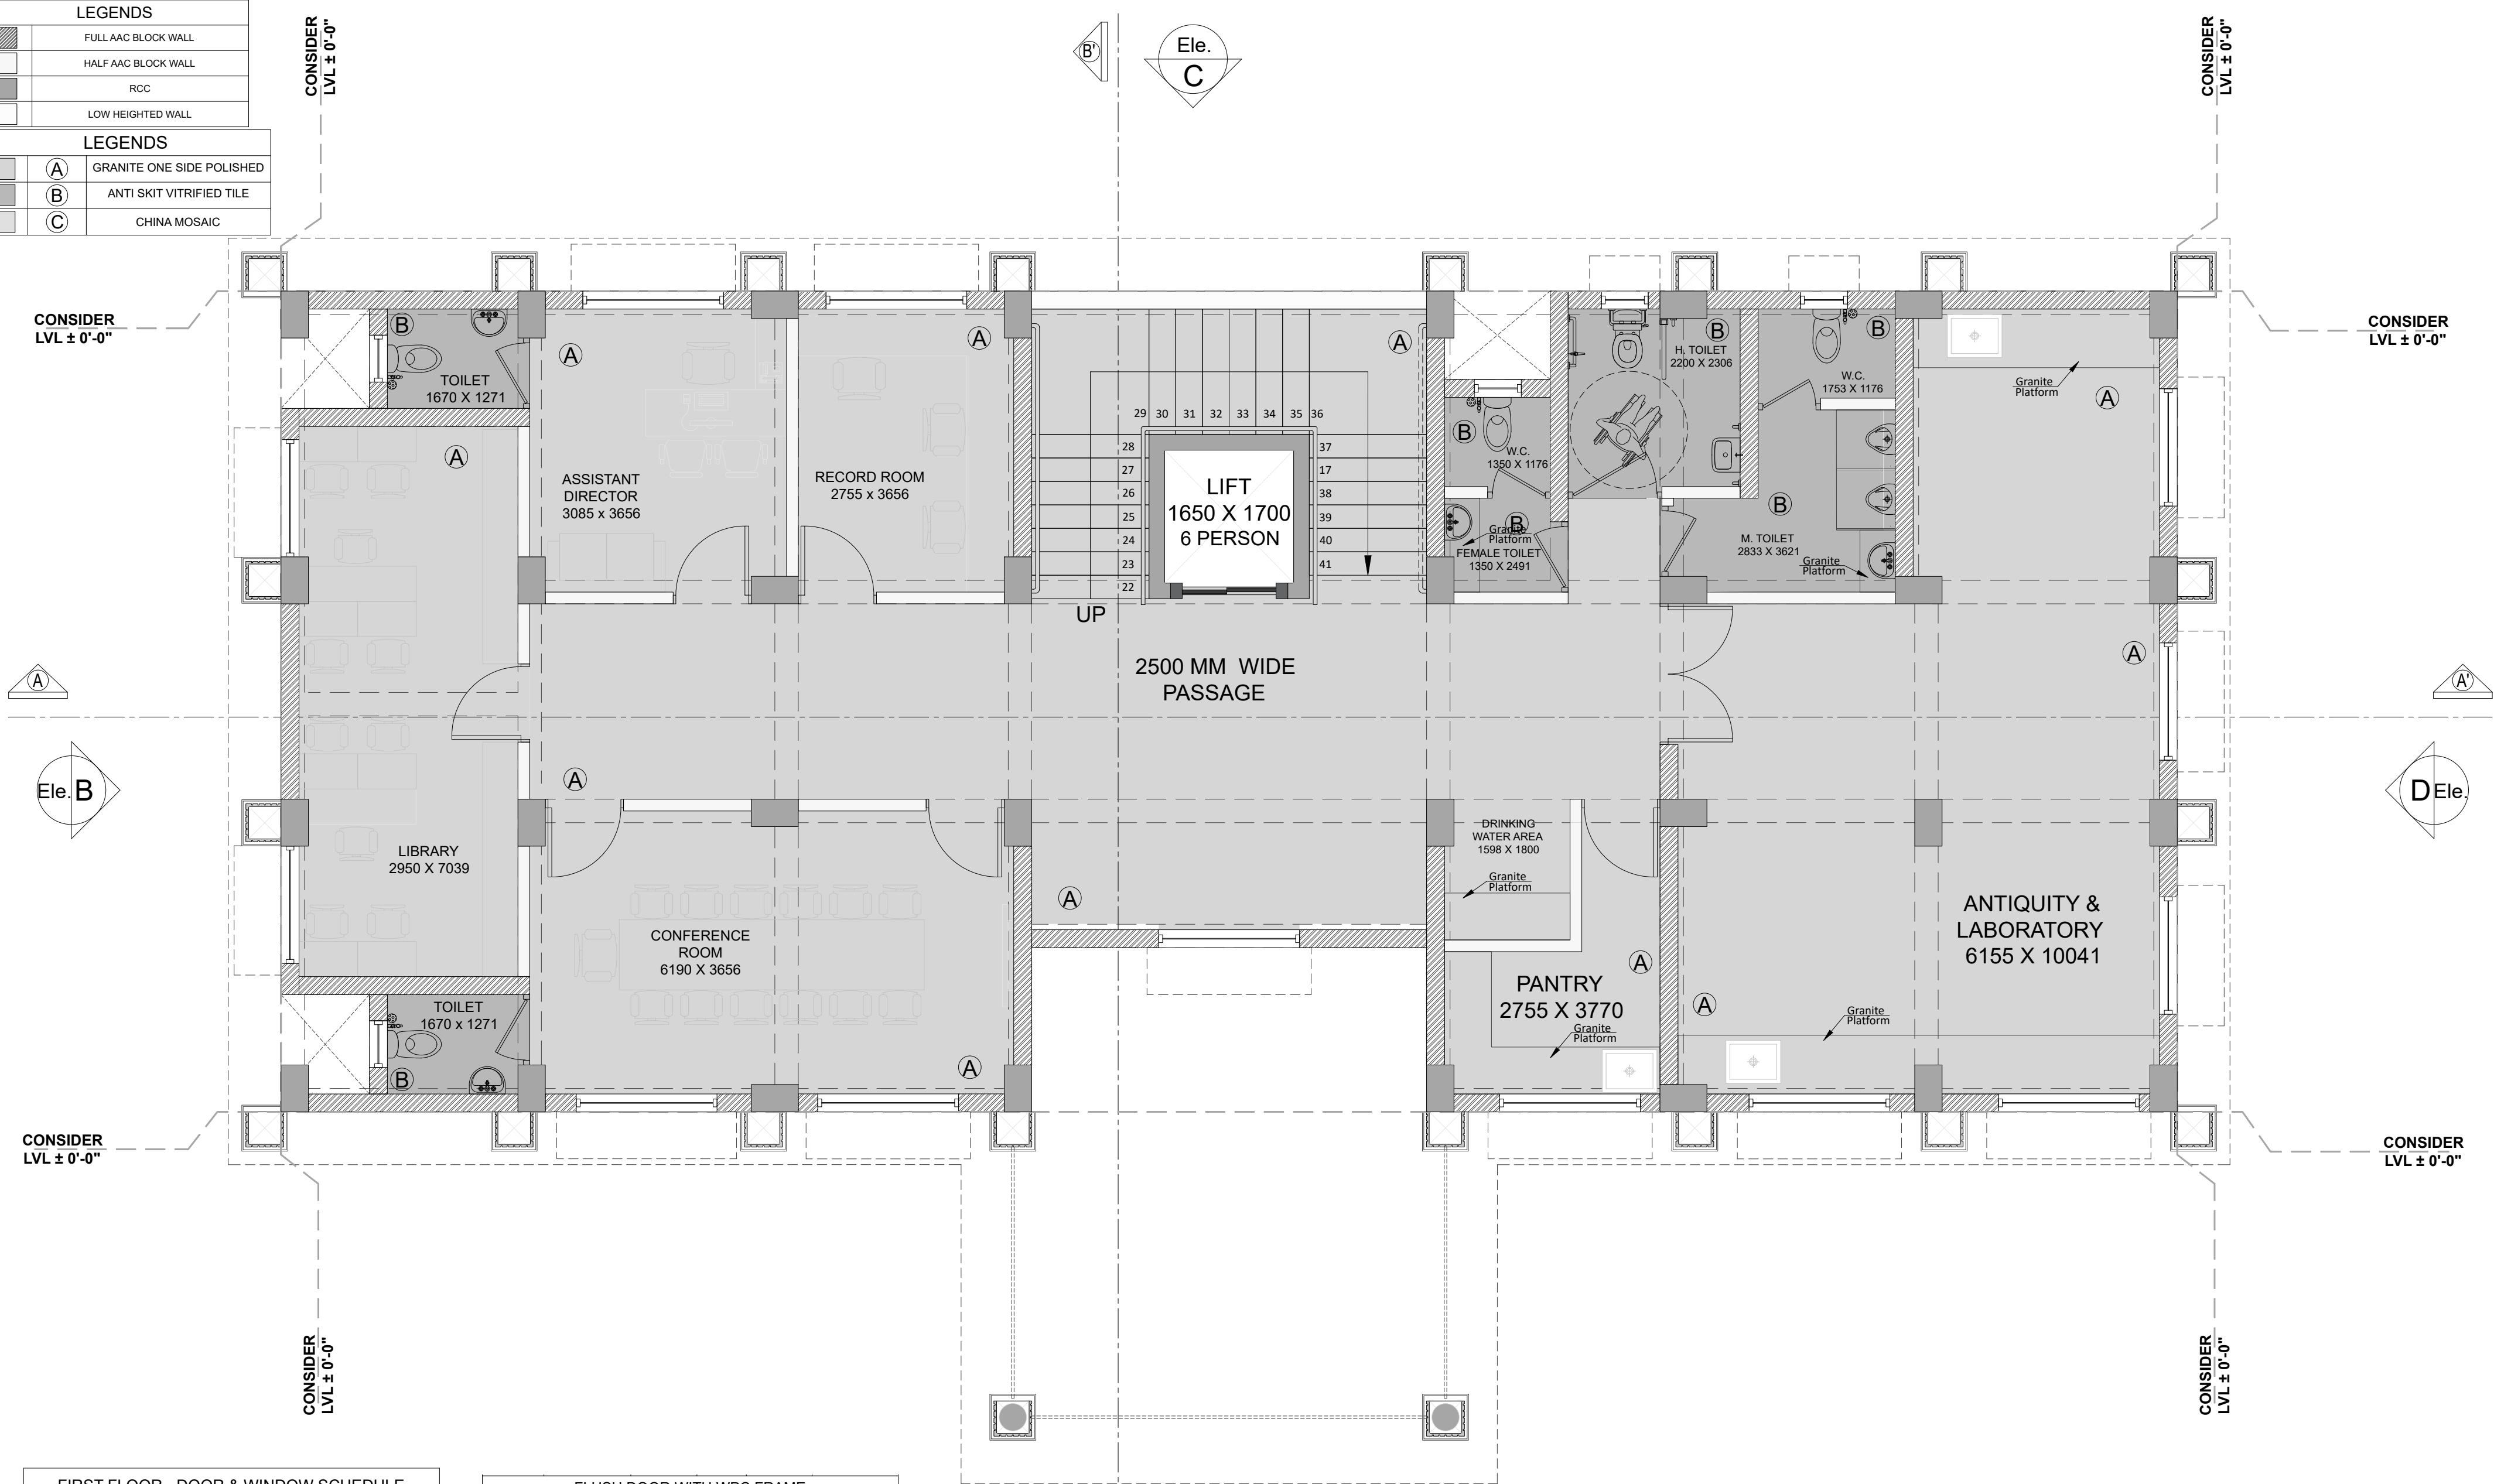

FIRST FLOOR - DOOR & WINDOW SCHEDULE					
FLUSH DOOR WITH LAMINATE FINISH					
CODE	DOOR SIZE	NO. OF DOORS	SILL HT.	LINTEL HT.	TYPE
DD	1800 X 2175	1	-	2175	2 - SHUTTER
D	1000 X 2175	6	-	2175	1 - SHUTTER

FLUSH DOOR WITH WPC FRAME					
CODE	DOOR SIZE	NO. OF DOORS	SILL HT.	LINTEL HT.	TYPE
WD1	1200 X 2175	1	-	2175	1 - SHUTTER
WD2	900 X 2175	4	-	2175	1 - SHUTTER
WD3	800 X 2175	2	-	2175	1 - SHUTTER

UPVC WINDOW					
CODE	WINDOW SIZE	NO. OF WINDOW	SILL HT.	LINTEL HT.	TYPE
W1	1800 X 1275	8	900	2175	2 - SHUTTER
W2	1500 X 1275	5	900	2175	2 - SHUTTER

VENTILATION					
CODE	VENTILATION SIZE	NO. OF VENTILATION	SILL HT.	LINTEL HT.	TYPE
V	600 X 600	5	1575	2175	-

PROJECT INFORMATION:		SITE ADDRESS :		KEY PLAN :		GENERAL NOTES:		REVISION PARTICULARS:				STRUCTURAL CON		ARCHITECTS / INTERIOR DESIGNERS:		DRAWING TITLE:				<div></div>	
BHUJ ARCHEOLOGY OFFICE, AT BHUJ.		CLIENT :  <b>SPORTS AUTHORITY OF GUJARAT</b>				1. All Dimensions Are In MM 2. Do not scale the drawings. 3. This drawing is to be read in conjunction with all other related architectural & others consultants drawings. 4. Any discrepancy found in the drawings must be brought to Architect's office prior of execution.						<div><div>PARAM</div><div>CONSULTING ENGINEERS B/1111 UNICUS SHYAMAL SHYAMAL CROSS ROAD, AHMEDABAD-15 MO :- 9510415231 E mail :- kedar.paramconsultant@gmail.com</div><div>M.E.P CONSULTANT</div></div>		<div><div>EITHER OR</div><div>ARCHITECTURE</div><div>901, Matrix, Behind Divya Bhaskar, S G Highway, Ahmedabad - Gujarat - 54. eitheror.architecture@gmail.com, 9724694445</div></div>		FIRST FLOOR FLOORING PLAN					
SR.NO		DATE		Dm By		Revision								SCALE: 1:25		DWN BY: HARSH SHAH		CHECKED BY:		APPROVED BY:	
														DATE : 20-05-2026		SHEET NO: S13		REV.NO: R0		DRAWING NO: A - 202	
														PROJ REF: ARC & CIVIL							

FULL AAC BLOCK WALL

HALF AAC BLOCK WALL

RCC

LOW HEIGHTED WALL

A


GRANITE ONE SIDE POLISHED

B

ANTI SKIT VITRIFIED TILE

C

CHINA MOSAIC

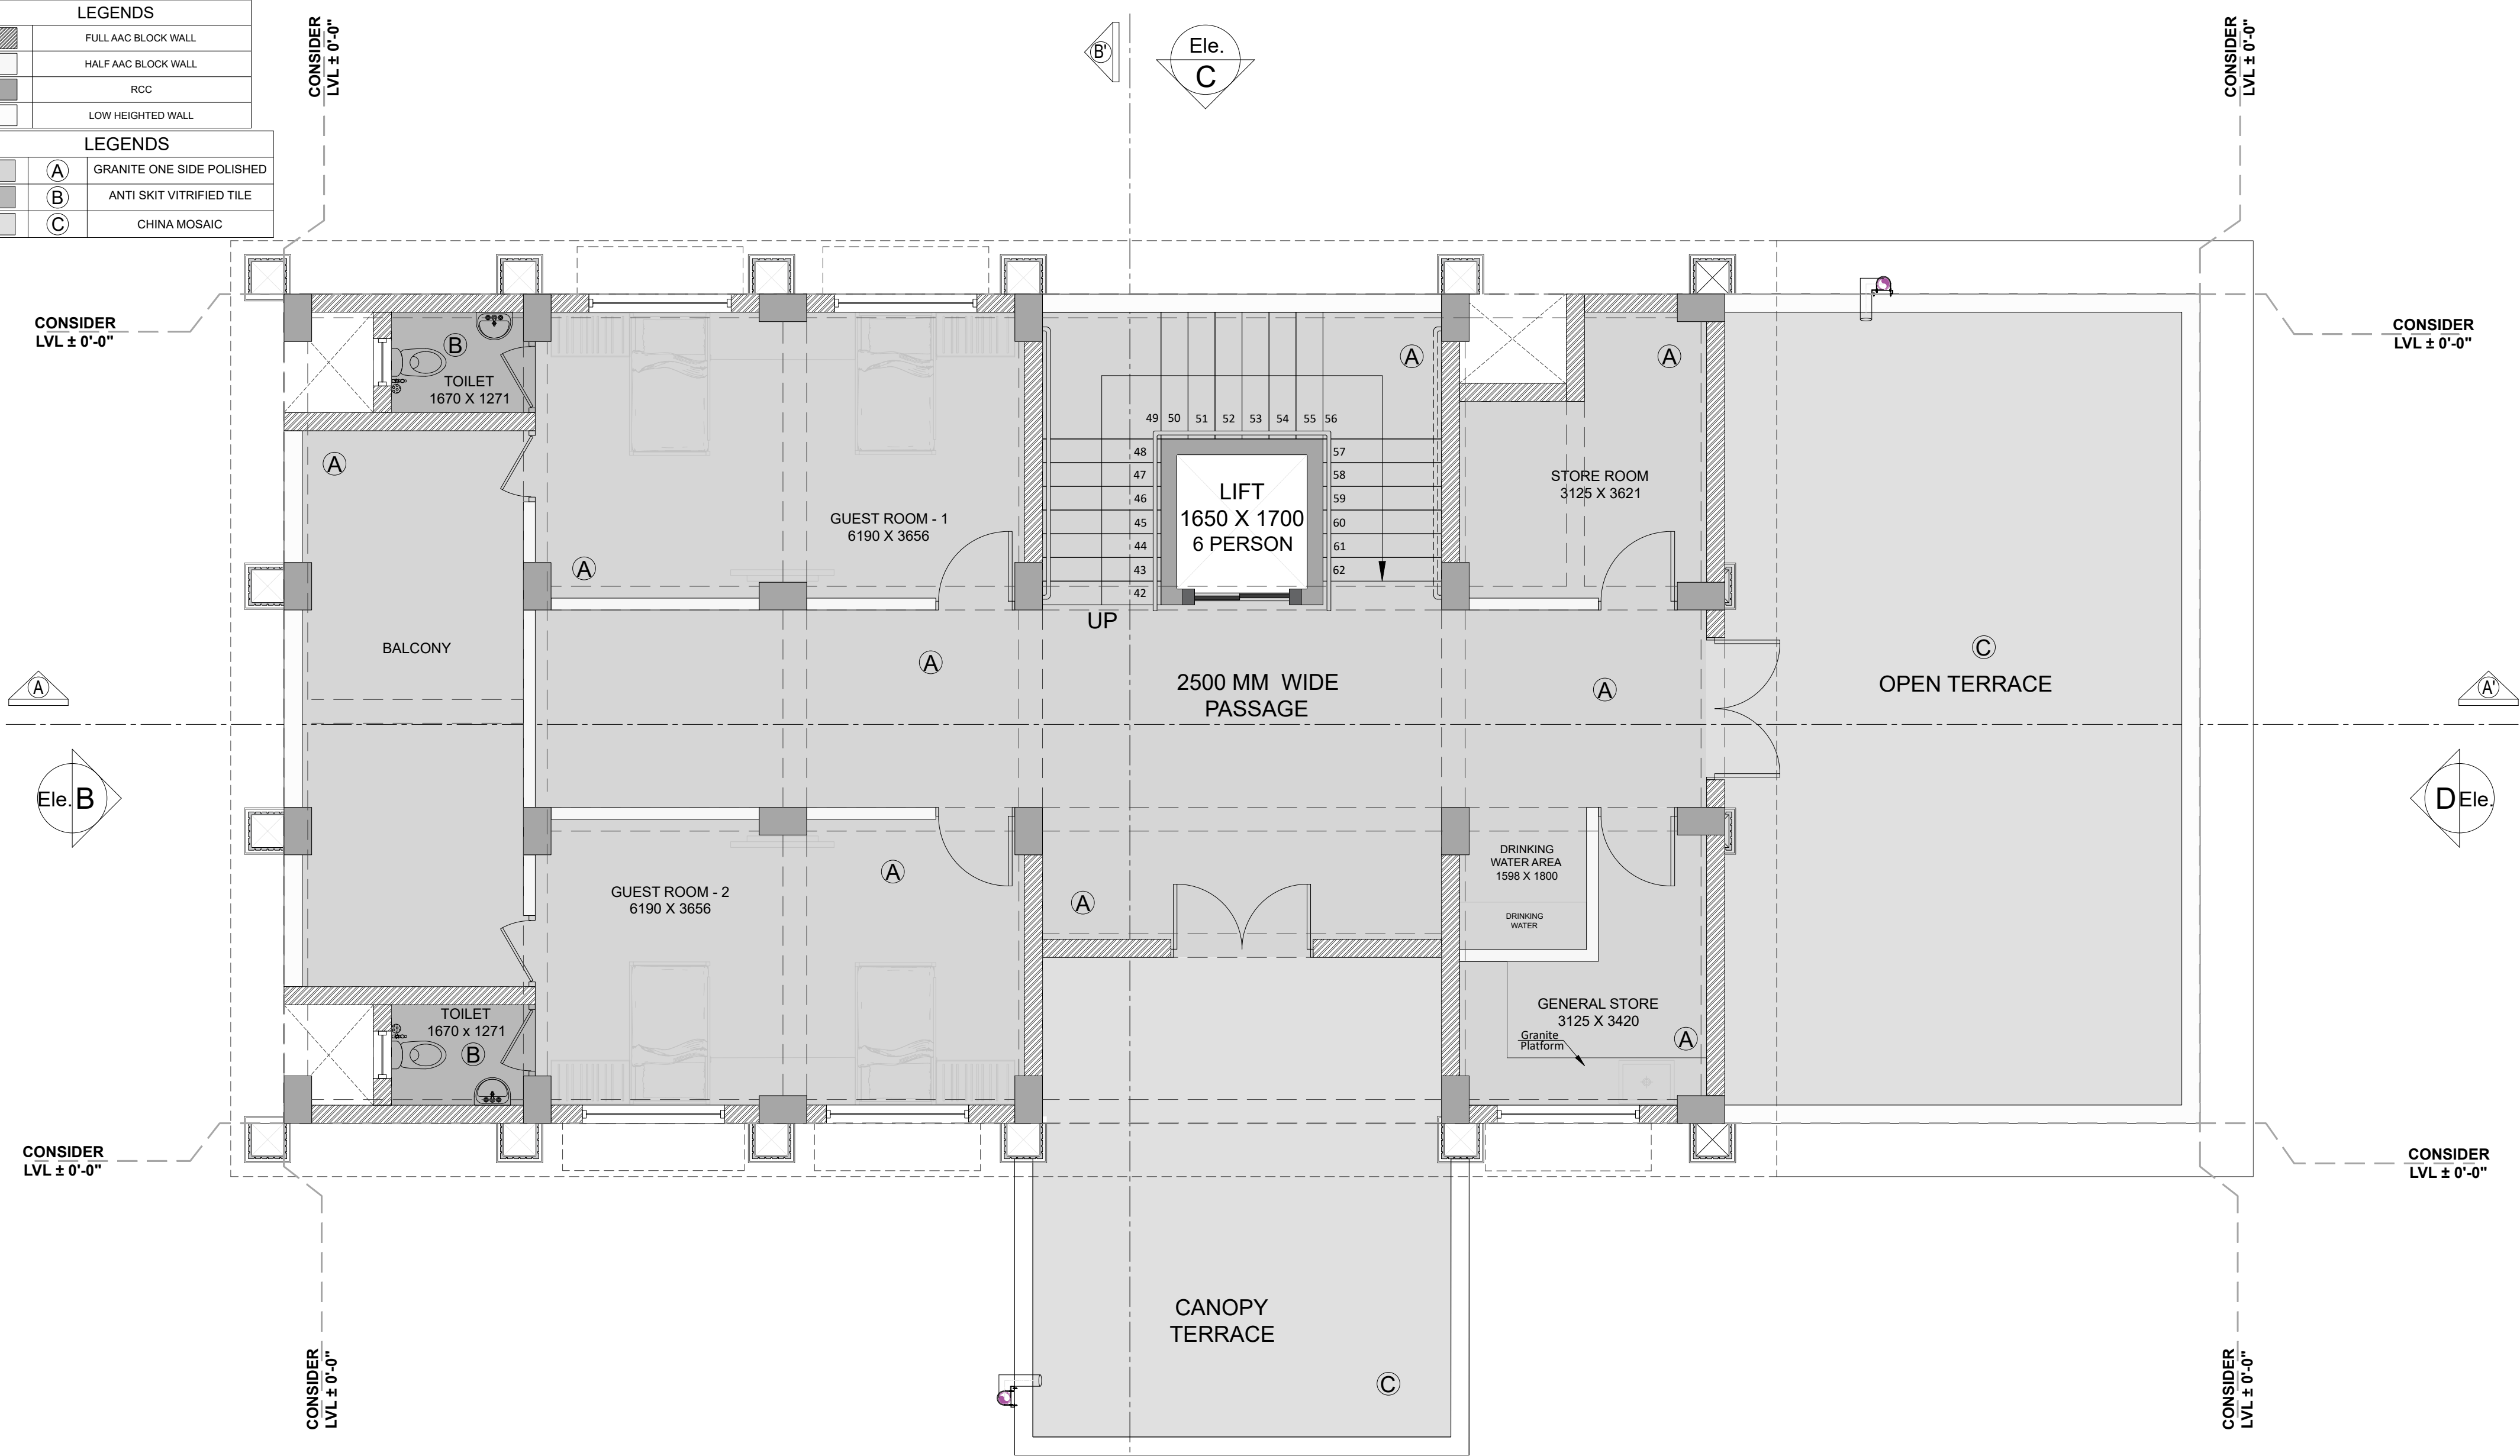

SECOND FLOOR - DOOR & WINDOW SCHEDULE					
FLUSH DOOR WITH LAMINATE FINISH					
CODE	DOOR SIZE	NO. OF DOORS	SILL HT.	LINTEL HT.	TYPE
DD	1800 X 2175	2	-	2175	2 - SHUTTER
D	1000 X 2175	4	-	2175	1 - SHUTTER
D1	900 X 2175	2	-	2175	1 - SHUTTER

FLUSH DOOR WITH WPC FRAME					
CODE	DOOR SIZE	NO. OF DOORS	SILL HT.	LINTEL HT.	TYPE
WD2	900 X 2175	2	-	2175	1 - SHUTTER

UPVC WINDOW					
CODE	WINDOW SIZE	NO. OF WINDOW	SILL HT.	LINTEL HT.	TYPE
W1	1800 X 1275	5	900	2175	2 - SHUTTER

VENTILATION					
CODE	VENTILATION SIZE	NO. OF VENTILATION	SILL HT.	LINTEL HT.	TYPE
V	600 X 600	2	1575	2175	-

PROJECT INFORMATION:

BHUJ ARCHEOLOGY OFFICE, AT BHUJ.

SITE ADDRESS :

CLIENT :  
SPORTS AUTHORITY OF GUJARAT

KEY PLAN :

GENERAL NOTES:

1. All Dimensions Are In MM  
2. Do not scale the drawings.  
3. This drawing is to be read in conjunction with all other related architectural & others consultants drawings.  
4. Any discrepancy found in the drawings must be brought to Architect's office prior of execution.

REVISION PARTICULARS:

SR.NO	DATE	Dwn By	Revision

STRUCTURAL CON

PARAM

CONSULTING ENGINEERS  
B/1111 UNICUS SHYAMAL  
SHYAMAL CROSS ROAD, AHMEDABAD-15  
MO :- 9510415231  
E mail :- kedar.paramconsultant@gmail.com

M.E.P CONSULTANT

ARCHITECTS / INTERIOR DESIGNERS:

EITHER OR ARCHITECTURE

901, Matrix, Behind Divya Bhaskar,  
S G Highway, Ahmedabad - Gujarat - 54.  
eitheror.architecture@gmail.com, 9724694445

DRAWING TITLE:

SECOND FLOOR FLOORING PLAN

SCALE:	1:25	DWN BY:	CHECKED BY:	APPROVED BY:
DATE :	20-05-2026	HARSH SHAH		
SHEET NO:	14	DRAWING NO:		
REV.NO:	R0			
PROJ REF:	ARC & CIVIL			

A - 203



FULL AAC BLOCK WALL

HALF AAC BLOCK WALL

RCC

LOW HEIGHTED WALL

A


GRANITE ONE SIDE POLISHED

B

ANTI SKIT VITRIFIED TILE


C

CHINA MOSAIC

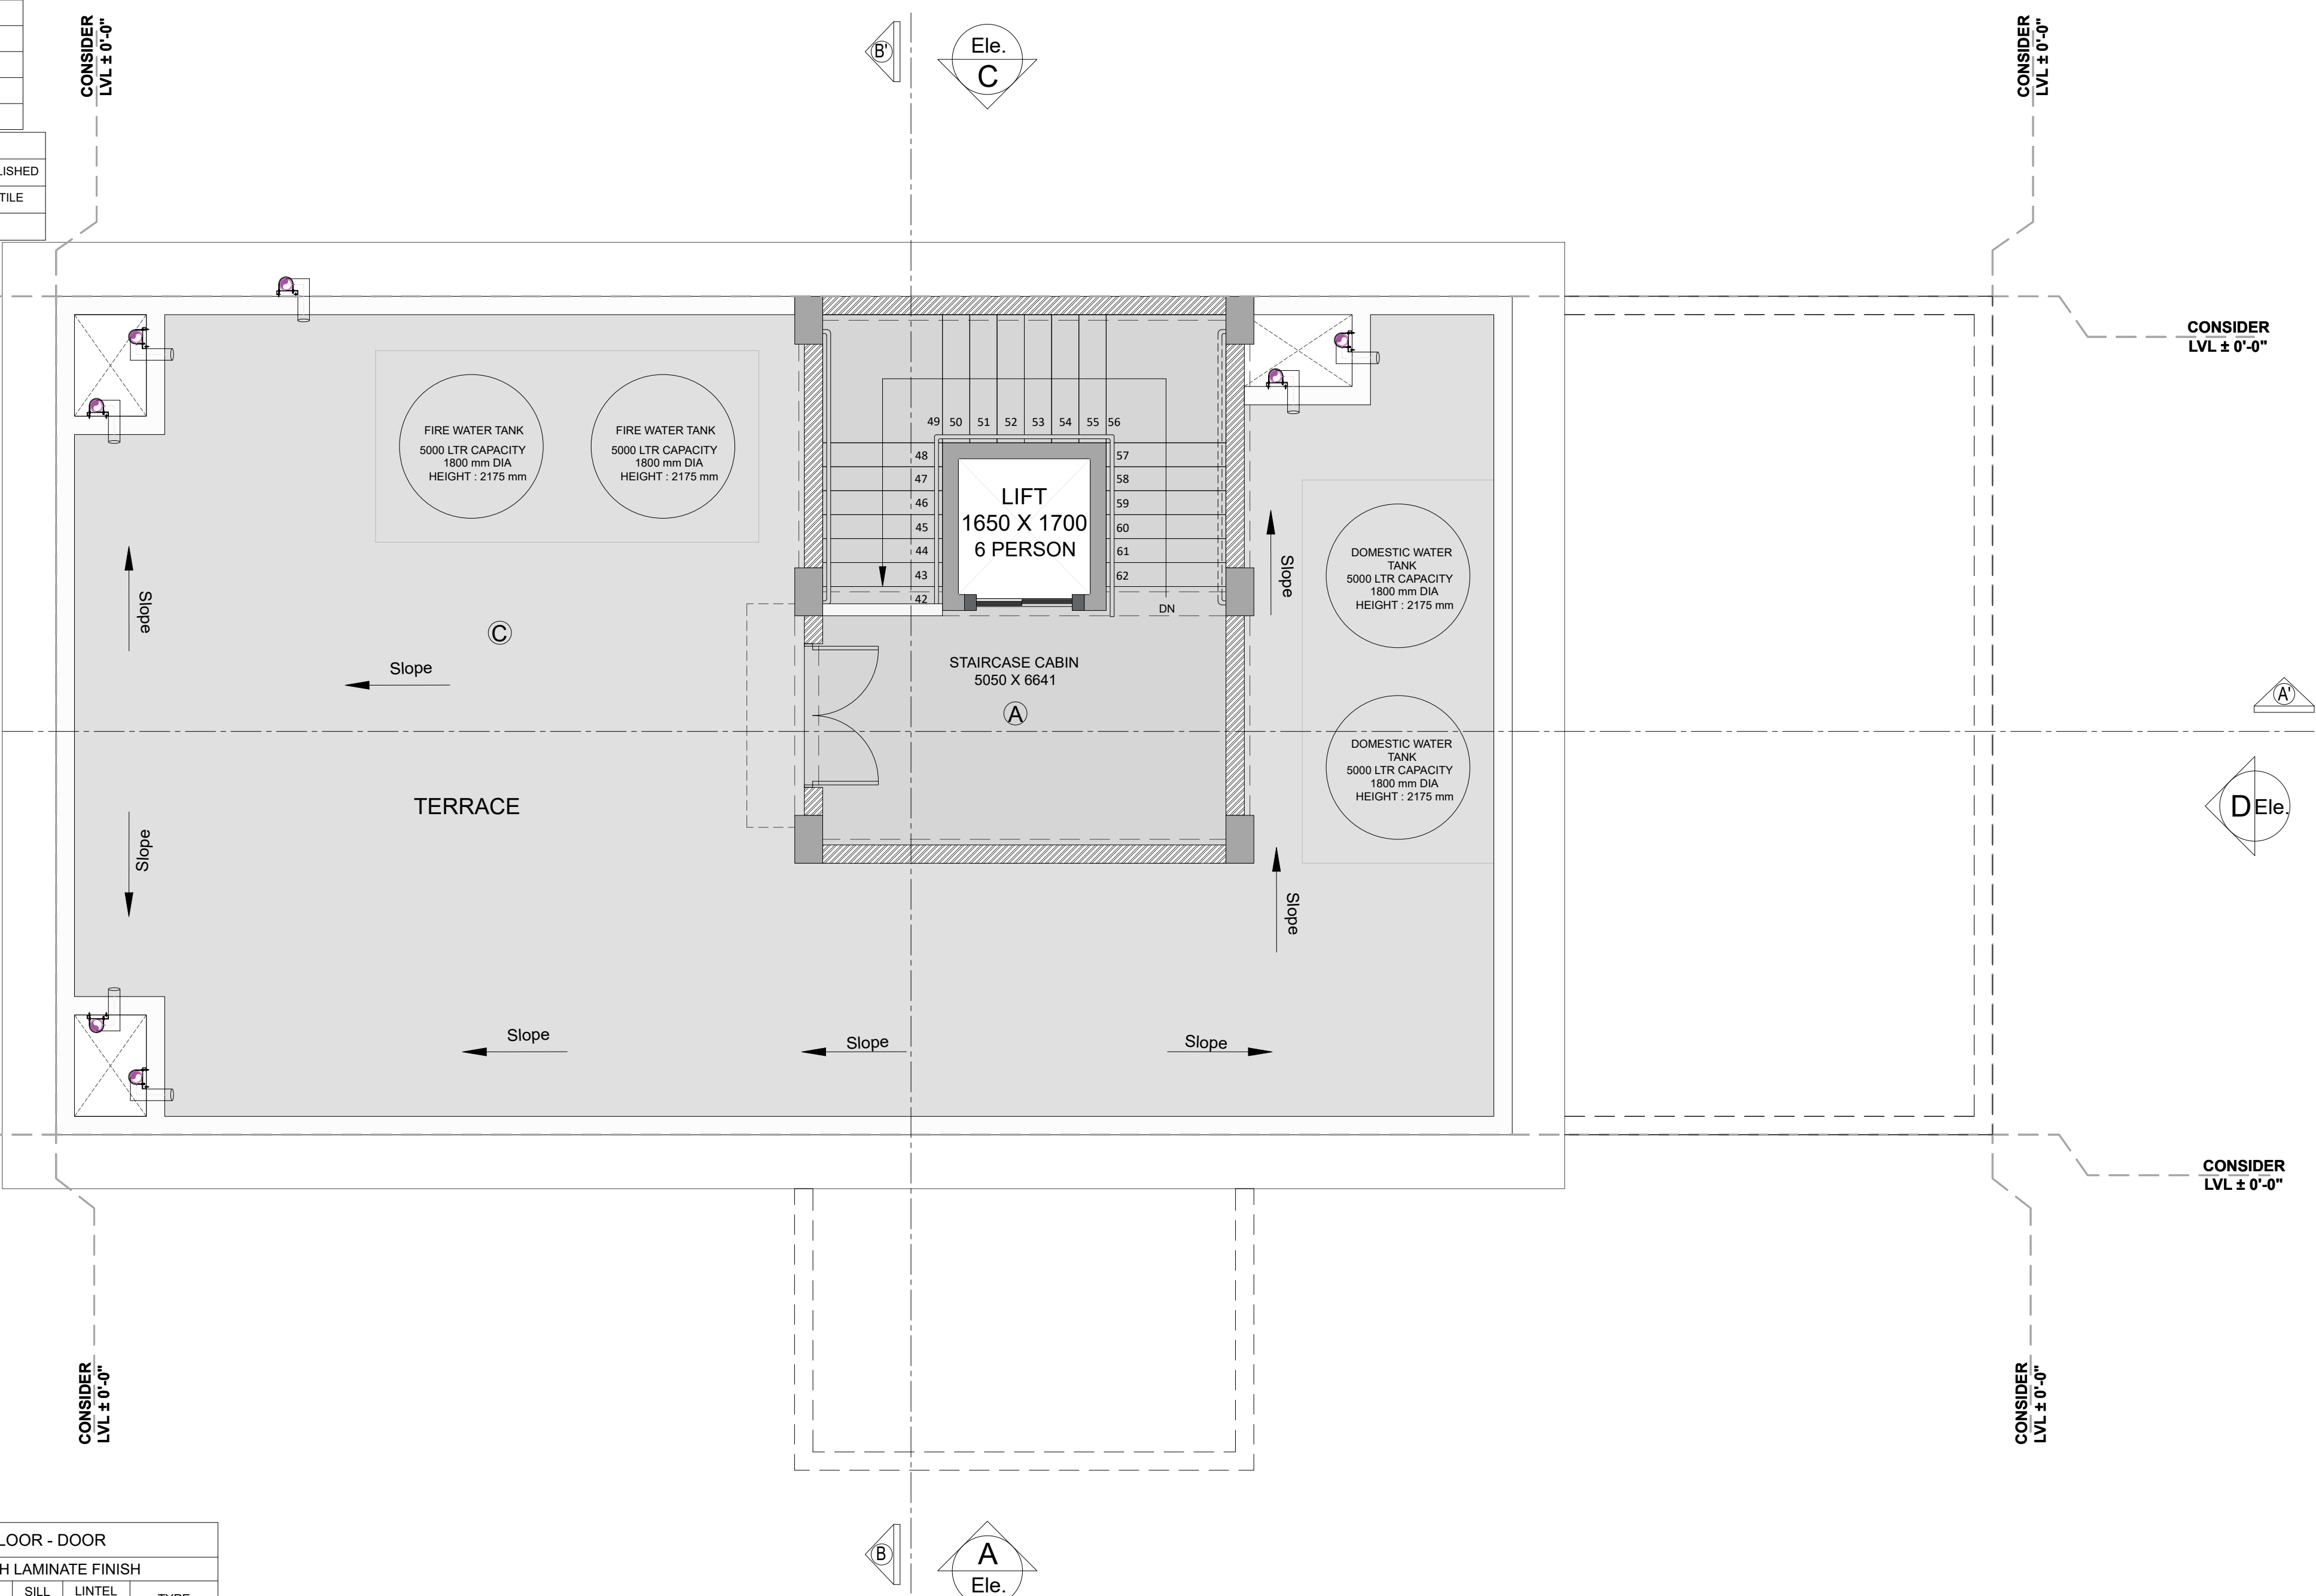


TERRACE FLOOR - DOOR					
FLUSH DOOR WITH LAMINATE FINISH					
CODE	DOOR SIZE	NO. OF DOORS	SILL HT.	LINTEL HT.	TYPE
DD	1800 X 2175	2	-	2175	2 - SHUTTER

PROJECT INFORMATION:		SITE ADDRESS :		KEY PLAN :		GENERAL NOTES:		REVISION PARTICULARS:				STRUCTURAL CON		ARCHITECTS / INTERIOR DESIGNERS:		DRAWING TITLE:		<div><div></div><div>N</div></div>		
BHUJ ARCHEOLOGY OFFICE, AT BHUJ.		CLIENT :  <b>SPORTS AUTHORITY OF GUJARAT</b>				1. All Dimensions Are In MM 2. Do not scale the drawings.  3. This drawing is to be read in conjunction with all other related architectural & others consultants drawings.  4. Any discrepancy found in the drawings must be brought to Architect's office prior of execution.		<div><div></div><div></div><div></div><div></div></div> <div>SR.NO    DATE    Dm By    Revision</div>		<div><div><b>PARAM</b></div><div>CONSULTING ENGINEERS B/1111 UNICUS SHYAMAL SHYAMAL CROSS ROAD, AHMEDABAD-15 MO :- 9510415231 E mail :-kedar.paramconsultant@gmail.com</div><div>M.E.P CONSULTANT</div></div>		<div><div><div></div><div><b>EITHER OR</b></div><div>ARCHITECTURE</div></div><div>901, Matrix, Behind Divya Bhaskar, S G Highway, Ahmedabad - Gujarat - 54. eitheror.architecture@gmail.com, 9724694445</div></div>		TERRACE FLOOR FLOORING PLAN						
														SCALE: 1:25		DWN BY:			CHECKED BY:	
				DATE : 20-05-2026										HARSH SHAH						
				SHEET NO : S15										DRAWING NO:						
														REV.NO: R0		A - 204				
														PROJ REF: ARC & CIVIL						

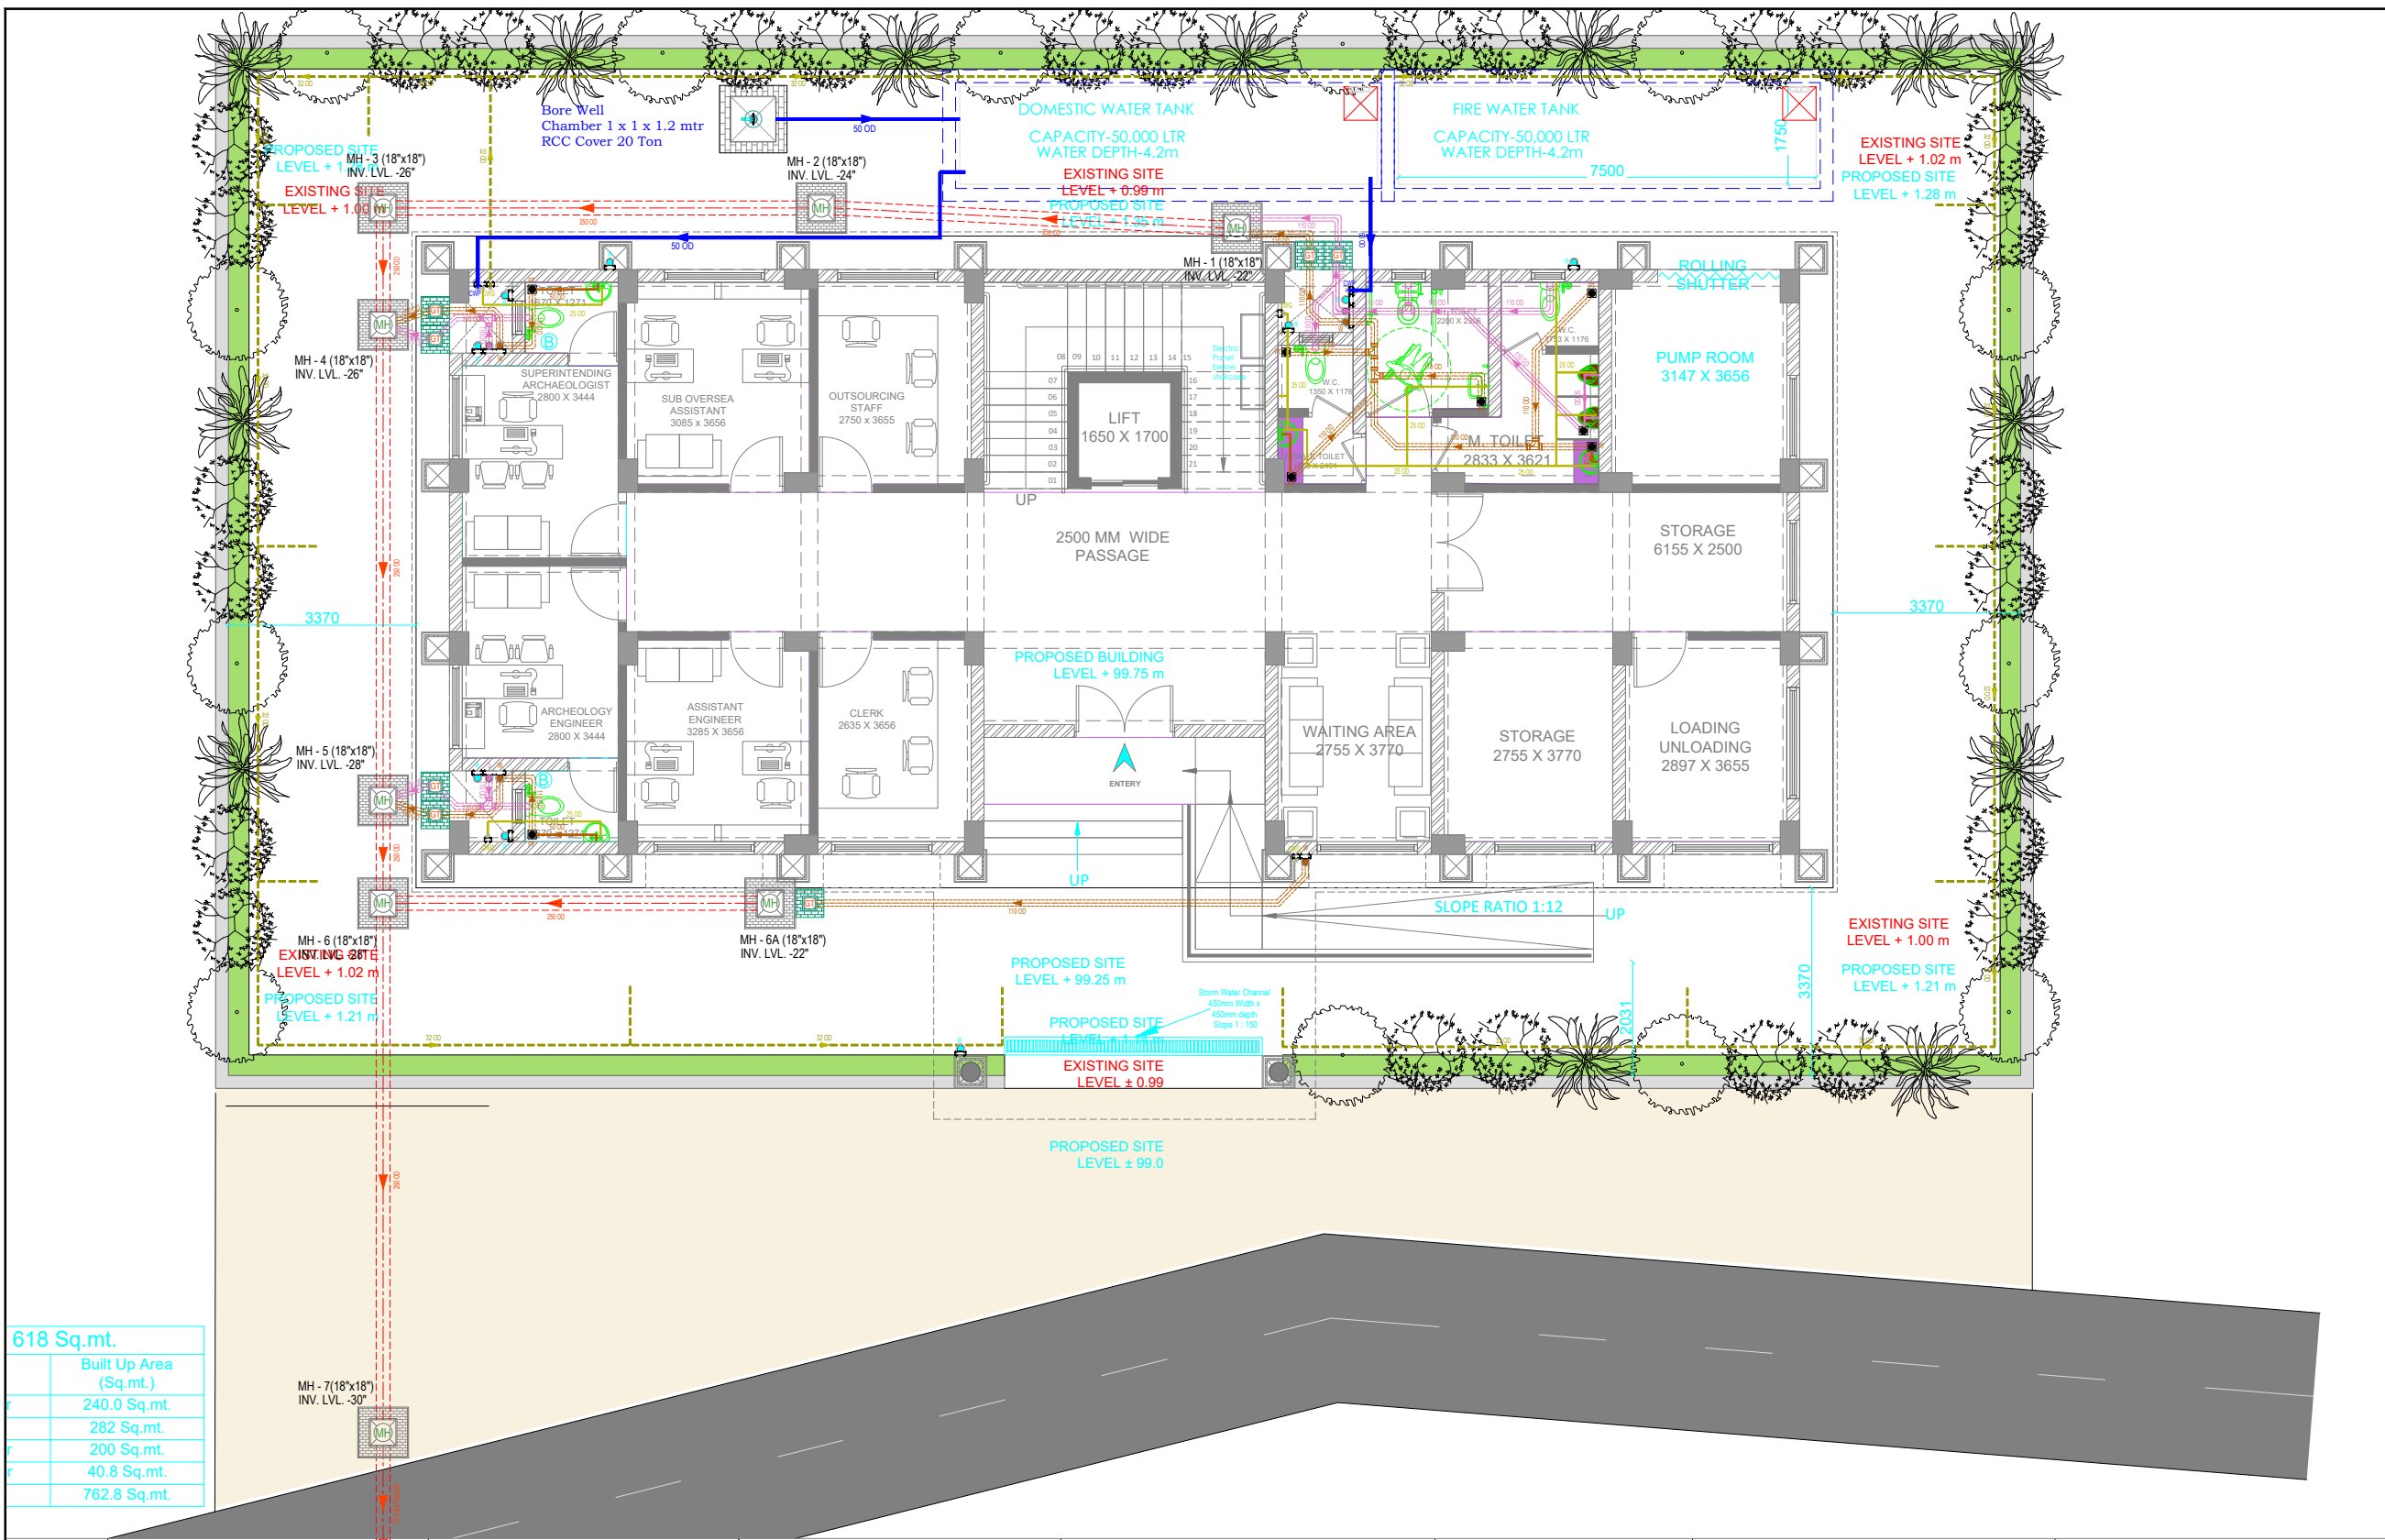

618 Sq.mt.	
	Built Up Area (Sq.mt.)
F	240.0 Sq.mt.
F	282 Sq.mt.
F	200 Sq.mt.
F	40.8 Sq.mt.
F	762.8 Sq.mt.

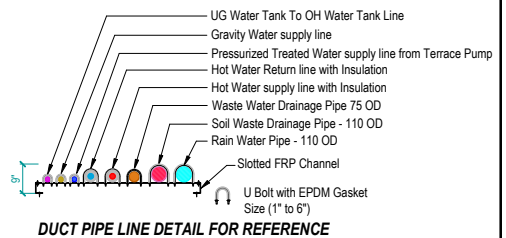

REVISION PARTICULARS:				
REV.	DATE	REMARKS	DRN.	CHK.
R1	18/05/26		I.K.	JNM
R0	11/04/26		I.K.	JNM

LEGEND FOR DRAINAGE PIPE LINE :			
[P]	TRAP-110 x 75mm	[G]	GUBBY
[MFT]	MULTI FLOOR TRAP		
W3	- 40mm OD uPVC (Low Noise heavy duty)	W/W	PIPE SLOPE- 1 IN 40
W2	- 50mm OD uPVC (Low Noise heavy duty)	W/W	PIPE SLOPE- 1 IN 40
W1	- 75mm OD uPVC (Low Noise heavy duty)	W/W	PIPE SLOPE- 1 IN 50
W	- 75mm OD uPVC (Low Noise heavy duty)	W/W	PIPE DUCT
S	- 110mm OD uPVC (Low Noise heavy duty)	S/W	PIPE DUCT
S1	- 110mm OD uPVC (Low Noise heavy duty)	S/W	PIPE SLOPE- 1 IN 40
G	- 110mmØ uPVC ECO DRAIN PIPE	W/W	PIPE SLOPE- 1 IN 80
H	- 160mmØ uPVC ECO DRAIN PIPE		PIPE SLOPE- 1 IN 100
AV	- 75mm OD uPVC (SWR -Type B Ring Fit)		AIRVENT PIPE
R	- 110mm OD uPVC (SWR -Type B Ring Fit)		RAIN WATER PIPE
R1	- 75mm OD uPVC (SWR -Type B Ring Fit)		RAIN WATER PIPE
BD	- 75mm OD uPVC (SWR -Type B Ring Fit)		BALCONY DRAIN PIPE

LEGEND OF WATER SUPPLY PIPE LINE :			
[CW]	GRAVITY- SOFT WATER SUPPLY LINE		
[PRESSURIZED]	PRESSURIZED - SOFT WATER SUPPLY LINE		
[RAW]	GRAVITY - RAW WATER SUPPLY LINE		
[PRESSURIZED-RAW]	PRESSURIZED - RAW WATER SUPPLY LINE		
[FL]	FLUSHING WATER LINE		
[B]	BORE WATER SUPPLY LINE		
[CONCEAL]	CONCEAL HOT WATER LINE WITH INSULATION 9mm THIK NITRILE RUBBER		
[OPEN]	OPEN HOT WATER LINE WITH INSULATION 13mm THIK NITRILE RUBBER		
[HOT RETN]	HOT WATER RETN LINE WITH INSULATION		
[INSULATION]	INSULATION 9mm THIK NITRILE RUBBER		
[PRESSURIZED-RAW]	PRESSURIZED - RAW WATER SUPPLY LINE 32MM		

[S]	(S) SOIL WASTE LINE
[W]	(W) WASTE WATER LINE
[R]	(R) RAIN WATER LINE
[VP OR AV]	(VP OR AV) AIR VENT LINE
[BD]	(BD) - BALCONY DRAIN LINE
[MAIN MAN HOLE]	MAIN MAN HOLE DRAINAGE LINE
[BALL VALVE]	BALL VALVE
[GATE/GLOBE VALVE]	GATE/GLOBE VALVE
[NON RETURN VALVE]	NON RETURN VALVE
[BALL COCK]	BALL COCK

ARCHITECT	
EITHER OR ARCHITECTURE	
901, Matrix, Behind Divya Bhaskar, S G Highway, Ahmedabad - Gujarat - 54, eitheror.architecture@gmail.com, 9724694445	
TITLE :	
PLUMBING MATER SITE PLAN	
SCALE: NTS	DRAWN BY: I.K.
DATE: 18/05/2026	CHECKED BY: JNM
DWG NO: DV_PLU.-01	APPROVED BY: -----

PROJECT :-	
BHUJ ARCHEOLOGY	
MEPF CONSULTANTS	
D.V. TECH ENGINEERS	
1221,Satymev Eminence, Near Shukan mall, Sola Science city Road, Sola Ahmedabad -380060, Email: dvtech09@gmail.com contact: 7383602432	
















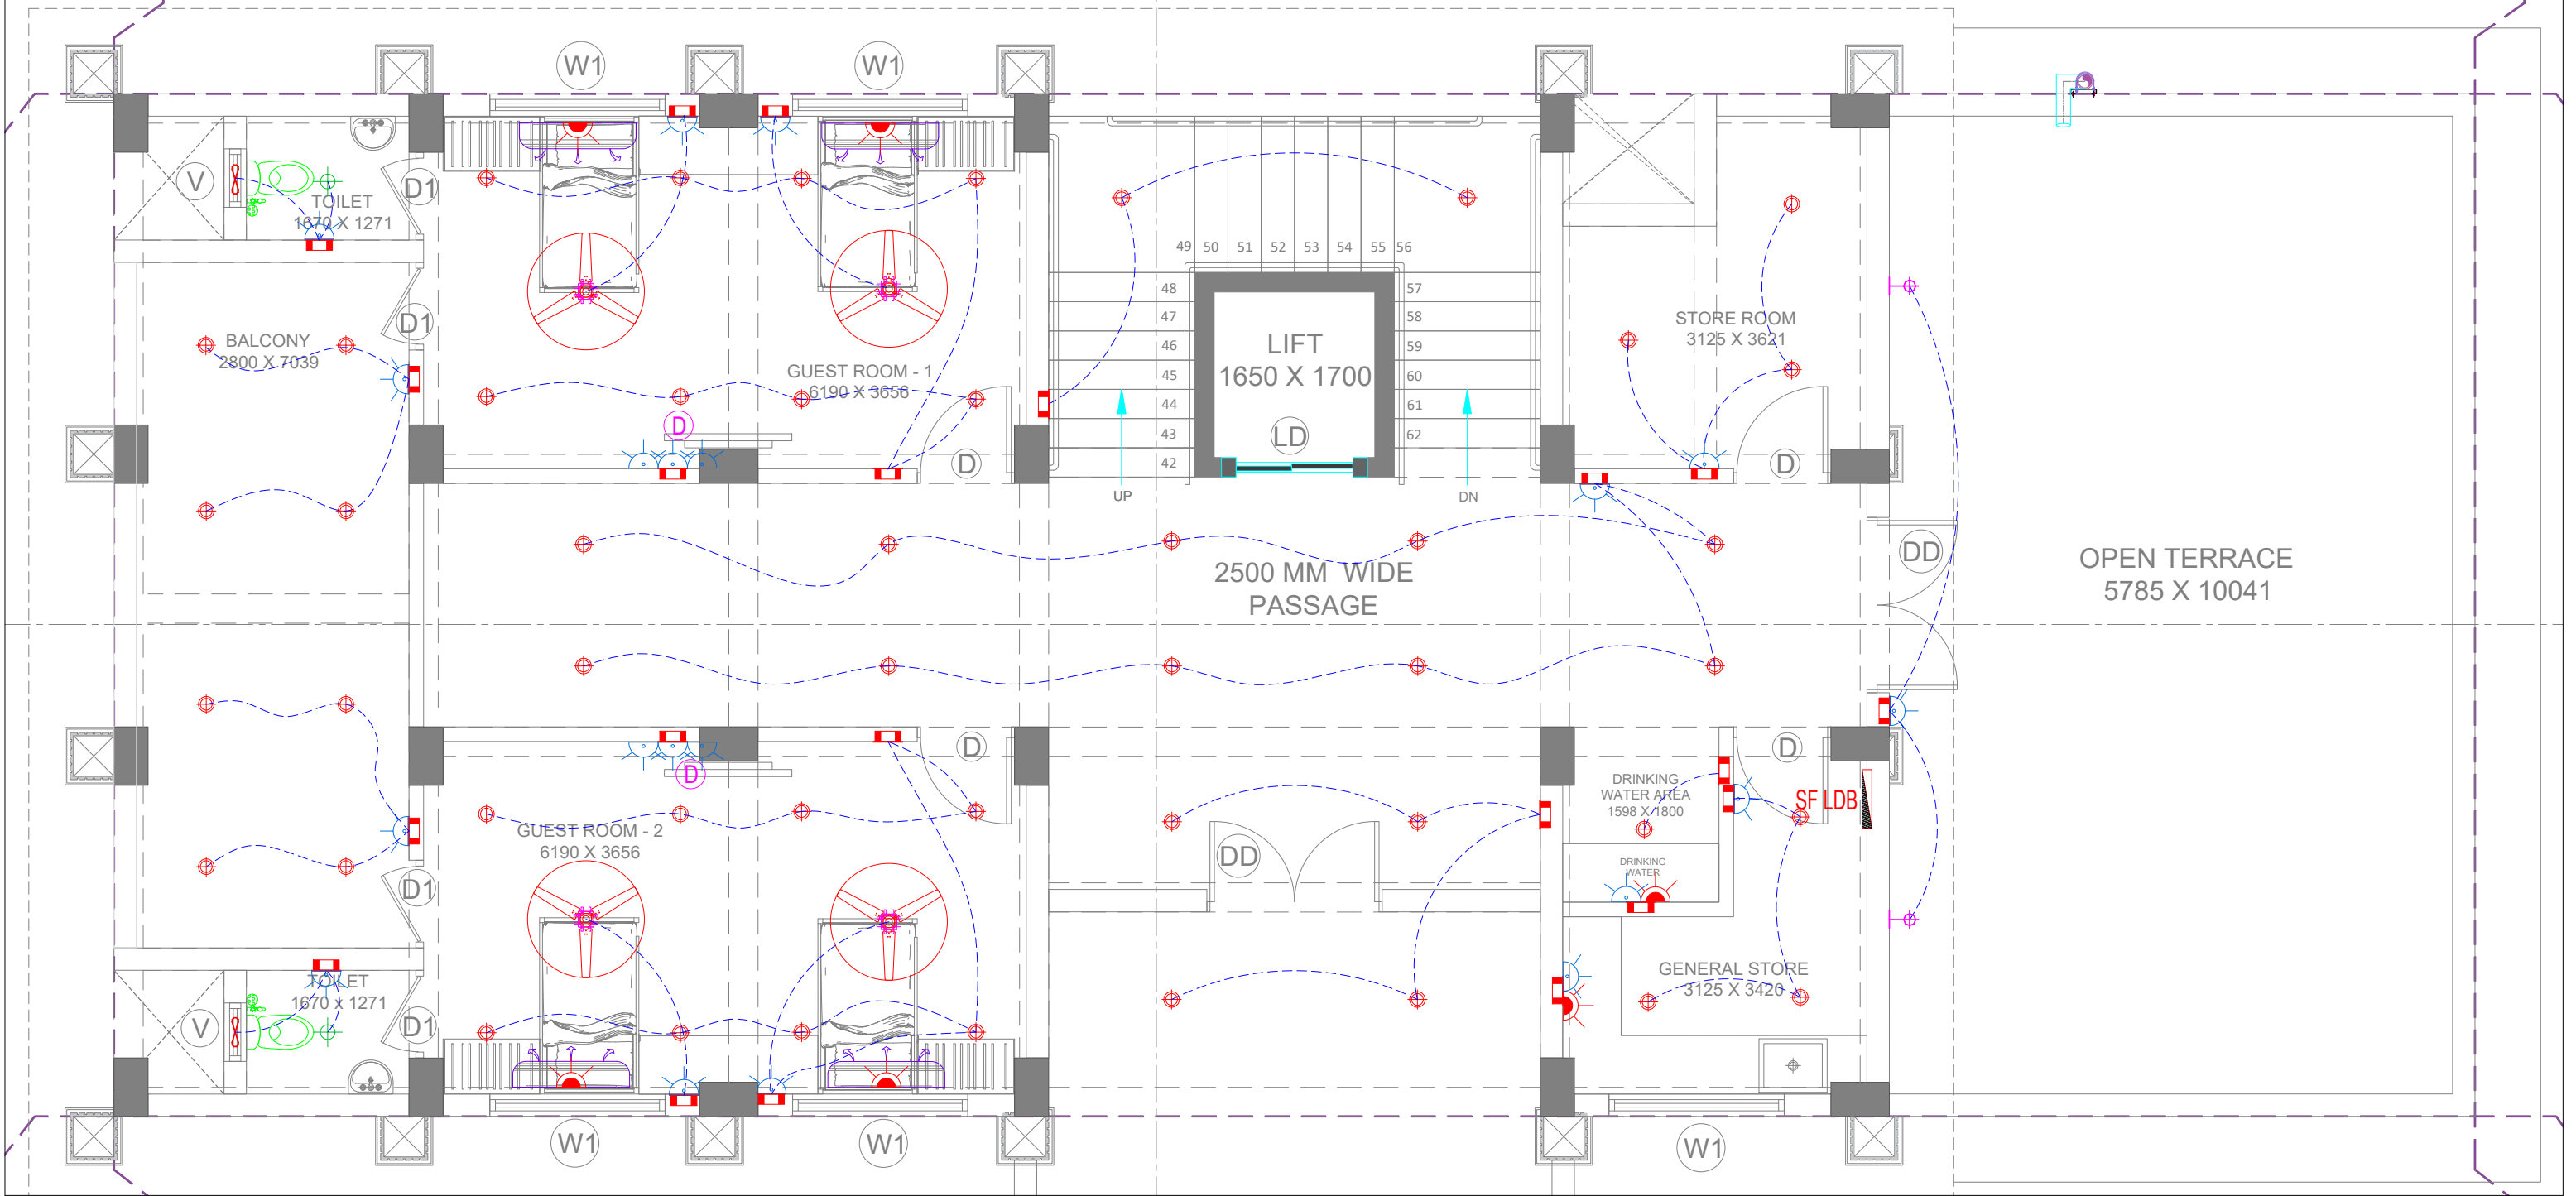

ELE LEGEND FOR SECOND FLOOR :-


SYM	DESCRIPTION	QTY.
	1200mm CEILING FAN	04 Nos.
	8WAY FAN JUNCTION BOX	04 Nos.
	18W LED DOWN LIGHT	47 Nos.
	12W LED DOWN LIGHT	02 Nos.
	WALL LIGHT	02 Nos.
	5A POWER SOCKET	20 Nos.
	15A POWER SOCKET	06 Nos.
	5/15A UPS SOCKET	00 Nos.
	SWITCH BOARD	21 Nos.
	EXHAUST FAN	02 Nos.
	LIGHTING DB	01 Nos.
	NORMAL CONTROL	-----

PROJECT INFORMATION:		SITE ADDRESS :				KEY PLAN :						REVISION PARTICULARS:				STRUCTURAL CON		ARCHITECTS / INTERIOR DESIGNERS:		DRAWING TITLE:																																																																																																																																																																																																																																																																																																																																																																																																																																																																																																																																																																																																																																																																																																																																																																																																																																																																																																																																																																																																																																																																																																															
BHUJ ARCHOLOGY																		<div><div></div><div><b>EITHER OR</b> ARCHITECTURE</div></div> <div>901, Matrix, Behind Divya Bhaskar, S G Highway, Ahmedabad - Gujarat - 54. eitheror.architecture@gmail.com, 9724694445</div>		ELE LIGHTING CONTROL LAYOUT FOR SECOND FLOOR																																																																																																																																																																																																																																																																																																																																																																																																																																																																																																																																																																																																																																																																																																																																																																																																																																																																																																																																																																																																																																																																																																															
		CLIENT :																						R0		20/05/26		D.M		---						SR.NO		DATE		Dm By		Revision																																																																																																																																																																																																																																																																																																																																																																																																																																																																																																																																																																																																																																																																																																																																																																																																																																																																																																																																																																																																																																																																																									

These drawings & designs are the sole property of EITHER OR ARCHITECTURE and as such shall not be reproduced in any form without express written permission of EITHER OR ARCHITECTURE. All drawings and related documents shall be returned to EITHER OR ARCHITECTURE upon request.






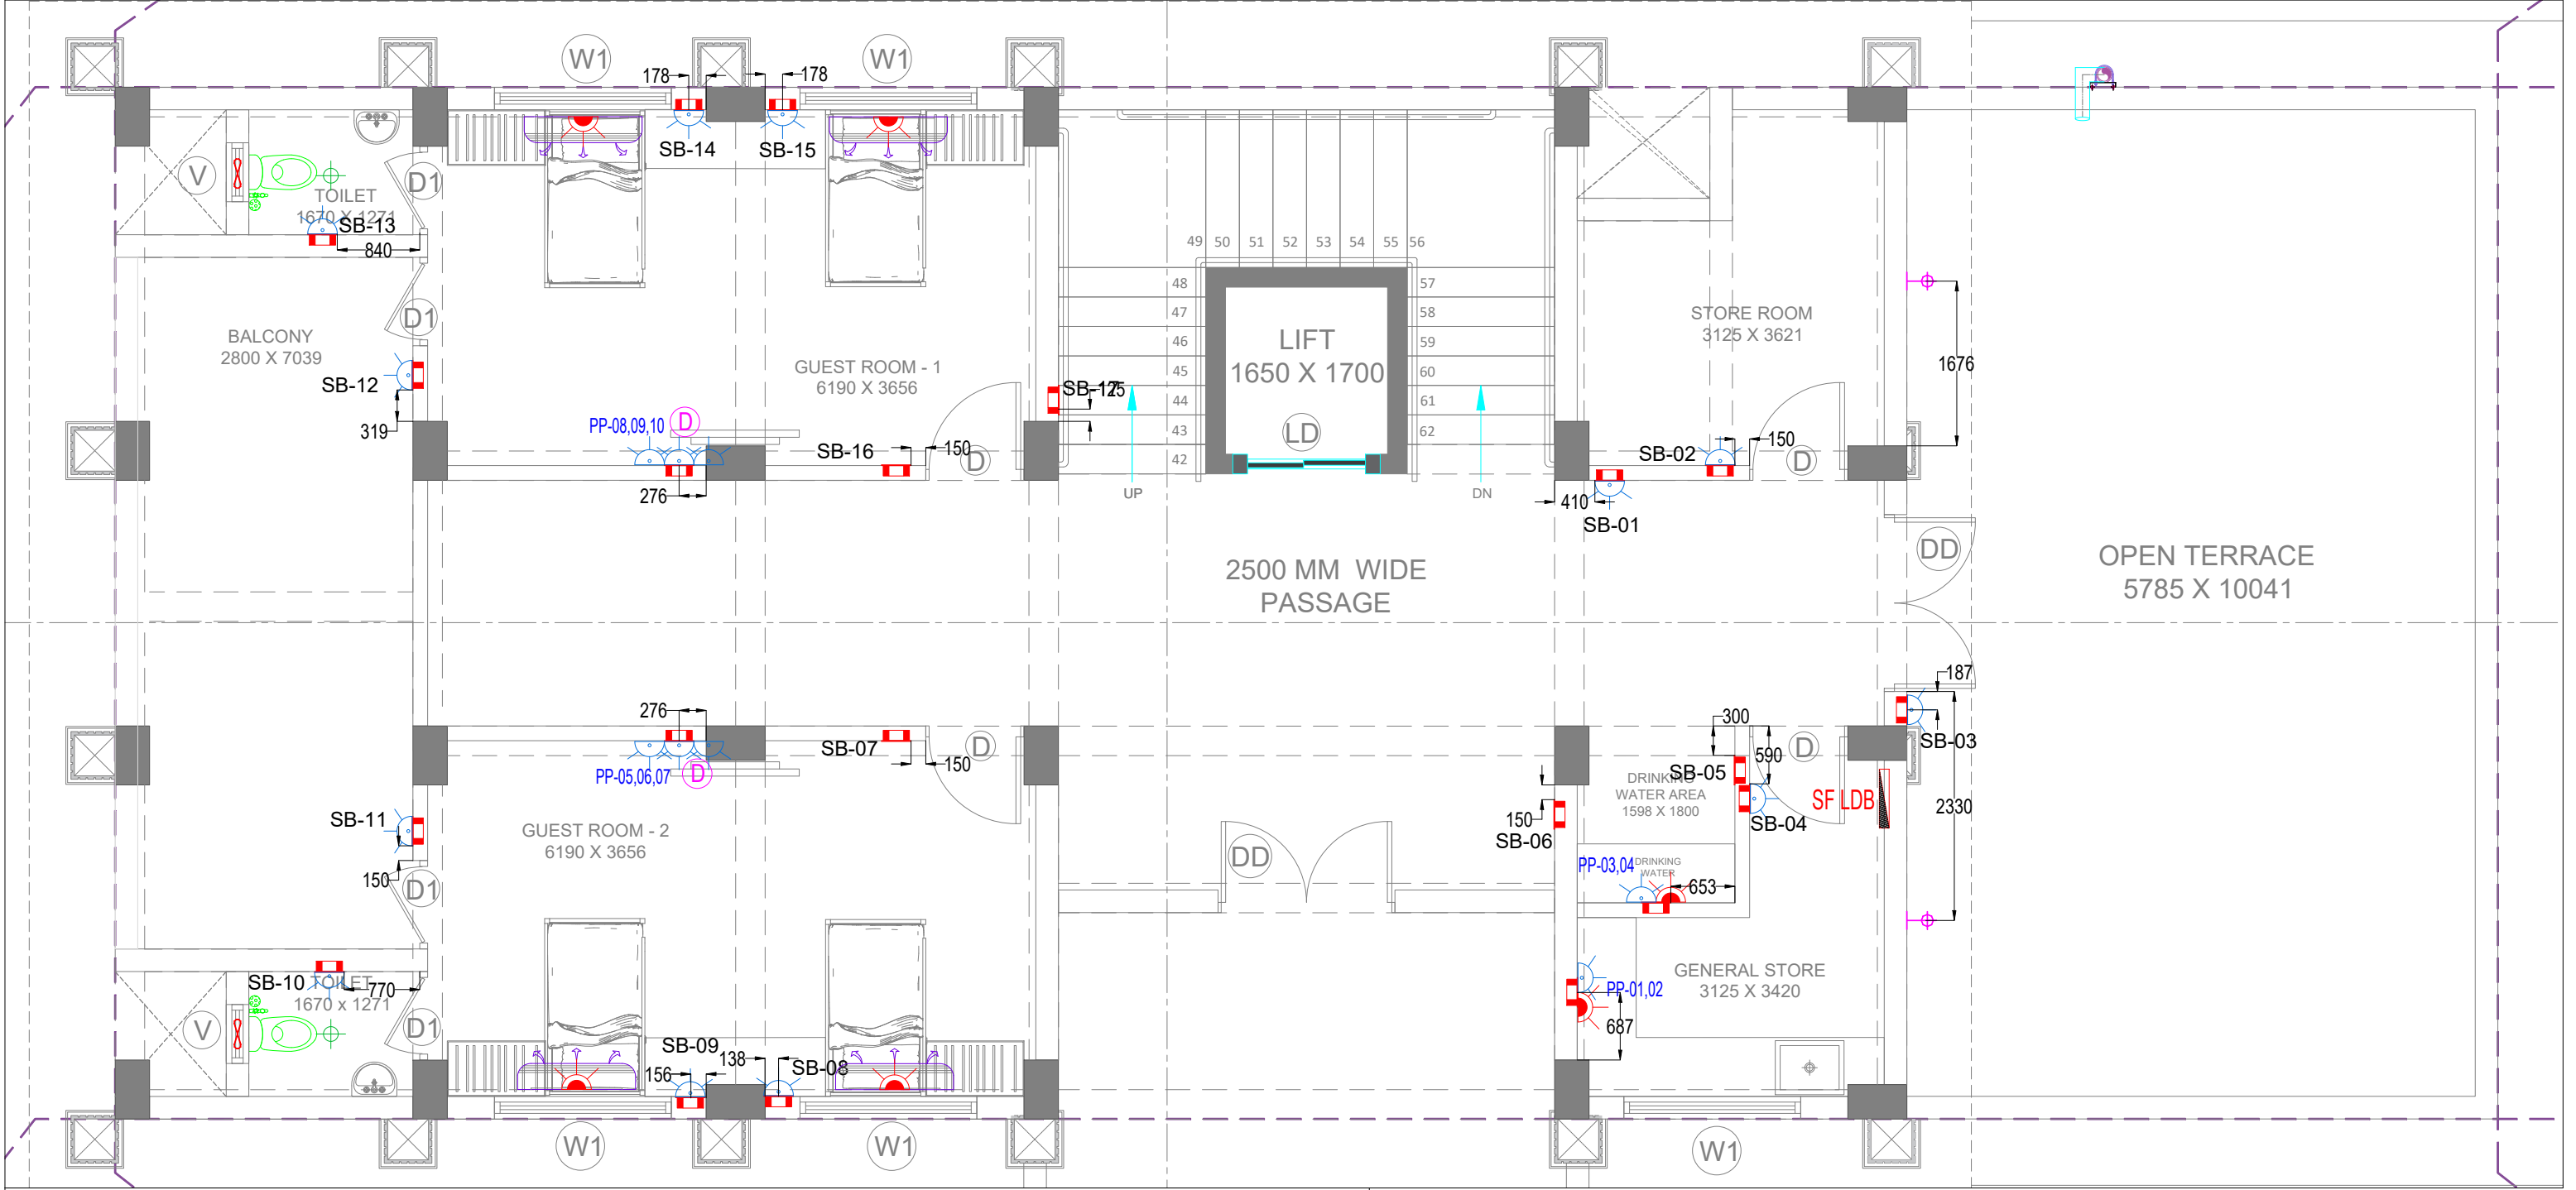

SECOND FLOOR SB DETAIL								
SB NO	MODULE	HEIGHT	SB NO	MODULE	HEIGHT	PP NO	MODULE	HEIGHT
SB1	6	4'	SB11	6	4'	PP1,2	6	4'
SB2	6	4'	SB12	6	4'	PP3,4	6	5'
SB3	6	4'	SB13	6	4'	PP5,6,7	8	2'
SB4	4	4'	SB14	6	2'		4	4'
SB5	1	4'	SB15	8	2'	PP8,9,10	8	2'
SB6	2	4'	SB16	3	4'		4	4'
SB7	3	4'	SB17	1	4'			
SB8	8	2'	SB18	8	4'			
SB9	6	2'	SB19	6	4'			
SB10	6	4'						

PROJECT INFORMATION:		SITE ADDRESS :				KEY PLAN :				REVISION PARTICULARS:				STRUCTURAL CON		ARCHITECTS / INTERIOR DESIGNERS:		DRAWING TITLE:									
BHUIJ ARCHOLOGY																<div><div></div><div>EITHER OR ARCHITECTURE</div><div>901, Matrix, Behind Divya Bhaskar, S G Highway, Ahmedabad - Gujarat - 54. eitheror.architecture@gmail.com, 9724694445</div></div>		ELE SB DETAIL LAYOUT FOR SECOND FLOOR									
		CLIENT :				R0		20/05/26		D.M		---		<div><div></div><div>D.V. TECH ENGINEERS</div></div>				SCALE:		1:250		DWN BY:		CHECKED BY:		APPROVED B	
												DATE :						20/05/2026		DHARTI MISTRY		DHARTI MISTRY		---			
						SR.NO		DATE		Dm By		Revision						SHEET NO.:		1 OF 3		DRAWING NO:					
																		REV.NO:		R0		CON:02					
																		PROJ REF:		ARC & CIVIL							


These drawings & designs are the sole property of EITHER OR ARCHITECTURE and as such shall not be reproduced in any form without express written permission of EITHER OR ARCHITECTURE. All drawings and related documents shall be returned to EITHER OR ARCHITECTURE upon request.

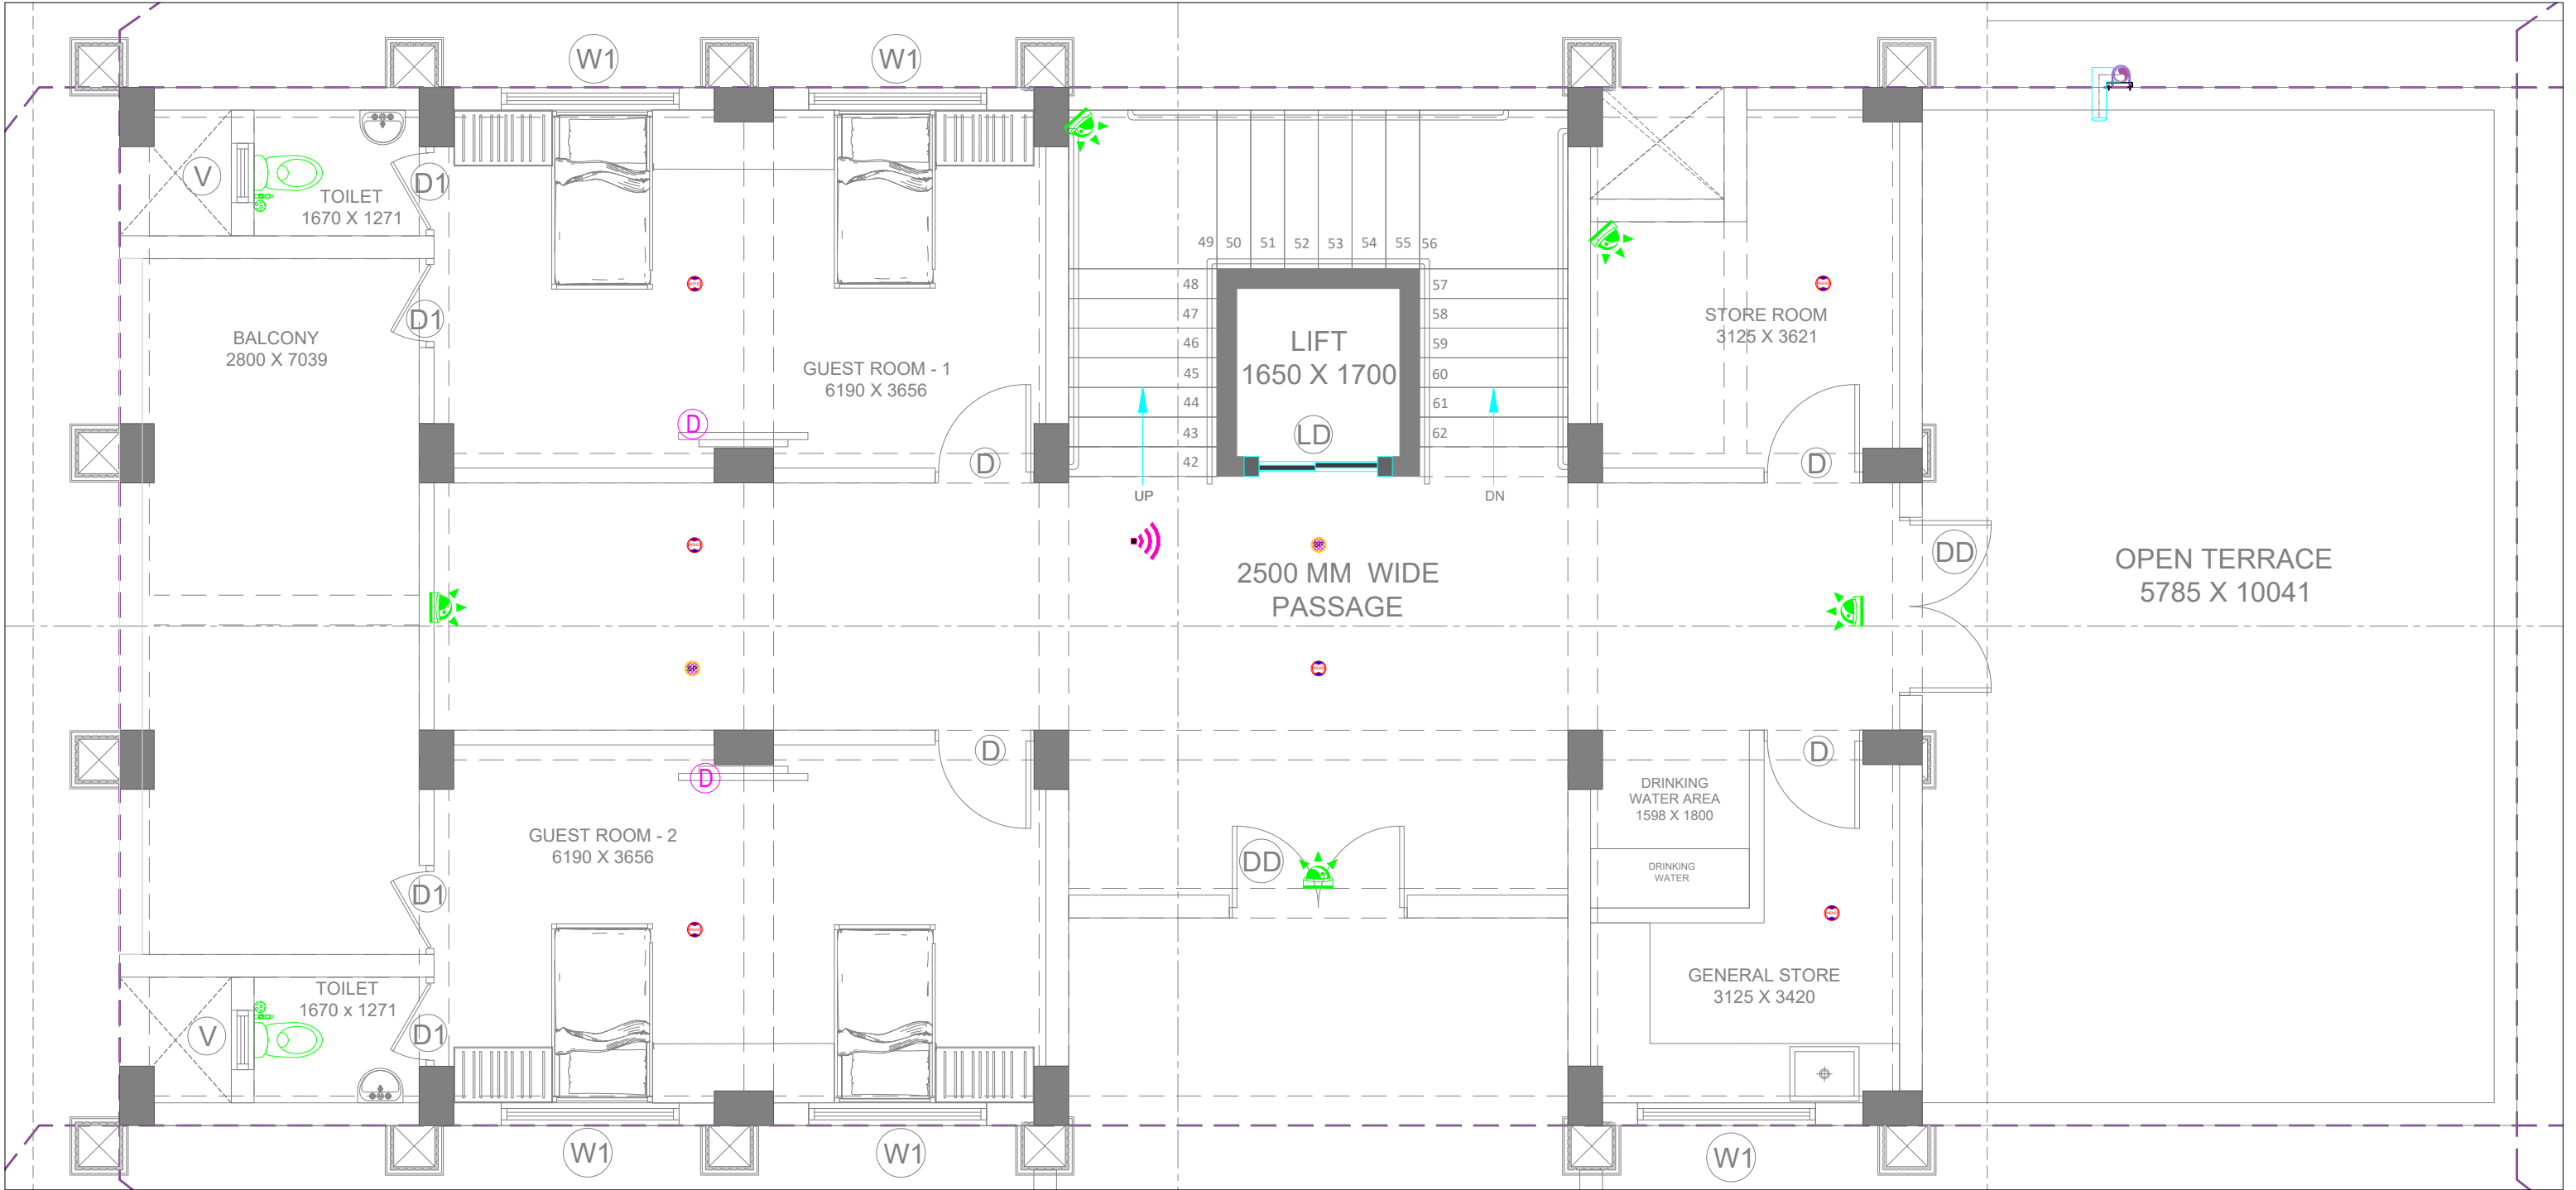

ELV LEGEND FOR SECOND FLOOR :-		
SYM	DESCRIPTION	QTY.
	CCTV CAMERA (DOME)	05 Nos.
	CCTV CAMERA (BULLET)	00 Nos.
	PA SYSTEM	02 Nos.
	WIFI POINT	01 Nos.
	SMOKE DETECTOR	06 Nos.
	TELEPHONE POINT	00 Nos.
	DATA POINT	02 Nos.


PROJECT INFORMATION:		SITE ADDRESS :				KEY PLAN :				REVISION PARTICULARS:		STRUCTURAL CON		ARCHITECTS / INTERIOR DESIGNERS:		DRAWING TITLE:					
BHUUJ ARCHOLOGY														<div><div></div><div>EITHER OR ARCHITECTURE</div><div>901, Matrix, Behind Divya Bhaskar, S G Highway, Ahmedabad - Gujarat - 54. eitheror.architecture@gmail.com, 9724694445</div></div>		ELV LAYOUT FOR SECOND FLOOR					
CLIENT :										R0		20/05/26		D.M		---					
										SR.NO		DATE		Dm By		Revision					



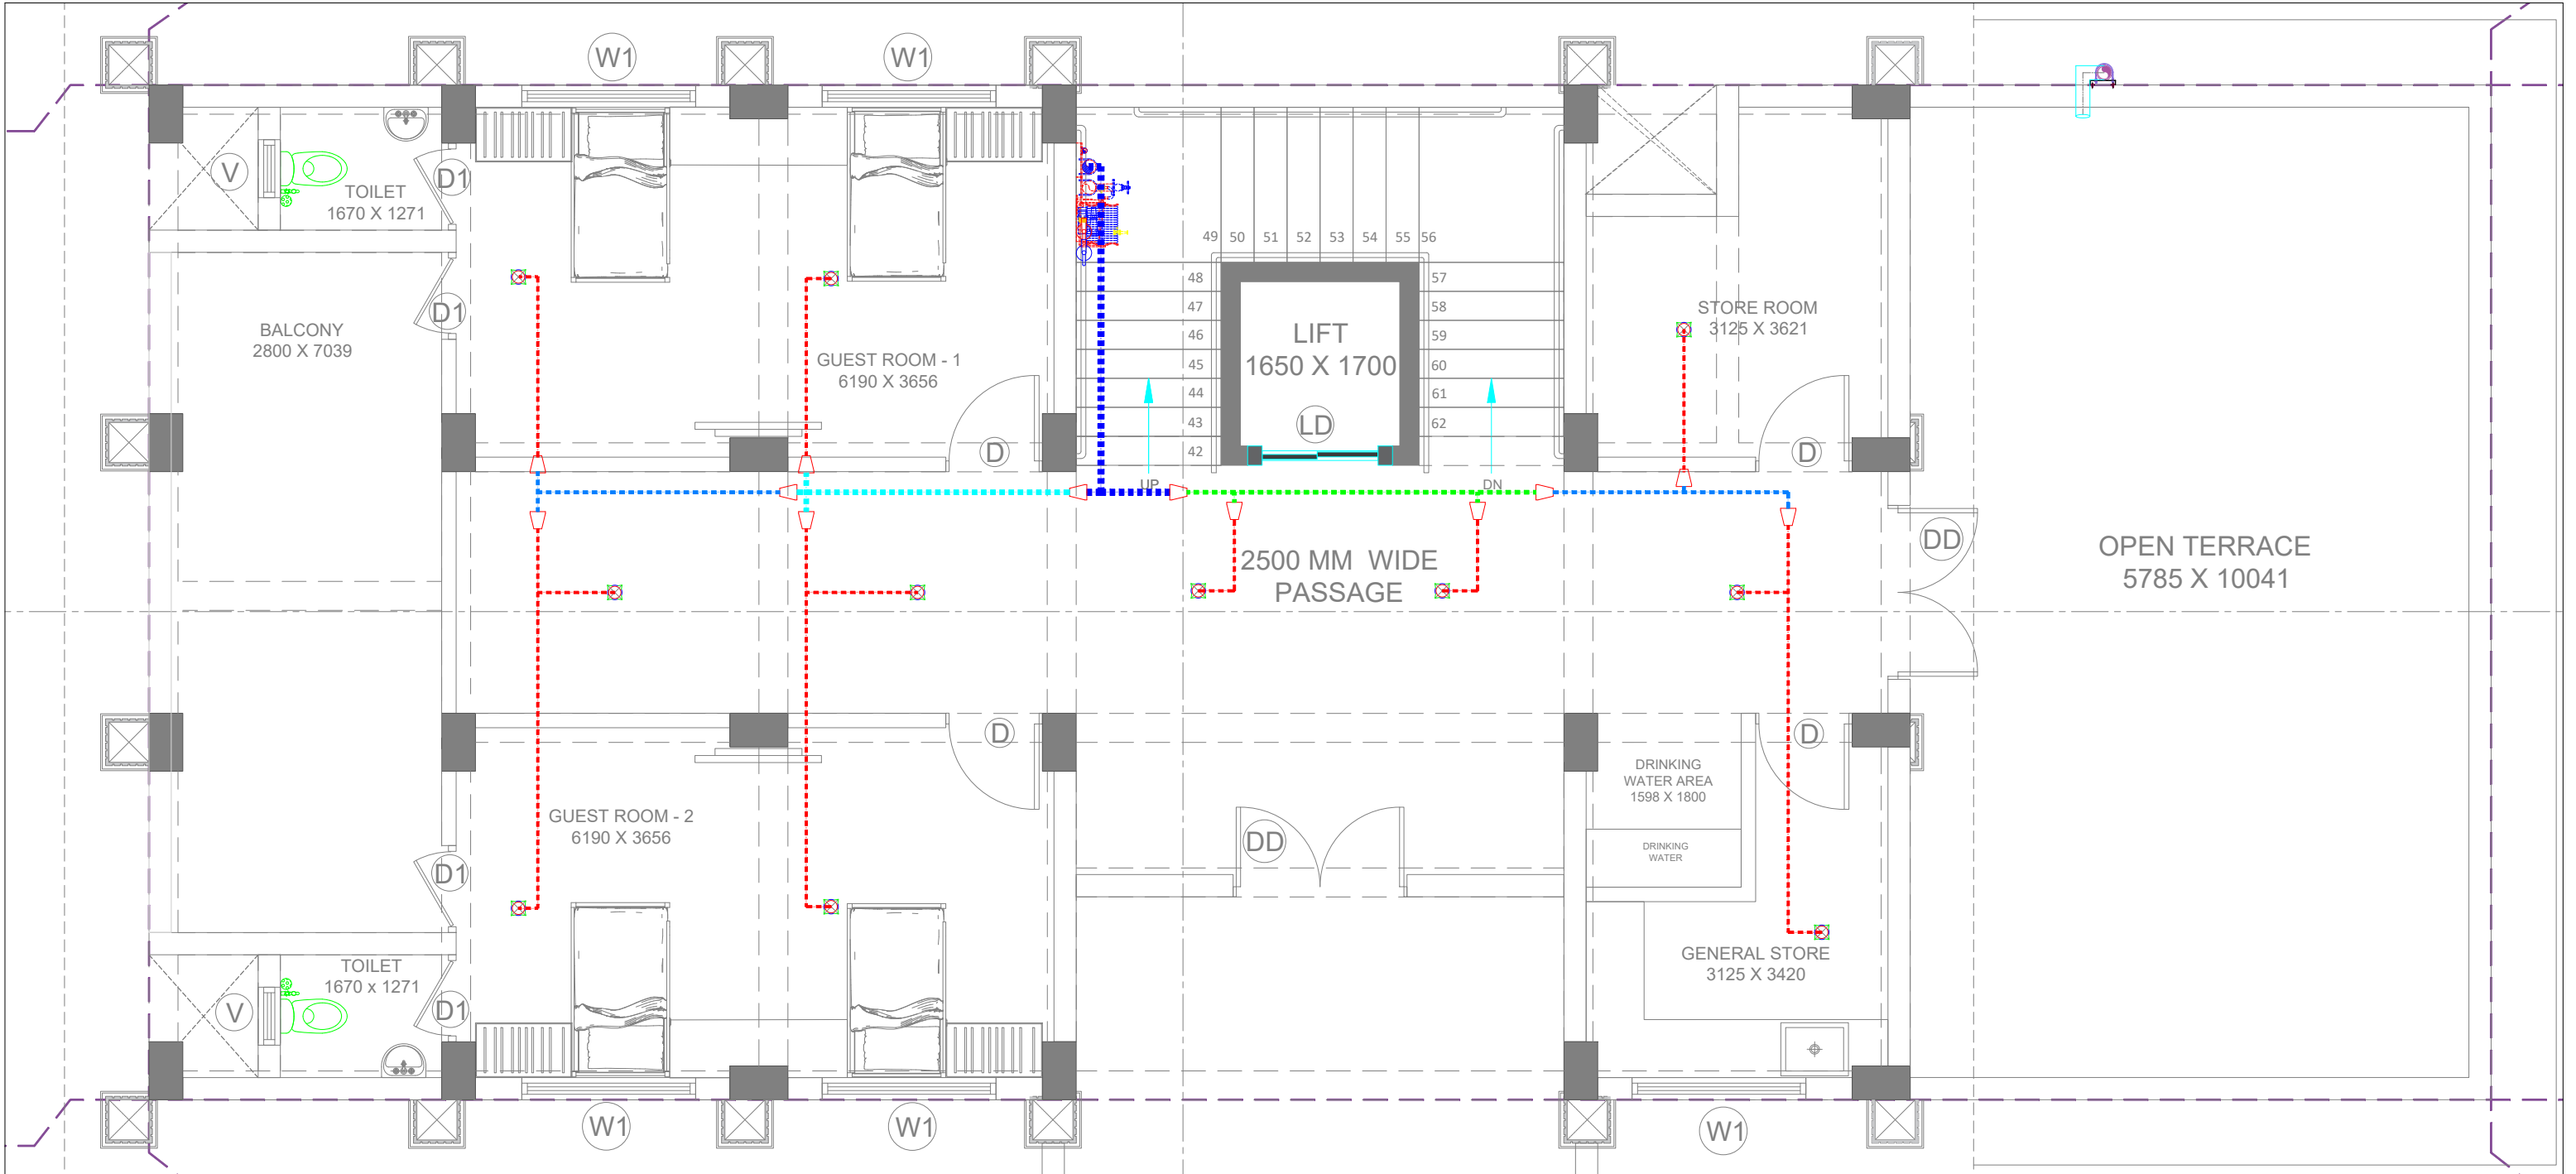


FIRE LEGEND FOR SECOND FLOOR:-		
SYMBOL	DESCRIPTION	QTY.
	25NB SPRINKLER PIPE	-----
	32NB SPRINKLER PIPE	-----
	40NB SPRINKLER PIPE	-----
	50NB SPRINKLER PIPE	-----
	65NB SPRINKLER PIPE	-----
	80NB SPRINKLER PIPE	-----
	100NB HYDRANT PIPE	-----
	150NB SPRINKLER PIPE	-----
	150NB HYDRANT PIPE	-----
	PENDANT SPRINKLER	11 Nos.
	HYDRANT VALVE (HV)	01 Nos.
	HOSE BOX (HB)	01 Nos.
	HOSE REEL (HR)	01 Nos.
	BUTTERFLY VALVE (BFV)	01 Nos.
	NON RETURN VALVE (NRV)	-----
	FIRE EXTINGUISHER CO2 4.5KG (F.X.)	01 Nos.
	FIRE EXTINGUISHER ABC 6KG (F.X.)	01 Nos.

PROJECT INFORMATION:		SITE ADDRESS :				KEY PLAN :				REVISION PARTICULARS:				STRUCTURAL CON		ARCHITECTS / INTERIOR DESIGNERS:		DRAWING TITLE:									
BHUIJ ARCHOLOGY																<div><div></div><div>EITHER OR ARCHITECTURE</div><div>901, Matrix, Behind Divya Bhaskar, S G Highway, Ahmedabad - Gujarat - 54. eitheror.architecture@gmail.com, 9724694445</div></div>		FIRE SPRINKLER LAYOUT FOR SECOND FLOOR									
																		SCALE: 1:250							DWN BY:	CHECKED BY:	APPROVED B
																		DATE : 20/05/2026							DHARTI MISTRY	DHARTI MISTRY	---
CLIENT :										R0 20/05/26 D.M ---		SR.NO DATE Dm By Revision		<div><div></div><div>D.V. TECH ENGINEERS</div></div>				DRAWING NO: 1 OF 3									
																		FFTG:01									
																		ARC & CIVIL									

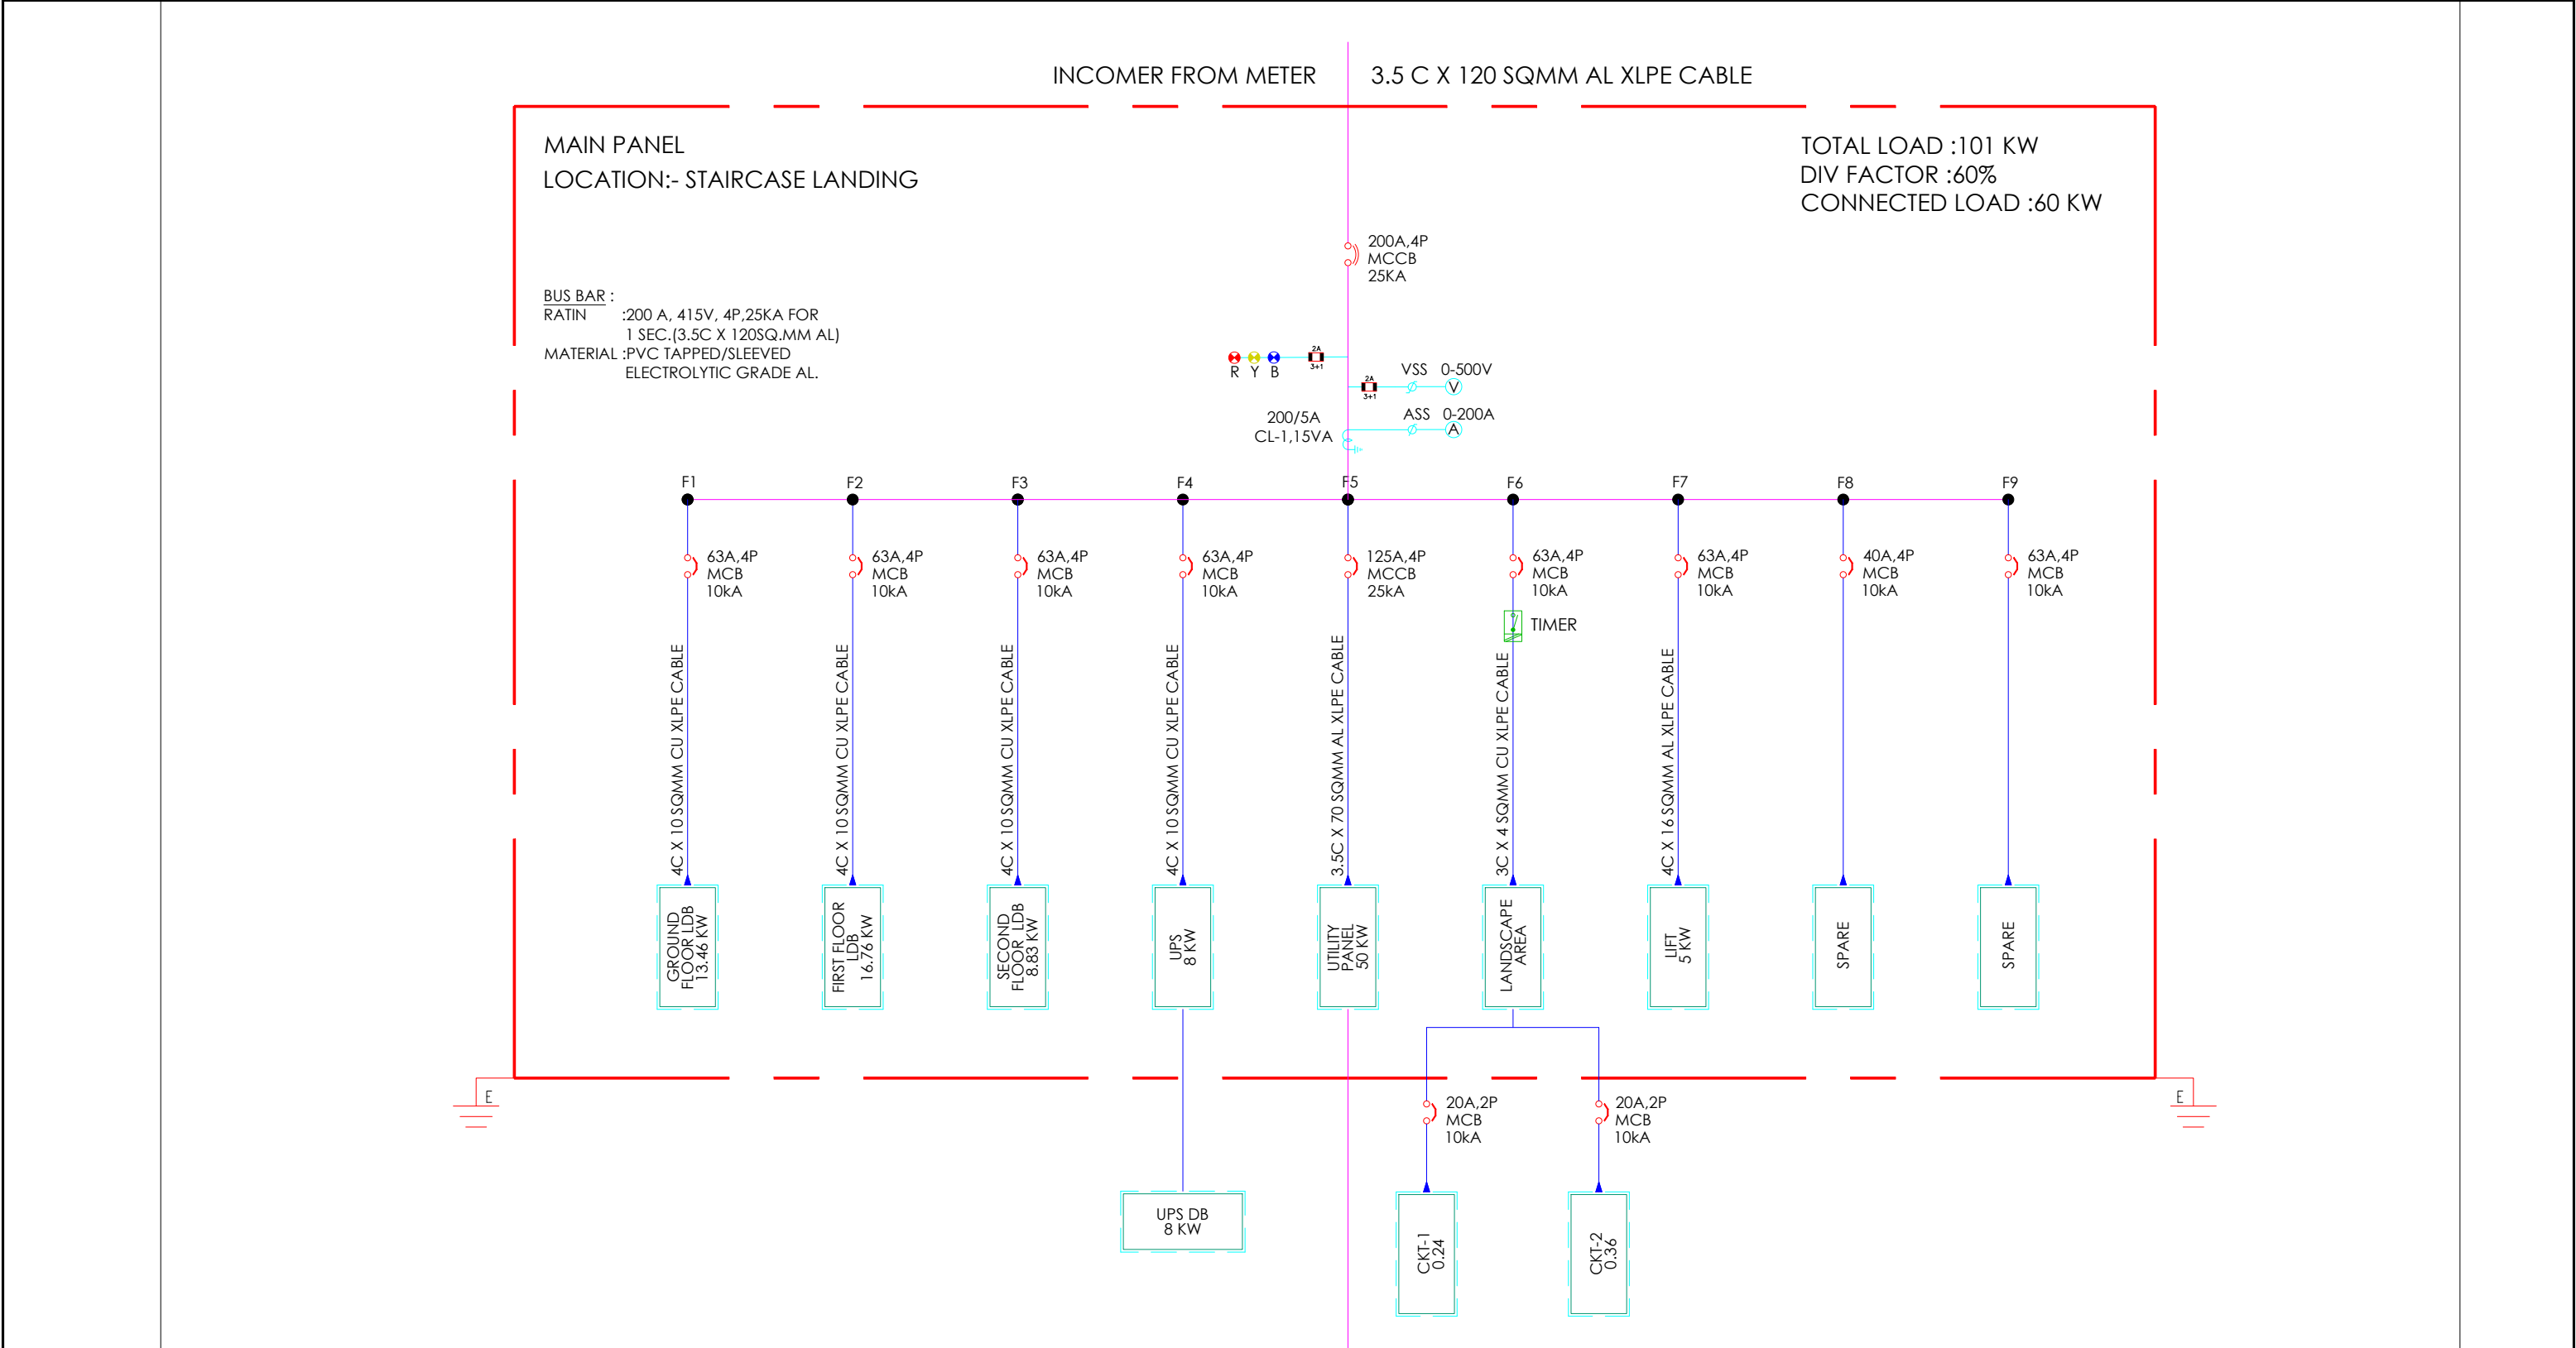

REVISION PARTICULARS:							ARCHITECT			PROJECT :-		
										BHUI ARCHEOLOGY		
										MEPF CONSULTANTS		
												
							TITLE :			1221,Satymev Eminence, Near Shukan mall, Sola Science city Road, Sola Ahmedabad -380060, Email: dvtech09@gmail.com contact: 7383602432		
							MAIN PANEL SLD LAYOUT					
							SCALE: NTS	DRAWN BY: D.M	REV:			
					DATE: 29/05/2026	CHECKED BY: --	R0					
					DWG NO: DV_ELE.-01	APPROVED BY: -----						
R0	29/05/26	----	D.M	--								
REV.	DATE	REMARKS	DRN.	CHK								



