


ELE LEGEND FOR GROUND FLOOR SITE PLAN:-		
SYM	DESCRIPTION	QTY.
	STREET LIGHT (SINGLE ARM)	32 Nos.
	STREET LIGHT (DUAL ARM)	05 Nos.
	LIGHTING DB	-- Nos.
	ELE CONTROL	-----


ELE LEGEND FOR GROUND FLOOR SITE PLAN:-		
SYM	DESCRIPTION	QTY.
	25X3 GI EARTHING	10 Nos.
	EARTHING STRIP	-----

PROJECT INFORMATION:		SITE ADDRESS :		KEY PLAN :		REVISION PARTICULARS:		STRUCTURAL CON	ARCHITECTS / INTERIOR DESIGNERS:		DRAWING TITLE:	
BHUU ARCHOLOGY									<div><div>EITHER OR</div><div>ARCHITECTURE</div><div>901, Matrix, Behind Divya Bhaskar, S G Highway, Ahmedabad - Gujarat - 54. eitheror.architecture@gmail.com, 9724694445</div></div>		ELE SPACE PLANNING & EARTHING DETAIL LAYOUT FOR SITE PLAN	
CLIENT :											SCALE: 1:250	
											DATE : 20/05/2026	
											SHEET NO.: 1 OF 3	
											REV.NO: R0	
											PROJ REF: ARC & CIVIL	
											DWN BY: DHARTI MISTRY	
											CHECKED BY: DHARTI MISTRY	
											APPROVED BY: ---	
											DRAWING NO: ELE:01	

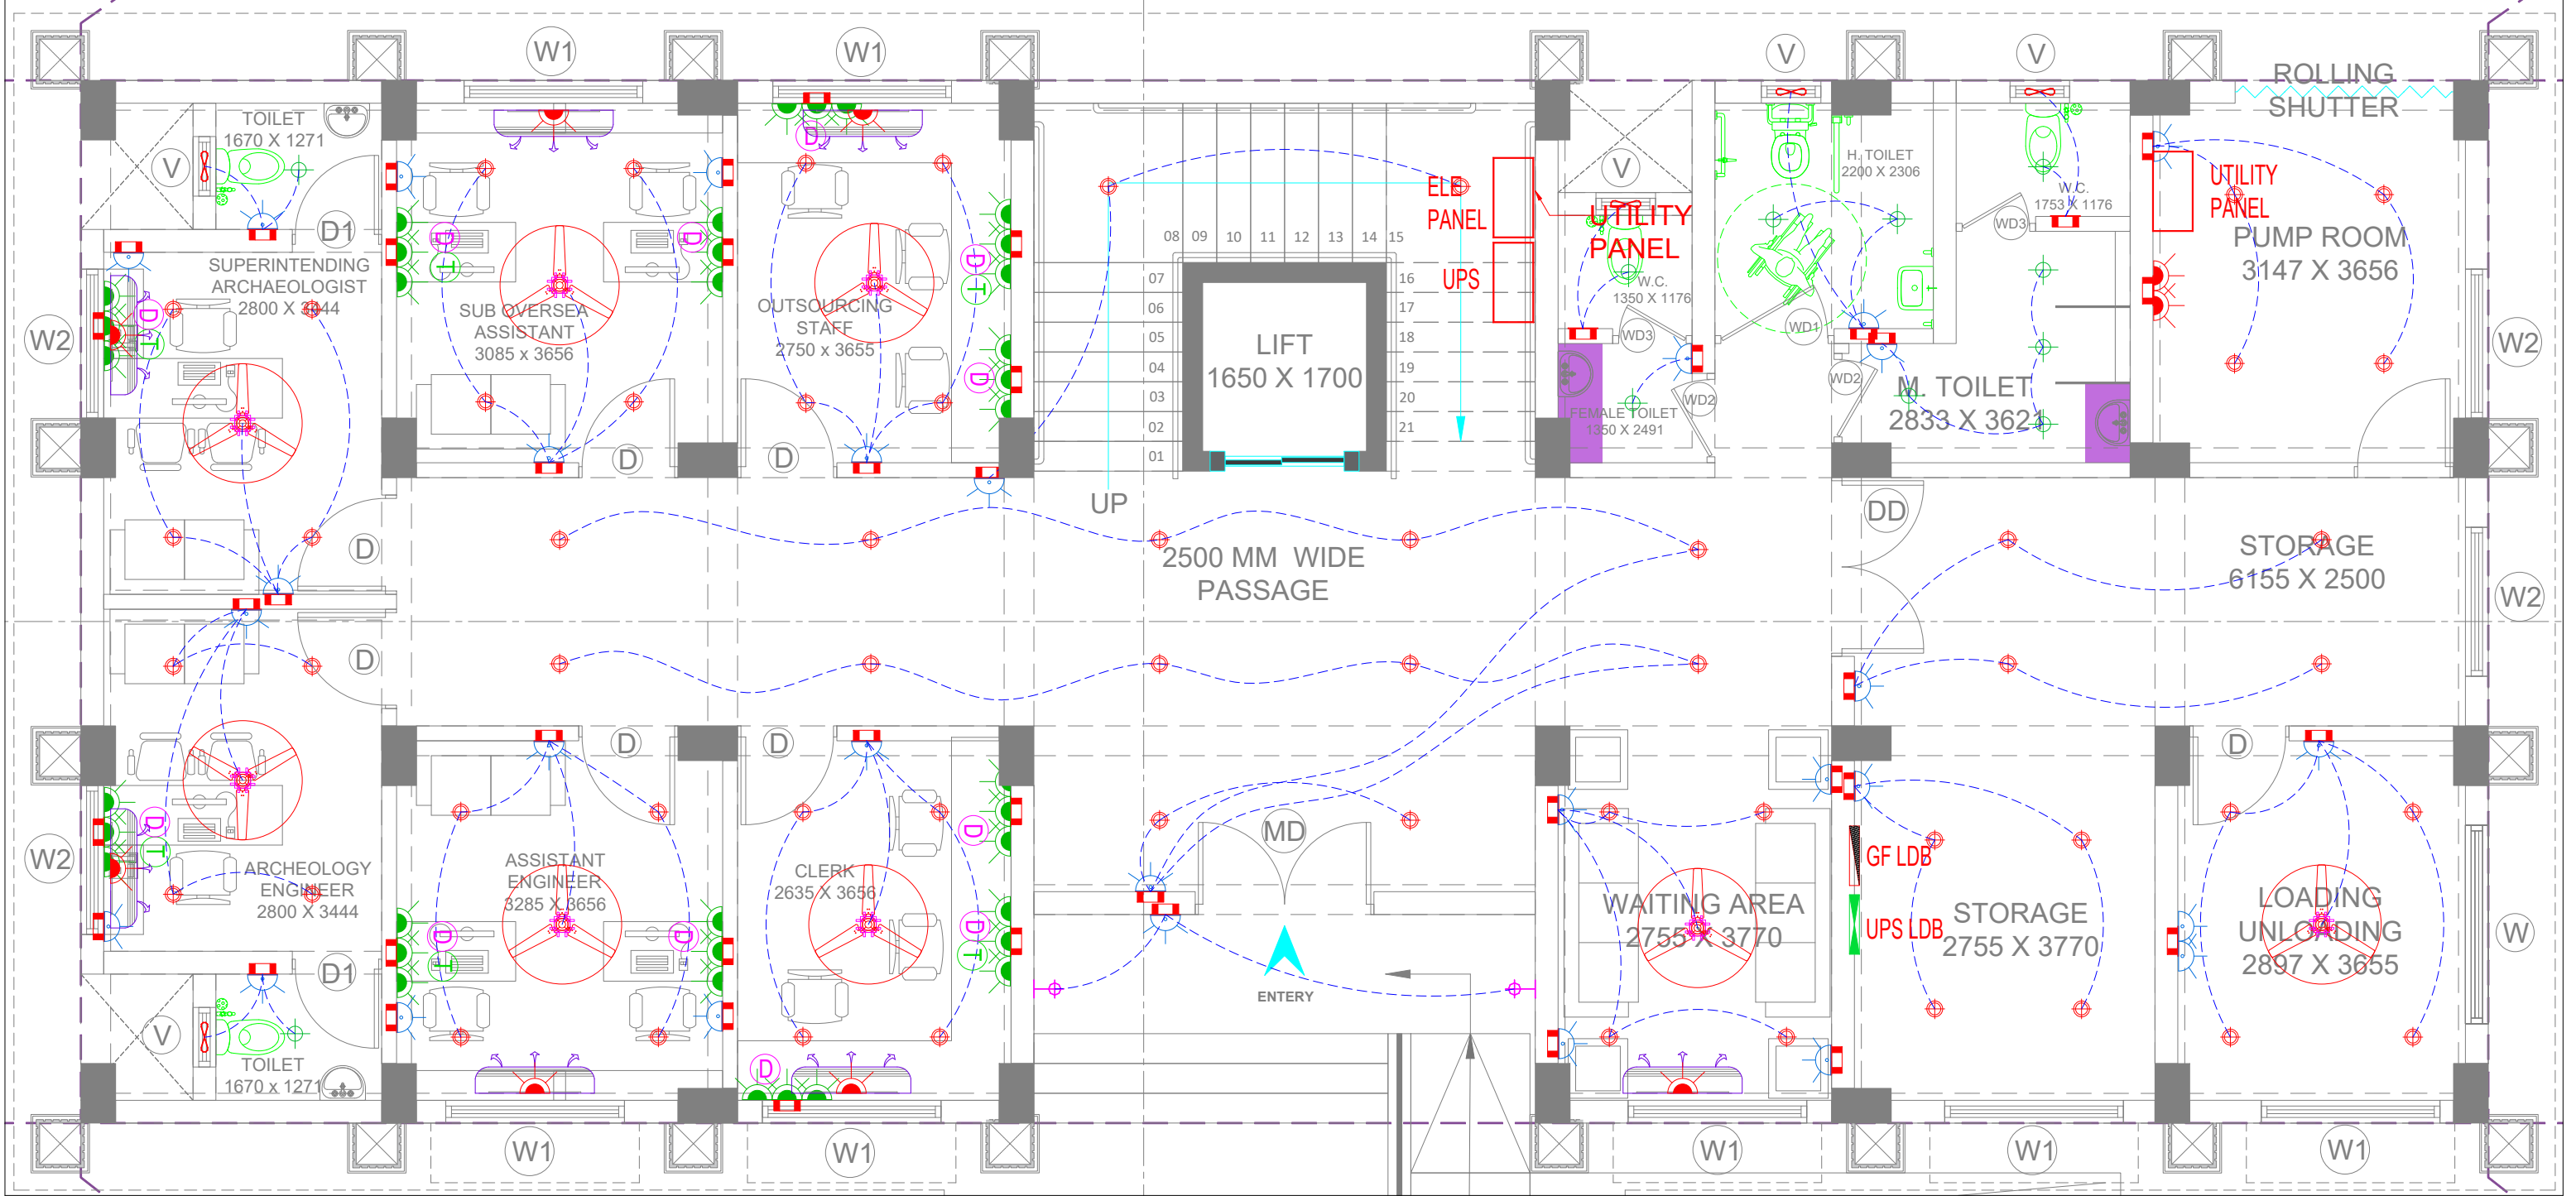

ELE LEGEND FOR GROUND FLOOR :-		
SYM	DESCRIPTION	QTY.
	1200mm CEILING FAN	08 Nos.
	8WAY FAN JUNCTION BOX	08 Nos.
	18W LED DOWN LIGHT	58 Nos.
	12W LED DOWN LIGHT	11 Nos.
	WALL LIGHT	02 Nos.
	5A POWER SOCKET	30 Nos.
	15A POWER SOCKET	10 Nos.
	SWITCH BOARD	44 Nos.
	EXHAUST FAN	05 Nos.
	LIGHTING DB	01 Nos.
	ELE CONTROL	-----
	2WAY CONTROL	-----


PROJECT INFORMATION:		SITE ADDRESS :			KEY PLAN :		REVISION PARTICULARS:				STRUCTURAL CON		ARCHITECTS / INTERIOR DESIGNERS:		DRAWING TITLE:																		
BHUIJ ARCHOLOGY													<div><div></div><div>EITHER OR ARCHITECTURE</div><div>901, Matrix, Behind Divya Bhaskar, S G Highway, Ahmedabad - Gujarat - 54. eitheror.architecture@gmail.com, 9724694445</div></div>		ELE LIGHTING CONTROL LAYOUT FOR GROUND FLOOR																		
CLIENT :						<table><tr><td></td><td></td><td></td><td></td></tr><tr><td>R0</td><td>20/05/26</td><td>D.M</td><td>---</td></tr><tr><td>SR.NO</td><td>DATE</td><td>Dm By</td><td>Revision</td></tr></table>								R0	20/05/26	D.M	---	SR.NO	DATE	Dm By	Revision	<div>M.E.P CONSULTANT</div> <div></div>		<div><div></div><div>EITHER OR ARCHITECTURE</div><div>901, Matrix, Behind Divya Bhaskar, S G Highway, Ahmedabad - Gujarat - 54. eitheror.architecture@gmail.com, 9724694445</div></div>		SCALE: 1:250		DWN BY:		CHECKED BY:		APPROVED BY:	
R0	20/05/26	D.M	---																														
SR.NO	DATE	Dm By	Revision																														
DATE :		20/05/2026		DHARTI MISTRY		DHARTI MISTRY		---																									
SHEET NO:		1 OF 3		DRAWING NO:		LTG-01																											
REV.NO:		R0																															
PROJ REF:		ARC & CIVIL																															

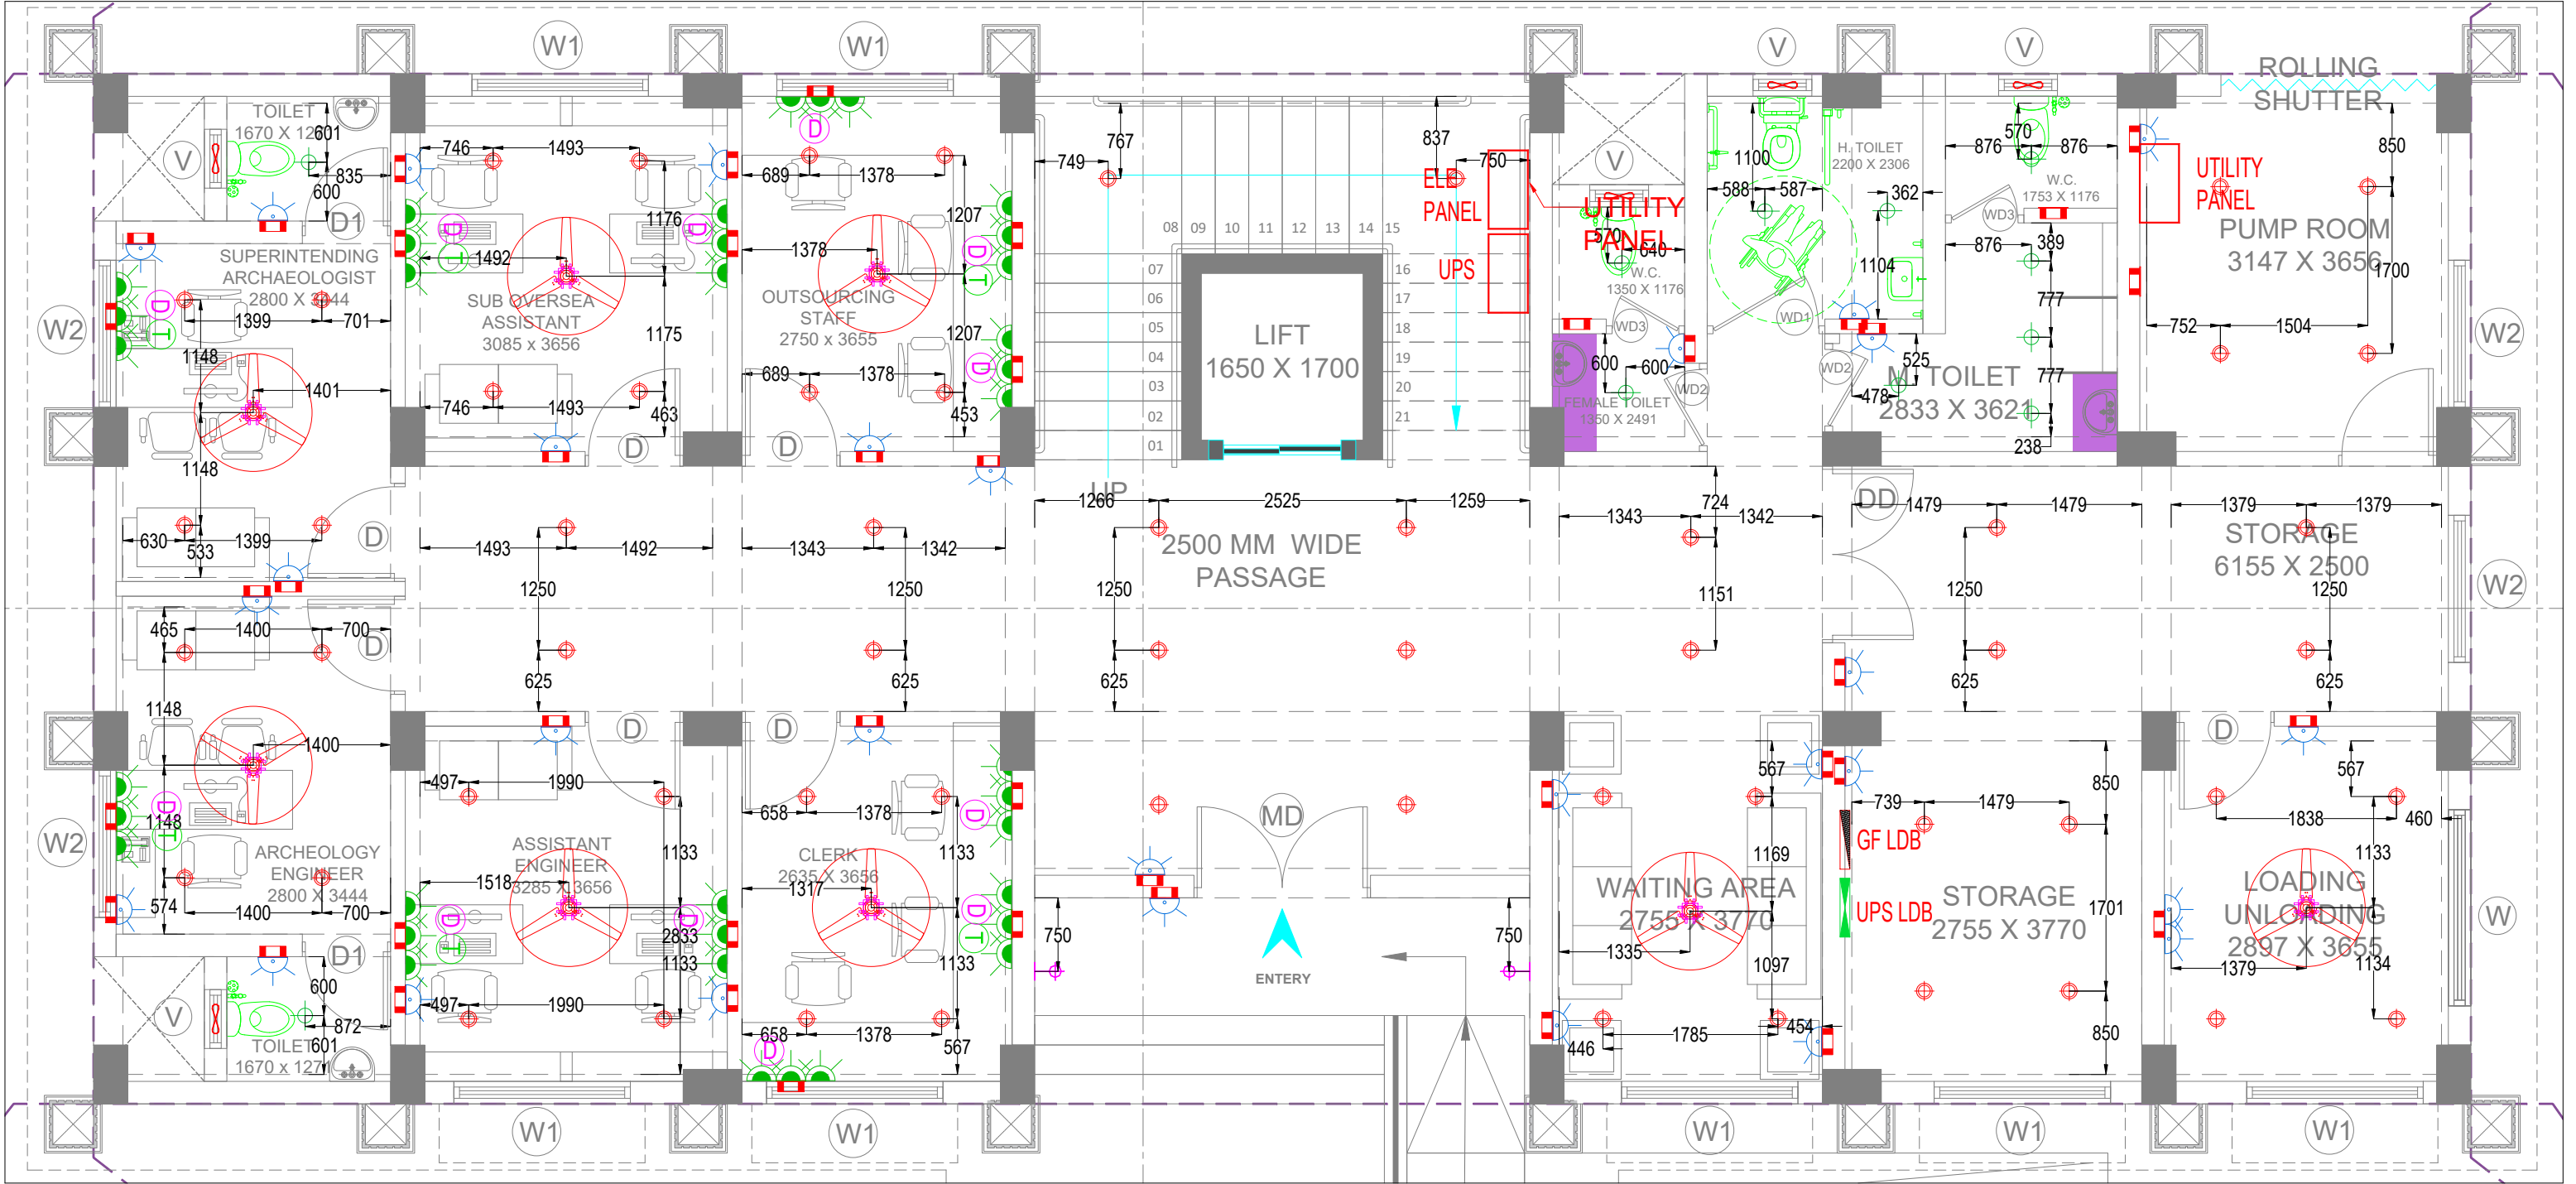

ELE LEGEND FOR GROUND FLOOR :-		
SYM	DESCRIPTION	QTY.
	1200mm CEILING FAN	08 Nos.
	8WAY FAN JUNCTION BOX	08 Nos.
	18W LED DOWN LIGHT	58 Nos.
	12W LED DOWN LIGHT	11 Nos.
	WALL LIGHT	02 Nos.
	5A POWER SOCKET	30 Nos.
	15A POWER SOCKET	10 Nos.
	SWITCH BOARD	44 Nos.
	EXHAUST FAN	05 Nos.
	LIGHTING DB	01 Nos.
	ELE CONTROL	-----
	2WAY CONTROL	-----

PROJECT INFORMATION:		SITE ADDRESS :				KEY PLAN :						REVISION PARTICULARS:				STRUCTURAL CON		ARCHITECTS / INTERIOR DESIGNERS:		DRAWING TITLE:											
BHUUJ ARCHOLOGY																		<div><div></div><div>EITHER OR ARCHITECTURE</div></div> <div>901, Matrix, Behind Divya Bhaskar, S G Highway, Ahmedabad - Gujarat - 54. eitheror.architecture@gmail.com, 9724694445</div>		ELE CEILING DIMENSION LAYOUT FOR GROUND FLOOR											
																				SCALE:		1:250		DWN BY:			CHECKED BY:		APPROVED BY:		
																				DATE :		20/05/2026		DHARTI MISTRY			DHARTI MISTRY		---		
		CLIENT :																		SHEET NO.:		DRAWING NO.:									
																				1 OF 3											
																				REV.NO:		R0									
																				CON:01											
																				PROJ REF:		ARC & CIVIL									


These drawings & designs are the sole property of EITHER OR ARCHITECTURE and as such shall not be reproduced in any form without express written permission of EITHER OR ARCHITECTURE. All drawings and related documents shall be returned to EITHER OR ARCHITECTURE upon request.

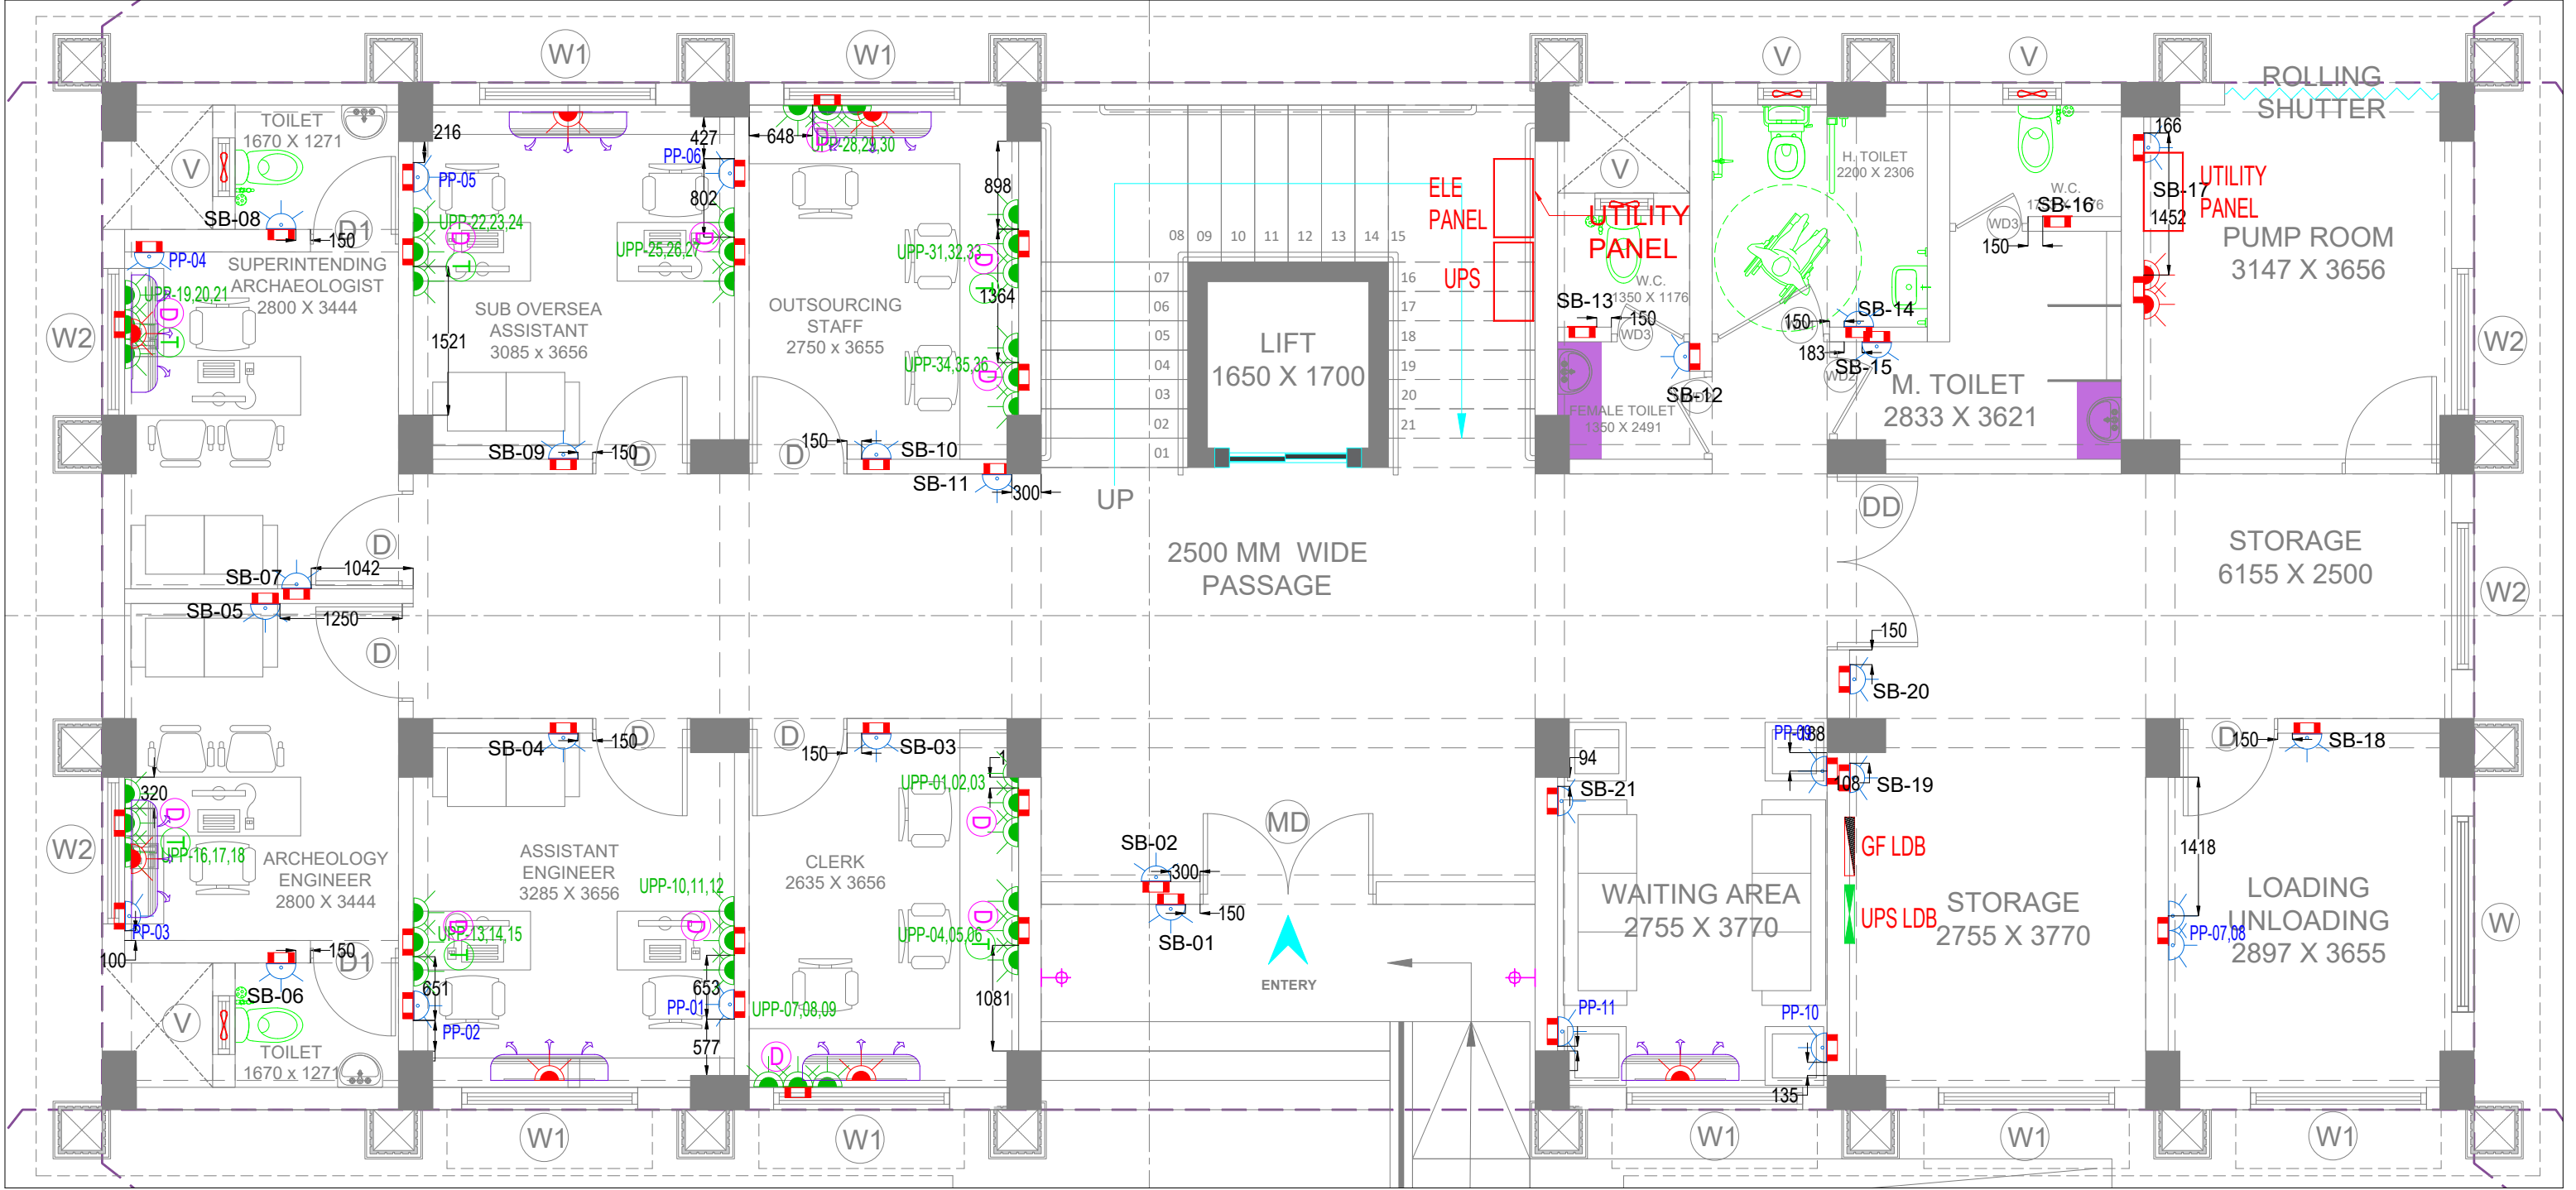

GROUND FLOOR SB DETAIL


SB NO	MODULE	HEIGHT	SB NO	MODULE	HEIGHT	PP NO	MODULE	HEIGHT	UPP NO	MODULE	HEIGHT
SB1	6	4'	SB12	4	4'	PP1	3	3'	UPP1,2,3	8	AT FURNITURE
SB2	6	4'	SB13	2	4'	PP2	3	3'	UPP4,5,6	8	
SB3	8	4'	SB14	6	4'	PP3	3	3'	UPP7,8,9	8	
SB4	8	4'	SB15	4	4'	PP4	3	3'	UPP10,11,12	8	
SB5	8	4'	SB16	2	4'	PP5	3	3'	UPP13,14,15	8	
SB6	6	4'	SB17	6	4'	PP6	3	3'	UPP16,17,18	8	
SB7	8	4'	SB18	8	4'	PP7,8	6	4'	UPP19,20,21	8	
SB8	6	4'	SB19	6	4'	PP9,10	6	4'	UPP22,23,24	8	
SB9	8	4'	SB20	6	4'	PP11	3	3'	UPP25,26,27	8	
SB10	8	4'	SB21	8	3'	PP12	3	3'	UPP28,29,30	8	
SB11	4	4'				PP13	3	3'	UPP31,32,33	8	
									UPP34,35,36	8	

PROJECT INFORMATION:		SITE ADDRESS :				KEY PLAN :				REVISION PARTICULARS:				STRUCTURAL CON		ARCHITECTS / INTERIOR DESIGNERS:				DRAWING TITLE:															
BHUIJ ARCHOLOGY																<div><div></div><div>D.V. TECH ENGINEERS</div></div>		<div><div><div></div><div>EITHER OR ARCHITECTURE</div></div><div>901, Matrix, Behind Divya Bhaskar, S G Highway, Ahmedabad - Gujarat - 54. eitheror.architecture@gmail.com, 9724694445</div></div>				ELE SB DETAIL LAYOUT FOR GROUND FLOOR													
																												M.E.P CONSULTANT							
																												R0		20/05/26		D.M		---	
																												SR.NO		DATE		Drn By		Revision	
CLIENT :																				SCALE: 1:250				DWN BY:		CHECKED BY:		APPROVED B							
																				DATE : 20/05/2026		DHARTI MISTRY		DHARTI MISTRY		---									
																				SHEET NO: 1 OF 3		DRAWING NO:													
																				REV.NO: R0															
																				CON:02															
																				PROJ REF: ARC & CIVIL															

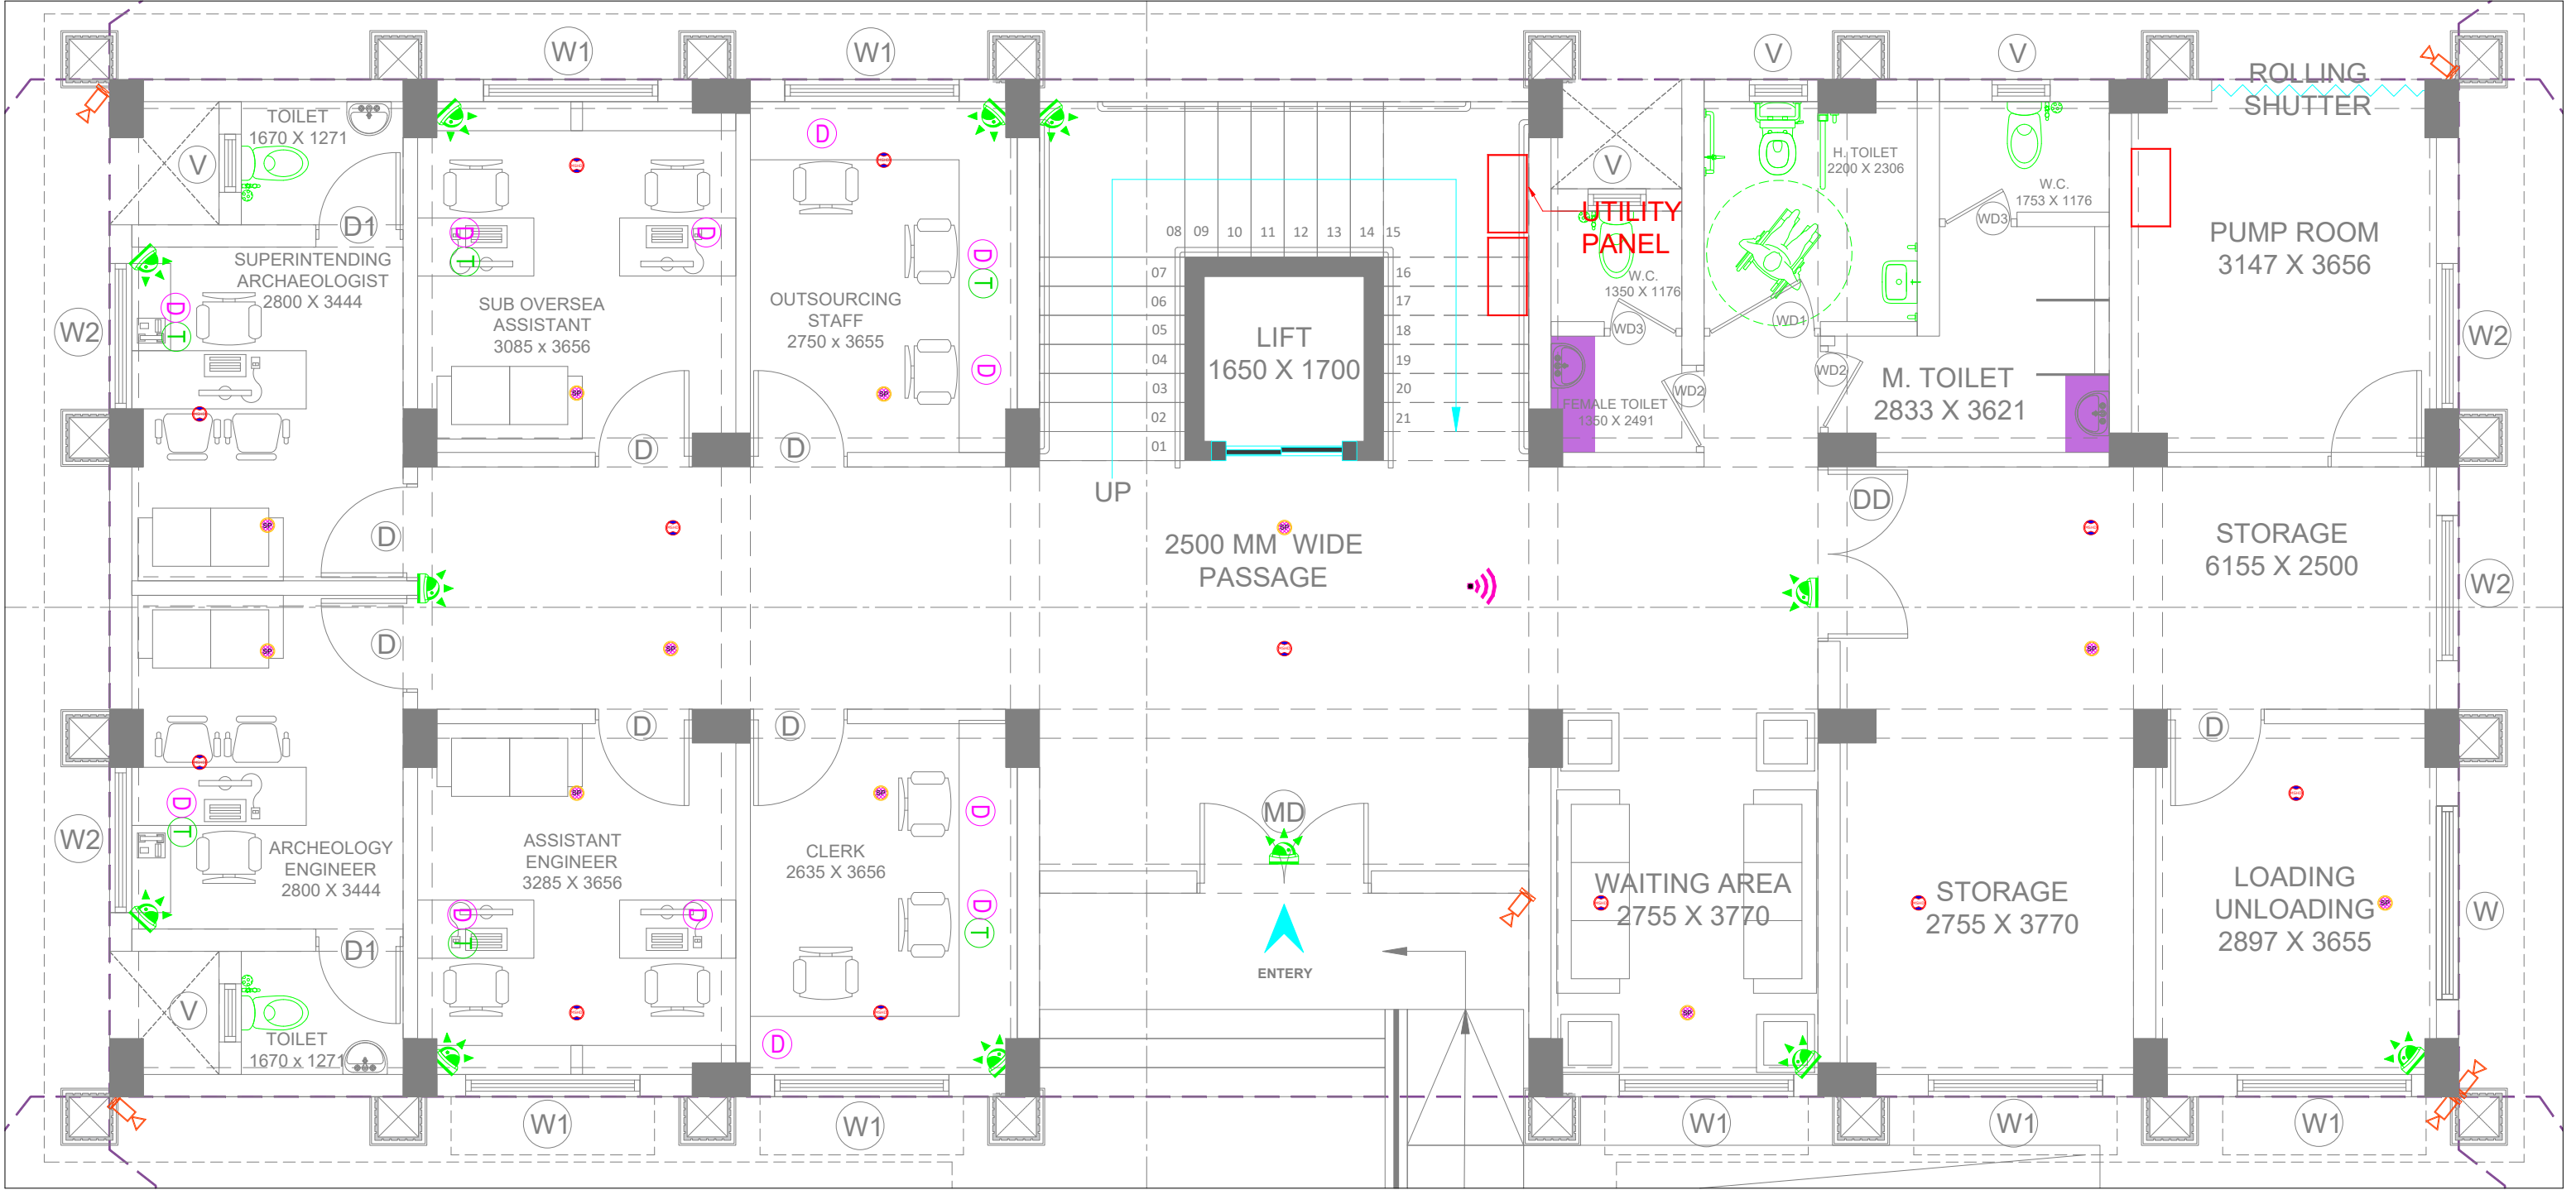

ELV LEGEND FOR GROUND FLOOR :-		
SYM	DESCRIPTION	QTY.
	CCTV CAMERA (DOME)	12 Nos.
	CCTV CAMERA (BULLET)	06 Nos.
	PA SYSTEM	11 Nos.
	WIFI POINT	01 Nos.
	SMOKE DETECTOR	12 Nos.
	TELEPHONE POINT	06 Nos.
	DATA POINT	12 Nos.

PROJECT INFORMATION:		SITE ADDRESS :				KEY PLAN :				REVISION PARTICULARS:		STRUCTURAL CON		ARCHITECTS / INTERIOR DESIGNERS:		DRAWING TITLE:									
BHUIJ ARCHOLOGY														<div><div></div><div>EITHER OR ARCHITECTURE</div><div>901, Matrix, Behind Divya Bhaskar, S G Highway, Ahmedabad - Gujarat - 54. eitheror.architecture@gmail.com, 9724694445</div></div>		ELV LAYOUT FOR GROUND FLOOR									
		CLIENT :												M.E.P CONSULTANT		<div><div></div><div>D.V. TECH ENGINEERS</div></div>		SCALE:		1:250		DWN BY:		CHECKED BY:	
DATE :		20/05/2026		DHARTI MISTRY		DHARTI MISTRY		---																	
SHEET NO :		1 OF 3		DRAWING NO:																					
REV.NO:		R0																ELV:01							
PROJ REF:		ARC & CIVIL																							
R0		20/05/26		D.M		---																			
SR.NO		DATE		Dm By		Revision																			

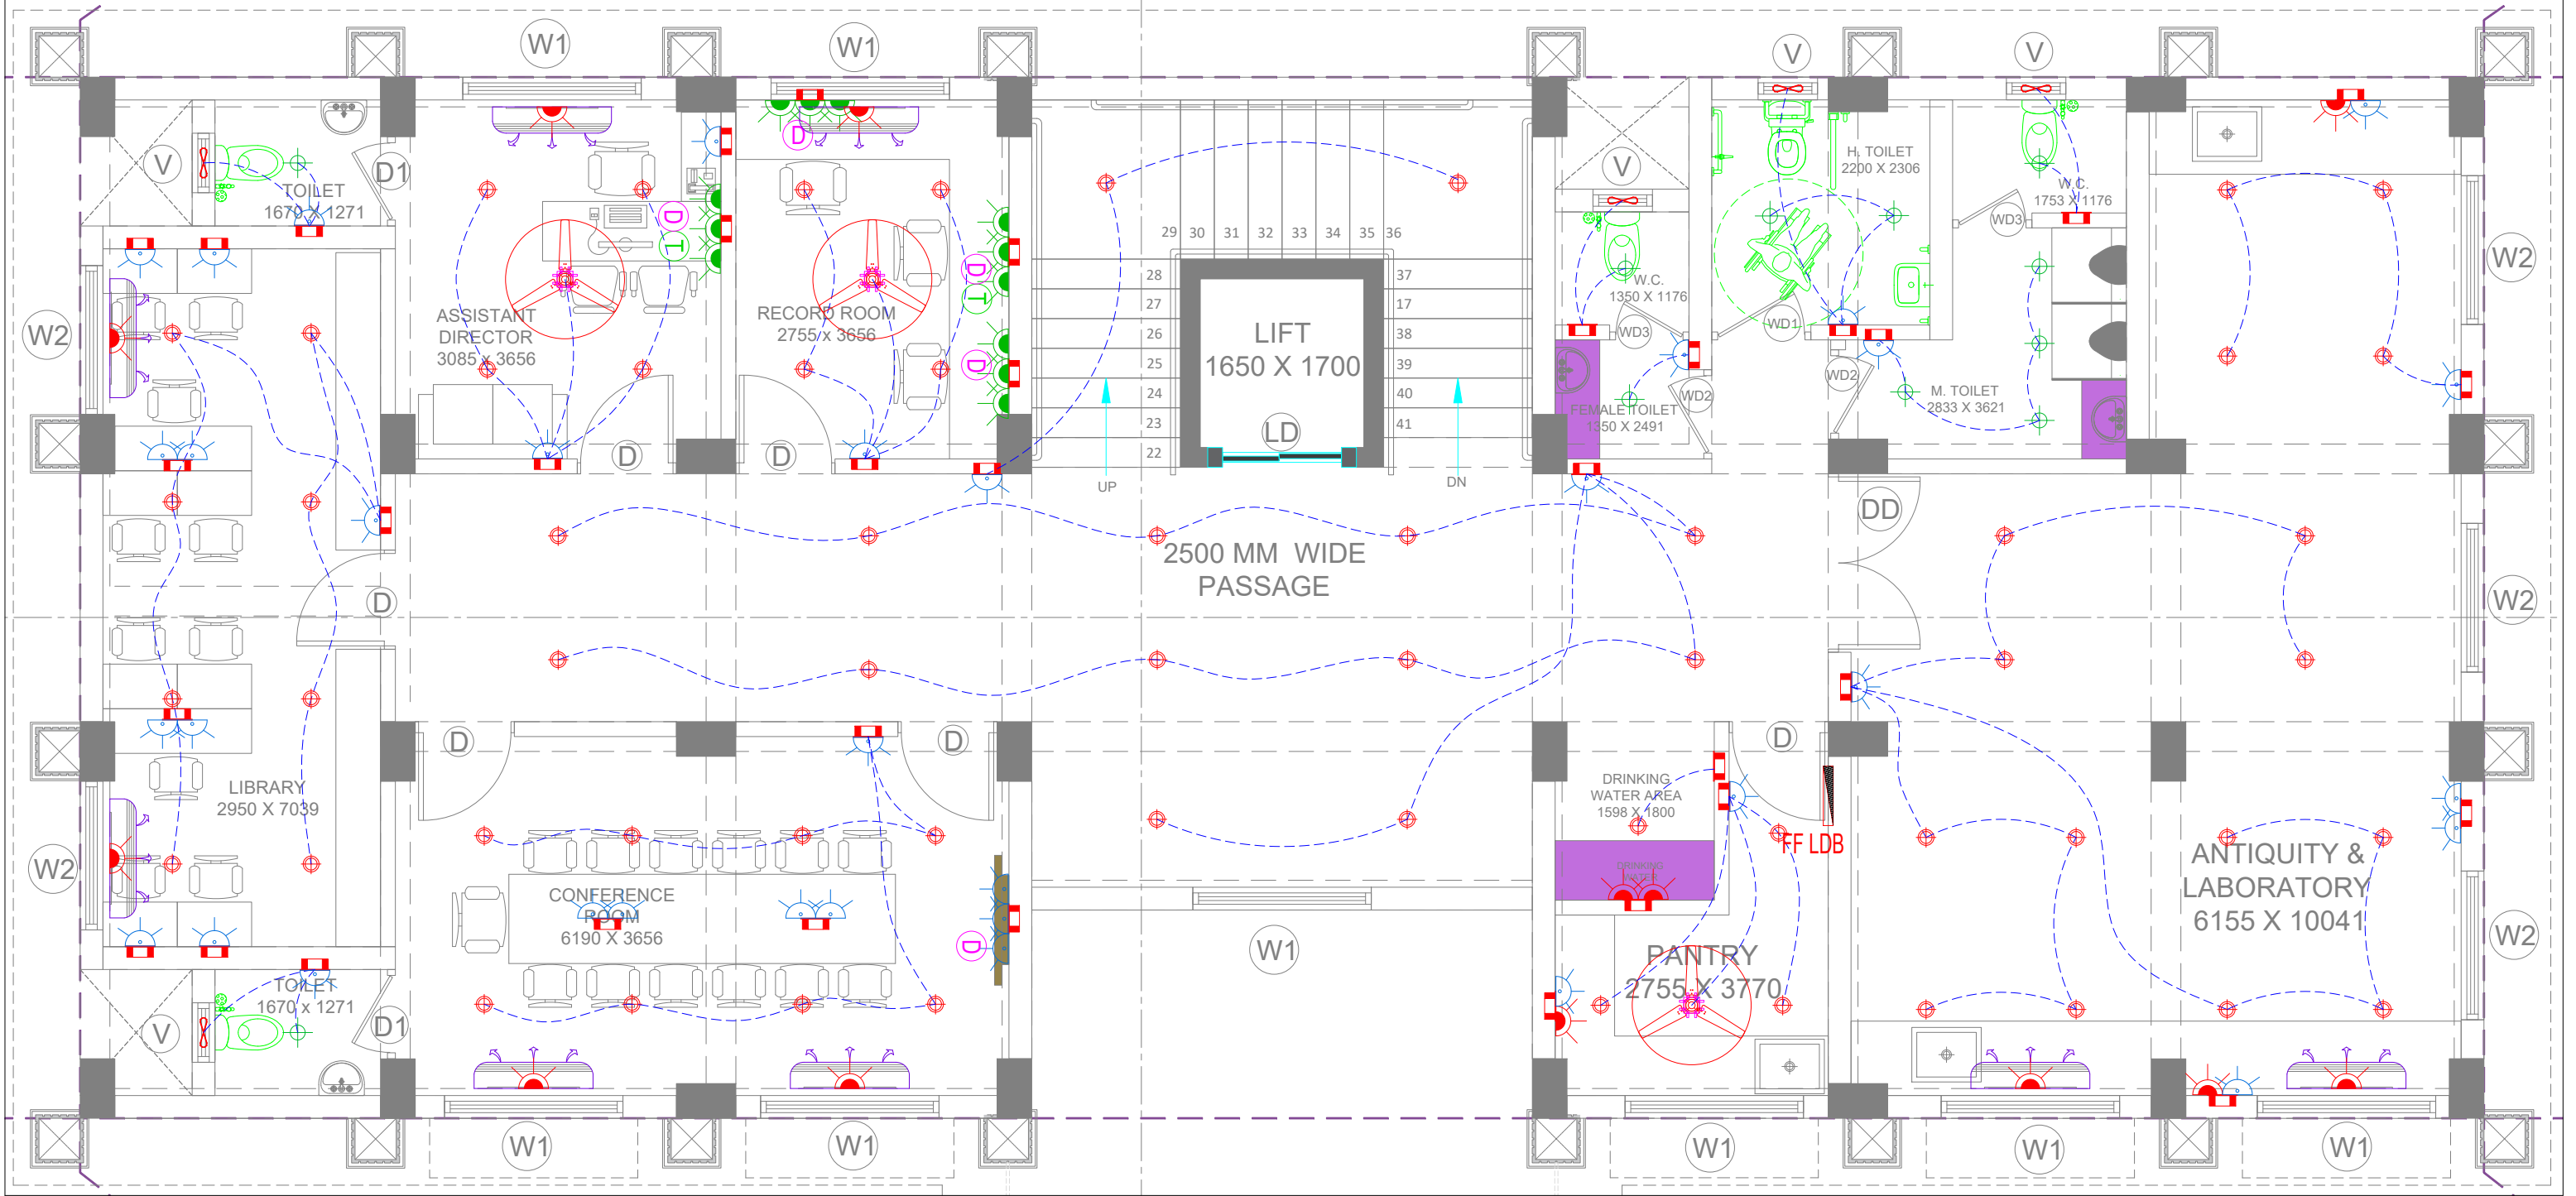


ELE LEGEND FOR FIRST FLOOR :-

SYM	DESCRIPTION	QTY.
	1200mm CEILING FAN	03 Nos.
	8WAY FAN JUNCTION BOX	03 Nos.
	18W LED DOWN LIGHT	58 Nos.
	12W LED DOWN LIGHT	11 Nos.
	WALL LIGHT	-- Nos.
	5A POWER SOCKET	35 Nos.
	15A POWER SOCKET	13 Nos.
	SWITCH BOARD	36 Nos.
	EXHAUST FAN	05 Nos.
	LIGHTING DB	01 Nos.
	NORMAL CONTROL	-----
	2WAY CONTROL	-----


PROJECT INFORMATION:		SITE ADDRESS :				KEY PLAN :				REVISION PARTICULARS:		STRUCTURAL CON		ARCHITECTS / INTERIOR DESIGNERS:		DRAWING TITLE:					
BHUIJ ARCHOLOGY														<div><div></div><div>EITHER OR ARCHITECTURE</div></div> <div>901, Matrix, Behind Divya Bhaskar, S G Highway, Ahmedabad - Gujarat - 54. eitheror.architecture@gmail.com, 9724694445</div>		ELE LIGHTING CONTROL LAYOUT FOR FIRST FLOOR					
		CLIENT :										R0		20/05/26		D.M		---		<div><div></div><div>D.V. TECH ENGINEERS</div></div>	
				SR.NO		DATE		Dm By		Revision											

These drawings & designs are the sole property of EITHER OR ARCHITECTURE and as such shall not be reproduced in any form without express written permission of EITHER OR ARCHITECTURE. All drawings and related documents shall be returned to EITHER OR ARCHITECTURE upon request.

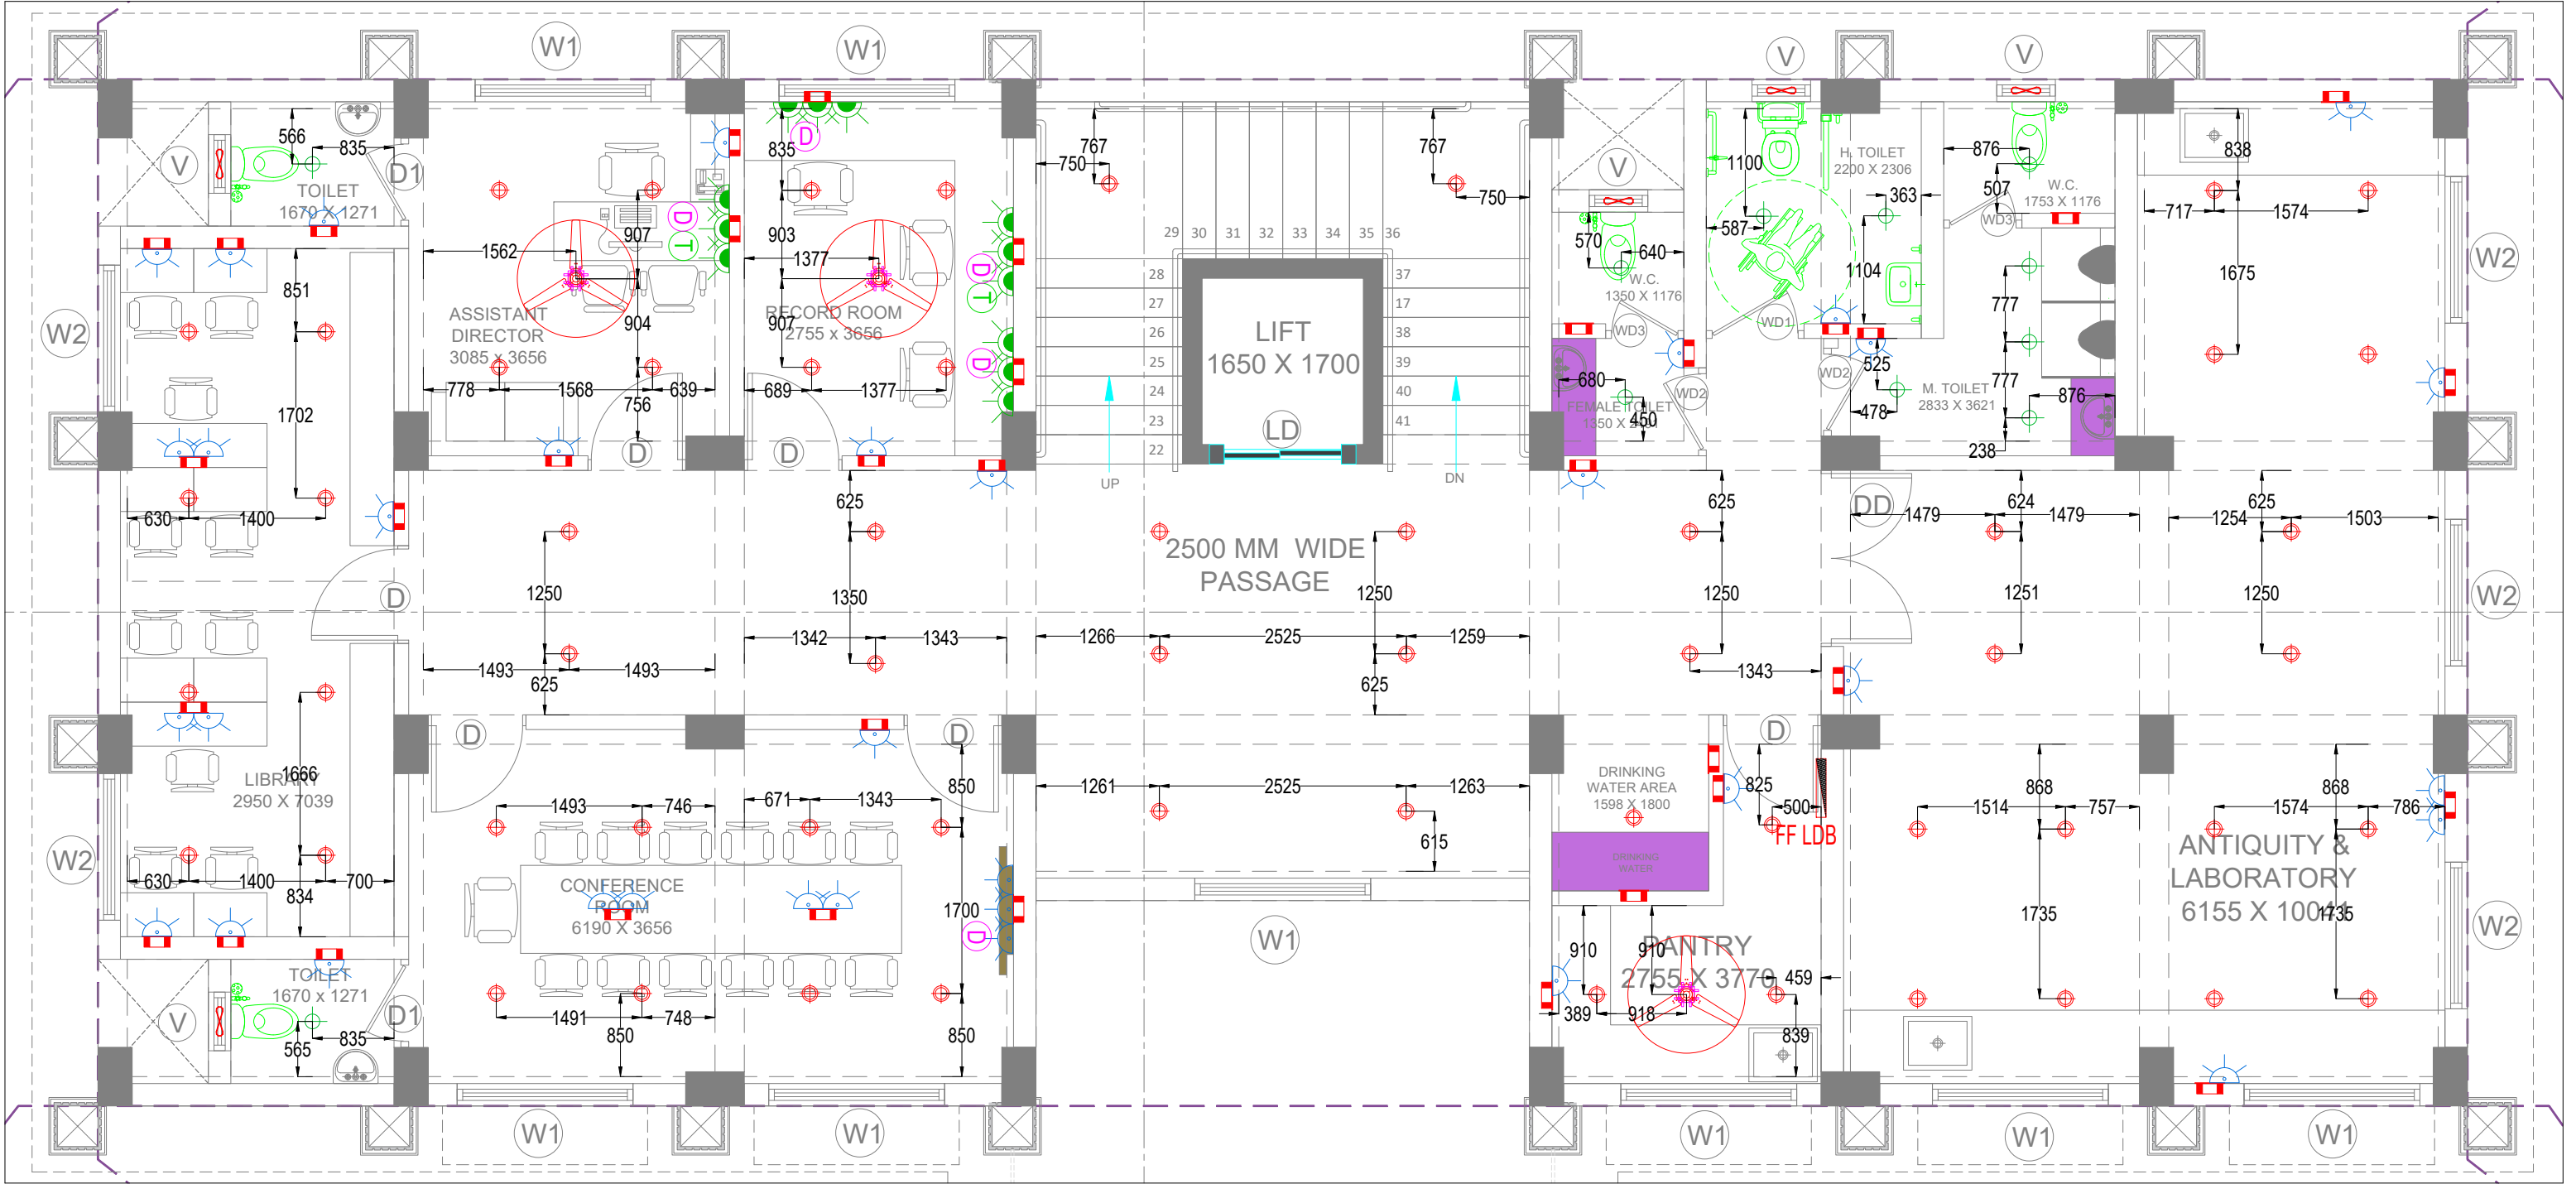

ELE LEGEND FOR FIRST FLOOR :-		
SYM	DESCRIPTION	QTY.
	1200mm CEILING FAN	03 Nos.
	8WAY FAN JUNCTION BOX	03 Nos.
	18W LED DOWN LIGHT	58 Nos.
	12W LED DOWN LIGHT	11 Nos.
	WALL LIGHT	-- Nos.
	5A POWER SOCKET	35 Nos.
	15A POWER SOCKET	13 Nos.
	SWITCH BOARD	36 Nos.
	EXHAUST FAN	05 Nos.
	LIGHTING DB	01 Nos.
	NORMAL CONTROL	-----
	2WAY CONTROL	-----

PROJECT INFORMATION:		SITE ADDRESS :				KEY PLAN :				REVISION PARTICULARS:				STRUCTURAL CON		ARCHITECTS / INTERIOR DESIGNERS:		DRAWING TITLE:										
BHUIJ ARCHOLOGY																		<div><div></div><div>EITHER OR ARCHITECTURE</div><div>901, Matrix, Behind Divya Bhaskar, S G Highway, Ahmedabad - Gujarat - 54. eitheror.architecture@gmail.com, 9724694445</div></div>		ELE CEILING DIMENSION LAYOUT FOR FIRST FLOOR								
		CLIENT :										M.E.P CONSULTANT		<div><div></div><div>D.V. TECH ENGINEERS</div></div>				SCALE: 1:250					DWN BY:		CHECKED BY:		APPROVED B	
										R0 20/05/26 D.M ---								DATE : 20/05/2026		DHARTI MISTRY		DHARTI MISTRY		---				
										SR.NO DATE Dm By Revision								SHEET NO : 1 OF 3		DRAWING NO:								
																		REV.NO: R0		CON:01								
																		PROJ REF: ARC & CIVIL										

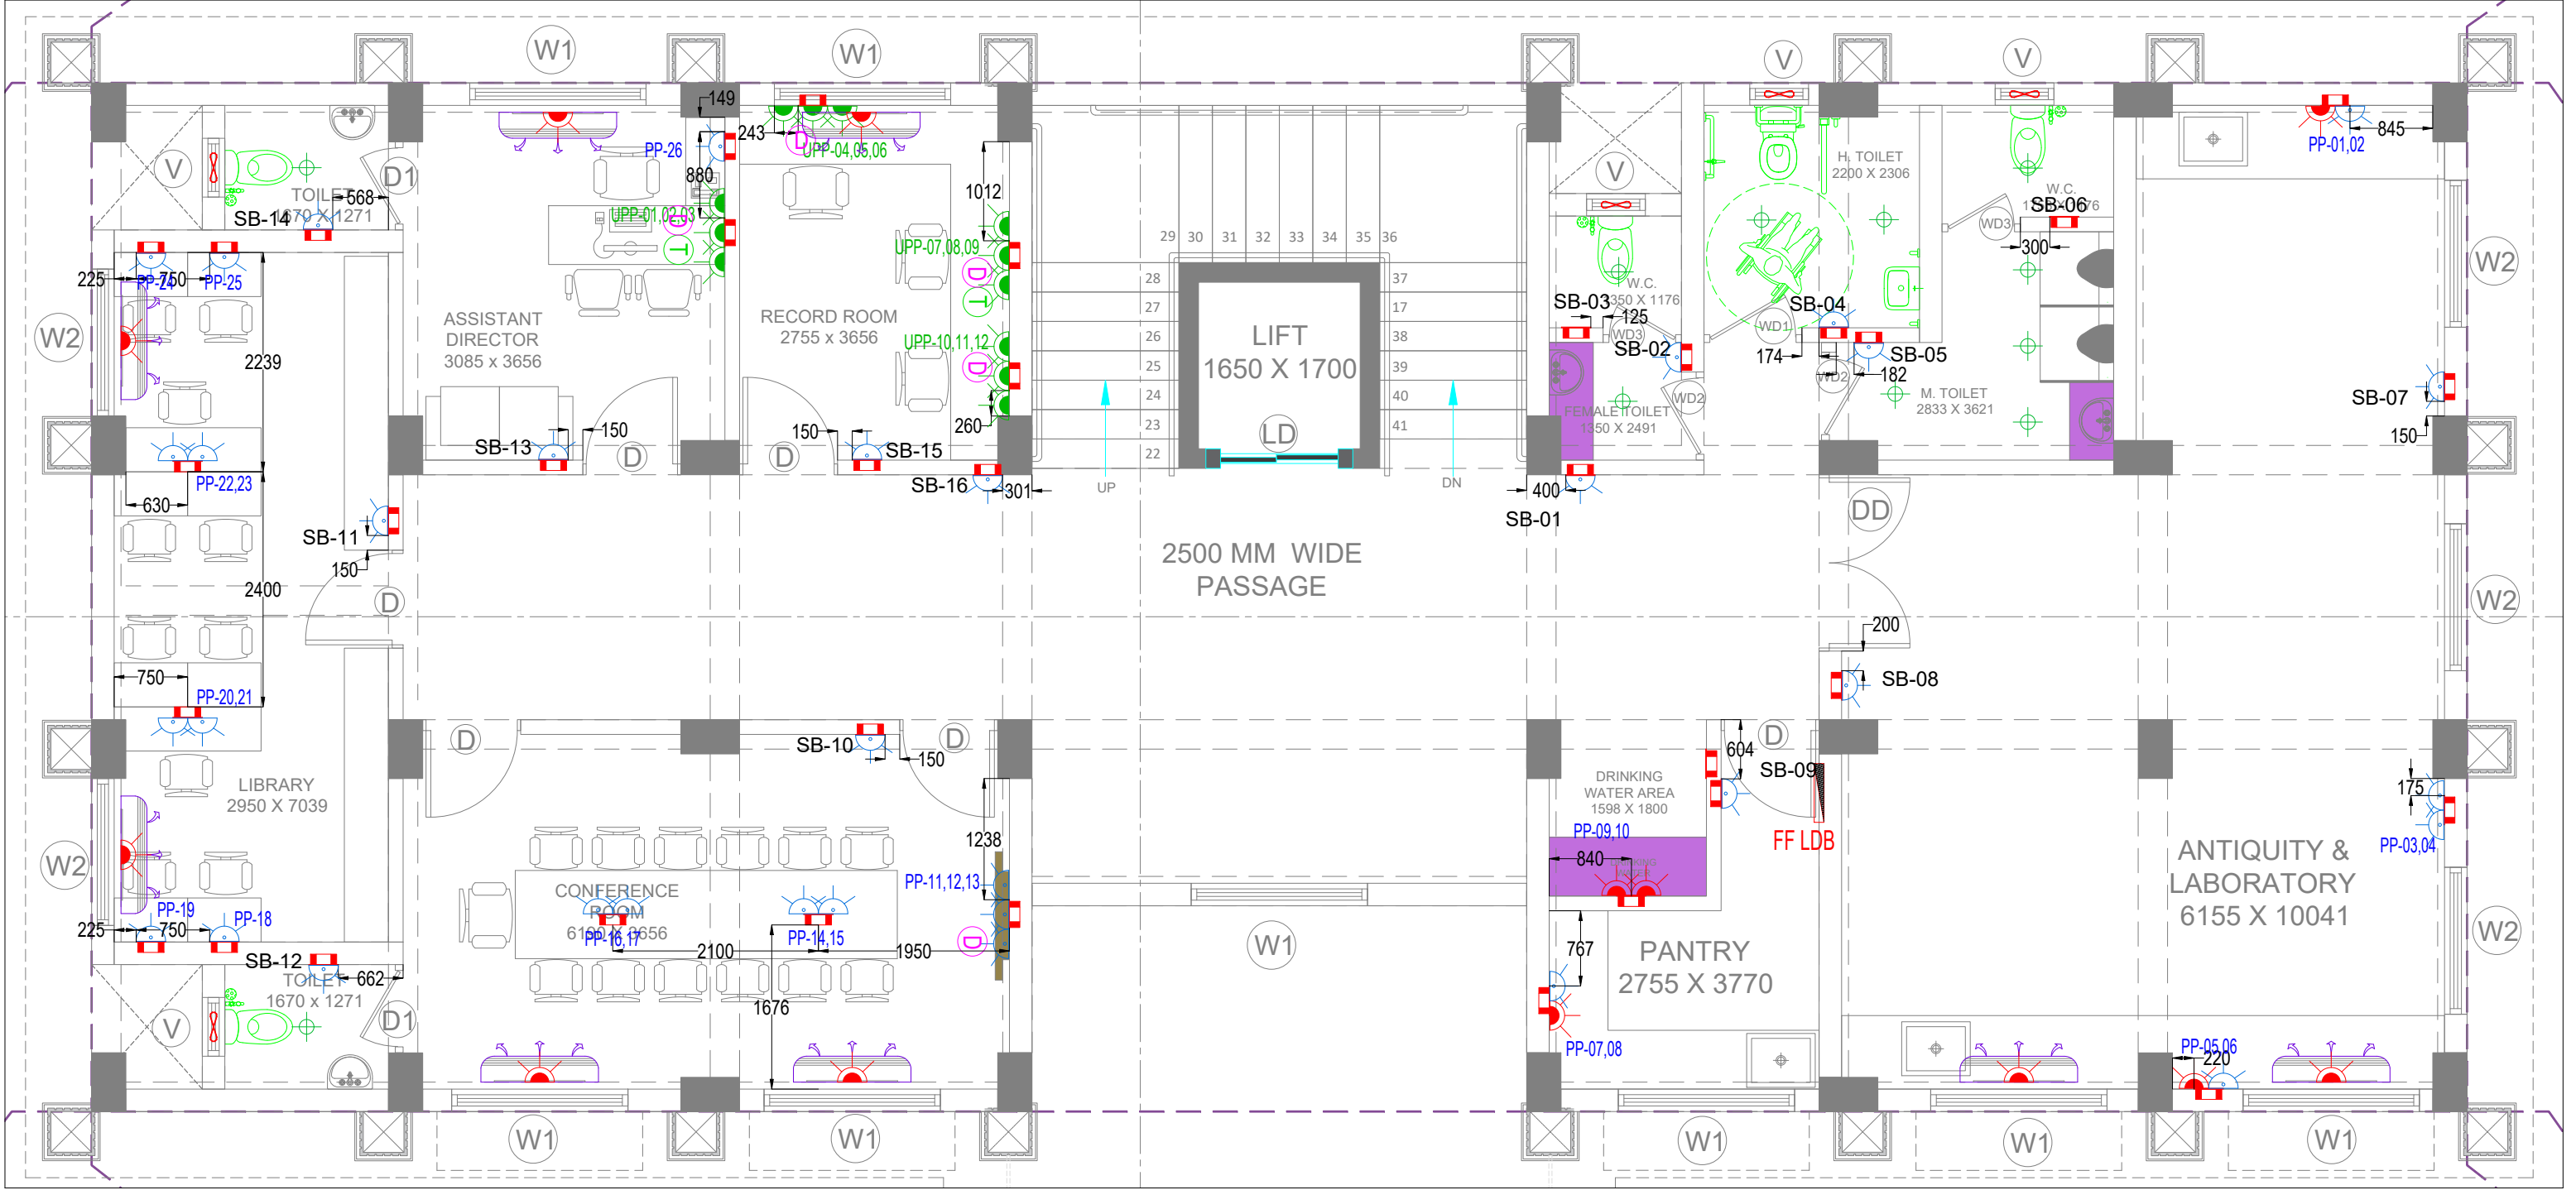


FIRST FLOOR SB DETAIL

SB NO	MODULE	HEIGHT	SB NO	MODULE	HEIGHT	PP NO	MODULE	HEIGHT	PP NO	MODULE	HEIGHT	UPP NO	MODULE	HEIGHT
SB1	6	4'	SB9	8	4'	PP1,2	6	4'	PP16,17	6	AT FURNITURE	UPP1,2,3	8	3'
SB2	1	4'	SB10	6	4'	PP3,4	6	4'	PP18	3		UPP4,5,6	8	3'
SB3	2	4'	SB11	6	4'	PP5,6	6	4'	PP19	3		UPP7,8,9	8	3'
SB4	2	4'	SB12	2	4'	PP7,8	6	4'	PP20,21	6		UPP10,11,12	8	3'
SB5	1	4'	SB13	8	4'	PP9,10	6	5'	PP22,23	6				
SB6	2	4'	SB14	2	4'	PP11,12,13	4	4'	PP24	3				
SB7	4	4'	SB15	8	4'		6	2'	PP25	3				
SB8	6	4'	SB16	4	4'	PP14,15	6	AT FURNITURE	PP26	3				

PROJECT INFORMATION:		SITE ADDRESS :		KEY PLAN :		REVISION PARTICULARS:		STRUCTURAL CON	ARCHITECTS / INTERIOR DESIGNERS:		DRAWING TITLE:	
BHUIJ ARCHOLOGY									<div>EITHER OR ARCHITECTURE</div> <div>901, Matrix, Behind Divya Bhaskar, S G Highway, Ahmedabad - Gujarat - 54. eitheror.architecture@gmail.com, 9724694445</div>		ELE SB DETAIL LAYOUT FOR FIRST FLOOR	
CLIENT :								M.E.P CONSULTANT			SCALE: 1:250	
											DATE :	20/05/2026
											SHEET NO.:	1 OF 3
											REV.NO:	R0
											PROJ REF:	ARC & CIVIL
											DWN BY:	DHARTI MISTRY
											CHECKED BY:	DHARTI MISTRY
											APPROVED BY:	---


These drawings & designs are the sole property of EITHER OR ARCHITECTURE and as such shall not be reproduced in any form without express written permission of EITHER OR ARCHITECTURE. All drawings and related documents shall be returned to EITHER OR ARCHITECTURE upon request.

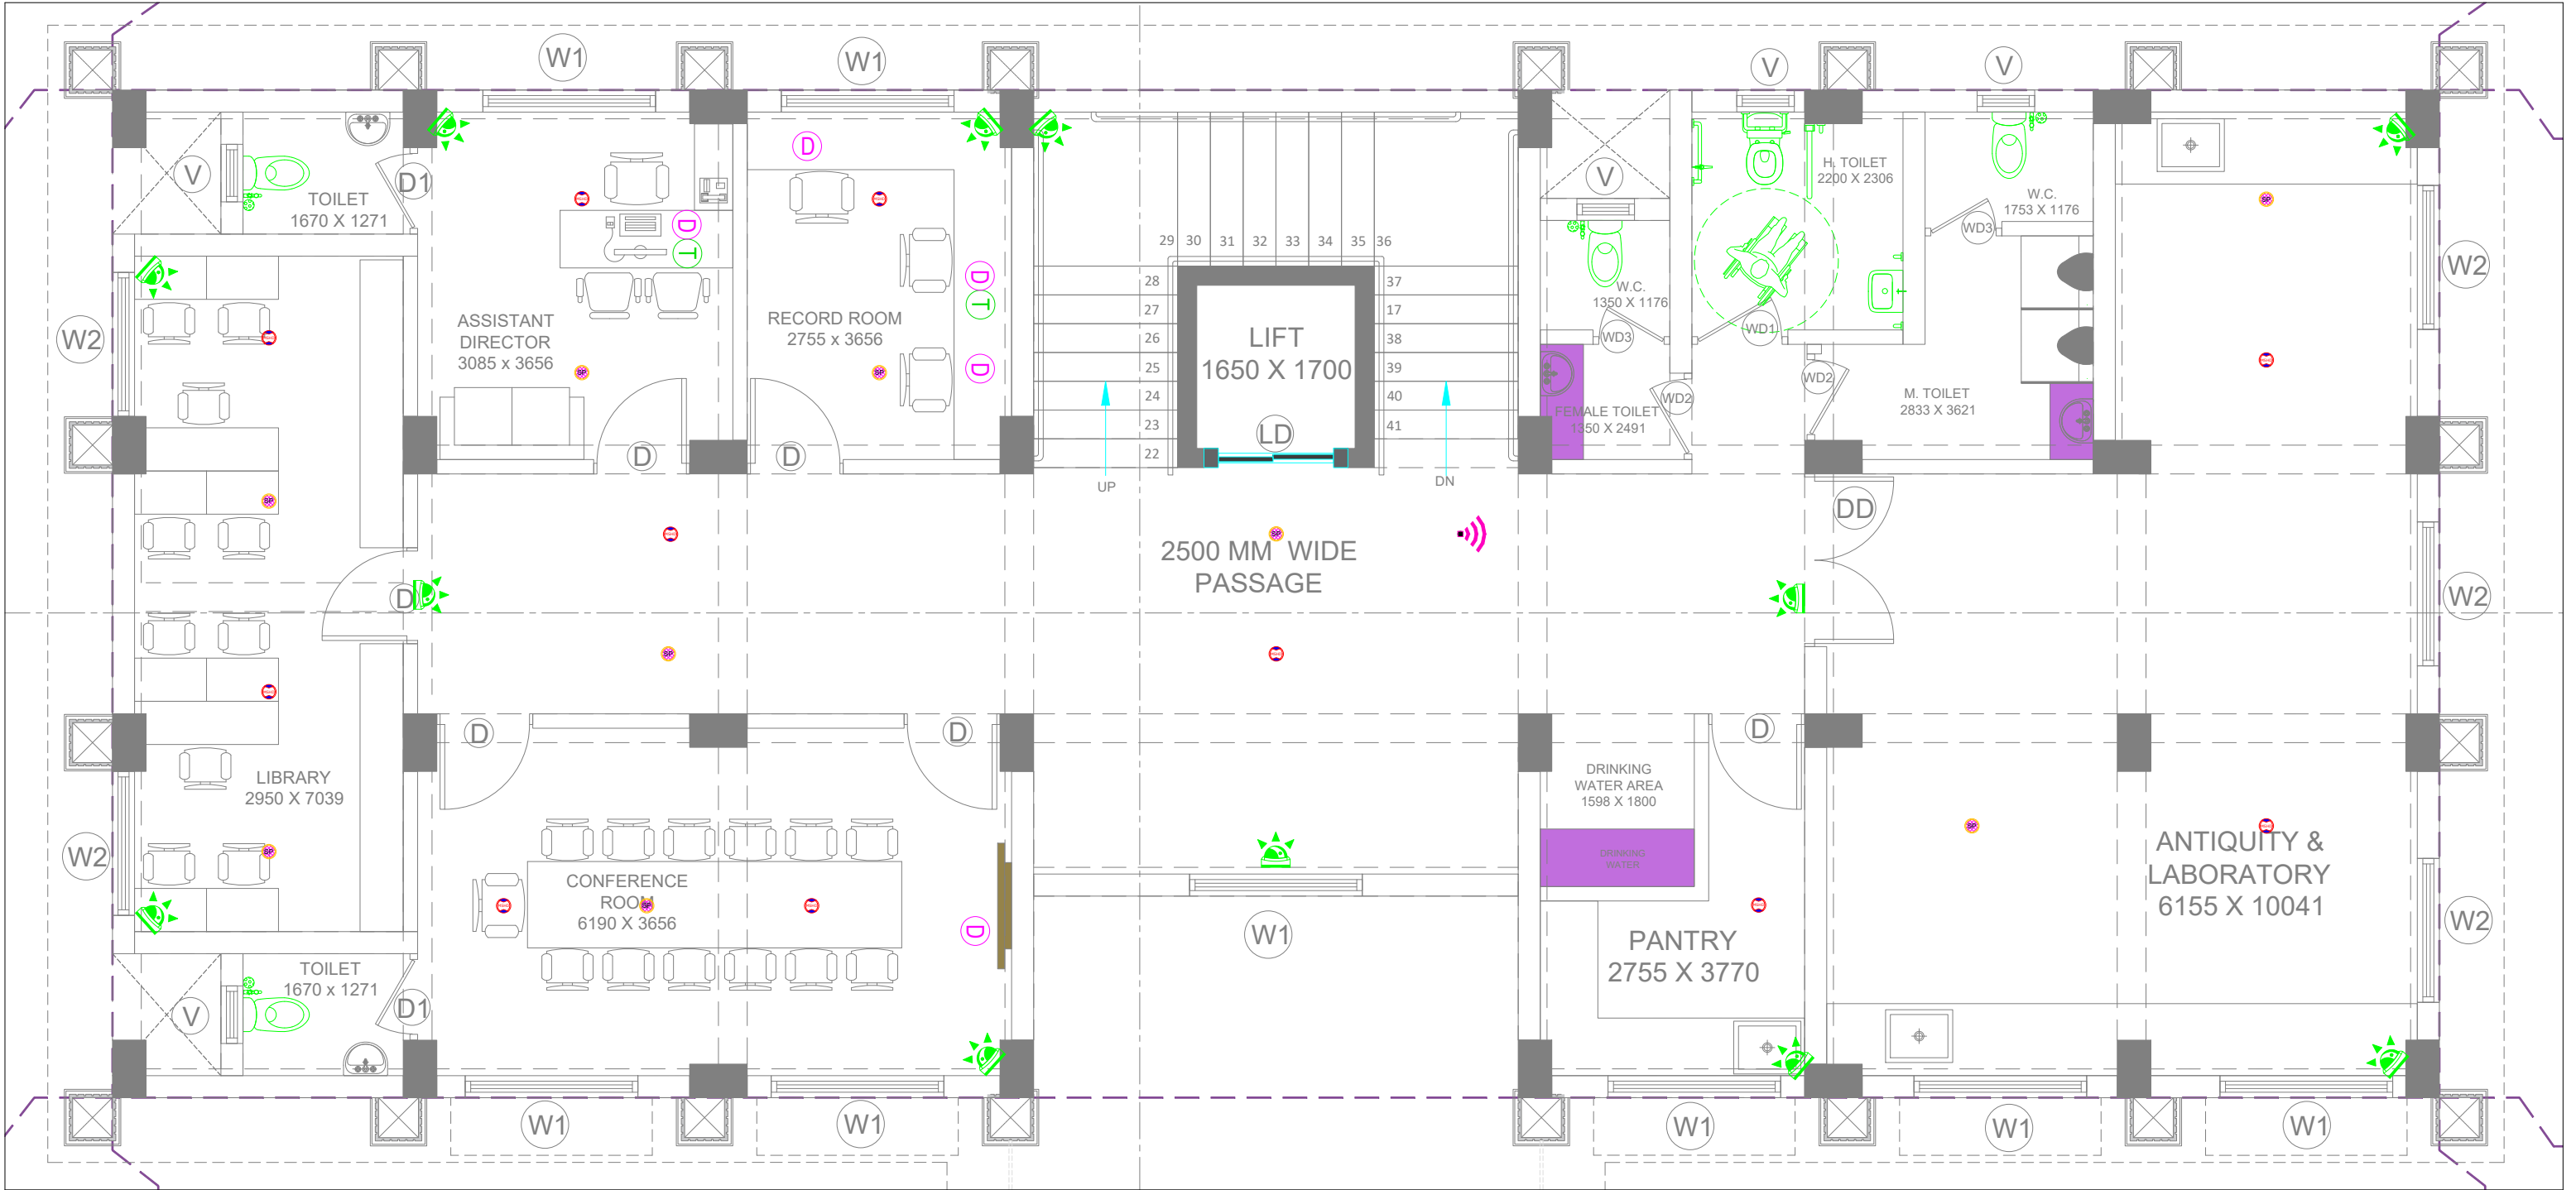

ELV LEGEND FOR FIRST FLOOR :-		
SYM	DESCRIPTION	QTY.
	CCTV CAMERA (DOME)	12 Nos.
	CCTV CAMERA (BULLET)	00 Nos.
	PA SYSTEM	09 Nos.
	WIFI POINT	01 Nos.
	SMOKE DETECTOR	11 Nos.
	TELEPHONE POINT	02 Nos.
	DATA POINT	05 Nos.


PROJECT INFORMATION:	SITE ADDRESS :		KEY PLAN :		REVISION PARTICULARS:				STRUCTURAL CON	ARCHITECTS / INTERIOR DESIGNERS:	DRAWING TITLE:							
BHUIJ ARCHOLOGY												<div><div></div><div>EITHER OR ARCHITECTURE</div><div>901, Matrix, Behind Divya Bhaskar, S G Highway, Ahmedabad - Gujarat - 54. eitheror.architecture@gmail.com, 9724694445</div></div>	ELV LAYOUT FOR FIRST FLOOR					
	CLIENT :									M.E.P CONSULTANT								
					R0	20/05/26	D.M	---										
					SR.NO	DATE	Dm By	Revision										

These drawings & designs are the sole property of EITHER OR ARCHITECTURE and as such shall not be reproduced in any form without express written permission of EITHER OR ARCHITECTURE. All drawings and related documents shall be returned to EITHER OR ARCHITECTURE upon request.

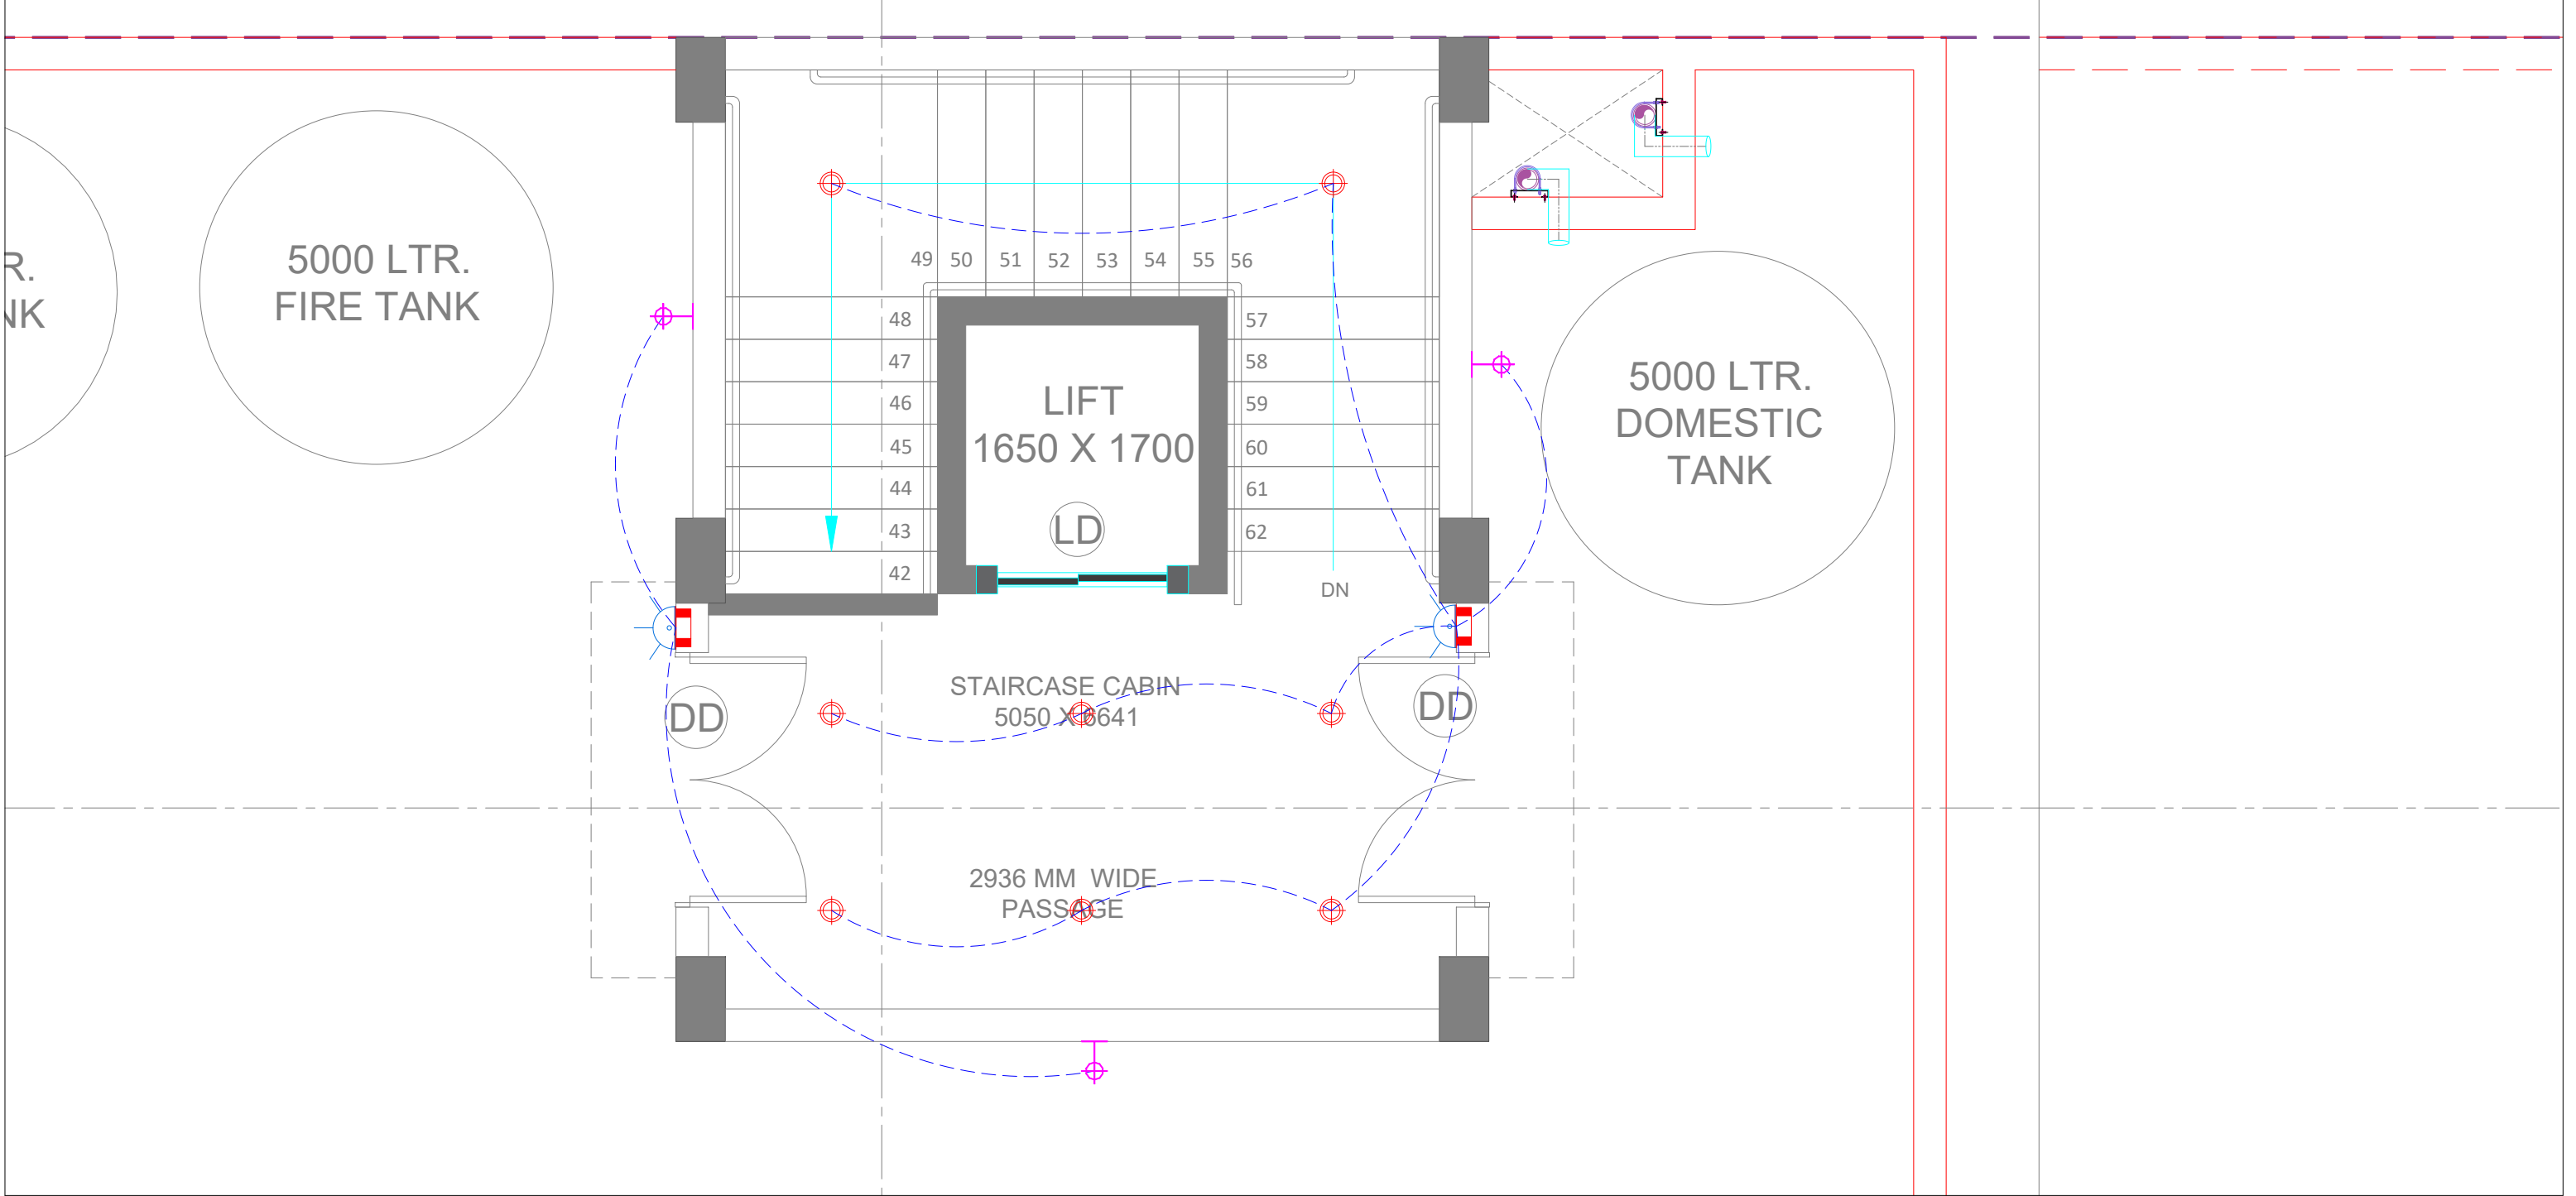






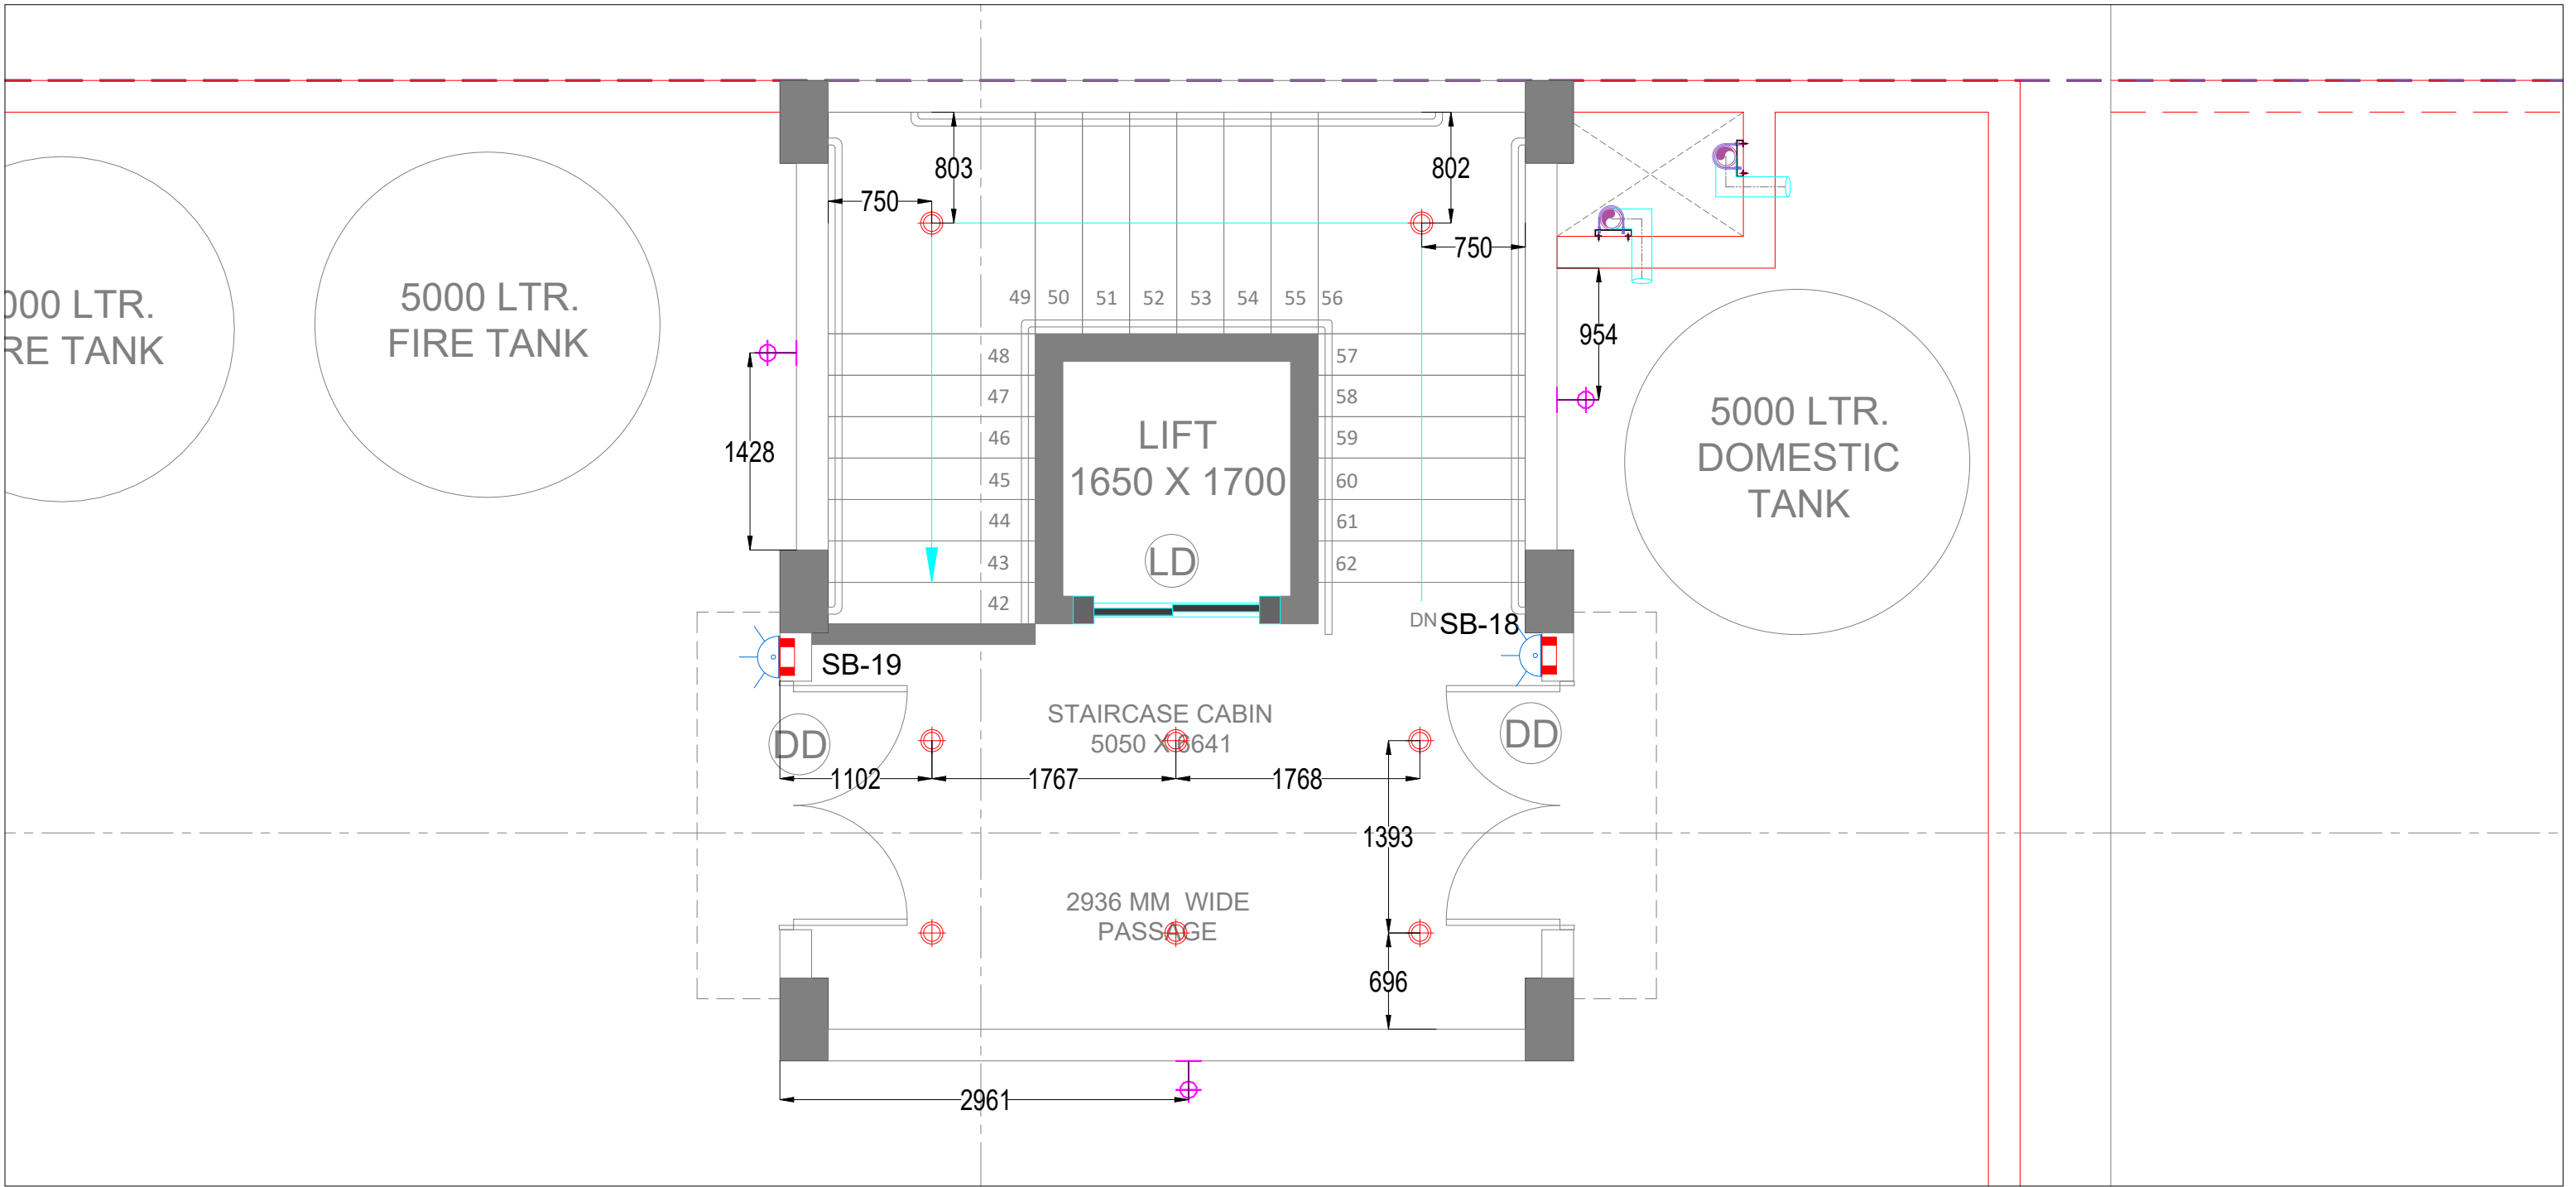

ELE LEGEND FOR STAIR CASE CABIN :-		
SYM	DESCRIPTION	QTY.
	18W LED DOWN LIGHT	08 Nos.
	WALL LIGHT	03 Nos.
	SWITCH BOARD	02 Nos.
	5A POWER SOCKET	02 Nos.
	NORMAL CONTROL	-----
	2WAY CONTROL	-----

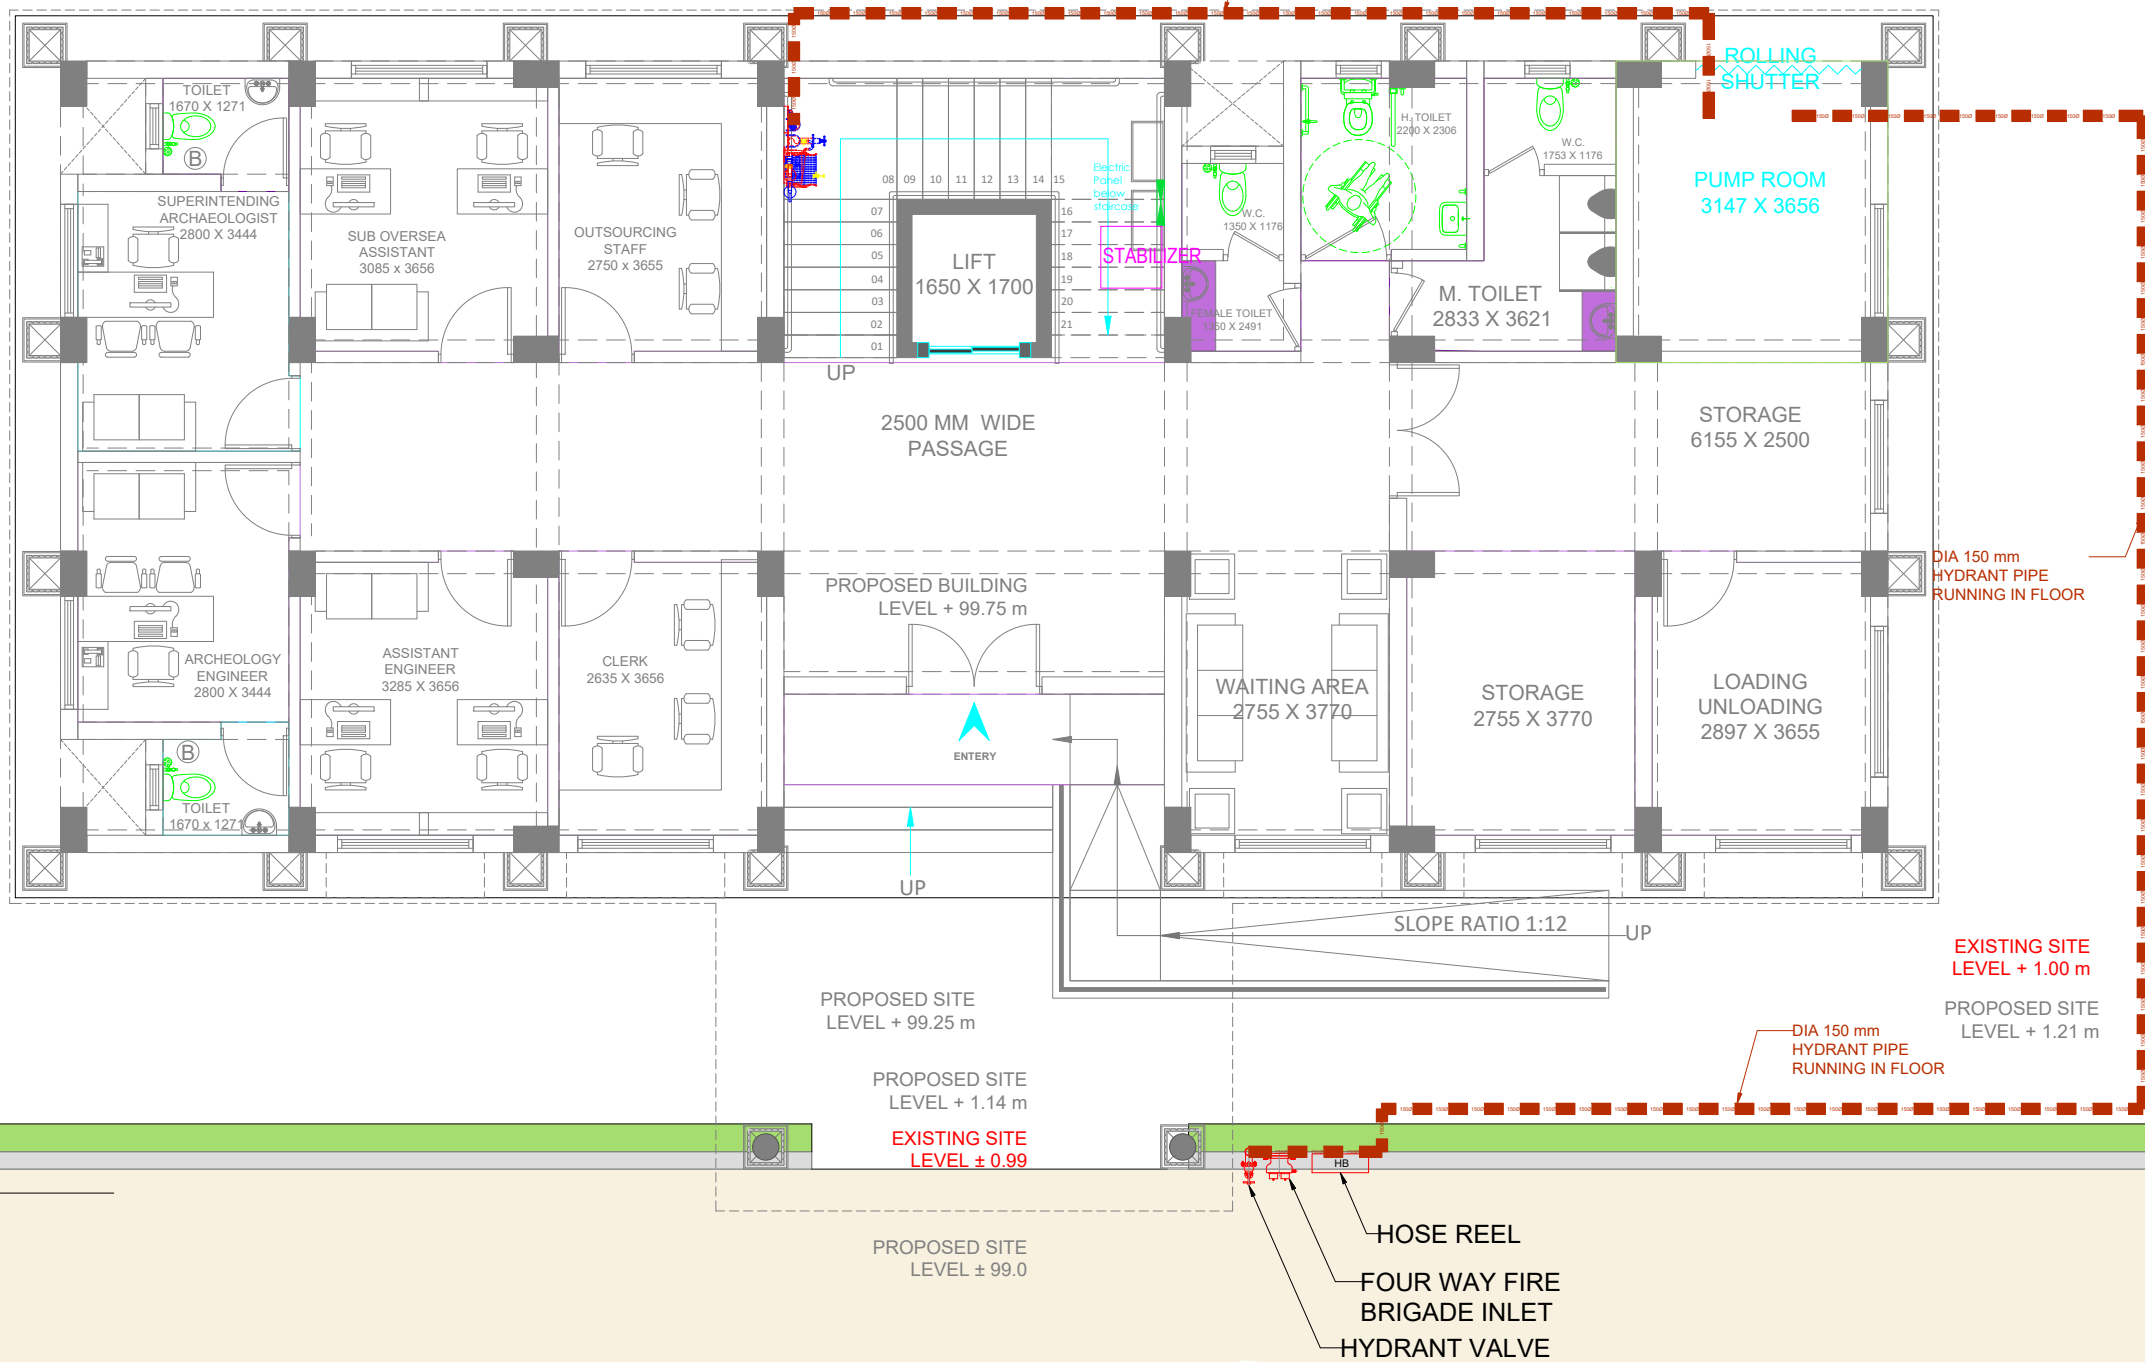PROJECT INFORMATION:		SITE ADDRESS :			KEY PLAN :						REVISION PARTICULARS:				STRUCTURAL CON		ARCHITECTS / INTERIOR DESIGNERS:		DRAWING TITLE:														
BHUIJ ARCHOLOGY																	<div><div></div><div>EITHER OR ARCHITECTURE</div><div>901, Matrix, Behind Divya Bhaskar, S G Highway, Ahmedabad - Gujarat - 54. eitheror.architecture@gmail.com, 9724694445</div></div>		ELE LIGHTING CONTROL LAYOUT FOR TERRACE FLOOR														
CLIENT :										R0		20/05/26		D.M		---		M.E.P CONSULTANT		<div><div></div><div>D.V. TECH ENGINEERS</div></div>		901, Matrix, Behind Divya Bhaskar, S G Highway, Ahmedabad - Gujarat - 54. eitheror.architecture@gmail.com, 9724694445		SCALE:		1:250		DWN BY:		CHECKED BY:		APPROVED B	
DATE :		20/05/2026		DHARTI MISTRY		DHARTI MISTRY		---																									
SHEET NO.:		1 OF 3		DRAWING NO.:																													
										SR.NO		DATE		Dm By		Revision								REV.NO:		R0		LTG:01		PROJ REF:		ARC & CIVIL	




PROJECT INFORMATION:	SITE ADDRESS :		KEY PLAN :		REVISION PARTICULARS:				STRUCTURAL CON	ARCHITECTS / INTERIOR DESIGNERS:	DRAWING TITLE:						
BHUIJ ARCHOLOGY											<div><div></div><div>EITHER OR ARCHITECTURE</div><div>901, Matrix, Behind Divya Bhaskar, S G Highway, Ahmedabad - Gujarat - 54. eitheror.architecture@gmail.com, 9724694445</div></div>	ELE CEILING DIMENSION LAYOUT FOR TERRACE FLOOR					
	CLIENT :																
					R0	20/05/26	D.M	---									
					SR.NO	DATE	Dm By	Revision									




SYMBOL	DESCRIPTION	QTY.
	100NB HYDRANT PIPE	-----
	150NB HYDRANT PIPE	-----
	EXTERNAL HYDRANT	01 Nos.
	HOSE REEL (HR)	01 Nos.
	TWO WAY FIRE BRIGADE INLET	-----
	FOUR WAY FIRE BRIGADE INLET	01 Nos.


PROJECT INFORMATION:		SITE ADDRESS :			KEY PLAN :			REVISION PARTICULARS:				STRUCTURAL CON		ARCHITECTS / INTERIOR DESIGNERS:		DRAWING TITLE:										
BHUV ARCHOLOGY														<div><div></div><div>EITHER OR ARCHITECTURE</div><div>901, Matrix, Behind Divya Bhaskar, S G Highway, Ahmedabad - Gujarat - 54. eitheror.architecture@gmail.com, 9724694445</div></div>		FIRE HYDRANT LAYOUT FOR SITE PLAN										
																SCALE:		1:250			DWN BY:		CHECKED BY:		APPROVED BY:	
																DATE :		20/05/2026			DHARTI MISTRY		DHARTI MISTRY		---	
		CLIENT :						R0		20/05/26		D.M		---				SHEET NO :		1 OF 3		DRAWING NO:				
								SR.NO		DATE		Dm By		Revision				REV.NO:		R0		FFTQ:01				
																		PROJ REF:		ARC & CIVIL						

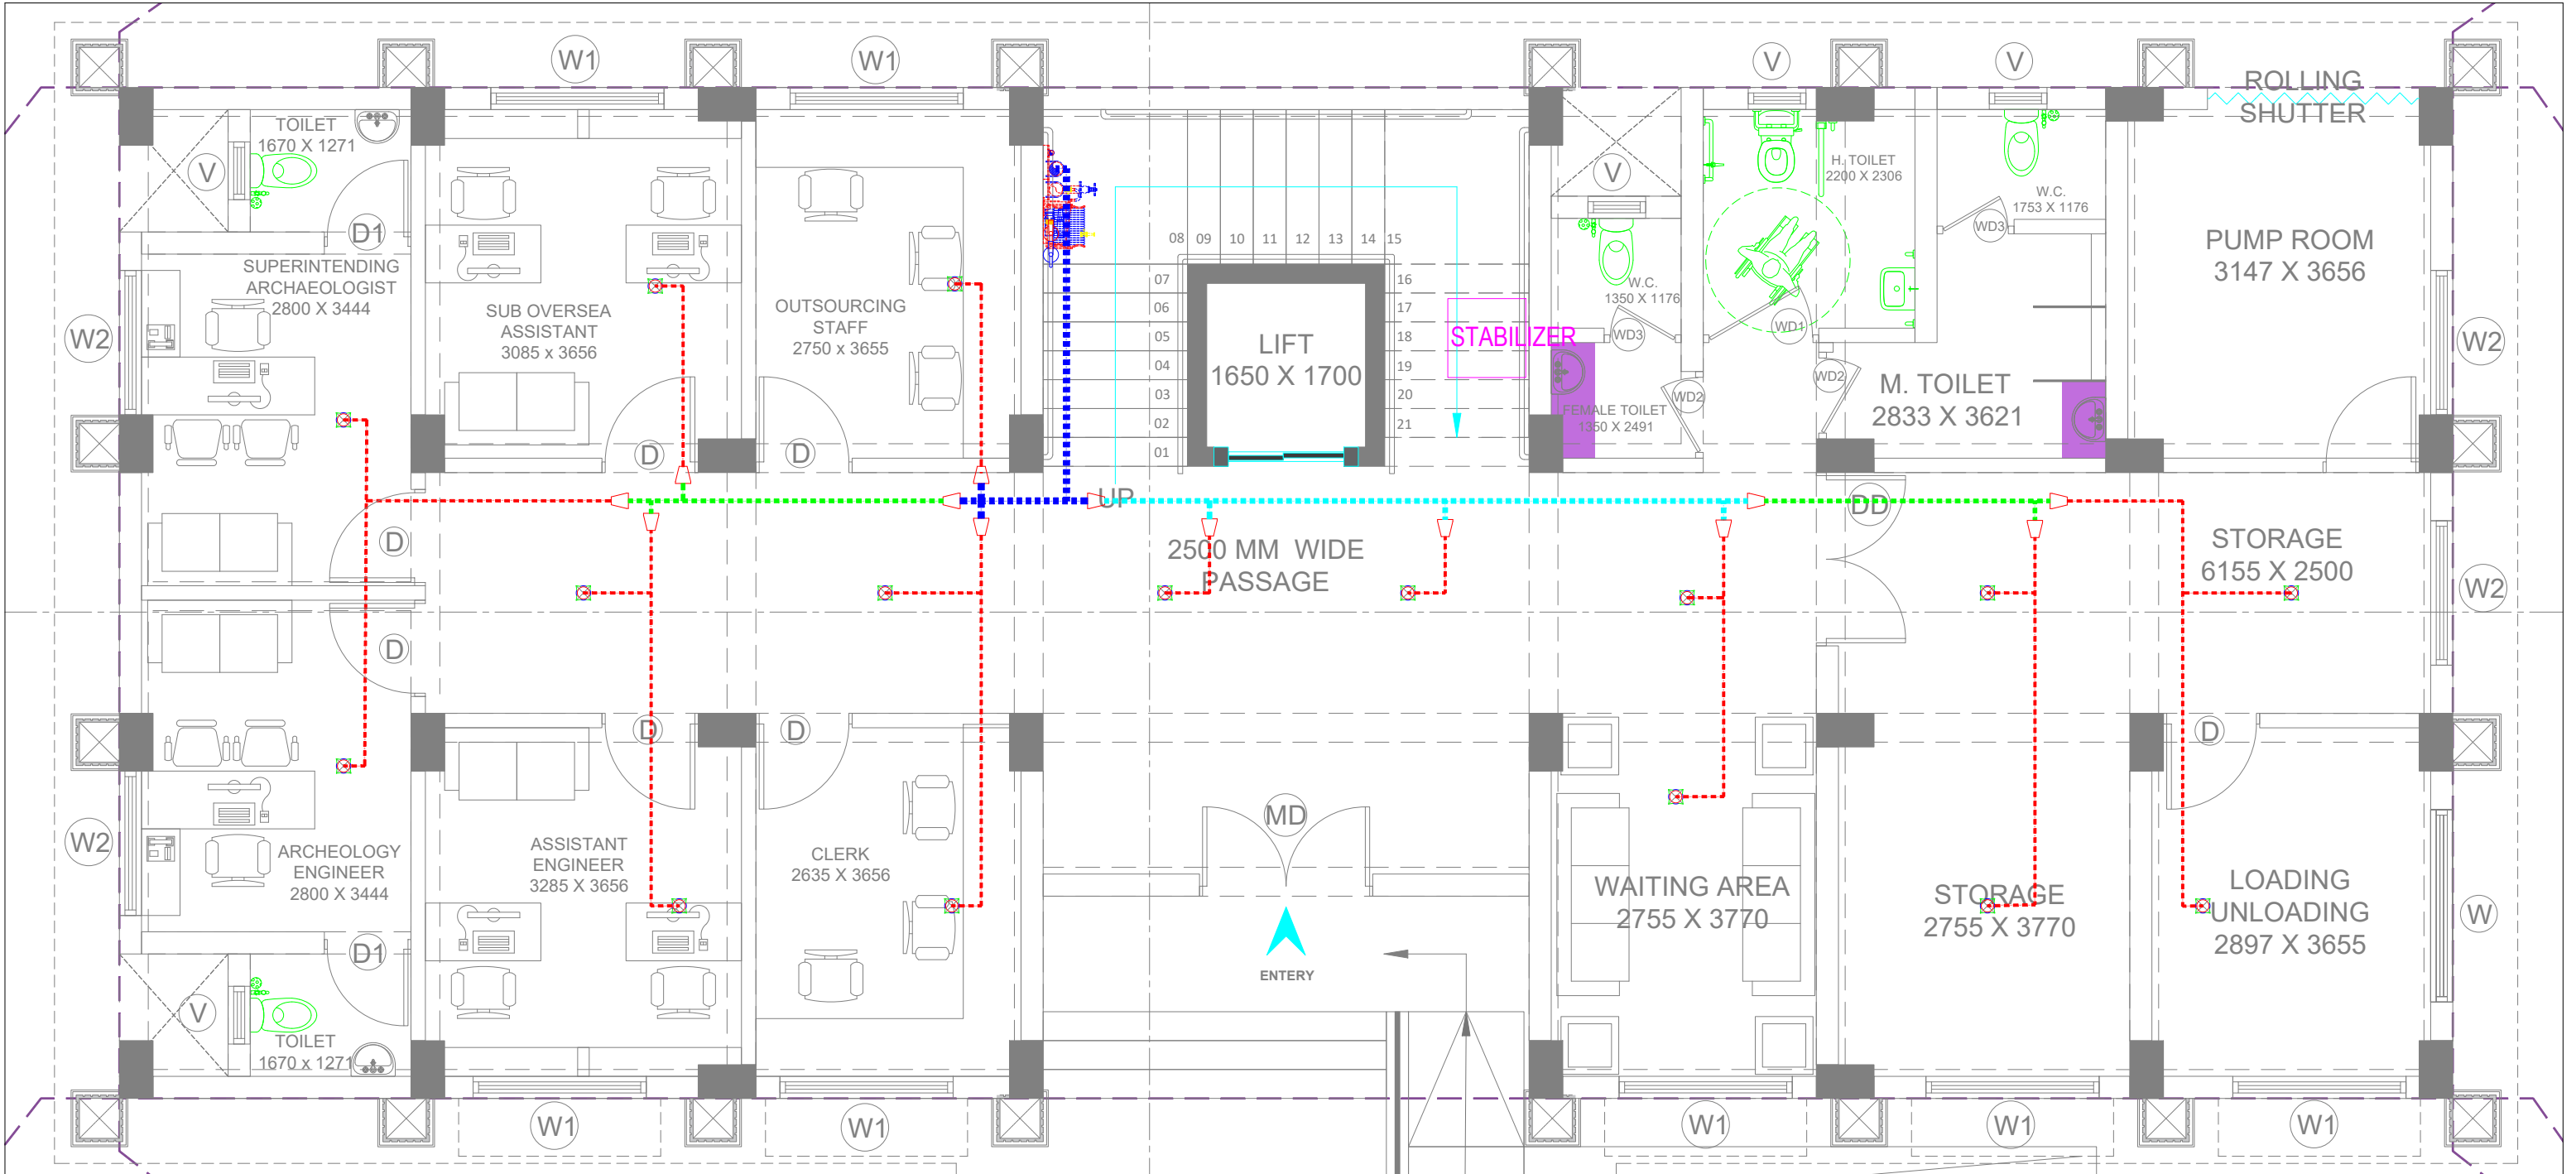

FIRE LEGEND FOR GROUND FLOOR:-		
SYMBOL	DESCRIPTION	QTY.
	25NB SPRINKLER PIPE	-----
	32NB SPRINKLER PIPE	-----
	40NB SPRINKLER PIPE	-----
	50NB SPRINKLER PIPE	-----
	65NB SPRINKLER PIPE	-----
	80NB SPRINKLER PIPE	-----
	100NB HYDRANT PIPE	-----
	150NB SPRINKLER PIPE	-----
	150NB HYDRANT PIPE	-----
	PENDANT SPRINKLER	16 Nos.
	HYDRANT VALVE (HV)	01 Nos.
	HOSE BOX (HB)	01 Nos.
	HOSE REEL (HR)	01 Nos.
	BUTTERFLY VALVE (BFV)	01 Nos.
	NON RETURN VALVE (NRV)	---
	FIRE EXTINGUISHER CO2 4.5KG (F.X.)	01 Nos.
	FIRE EXTINGUISHER ABC 6KG (F.X.)	01 Nos.

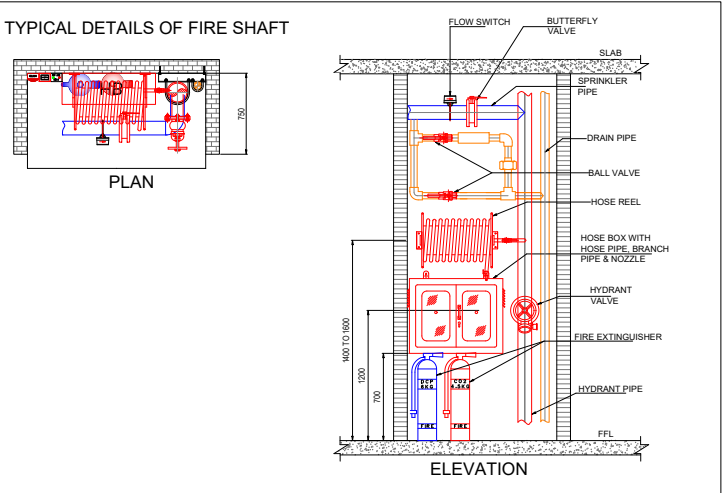


PROJECT INFORMATION:		SITE ADDRESS :				KEY PLAN :				REVISION PARTICULARS:		STRUCTURAL CON		ARCHITECTS / INTERIOR DESIGNERS:		DRAWING TITLE:															
BHUU ARCHOLOGY														<div><div></div><div>EITHER OR ARCHITECTURE</div><div>901, Matrix, Behind Divya Bhaskar, S G Highway, Ahmedabad - Gujarat - 54. eitheror.architecture@gmail.com, 9724694445</div></div>		FIRE SPRINKLER LAYOUT FOR GROUND FLOOR															
		CLIENT :																				M.E.P CONSULTANT		<div><div></div><div>D.V. TECH ENGINEERS</div></div>		SCALE:		1:250		DWN BY:	
										R0		20/05/26		D.M		---		DATE :		20/05/2026		SHEET NO :				1 OF 3		DRAWING NO:			
												SR.NO		DATE		Dm By		Revision				REV.NO:		R0		FFTG:01		PROJ REF:		ARC & CIVIL	

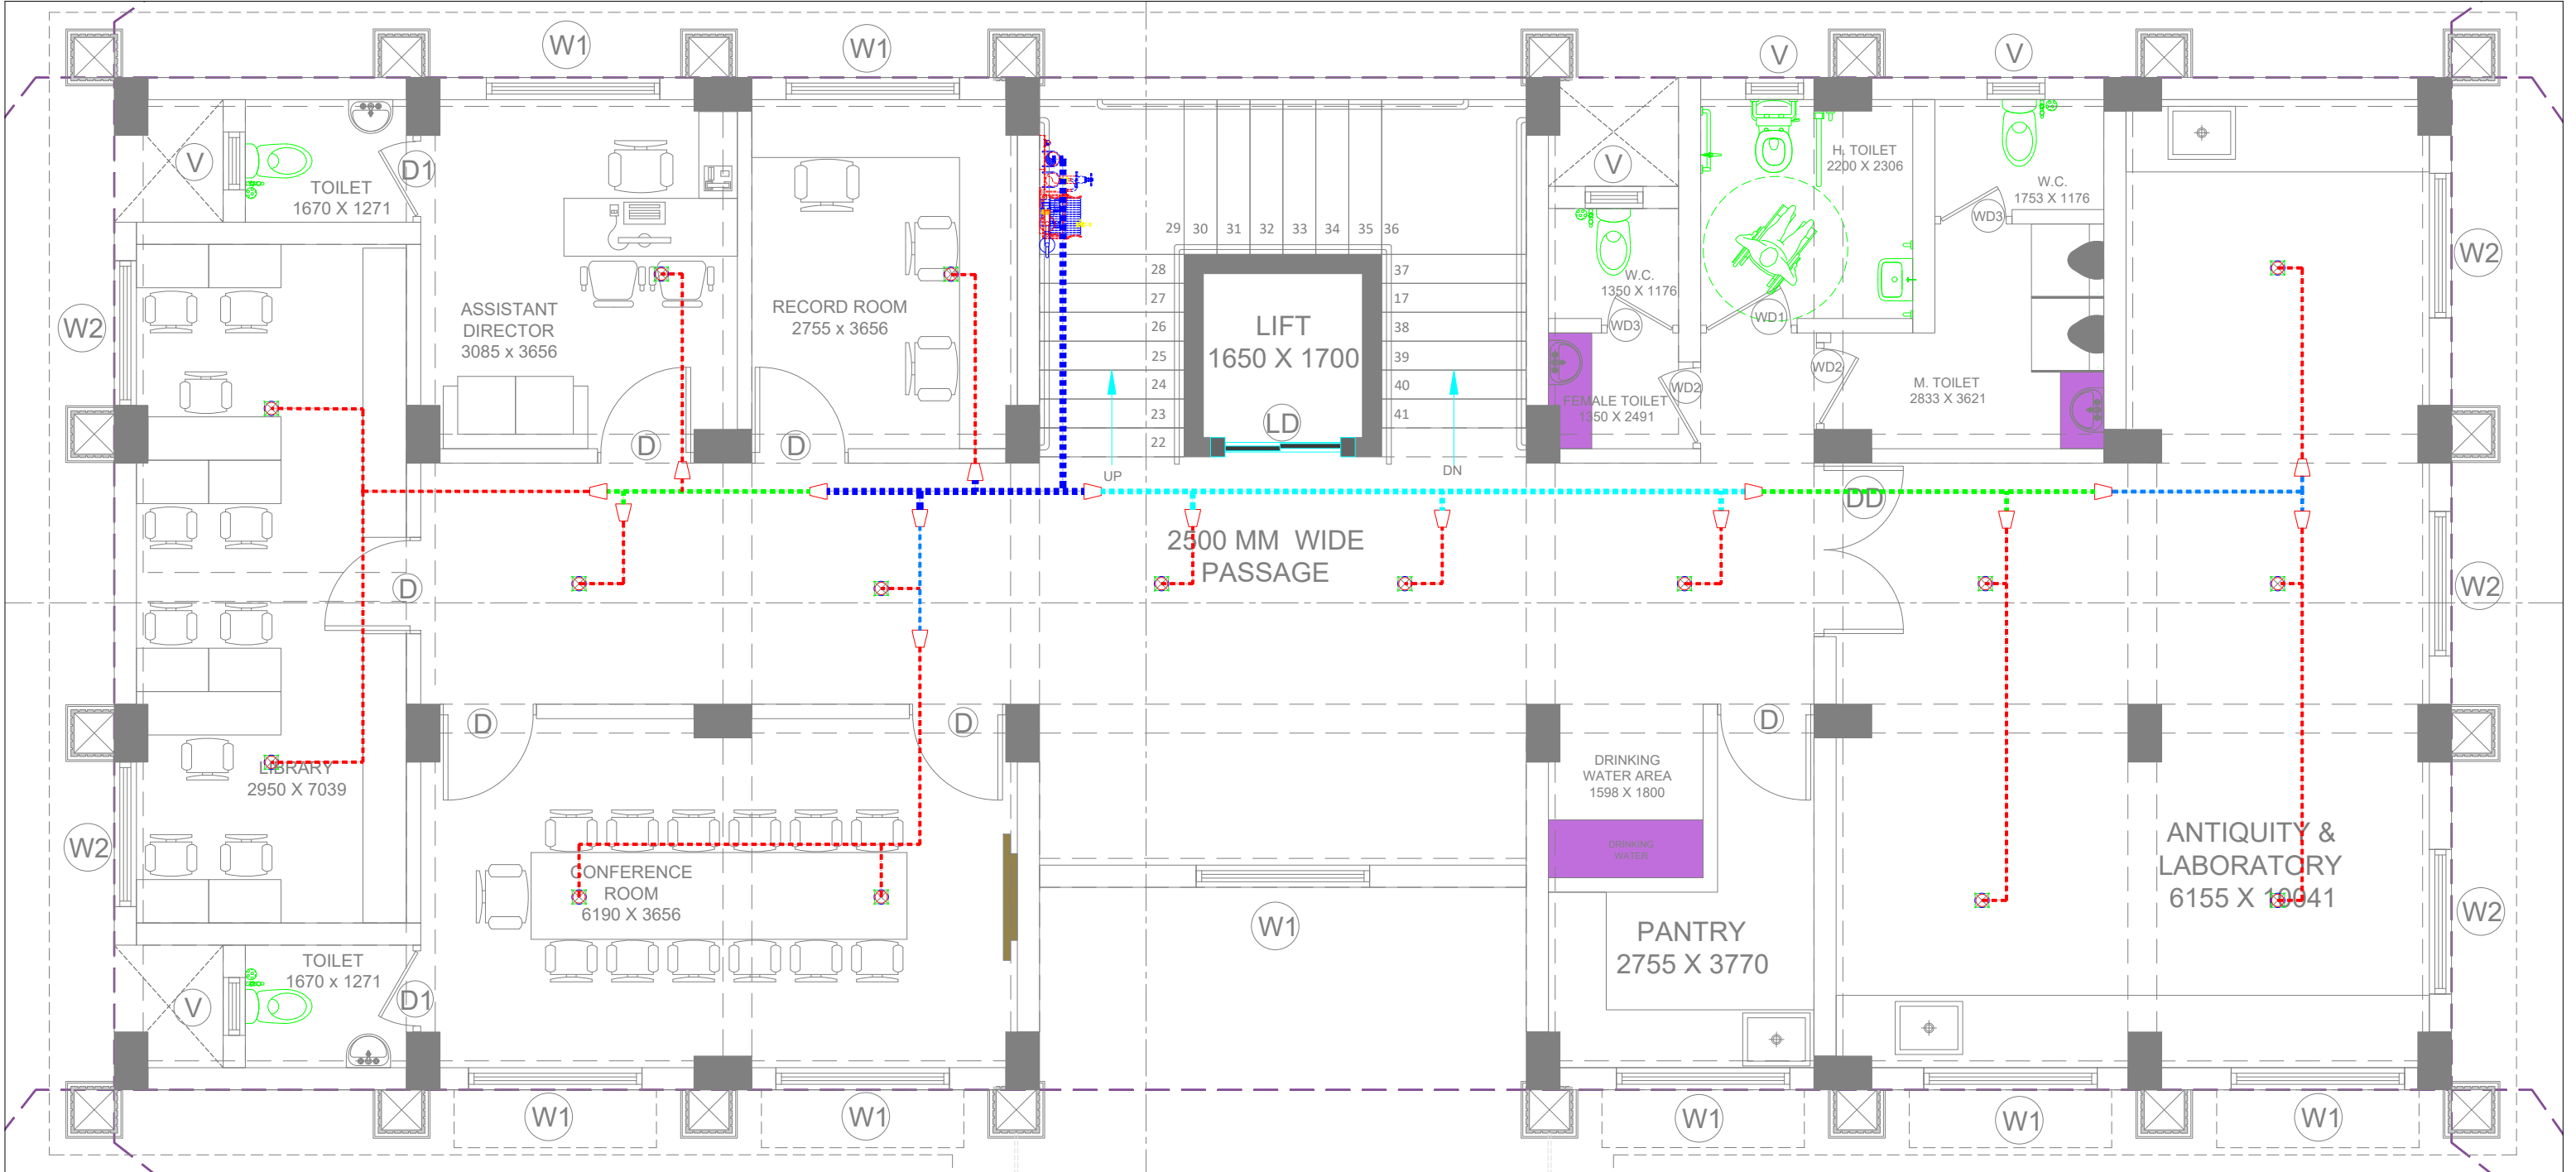

FIRE LEGEND FOR FIRST FLOOR:-		
SYMBOL	DESCRIPTION	QTY.
	25NB SPRINKLER PIPE	-----
	32NB SPRINKLER PIPE	-----
	40NB SPRINKLER PIPE	-----
	50NB SPRINKLER PIPE	-----
	65NB SPRINKLER PIPE	-----
	80NB SPRINKLER PIPE	-----
	100NB HYDRANT PIPE	-----
	150NB SPRINKLER PIPE	-----
	150NB HYDRANT PIPE	-----
	PENDANT SPRINKLER	16 Nos.
	HYDRANT VALVE (HV)	01 Nos.
	HOSE BOX (HB)	01 Nos.
	HOSE REEL (HR)	01 Nos.
	BUTTERFLY VALVE (BFV)	01 Nos.
	NON RETURN VALVE (NRV)	-----
	FIRE EXTINGUISHER CO2 4.5KG (F.X.)	01 Nos.
	FIRE EXTINGUISHER ABC 6KG (F.X.)	01 Nos.

PROJECT INFORMATION:		SITE ADDRESS :			KEY PLAN :						REVISION PARTICULARS:				STRUCTURAL CON		ARCHITECTS / INTERIOR DESIGNERS:		DRAWING TITLE:											
BHUIJ ARCHOLOGY																	<div><div></div><div>EITHER OR ARCHITECTURE</div><div>901, Matrix, Behind Divya Bhaskar, S G Highway, Ahmedabad - Gujarat - 54. eitheror.architecture@gmail.com, 9724694445</div></div>		FIRE SPRINKLER LAYOUT FOR FIRST FLOOR											
CLIENT :														M.E.P CONSULTANT		<div><div></div><div>D.V. TECH ENGINEERS</div></div>				SCALE: 1:250					DWN BY:		CHECKED BY:		APPROVED B	
DATE :		20/05/2026		DHARTI MISTRY		DHARTI MISTRY		---																						
SHEET NO.:		1 OF 3		DRAWING NO.:																										
REV.NO:		R0																FFTG:01												
PROJ REF:		ARC & CIVIL																												

These drawings & designs are the sole property of EITHER OR ARCHITECTURE and as such shall not be reproduced in any form without express written permission of EITHER OR ARCHITECTURE. All drawings and related documents shall be returned to EITHER OR ARCHITECTURE upon request.

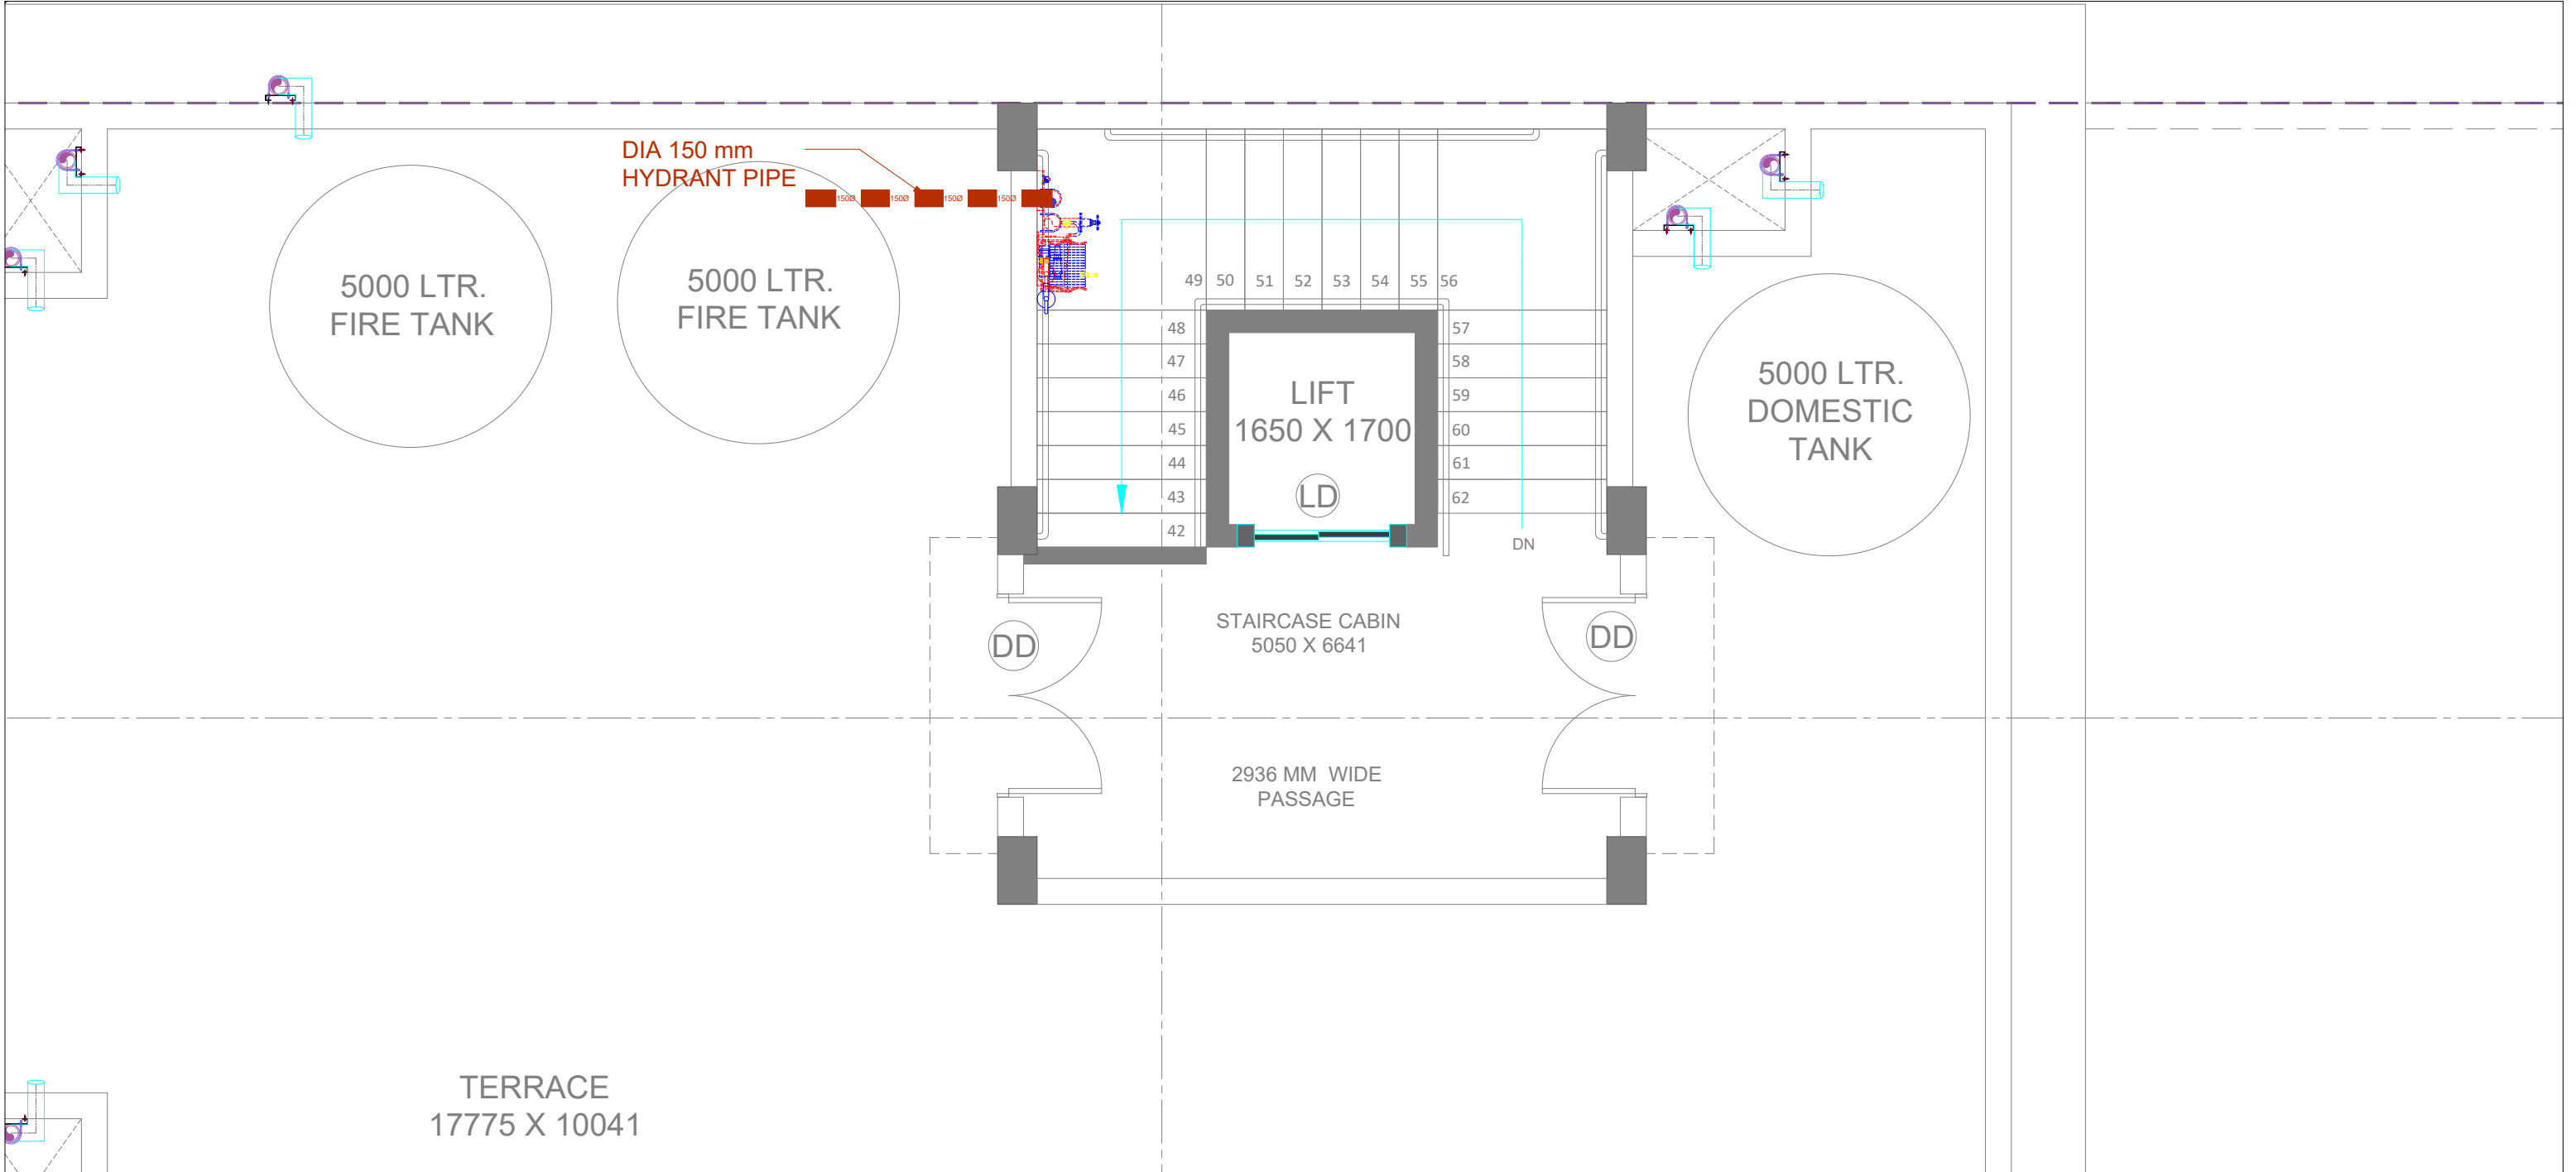

FIRE LEGEND FOR SECOND FLOOR:-		
SYMBOL	DESCRIPTION	QTY.
.....	25NB SPRINKLER PIPE
.....	32NB SPRINKLER PIPE
.....	40NB SPRINKLER PIPE
.....	50NB SPRINKLER PIPE
.....	65NB SPRINKLER PIPE
.....	80NB SPRINKLER PIPE
.....	100NB HYDRANT PIPE
.....	150NB SPRINKLER PIPE
.....	150NB HYDRANT PIPE
.....	PENDANT SPRINKLER	-- Nos.
.....	HYDRANT VALVE (HV)	01 Nos.
.....	HOSE BOX (HB)	01 Nos.
.....	HOSE REEL (HR)	01 Nos.
.....	BUTTERFLY VALVE (BFV)	01 Nos.
.....	NON RETURN VALVE (NRV)
.....	FIRE EXTINGUISHER CO2 4.5KG (F.X.)	01 Nos.
.....	FIRE EXTINGUISHER ABC 6KG (F.X.)	01 Nos.

PROJECT INFORMATION:		SITE ADDRESS :				KEY PLAN :						REVISION PARTICULARS:				STRUCTURAL CON		ARCHITECTS / INTERIOR DESIGNERS:		DRAWING TITLE:											
BHUIJ ARCHOLOGY																						<div><div></div><div>EITHER OR ARCHITECTURE</div></div> <div>901, Matrix, Behind Divya Bhaskar, S G Highway, Ahmedabad - Gujarat - 54. eitheror.architecture@gmail.com, 9724694445</div>				FIRE SPRINKLER LAYOUT FOR TERRACE FLOOR					
		CLIENT :												M.E.P CONSULTANT		<div><div></div><div>D.V. TECH ENGINEERS</div></div>															

