



ELECTRICAL DRAWING

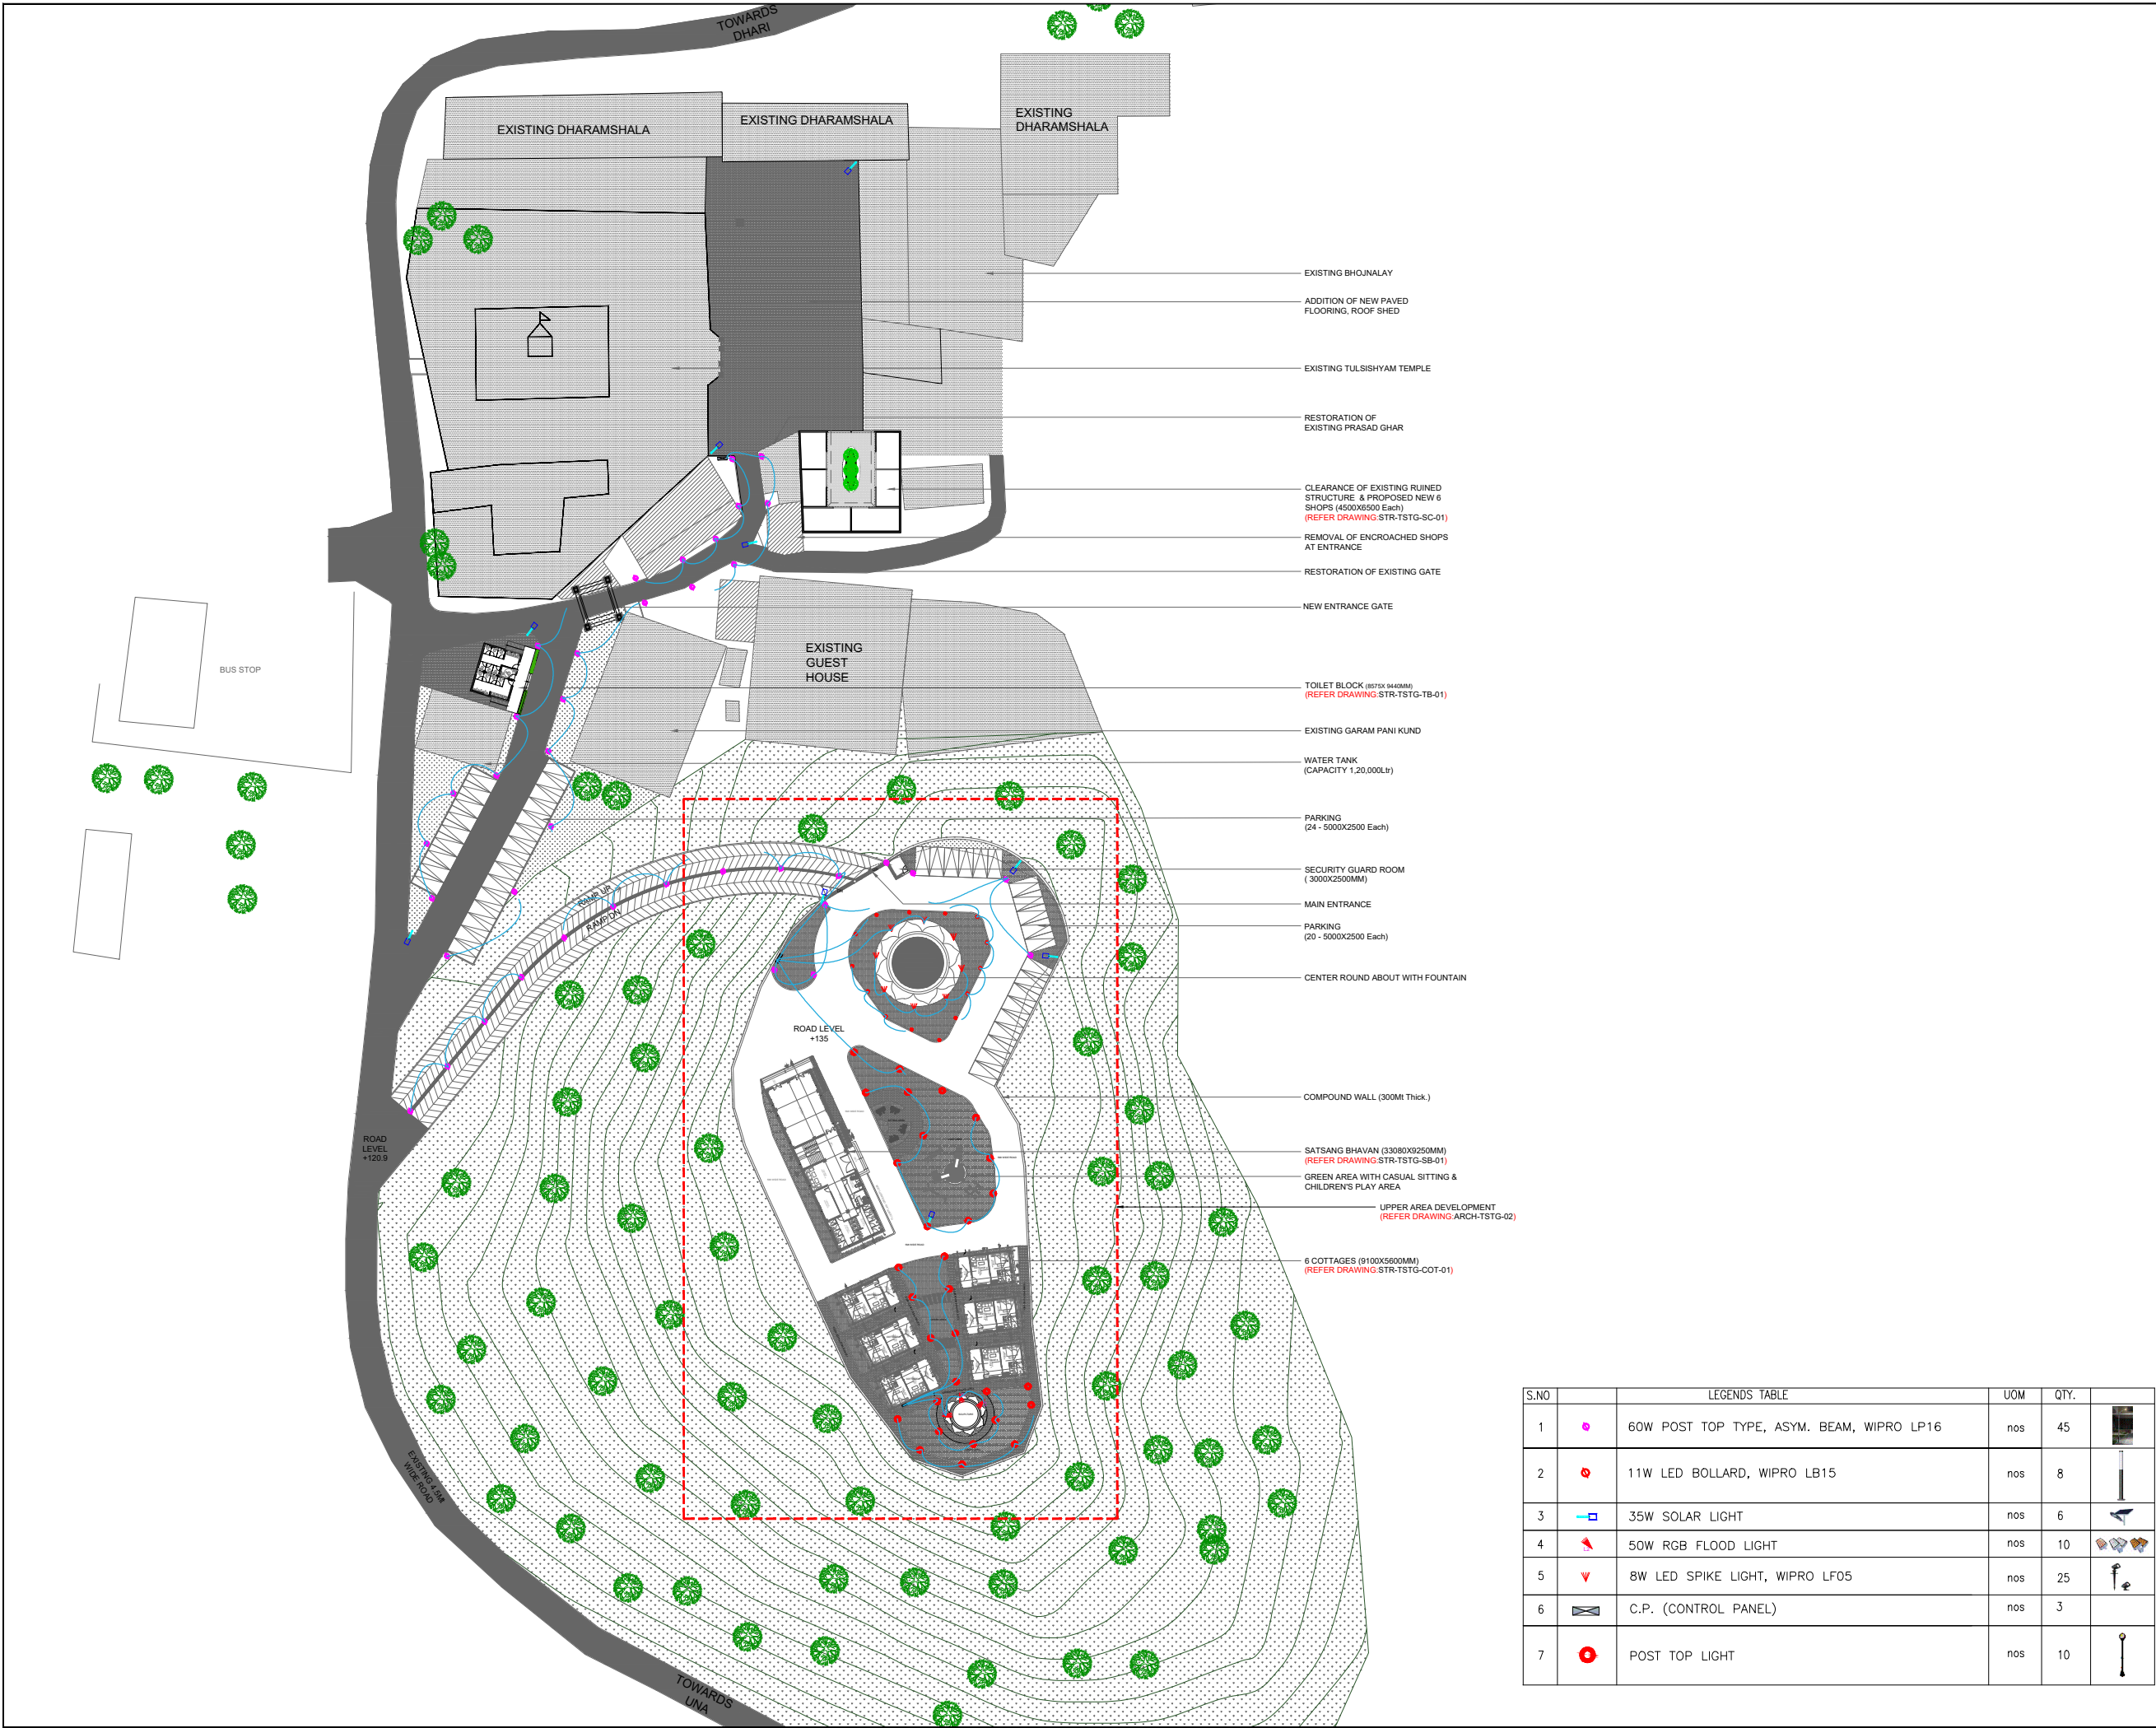










InGenious Studio pvt. Ltd.

GENERAL NOTES:

1. THIS DRAWING IS THE COPYRIGHT OF INGENIOUS STUDIO PVT. LTD. AND MUST NOT BE REPRODUCED, COPIED OR USED WITHOUT THE ABOVE CONSULTANTS AUTHORITY.
2. DO NOT SCALE FROM THE DRAWINGS.
3. ALL DIMENSIONS ARE IN MILLIMETRES AND LEVELS IN METRES UNLESS NOTED OTHERWISE. ALL DIMENSIONS TO BE VERIFIED ON SITE & APPROVED BY THE ENGINEER.
4. THIS DRAWING SHOULD BE READ IN CONJUNCTION WITH OTHER RELEVANT ARCHITECTURAL, STRUCTURAL, MECHANICAL AND ELECTRICAL DRAWINGS AND ALL RELEVANT SECTIONS OF THE SPECIFICATIONS.



NORTH

| AREA LEGEND | | |
|-------------|---|---------------------|
| S.NO. | SYMBOL | DESCRIPTION |
| 01 |  | EXISTING STRUCTURES |
| 02 |  | NEW STRUCTURES |
| 03 |  | GREEN AREA |
| 04 |  | ROAD |
| 05 |  | PAVED AREAS |
| 05 |  | REMOVAL OF AREAS |


| AREA CALCULATION | | |
|------------------|------------------------|-----------|
| S.NO. | DESCRIPTIONS | AREA |
| 01 | TOILET BLOCK | 88 SqM. |
| 02 | NEW SHOPS | 196 SqM. |
| 03 | LOWER PARKING | 312 SqM. |
| 04 | UPPER AREA DEVELOPMENT | 4315 SqM. |

Purpose of Issue

| TENDER | | | | |
|--------|-------------|------|---------|------------|
| Rev | Description | Date | Checked | Authorised |
| | | | | |
| | | | | |
Purpose of Issue

ARCHITECTURAL CONSULTANTS

 InGenious Studio pvt. Ltd.

Office no. 334, Third Floor, Tower B-2 Telephone: +91-124-4363861
Space Tech Park, Email: info@ingeniousstudio.in
Sohna Road, Gurgaon, Haryana, India Website: www.ingeniousstudio.in

STRUCTURAL CONSULTANTS

ELECTRICAL CONSULTANTS

M/E CONSULTANTS

Project: TEMPLE AREA DEVELOPMENT- TULSISHYAM TEMPLE, GUJARAT


Client: GUJARAT PAVITRA YATRADHAM VIKAS BOARD

Drawing title: PROPOSED ELECTRICAL SITE PLAN

| Original Scale | Drawn | Checked | Authorised | Size |
|----------------|----------------|----------------|----------------|------|
| 1:500 | PDA/THAM | J.J. Singh | J.J. Singh | A1 |
| Date: 16.03.20 | Date: 16.03.20 | Date: 16.03.20 | Date: 16.03.20 | |

Drawing Number: ELEC-TSTG-SP-01

Rev: R0

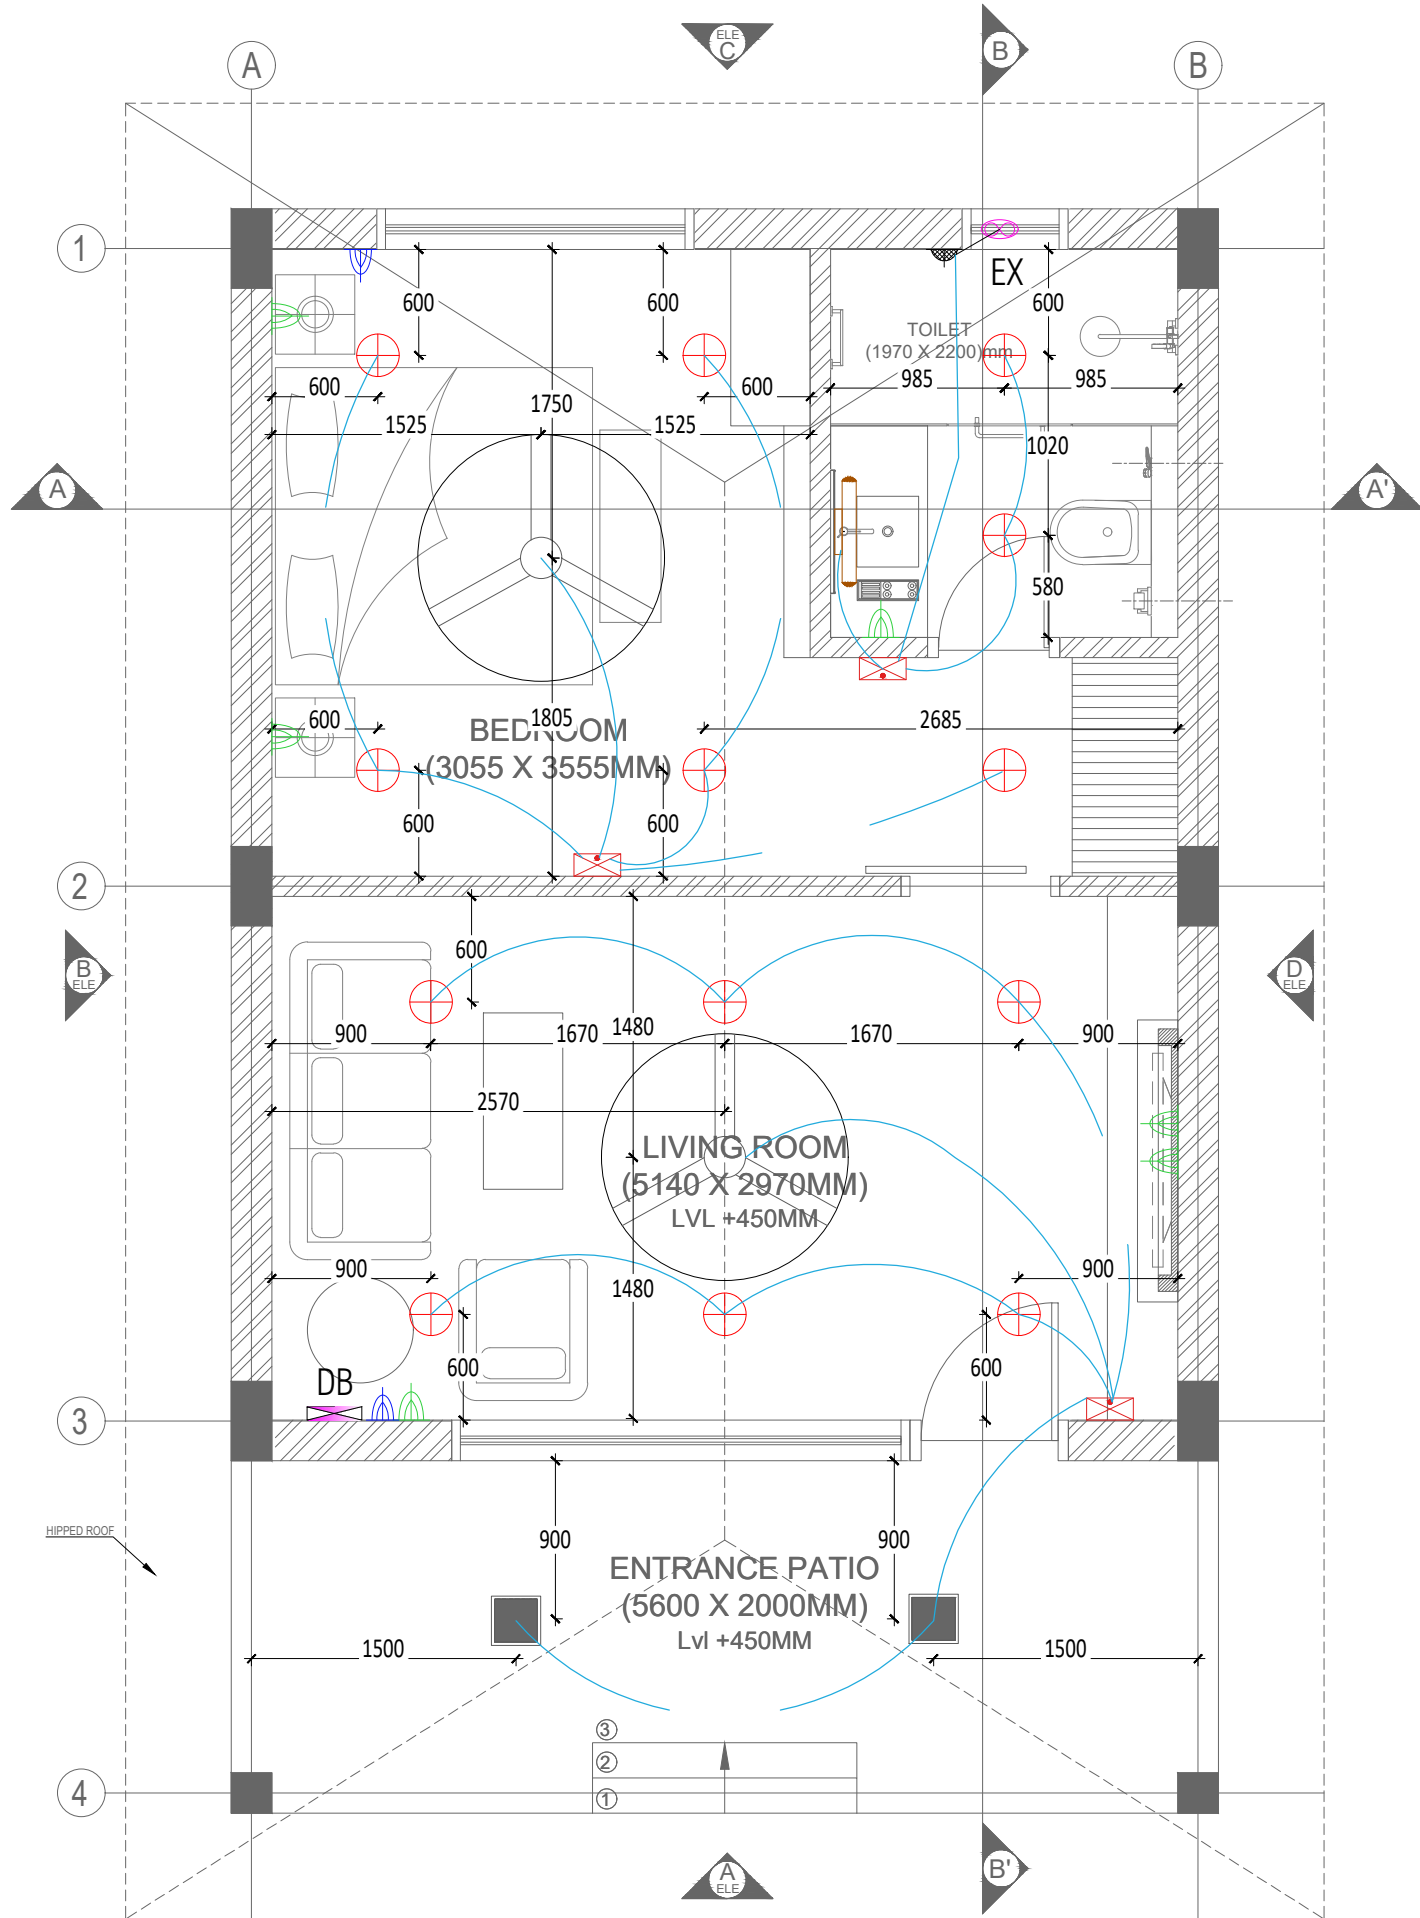

FLOOR PLAN

| LEGENDS TABLE | | | | |
|---------------|--------|---|-----|----|
| S.NO | SYMBOL | DESCRIPTION | UOM | |
| 1 | | 18W SURFACE/RECESS DIFFUSE DL, WIPRO LD06 | nos | 13 |
| 2 | | 10W 2FT. LED MIRROR LIGHT, WIPRO LL20-111 | nos | 01 |
| 3 | | S.B. (SWITCH BOARD) | nos | 03 |
| 4 | | D.B. (DISTRIBUTION BOARD) | nos | 01 |
| 5 | | 6A SWITCH AND SOCKET | nos | 06 |
| 6 | | 16A SWITCH AND SOCKET | nos | 02 |
| 7 | | EXHAUST FAN | nos | 01 |
| 8 | | WALL ROSE FOR EXHAUST FAN | nos | 01 |
| 9 | | 25W SURFACE/RECESS PANEL | nos | 02 |
| 10 | | CEILING FAN | nos | 02 |

InGenious Studio pvt. ltd.

GENERAL NOTES:

1. THIS DRAWING IS THE COPYRIGHT OF INGENIOUS STUDIO PVT. LTD. AND MUST NOT BE REPRODUCED, COPIED OR USED WITHOUT THE ABOVE CONSULTANT'S AUTHORITY.

2. DO NOT SCALE FROM THE DRAWINGS.

3. ALL DIMENSIONS ARE IN MILLIMETRES AND LEVELS IN METRES UNLESS NOTED OTHERWISE. ALL DIMENSIONS TO BE VERIFIED ON SITE & APPROVED BY THE ENGINEER.

4. THIS DRAWING SHOULD BE READ IN CONJUNCTION WITH OTHER RELEVANT ARCHITECTURAL, STRUCTURAL, MECHANICAL AND ELECTRICAL DRAWINGS AND ALL RELEVANT SECTIONS OF THE SPECIFICATIONS.

Purpose of Issue

TENDER

| Rev | Description | Date | Checked | Authorised |
|-----|-------------|------|---------|------------|
| | | | | |
| | | | | |
Purpose of Issue

ARCHITECTURAL CONSULTANTS

InGenious Studio pvt. ltd.

Office no. 334, Third Floor, Tower B-2 Telephone: +91-124-4363861
Space Tech Park, Email: info@ingeniousstudio.in
Sohna Road, Gurgaon, Haryana, India Website: www.ingeniousstudio.in

STRUCTURAL CONSULTANTS

ELECTRICAL CONSULTANTS

PHE CONSULTANTS

Project:

TEMPLE AREA DEVELOPMENT-
TULSISHYAM TEMPLE, GUJARAT

Client:

GUJARAT PAVITRA
YATRADHAM VIKAS BOARD

Drawing title:


COTTAGE BLOCK


| Original Scale | Drawn | Checked | Authorised | Size |
|----------------|----------------|----------------|----------------|------|
| 1:20 | PDA/THAM | J.J. Singh | J.J. Singh | A1 |
| Date: 16.03.20 | Date: 16.03.20 | Date: 16.03.20 | Date: 16.03.20 | Rev |


Drawing Number

ELEC-TSTG-COT-01


R0

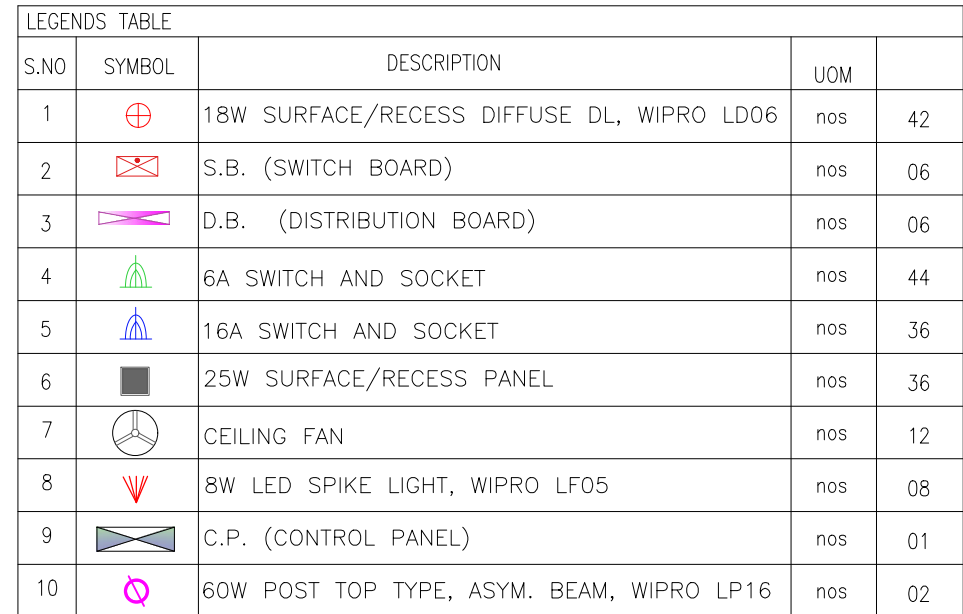

| | | | | |
|---|----------------|----------------|----------------|------------|
| Purpose of Issue | | | | |
| TENDER | | | | |
| | | | | |
| | | | | |
| Sl. | Description | Date | Checked | Authorized |
| Purpose of Issue | | | | |
| ARCHITECTURAL CONSULTANTS | | | | |
|  InGenious Studio pvt. ltd. | | | | |
| Office no. 334, Third Floor, Tower B-2 Telephone -+91-124-4383861 Spaze 1 Tech Park, Email : info@ingeniousstudio.in Sohna Road, Gurgaon, Haryana, India Website : www.ingeniousstudio.in | | | | |
| STRUCTURAL CONSULTANTS | | | | |
| ELECTRICAL CONSULTANTS | | | | |
| MECHANICAL CONSULTANTS | | | | |
| PHE CONSULTANTS | | | | |
| Project: TEMPLE AREA DEVELOPMENT- TULSI SHYAM TEMPLE, GUJARAT | | | | |
| Client: GUJARAT PAVITRA YATRADHAM VIKAS BOARD | | | | |
| Drawing title: NEWS SHOPS ELECTRICAL PLAN | | | | |
| Original Scale | Drawn | Checked | Authorized | Size |
| N.T.S | PRATHAM | J.J. Singh | J.J. Singh | A1 |
| Date: 16.03.20 | Date: 16.03.20 | Date: 16.03.20 | Date: 16.03.20 | |
| Drawing Number | | | | Rev |
| ELEC-TSTG-SC-01 | | | | R0 |

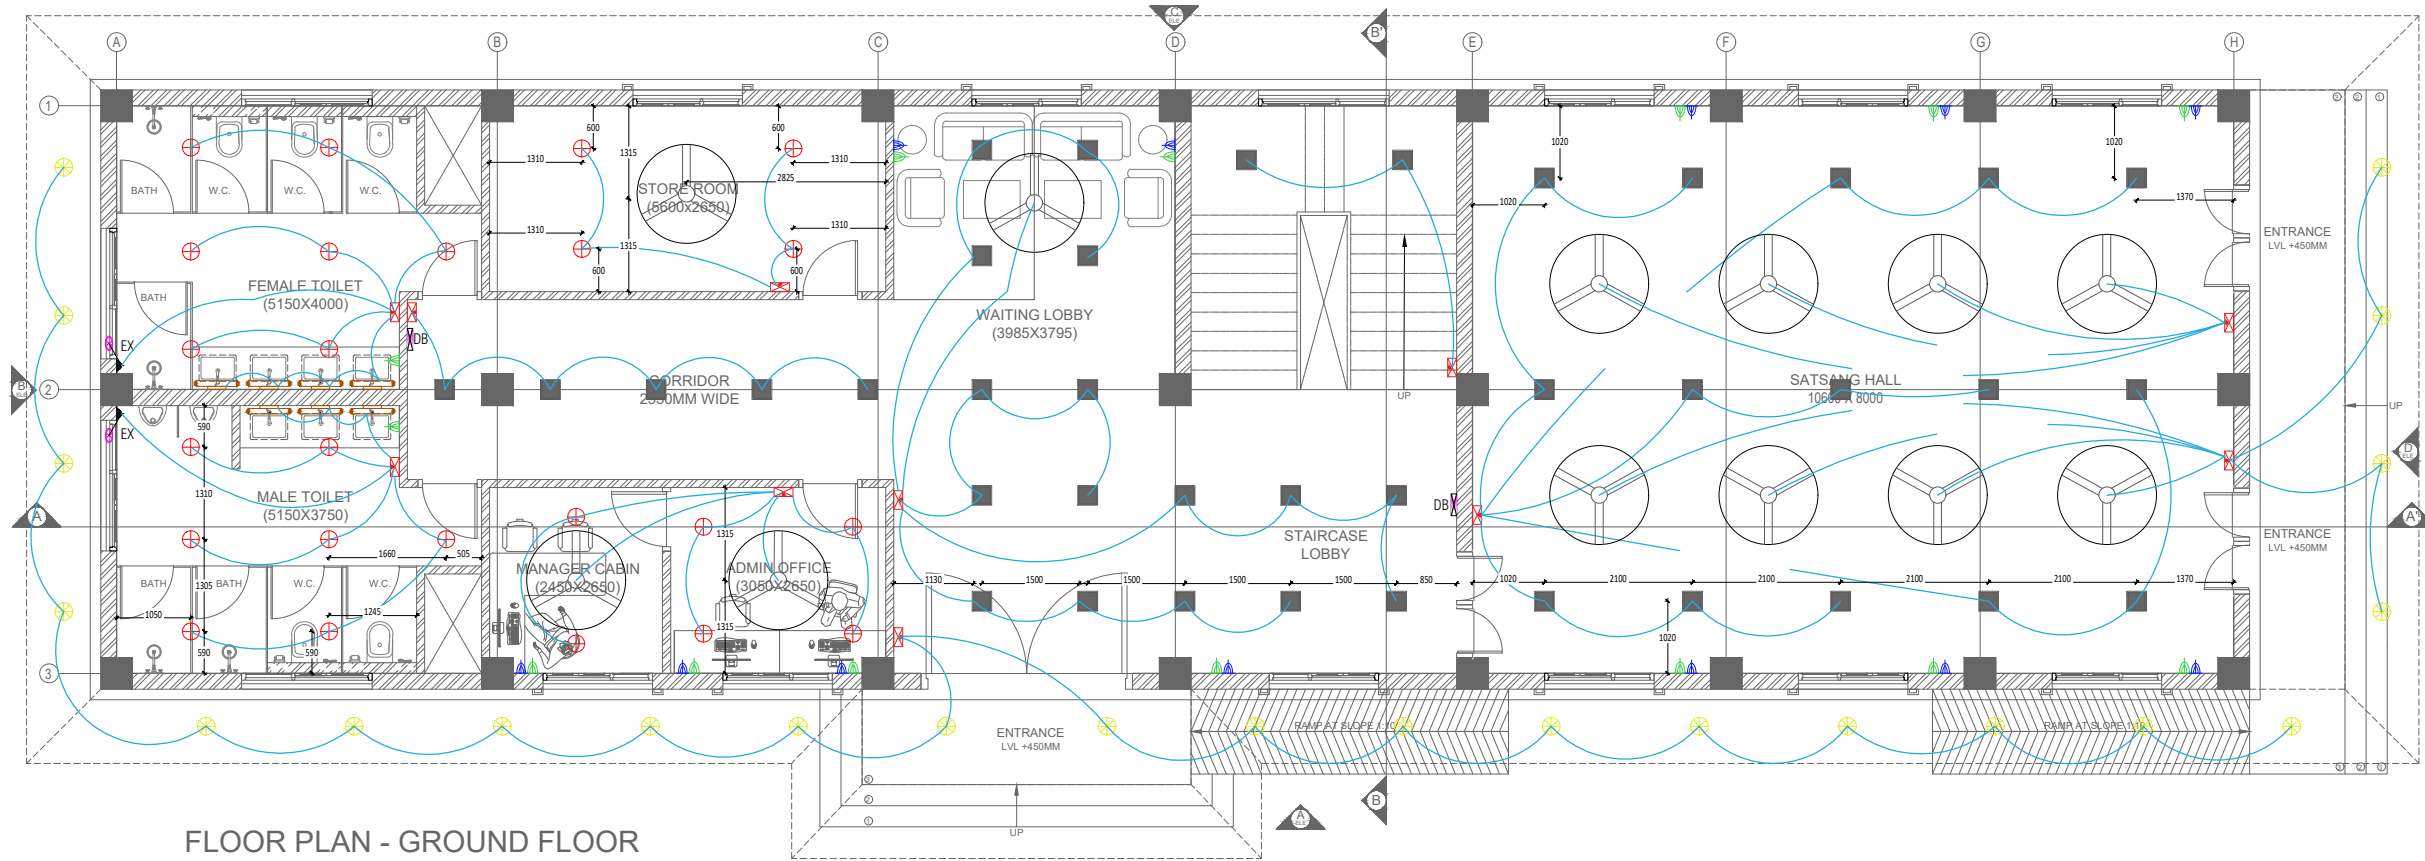

FLOOR PLAN - GROUND FLOOR

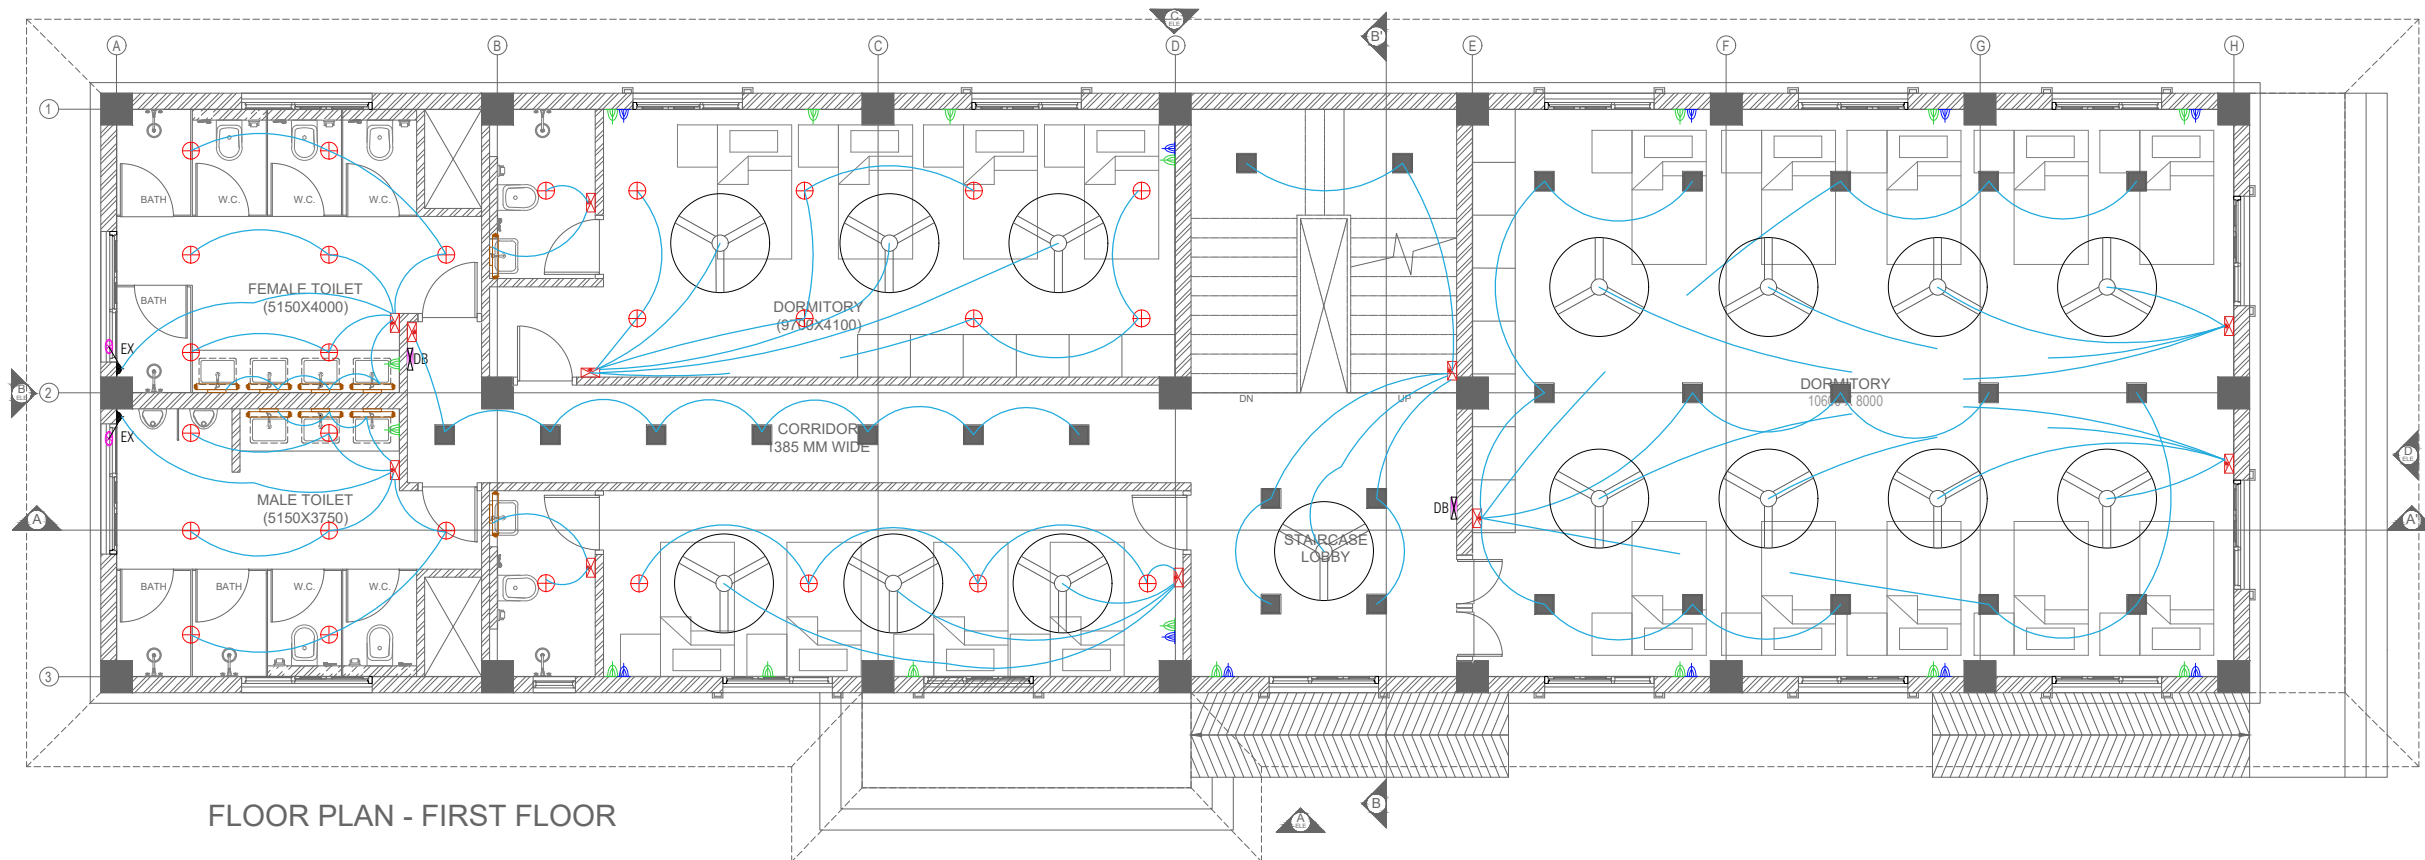

FLOOR PLAN - FIRST FLOOR

Purpose of Issue: TENDER

| Rev | Description | Date | Checked | Authorised |
|-----|-------------|------|---------|------------|
| | | | | |
| | | | | |
| | | | | |
| | | | | |
| | | | | |

Purpose of Issue:

ARCHITECTURAL CONSULTANTS
InGenious Studio pvt. ltd.
 Office no. 334, Third Floor, Tower B-2 Telephone: +91-124-4363861
 Space Tech Park Email: info@ingeniousstudio.in
 Sohna Road, Gurgaon, Haryana, India Website: www.ingeniousstudio.in

STRUCTURAL CONSULTANTS

ELECTRICAL CONSULTANTS

P/E CONSULTANTS

Project: TEMPLE AREA DEVELOPMENT- TULSISHYAM TEMPLE, GUJARAT

Client: GUJARAT PAVITRA YATRADHAM VIKAS BOARD

Drawing title: SATSANG HALL BLOCK ELECTRICAL PLAN

Original Scale: 1:50
 Date: 16.03.2018
 Drawn: PDA/THAM
 Checked: J.J. Singh
 Date: 16.03.2018
 Authorised: J.J. Singh
 Date: 16.03.2018
 Size: A1

Drawing Number: ELEC-TSTG-SB-01

Rev: R0

GENERAL NOTES:

1. THIS DRAWING IS THE COPYRIGHT OF INGENIOUS STUDIO PVT. LTD. AND MUST NOT BE REPRODUCED, COPIED OR USED WITHOUT THE ABOVE CONSULTANT'S AUTHORITY.
2. DO NOT SCALE FROM THE DRAWINGS.
3. ALL DIMENSIONS ARE IN MILLIMETRES AND LEVELS IN METRES UNLESS NOTED OTHERWISE. ALL DIMENSIONS TO BE VERIFIED ON SITE & APPROVED BY THE ENGINEER.
4. THIS DRAWING SHOULD BE READ IN CONJUNCTION WITH OTHER RELEVANT ARCHITECTURAL, STRUCTURAL, MECHANICAL AND ELECTRICAL DRAWINGS AND ALL RELEVANT SECTIONS OF THE SPECIFICATIONS.



FLOOR PLAN - TERRACE FLOOR

LEGENDS TABLE

| S.NO | SYMBOL | DESCRIPTION | UOM | |
|------|--------|---|-----|----|
| 1 | | 18W SURFACE/RECESS DIFFUSE DL, WIPRO LD06 | nos | 52 |
| 2 | | 10W 2FT. LED MIRROR LIGHT, WIPRO LL20-111 | nos | 16 |
| 3 | | S.B. (SWITCH BOARD) | nos | 22 |
| 4 | | D.B. (DISTRIBUTION BOARD) | nos | 4 |
| 5 | | 6A SWITCH AND SOCKET | nos | 31 |
| 6 | | 16A SWITCH AND SOCKET | nos | 24 |
| 7 | | EXHAUST FAN | nos | 2 |
| 8 | | WALL ROSE FOR EXHAUST FAN | nos | 2 |
| 9 | | 25W SURFACE/RECESS PANEL | nos | 70 |
| 10 | | 15W SURFACE/RECESS DIFFUSE DL, WIPRO LD06 | nos | 23 |
| 11 | | CEILING FAN | nos | 27 |


Purpose of Issue

TENDER

| | | | | | |
|-----|-------------|------|---------|------------|--|
| | | | | | |
| | | | | | |
| Rev | Description | Date | Checked | Authorised | |

Purpose of Issue

 ARCHITECTURAL CONSULTANTS



InGenious Studio pvt. ltd.

Office no. 334, Third Floor, Tower B-2 Telephone: +91-124-4363861

Space Tech Park Email : info@ingeniousstudio.in

Sohna Road, Gurgaon, Haryana, India Website : www.ingeniousstudio.in

STRUCTURAL CONSULTANTS

ELECTRICAL CONSULTANTS

PHE CONSULTANTS

Project:

TEMPLE AREA DEVELOPMENT-
TULSISHYAM TEMPLE, GUJARAT

Client:

GUJARAT PAVITRA
YATRADHAM VIKAS BOARD



Drawing title:

SATSANG HALL BLOCK
ELECTRICAL PLAN

| | | | | |
|----------------|----------------|----------------|----------------|------|
| Original Scale | Drawn | Checked | Authorised | Size |
| 1:50 | PRATHAM | J.J.Singh | J.J.Singh | A1 |
| Date: 16.03.28 | Date: 16.03.28 | Date: 16.03.28 | Date: 16.03.28 | Rev |

Drawing Number

ELEC-TSTG-SB-02

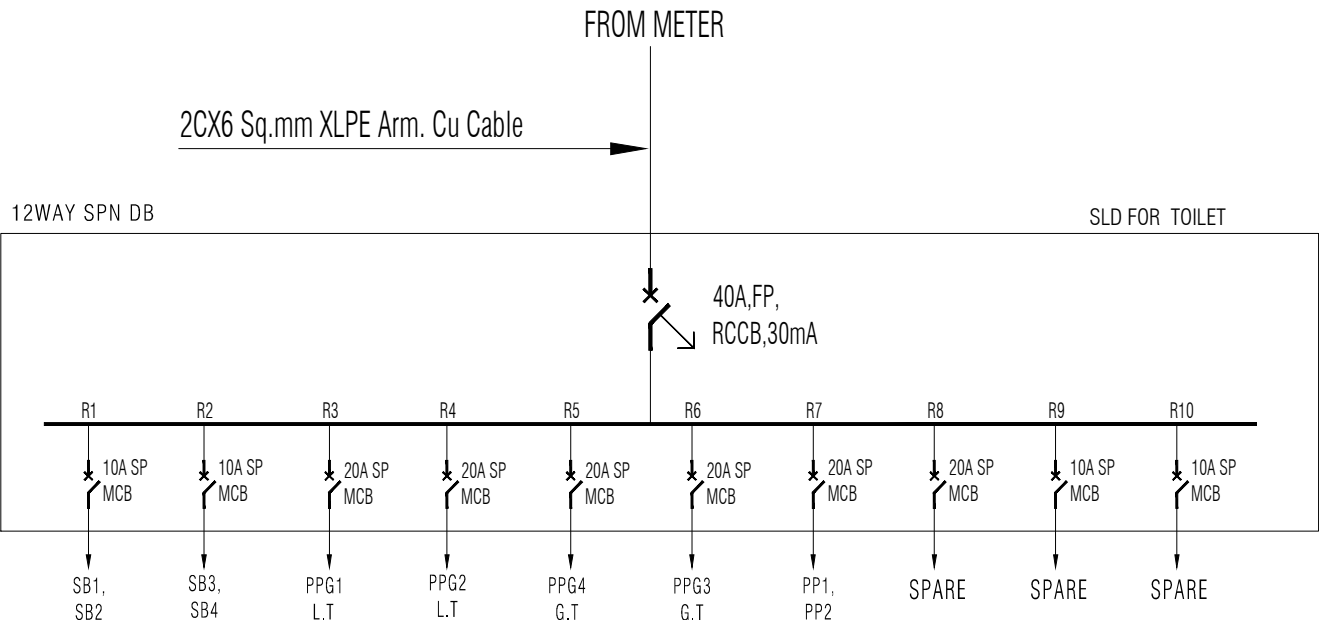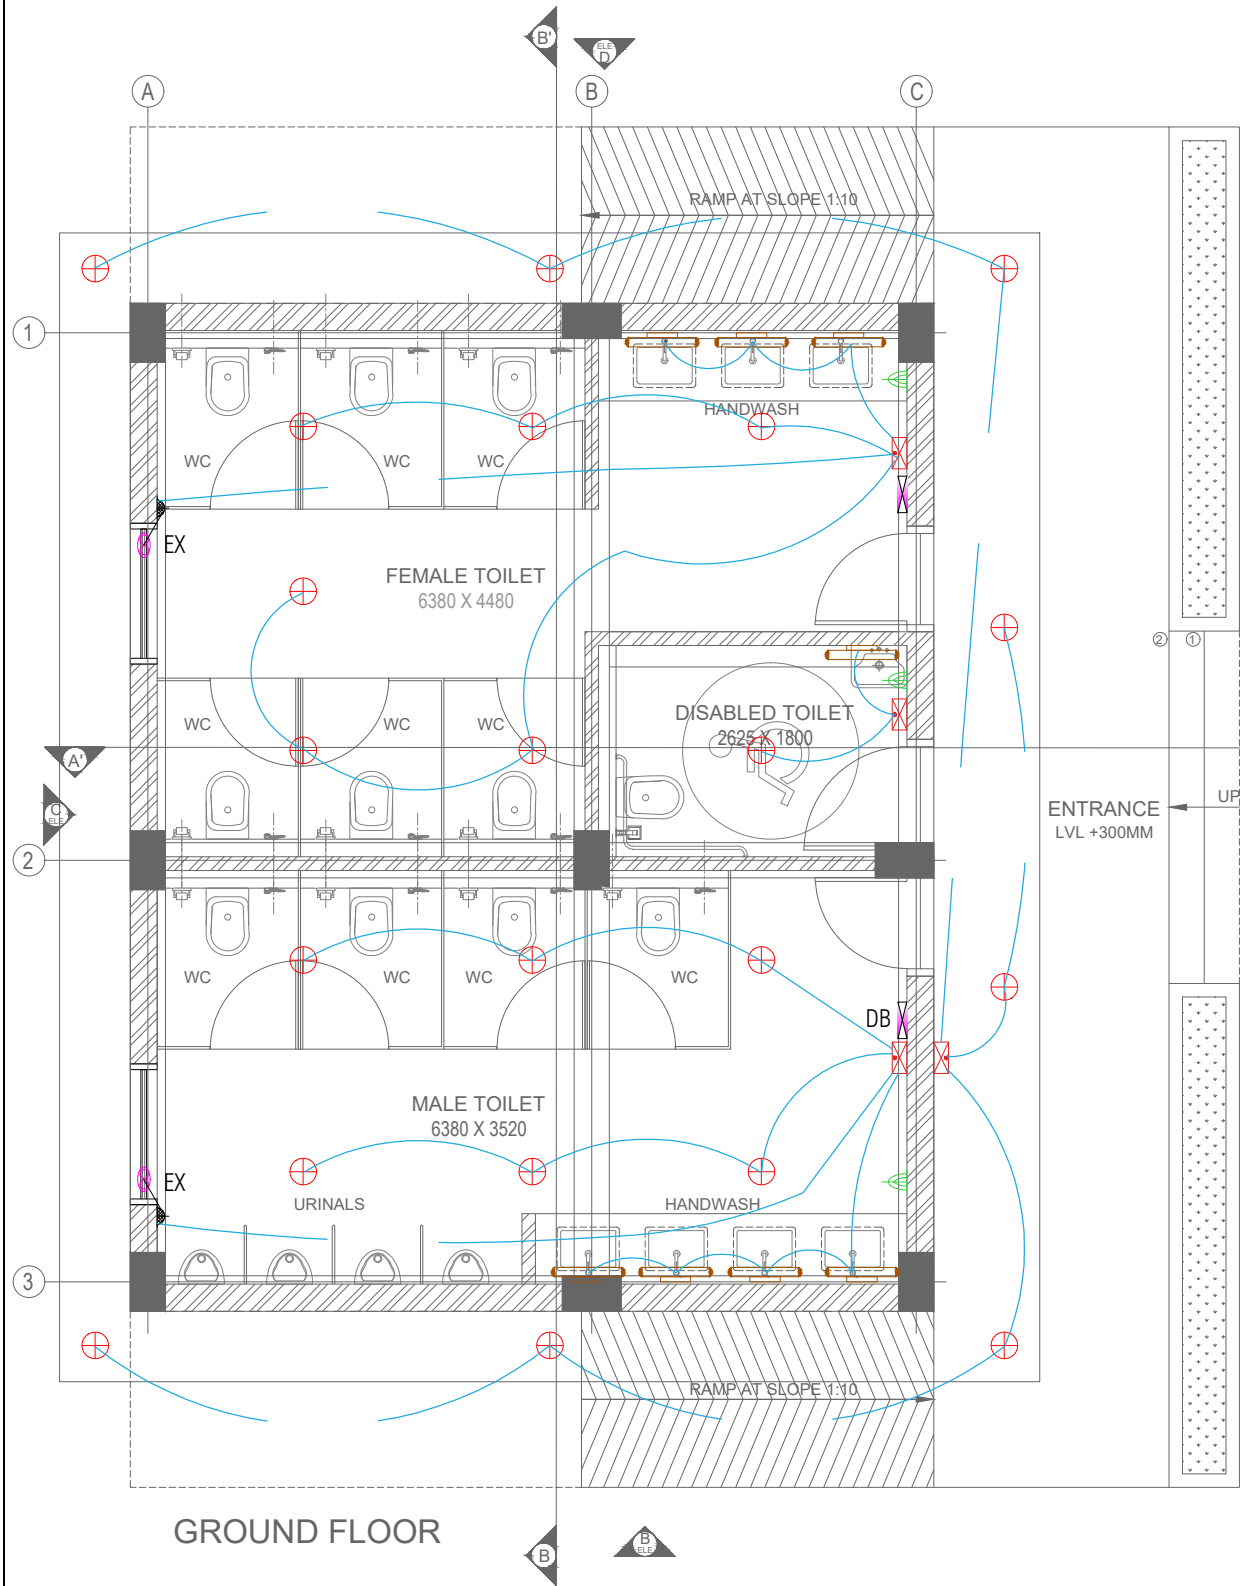

| LEGENDS TABLE | | | | |
|---------------|--------|---|-----|----|
| S.NO | SYMBOL | DESCRIPTION | UOM | |
| 1 | | 18W SURFACE/RECESS DIFFUSE DL, WIPRO LD06 | nos | 21 |
| 2 | | 10W 2FT. LED MIRROR LIGHT, WIPRO LL20-111 | nos | 8 |
| 3 | | S.B. (SWITCH BOARD) | nos | 4 |
| 4 | | D.B. (DISTRIBUTION BOARD) | nos | 2 |
| 5 | | 6A SWITCH AND SOCKET | nos | 3 |
| 6 | | EXHAUST FAN | nos | 2 |
| 7 | | WALL ROSE FOR EXHAUST FAN | nos | 2 |

InGenious Studio pvt. Ltd.

GENERAL NOTES:

1. THIS DRAWING IS THE COPYRIGHT OF INGENIOUS STUDIO PVT. LTD. AND MUST NOT BE REPRODUCED, COPIED OR USED WITHOUT THE ABOVE CONSULTANTS AUTHORITY.

2. DO NOT SCALE FROM THE DRAWINGS.

3. ALL DIMENSIONS ARE IN MILLIMETRES AND LEVELS IN METRES UNLESS NOTED OTHERWISE. ALL DIMENSIONS TO BE VERIFIED ON SITE & APPROVED BY THE ENGINEER.

4. THIS DRAWING SHOULD BE READ IN CONJUNCTION WITH OTHER RELEVANT ARCHITECTURAL, STRUCTURAL, MECHANICAL AND ELECTRICAL DRAWINGS AND ALL RELEVANT SECTIONS OF THE SPECIFICATIONS.

NORTH

| | | | | |
|---|----------------|----------------|----------------|------------|
| Purpose of Issue | | | | |
| TENDER | | | | |
| Rev | Description | Date | Checked | Authorised |
| | | | | |
| Purpose of Issue | | | | |
| ARCHITECTURAL CONSULTANTS | | | | |
| <p>InGenious Studio pvt. Ltd.</p> <p>Office no. 334, Third Floor, Tower B-2 Telephone: +91-124-4363861 Email: info@ingeniousstudio.in Space Tech Park, Sohna Road, Gurgaon, Haryana, India Website: www.ingeniousstudio.in</p> | | | | |
| STRUCTURAL CONSULTANTS | | | | |
| ELECTRICAL CONSULTANTS | | | | |
| P/E CONSULTANTS | | | | |
| Project: | | | | |
| TEMPLE AREA DEVELOPMENT- TULSISHYAM TEMPLE, GUJARAT | | | | |
| Client: | | | | |
| GUJARAT PAVITRA YATRADHAM VIKAS BOARD | | | | |
| Drawing title: | | | | |
| TOILET BLOCK ELECTRICAL PLAN | | | | |
| Original Scale | Drawn | Checked | Authorised | Size |
| 1:30 | PDA/THAM | J.J. Singh | J.J. Singh | A1 |
| Date: 16.03.20 | Date: 16.03.20 | Date: 16.03.20 | Date: 16.03.20 | Rev |
| Drawing Number | | | | R0 |
| ELEC-TSTG-TB-01 | | | | |



| | | | | |
|--|----------------|----------------|----------------|------------|
| InGenious Studio pvt. Ltd. <u>GENERAL NOTES:</u> 1. THIS DRAWING IS THE COPYRIGHT OF INGENIOUS STUDIO PVT. LTD. AND MUST NOT BE RETAINED, COPIED OR USED WITHOUT THE ABOVE CONSULTANT'S AUTHORITY. 2. DO NOT SCALE FROM THE DRAWINGS. 3. ALL DIMENSIONS ARE IN MILLIMETRES AND LEVELS IN METRES UNLESS NOTED OTHERWISE. ALL DIMENSIONS TO BE VERIFIED ON SITE & APPROVED BY THE ENGINEER. 4. THIS DRAWING SHOULD BE READ IN CONJUNCTION WITH OTHER RELEVANT ARCHITECTURAL, STRUCTURAL, MECHANICAL AND ELECTRICAL DRAWINGS AND ALL RELEVANT SECTIONS OF THE SPECIFICATIONS. | | | | |
| | | | | |
| TENDER | | | | |
| Rev# | Description | Date | Checked | Authorised |
| | | | | |
| ARCHITECTURAL CONSULTANTS | | | | |
| <div style="display: flex; align-items: center;"> <div> InGenious Studio pvt. Ltd. Office no. 334, Third Floor, Tower B-2 Telephone : +91-124-4383861 Spazio T Tech Park Email : info@ingeniousstudio.in Sohna Road, Gurgaon, Haryana, India Website : www.ingeniousstudio.in </div> </div> | | | | |
| STRUCTURAL CONSULTANTS | | | | |
| | | | | |
| ELECTRICAL CONSULTANTS | | | | |
| | | | | |
| PHE CONSULTANTS | | | | |
| | | | | |
| PROJECT: | | | | |
| TEMPLE AREA DEVELOPMENT- TULSI SHYAM TEMPLE, GUJARAT | | | | |
| CLIENT: | | | | |
| GUJARAT PAVITRA YATRADHAM VIKAS BOARD | | | | |
| Drawing title: <div style="text-align: center; font-weight: bold;"> GUARD ROOM ELECTRICAL PLAN </div> | | | | |
| Original Scale | Drawn | Checked | Authorised | Size |
| N.T.S | PRATHAM | J.J. Singh | J.J. Singh | A1 |
| | Date: 16.03.26 | Date: 16.03.26 | Date: 16.03.26 | |
| Drawing Number <div style="text-align: center; font-weight: bold;">ELEC-TSTG-GR-01</div> | | | | |