


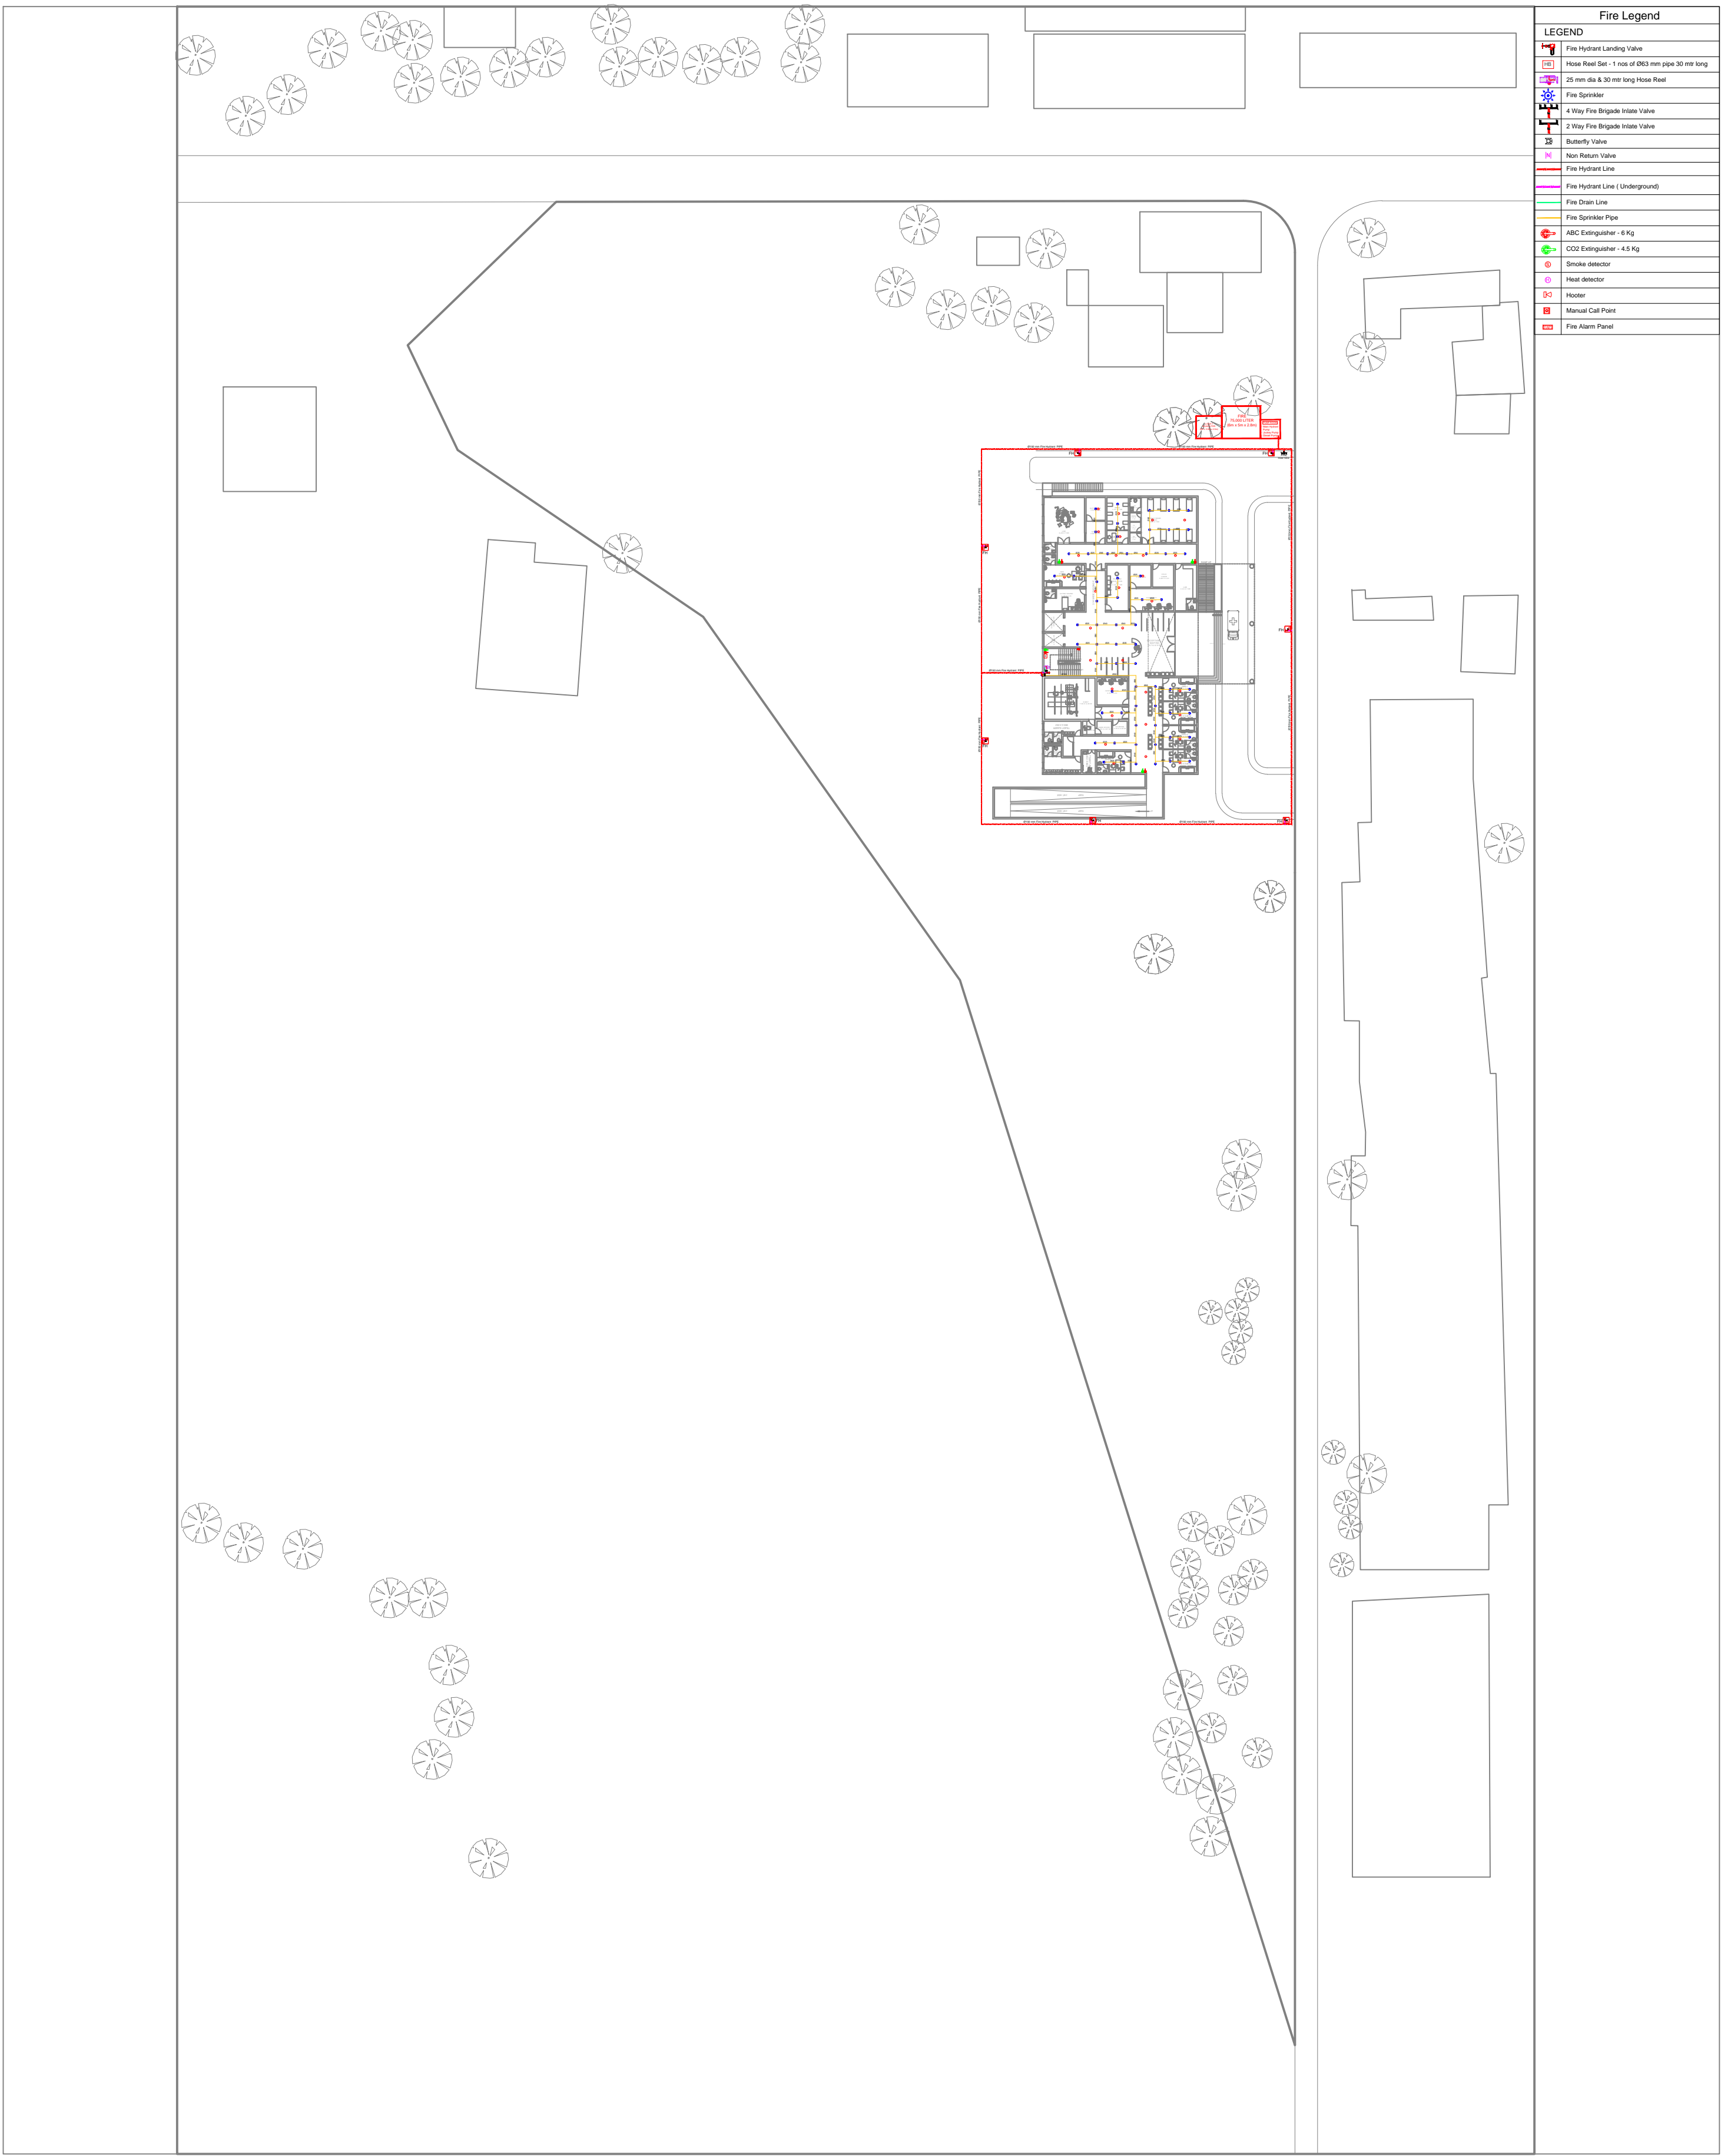





Fire Legend	
LEGEND	
	Fire Hydrant Landing Valve
	Hose Reel Set - 1 nos of Ø63 mm pipe 30 mtr long
	25 mm dia & 30 mtr long Hose Reel
	Fire Sprinkler
	4 Way Fire Brigade Inlets Valve
	2 Way Fire Brigade Inlets Valve
	Butterfly Valve
	Non Return Valve
	Fire Hydrant Line
	Fire Hydrant Line (Underground)
	Fire Drain Line
	Fire Sprinkler Pipe
	ABC Extinguisher - 6 Kg
	CO2 Extinguisher - 4.5 Kg
	Smoke detector
	Heat detector
	Hooter
	Manual Call Point
	Fire Alarm Panel

	MEDICAL AUTHORITY	DEE,PIU ZONE 5 :-	EE,PIU ZONE 5 :-	PROJECT :NEW CONSTRUCTION 30 BEDDED CHC AT. THANGADHA, TA. THANGADHA , DIST. SURENDRANAGAR.	STAGE :- CONCEPTUAL	DATE:- 08-10-2024	SCALE :- N.T.S	ARCHITECTS : <div></div> <div>SARJAN ARCHITECTS</div> <div>& PROJECT CONSULTANTS</div> <div>51, River Palace- A, Opp. Old Civil Court, Nanpura, Surat- 395001. E-Mail: sarjanarch.pc@gmail.com Web: www.sarjanarchitects.com</div> <div>Contact: +91-261-2476778/ 9879604444</div>
	SIGN & STAMP:-	SIGN & STAMP:-	SIGN & STAMP:-	ARCHITECT SIGN & STAMP :- <div></div>	DRAWING TITLE :			
					SITE PLAN			
					TOTAL BUILT UP AREA = 2401.97 SQ.MT. <div></div>			






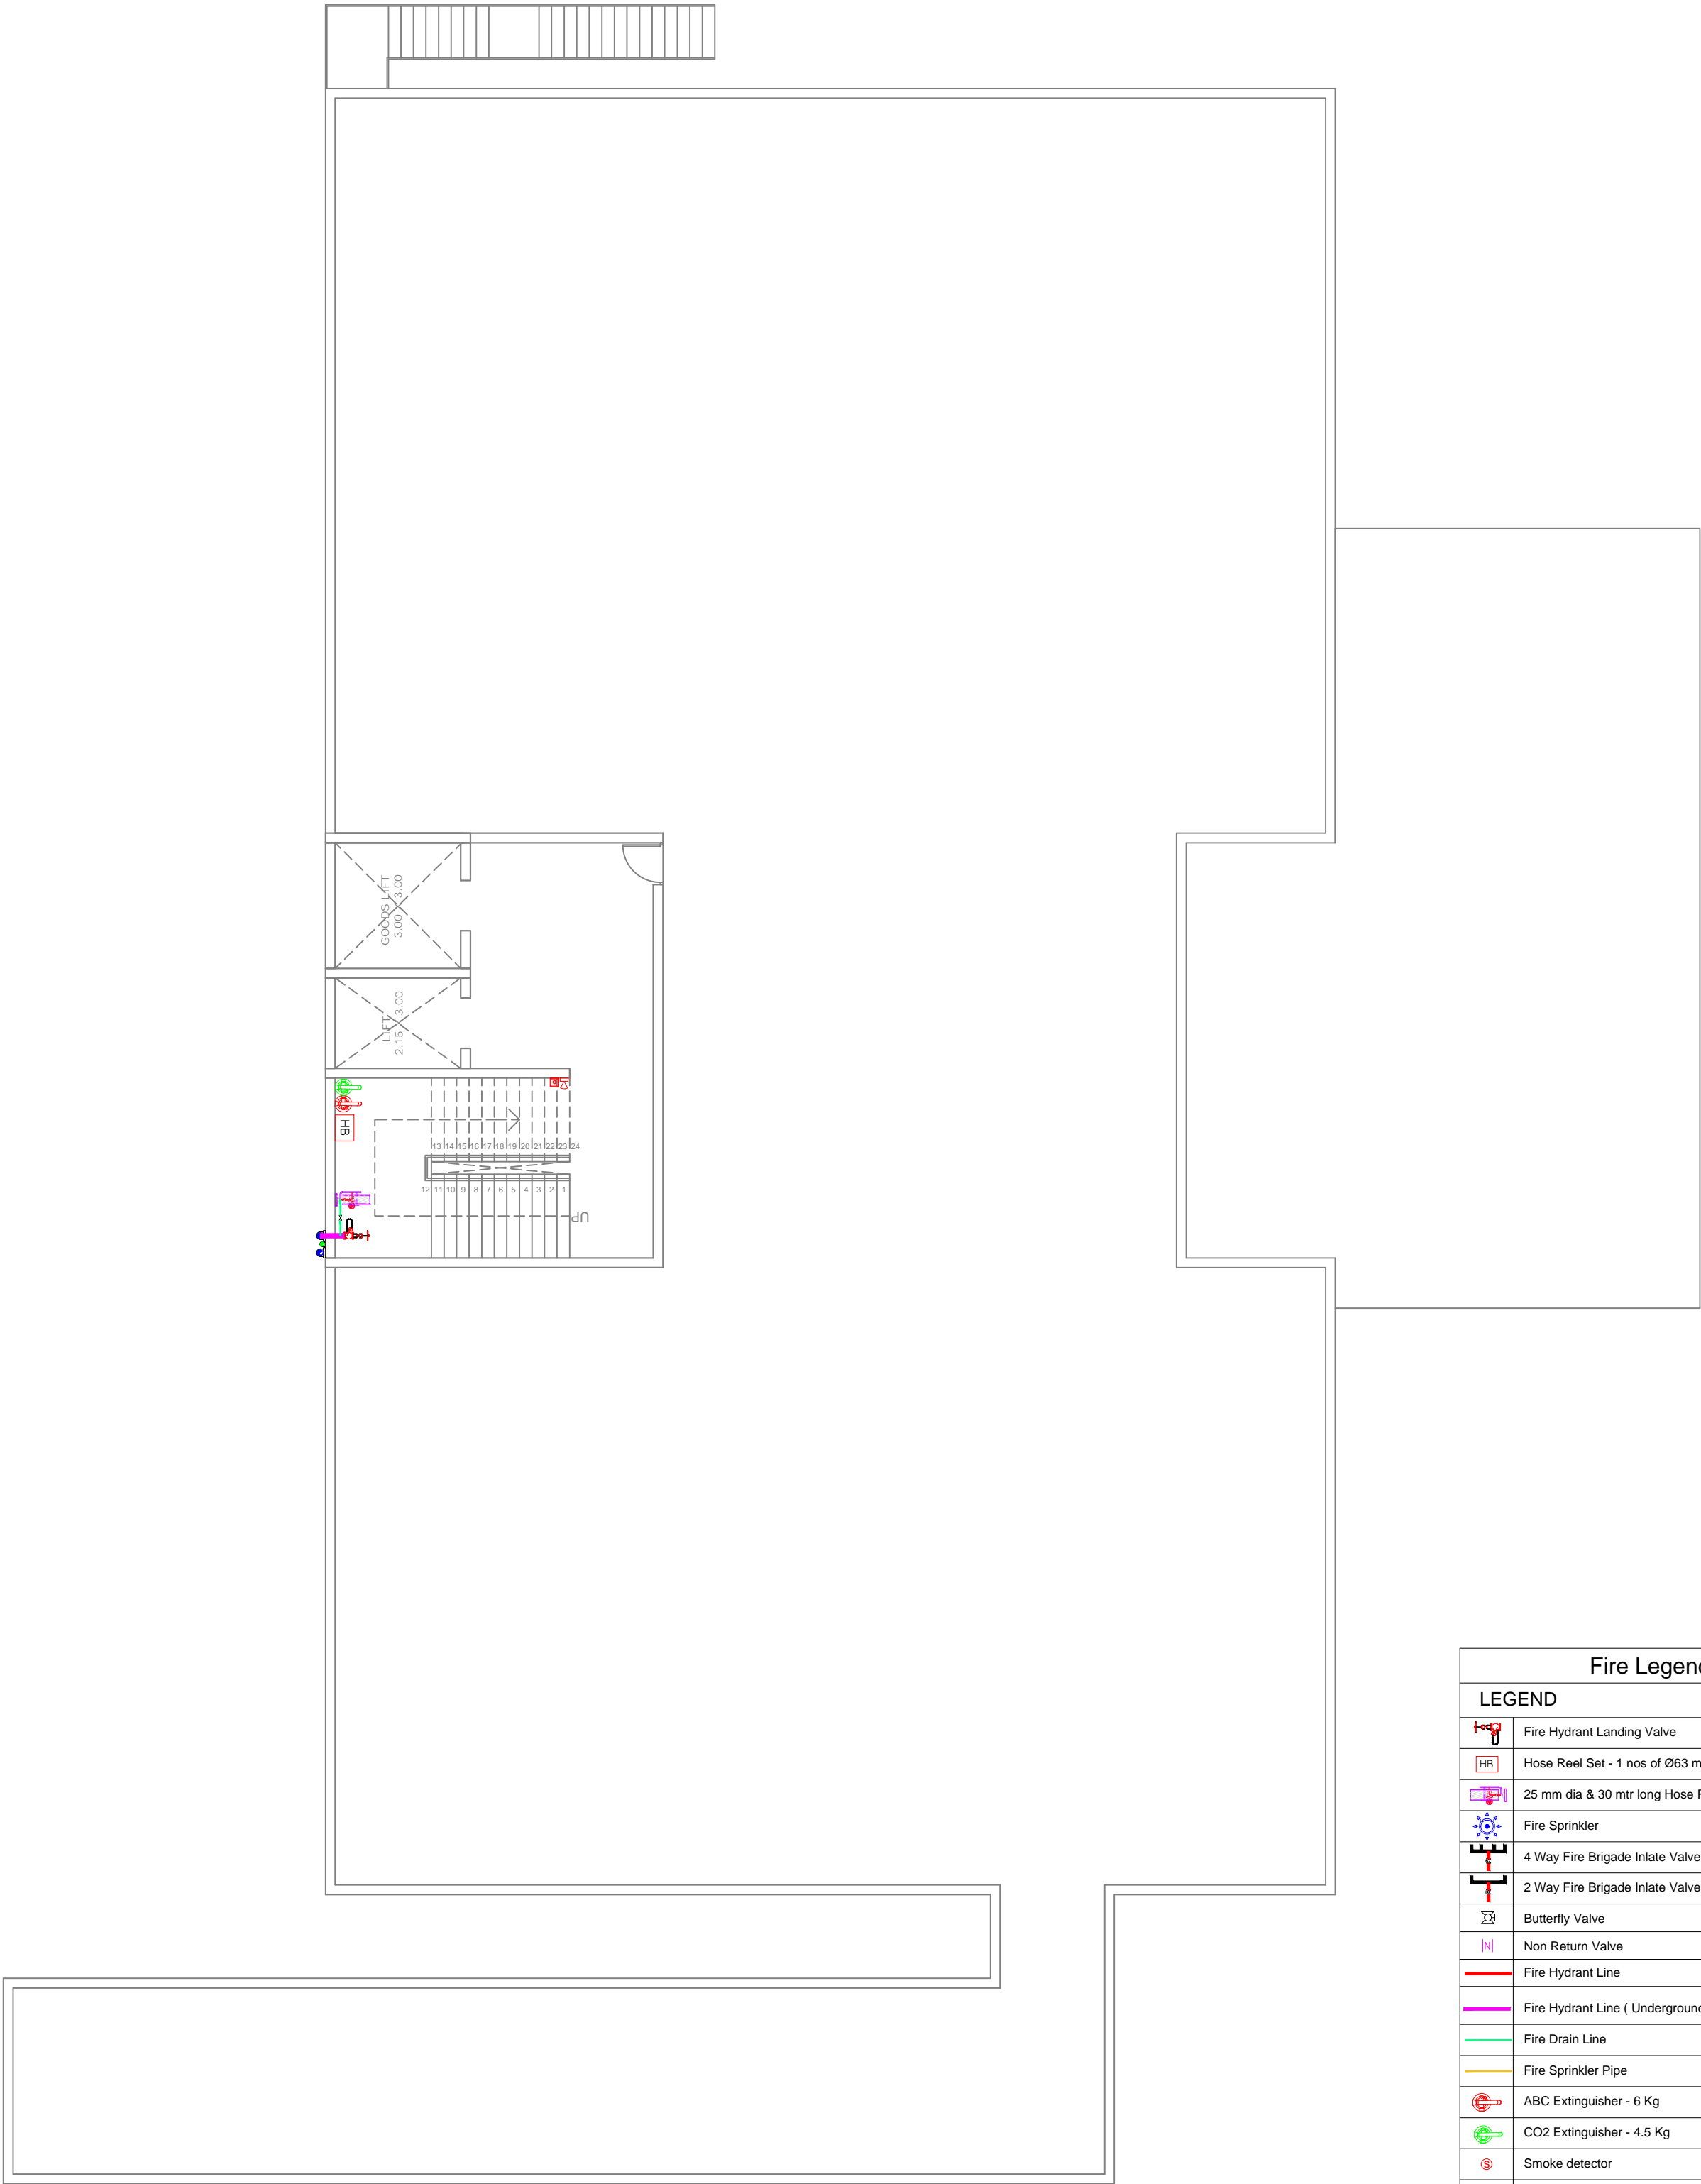
Fire Legend	
LEGEND	
	Fire Hydrant Landing Valve
	Hose Reel Set - 1 nos of Ø63 mm pipe 30 mtr long
	25 mm dia & 30 mtr long Hose Reel
	Fire Sprinkler
	4 Way Fire Brigade Inlet Valve
	2 Way Fire Brigade Inlet Valve
	Butterfly Valve
	Non Return Valve
	Fire Hydrant Line
	Fire Hydrant Line (Underground)
	Fire Drain Line
	Fire Sprinkler Pipe
	ABC Extinguisher - 6 Kg
	CO2 Extinguisher - 4.5 Kg
	Smoke detector
	Heat detector
	Hooter
	Manual Call Point
	Fire Alarm Panel

	MEDICAL AUTHORITY	DEE,PIU ZONE S. :-	EE, PIU ZONE S. :-	PROJECT :NEW CONSTRUCTION 30 BEDDED CHC AT. THANGADHA, TA. THANGADHA , DIST. SURENDRANAGAR.	STAGE :- CONCEPTUAL	DATE:- 08-10-2024	SCALE :- N.T.S	ARCHITECTS : <div><div>SARJAN ARCHITECTS & PROJECT CONSULTANTS</div><div>51, River Palace- A, Opp. Old Civil Court, Nanpura, Surat- 395001. E-Mail: sarjanarch.pc@gmail.com Web: www.sarjanarchitects.com</div><div>Contact: +91-261-2476778/ 9879604444</div></div>
	SIGN & STAMP:-	SIGN & STAMP:-	SIGN & STAMP:-	ARCHITECT SIGN & STAMP :- <div></div>	DRAWING TITLE : <div>SITE PLAN</div>			
					TOTAL BUILT UP AREA = 2401.97 SQ.MT.			



Fire Legend	
LEGEND	
	Fire Hydrant Landing Valve
	Hose Reel Set - 1 nos of Ø63 mm pipe 30 mtr long
	25 mm dia & 30 mtr long Hose Reel
	Fire Sprinkler
	4 Way Fire Brigade Inlet Valve
	2 Way Fire Brigade Inlet Valve
	Butterfly Valve
	Non Return Valve
	Fire Hydrant Line
	Fire Hydrant Line (Underground)
	Fire Drain Line
	Fire Sprinkler Pipe
	ABC Extinguisher - 6 Kg
	CO2 Extinguisher - 4.5 Kg
	Smoke detector
	Heat detector
	Hooter
	Manual Call Point
	Fire Alarm Panel

	MEDICAL AUTHORITY	DEE PIU ZONE 5 :-	EE PIU ZONE 5 :-	PROJECT : NEW CONSTRUCTION 30 BEDDED CHC AT. THANGADHA , TA.THANGADHA ,DIST. SURENDRANAGAR.	STAGE :- CONCEPTUAL	DATE:- 08-10-2024	SCALE :- N.T.S	ARCHITECTS : <div> SARJAN ARCHITECTS & PROJECT CONSULTANTS 51, River Palace- A, Opp. Old Civil Court, Nanpura, Surat- 395001. E-Mail: sarjanarch.pc@gmail.com Web: www.sarjanarchitects.com Contact: +91-261-2476778/ 9879604444</div>
	SIGN & STAMP:-	SIGN & STAMP:-	SIGN & STAMP:-		DRAWING TITLE : <div>GROUND FLOOR PLAN</div>			
				ARCHITECT SIGN & STAMP :- <div></div>	BUILT UP AREA = 1245.39 SQMT. TOTAL BUILT UP AREA = 2401.97 SQ.MT.			<div></div>



Fire Legend	
LEGEND	
	Fire Hydrant Landing Valve
	Hose Reel Set - 1 nos of Ø63 mm pipe 30 mtr long
	25 mm dia & 30 mtr long Hose Reel
	Fire Sprinkler
	4 Way Fire Brigade Inlate Valve
	2 Way Fire Brigade Inlate Valve
	Butterfly Valve
	Non Return Valve
	Fire Hydrant Line
	Fire Hydrant Line (Underground)
	Fire Drain Line
	Fire Sprinkler Pipe
	ABC Extinguisher - 6 Kg
	CO2 Extinguisher - 4.5 Kg
	Smoke detector
	Heat detector
	Hooter
	Manual Call Point
	Fire Alarm Panel

	MEDICAL AUTHORITY	DEF. PIU ZONE S. :-	EE. PIU ZONE S. :-	PROJECT : NEW CONSTRUCTION 30 BEDDED CHC AT. THANGADHA , TA.THANGADHA ,DIST. SURENDRANAGAR.	STAGE :- CONCEPTUAL	DATE:- 08-10-2024	SCALE :- N.T.S	ARCHITECTS : SARJAN ARCHITECTS & PROJECT CONSULTANTS S1, River Palace- A, Opp. Old Civil Court, Nanpura, Surat- 395001. E-Mail: sarjanarch.pc@gmail.com Web: www.sarjanarchitects.com Contact: +91-261-2476778/ 9879604444
	SIGN & STAMP:-	SIGN & STAMP:-	SIGN & STAMP:-	ARCHITECT SIGN & STAMP :- 	DRAWING TITLE : TERRACE FLOOR PLAN	BUILT UP AREA = 68.16 SQMT.		