

1 2 3 4 5 6 7 8

A


B

C

D

E

F

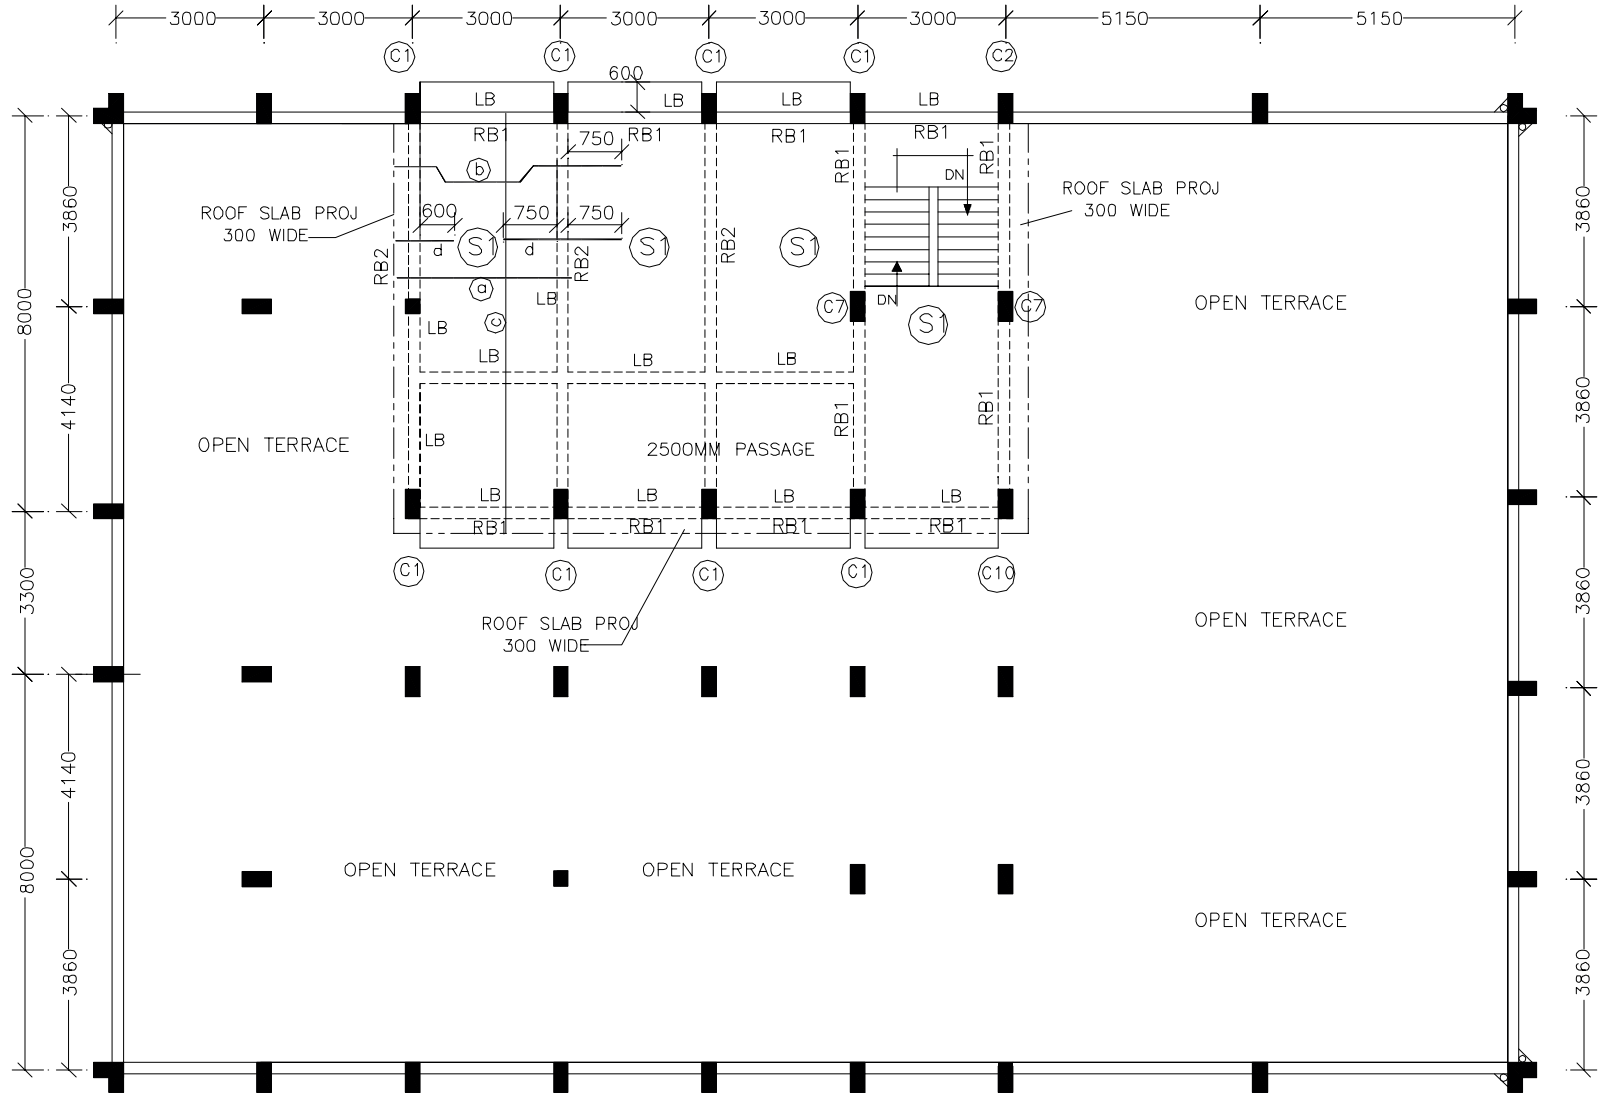

FIRST FLOOR PLAN

KARNATAKA POWER TRANSMISSION CORORATION LTD

220KV SUB STATION CONTROL ROOM  
FIRST FLOOR LINTEL, ROOF BEAM, ROOF SLAB, COLUMN LAYOUT

SHEET 1 OF 2

DRG NO: CEE(P & C)/SE(C)/06-07/220/007

|        |        |           |   |                                 |
|--------|--------|-----------|---|---------------------------------|
| GRRAJU |        |           |   | NTS                             |
| HDM    | AEE(C) | SE(CIVIL) | CHIEF ENGINEER ELE<br>PLANING & CO ORDINATION | PLANING<br>AND<br>CO ORDINATION |
| DRN    | DGN    | CHD       | REC   | APPROVED                        |

1 2 3 4 5 6 7 8