


2ND FLOOR ELECTRICAL PLAN

LEGENDS:	
	CCTV
	PROJECTOR POINT
	SPLIT AC
	ONE WAY CASSETTE AC
	CASSETTE AC
	CHANDELIER POINT
	NOTE: eg.(6M) M = MODULE

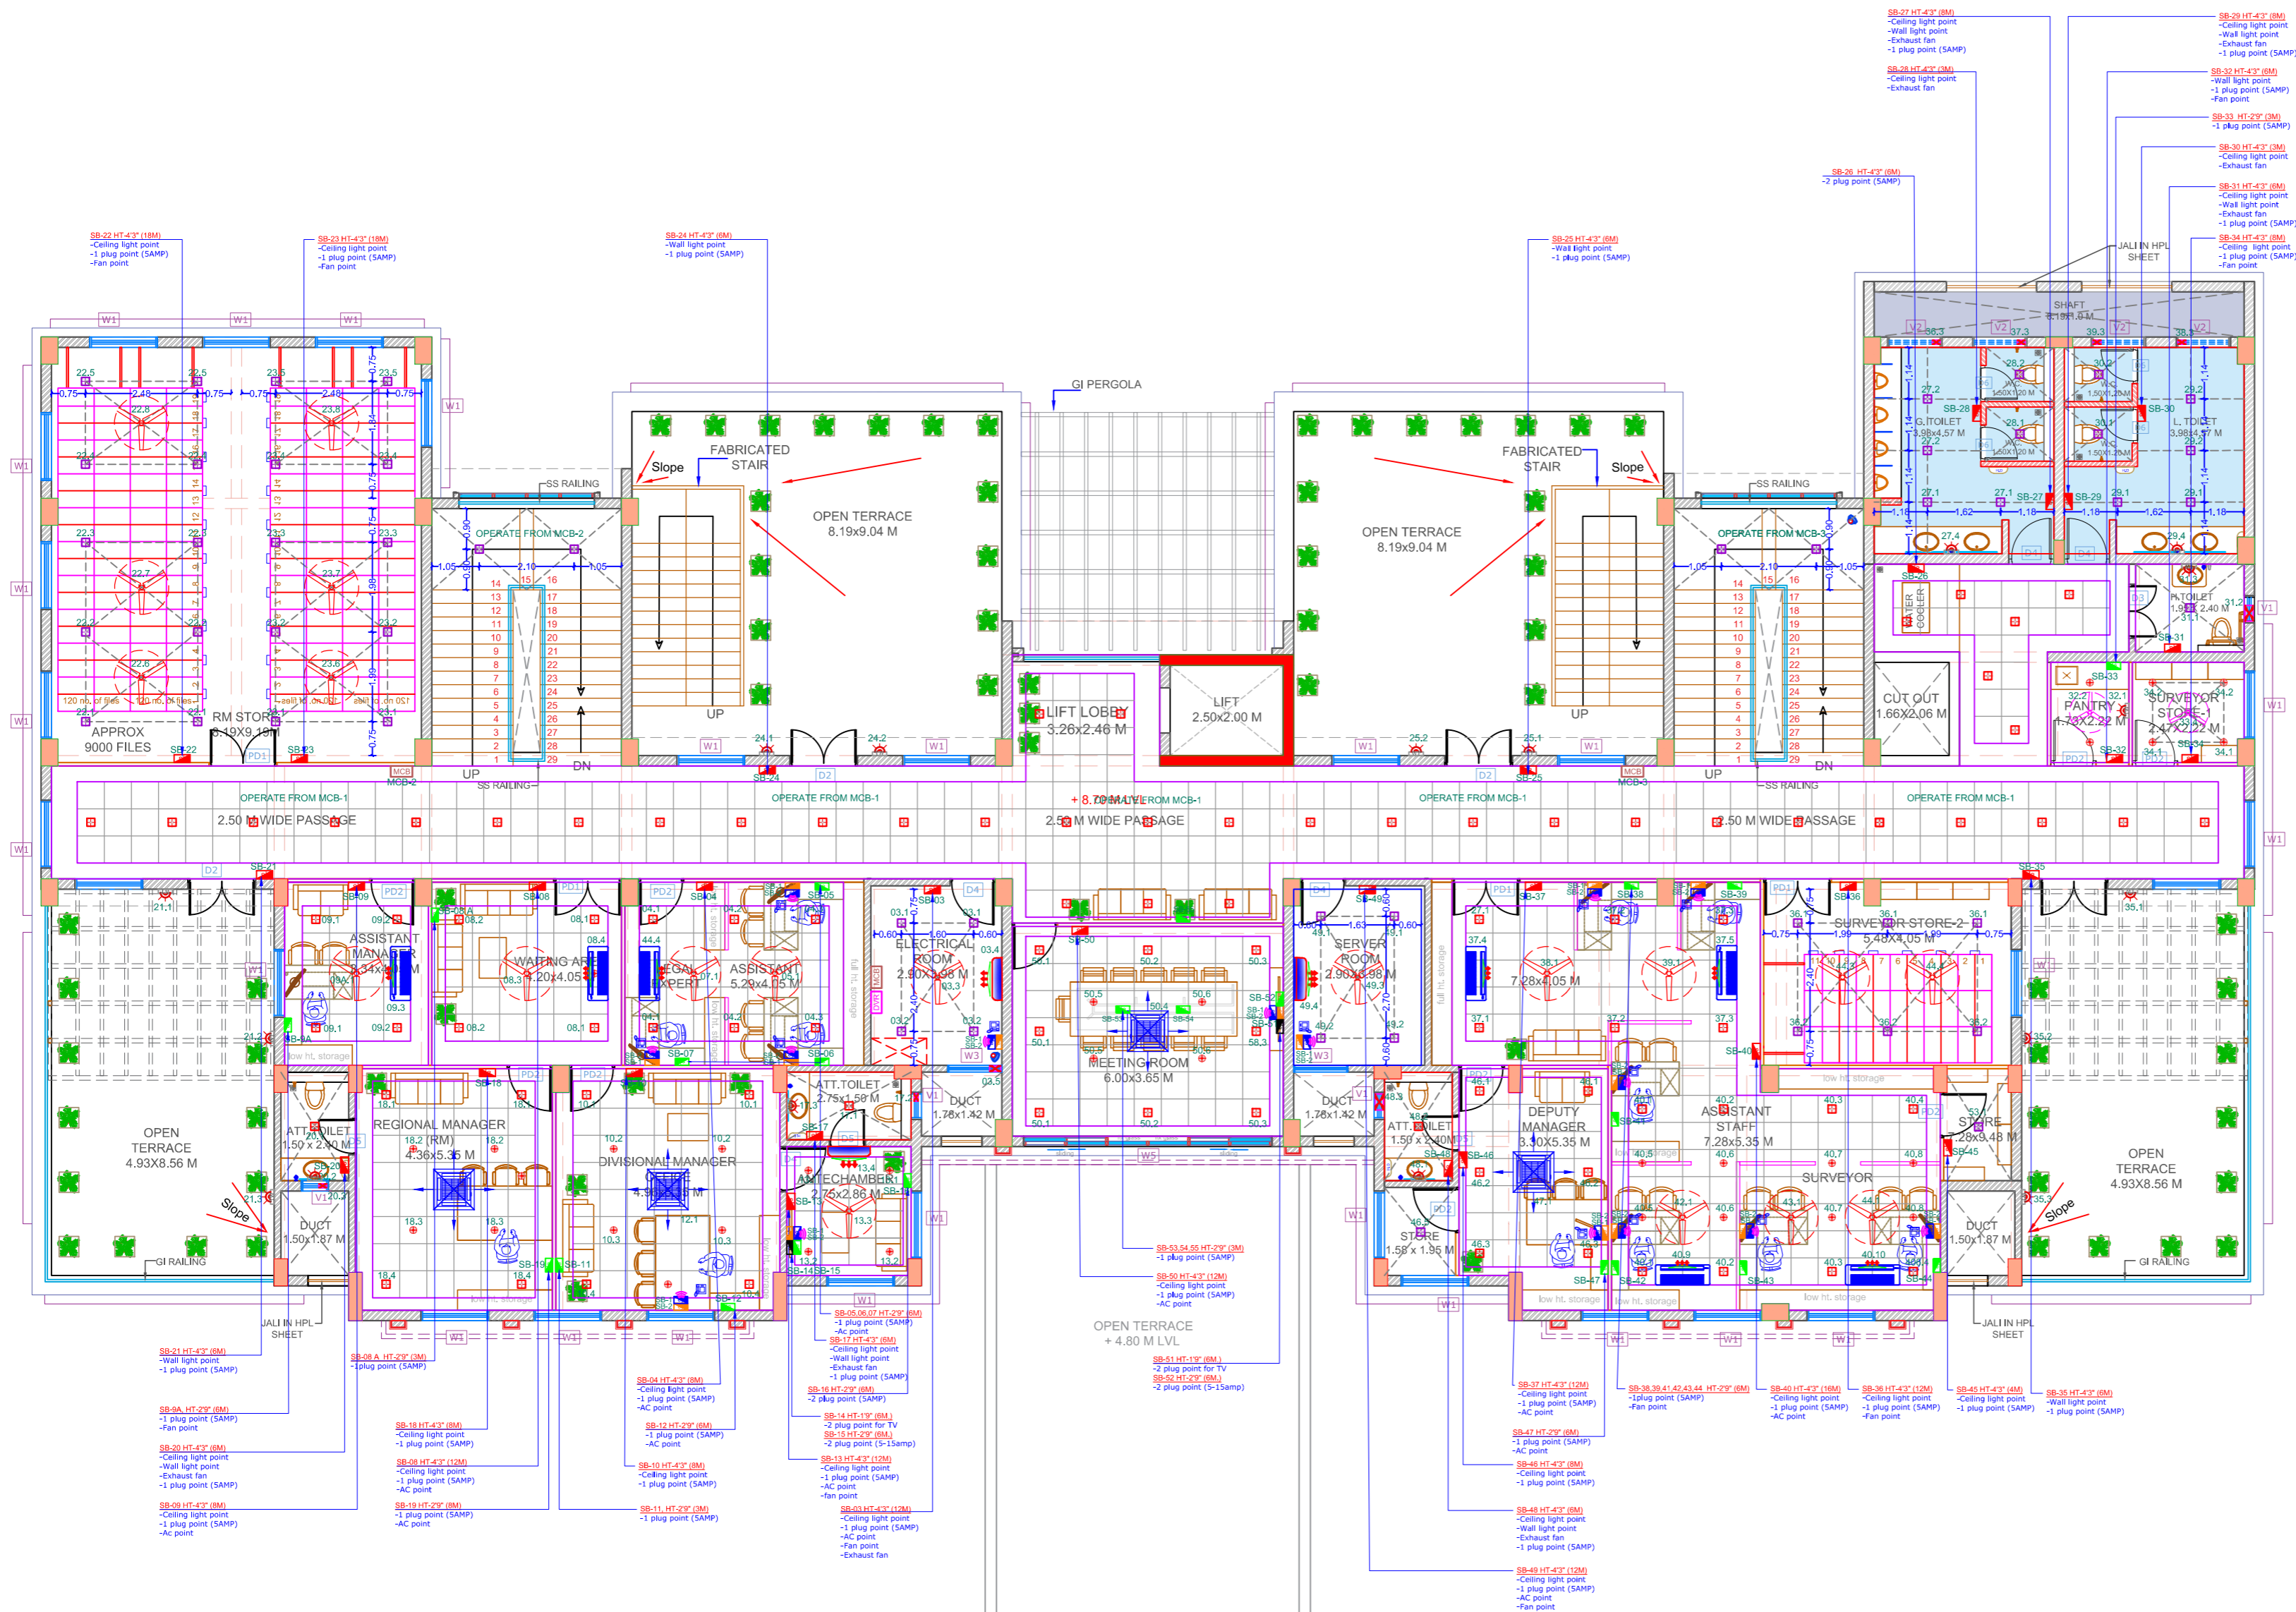

NO.	DESCRIPTION	DATE	PRINT	SIGN.
R0			B C E	
REVISION				

SIGN & STAMP:-

CLIENT : G.I.D.C. VADODARA

PROJECT TITLE :
G.I.D.C. OFFICE BUILDING
AT VADODARA

STAGE	DATE	SCALE
CONCEPTUAL	02-03-2026	N.T.S.

DRAWING TITLE : 2ND FLOOR ELECTRICAL PLAN OPTION-4	
--	--

ARCHITECTS:

SARJAN ARCHITECTS
& PROJECT CONSULTANTS
51, River Palace- A, Opp. Old Civil Court, Nanpura, Surat- 395001.
E-Mail: sarjanarch.pc@gmail.com Web: www.sarjanarchitects.com
Contact: +91-261-2476778/ 9879604444