

GROUND FLOOR PLAN

ELECTRICAL LEGEND:					
	T	TUBE LIGHT FIXTURE		TP	TELEPHONE POINT
	CL	CEILING LIGHT POINT		TV	TELEVISION POINT
	BL	BRACKET LIGHT POINT		PP	20A PLUG WITH 20A SWITCH
	SB	SWITCH BOARD		EXT	EXHAUST FAN
	F	FAN POINT		ML	MIRROR LIGHT
				BP	BELL PUSH SWITCH
				BZ	BELL BUZZER
	P	6A PLUG POINT WITH 6A SWITCH		PP	6/16A PLUG POINT WITH 16A SWITCH
	VDP	VIDEO DOOR PHONE			LIGHTING DISTRIBUTION BOARD

DRAWING NO.	01 / ELECTRICAL - TYPE - B1		
ARCHITECT	VISHESH CONSULTANTS		
SCALE	NTS	CHECKED BY	APURVA
DATE	06/03/2025		

- GENERAL NOTES
1. THE ARCHITECT/ARCHITECTURAL CONSULTANT NEEDS TO BE NOTIFIED IN CASE OF ANY DISCREPANCY BETWEEN THE DRAWINGS AND THE CONDITION ON SITE.
 2. FOR ALL SPECIALIST WORKS & DETAILS THE CONTRACTOR / SUB-CONTRACTOR ARE TO PROVIDE DETAILED SHOP DRAWINGS FOR ARCHITECT'S / ARCHITECTURAL CONSULTANT'S / ENGINEER'S APPROVAL PRIOR TO CONSTRUCTION.
 3. THERE SHALL BE NO DEVIATION FROM THE APPROVED DRAWINGS WITHOUT PRIOR CONSENT OF THE ARCHITECT / ARCHITECTURAL CONSULTANT / ENGINEER.
 4. THIS DRAWING SHOULD BE READ AND NOT MEASURED.
 5. ALL DIMENSIONS ARE IN METERS AND LEVELS ARE IN METERS UNLESS STATED OTHERWISE.
 6. ALL DRAWINGS MUST BE CROSS-REFERENCED IN CASE OF ANY DOUBT / DISCREPANCY.
 7. TOC REPRESENTS TOP OF CONCRETE & FFL REPRESENTS FINISHED FLOOR LEVEL. ALL DIMENSIONS SHOWN IN THE DRAWINGS ARE STRUCTURAL / MASONRY DIMENSIONS.
 8. ALL ARCHITECTURAL DRAWINGS MUST BE REFERRED IN COORDINATION WITH STRUCTURAL DRAWINGS.

AREA STATEMENT	
USABLE FLOOR SPACE AREA OF TYPE B1	40.70 SQ.MT
SINGLE QUARTER ON GROUND FLOOR	
TOTAL BUILT UP AREA ON GROUND FLOOR	132.92 SQ.MT

DRAWING TITLE	NORTH
GROUND FLOOR PLAN	


PROJECT NAME
ELECTRICAL LAYOUT OF B1 TYPE (2nos) STAFF QUARTERS

CLIENT
ANAND AGRICULTURAL UNIVERSITY

This Drawing is the Property of **VISHESH CONSULTANTS** and it should not be used in full or part without their prior permission.

ARCHITECT
VISHESH CONSULTANTS
ARCHITECTURE, INTERIORS AND ENGINEERING CONSULTANCY
7, FIRST FLOOR, CLASSIC COMPLEX, PRODUCTIVITY ROAD, AKOTA, VADODARA M 3825050577

VISHESH CONSULTANTS

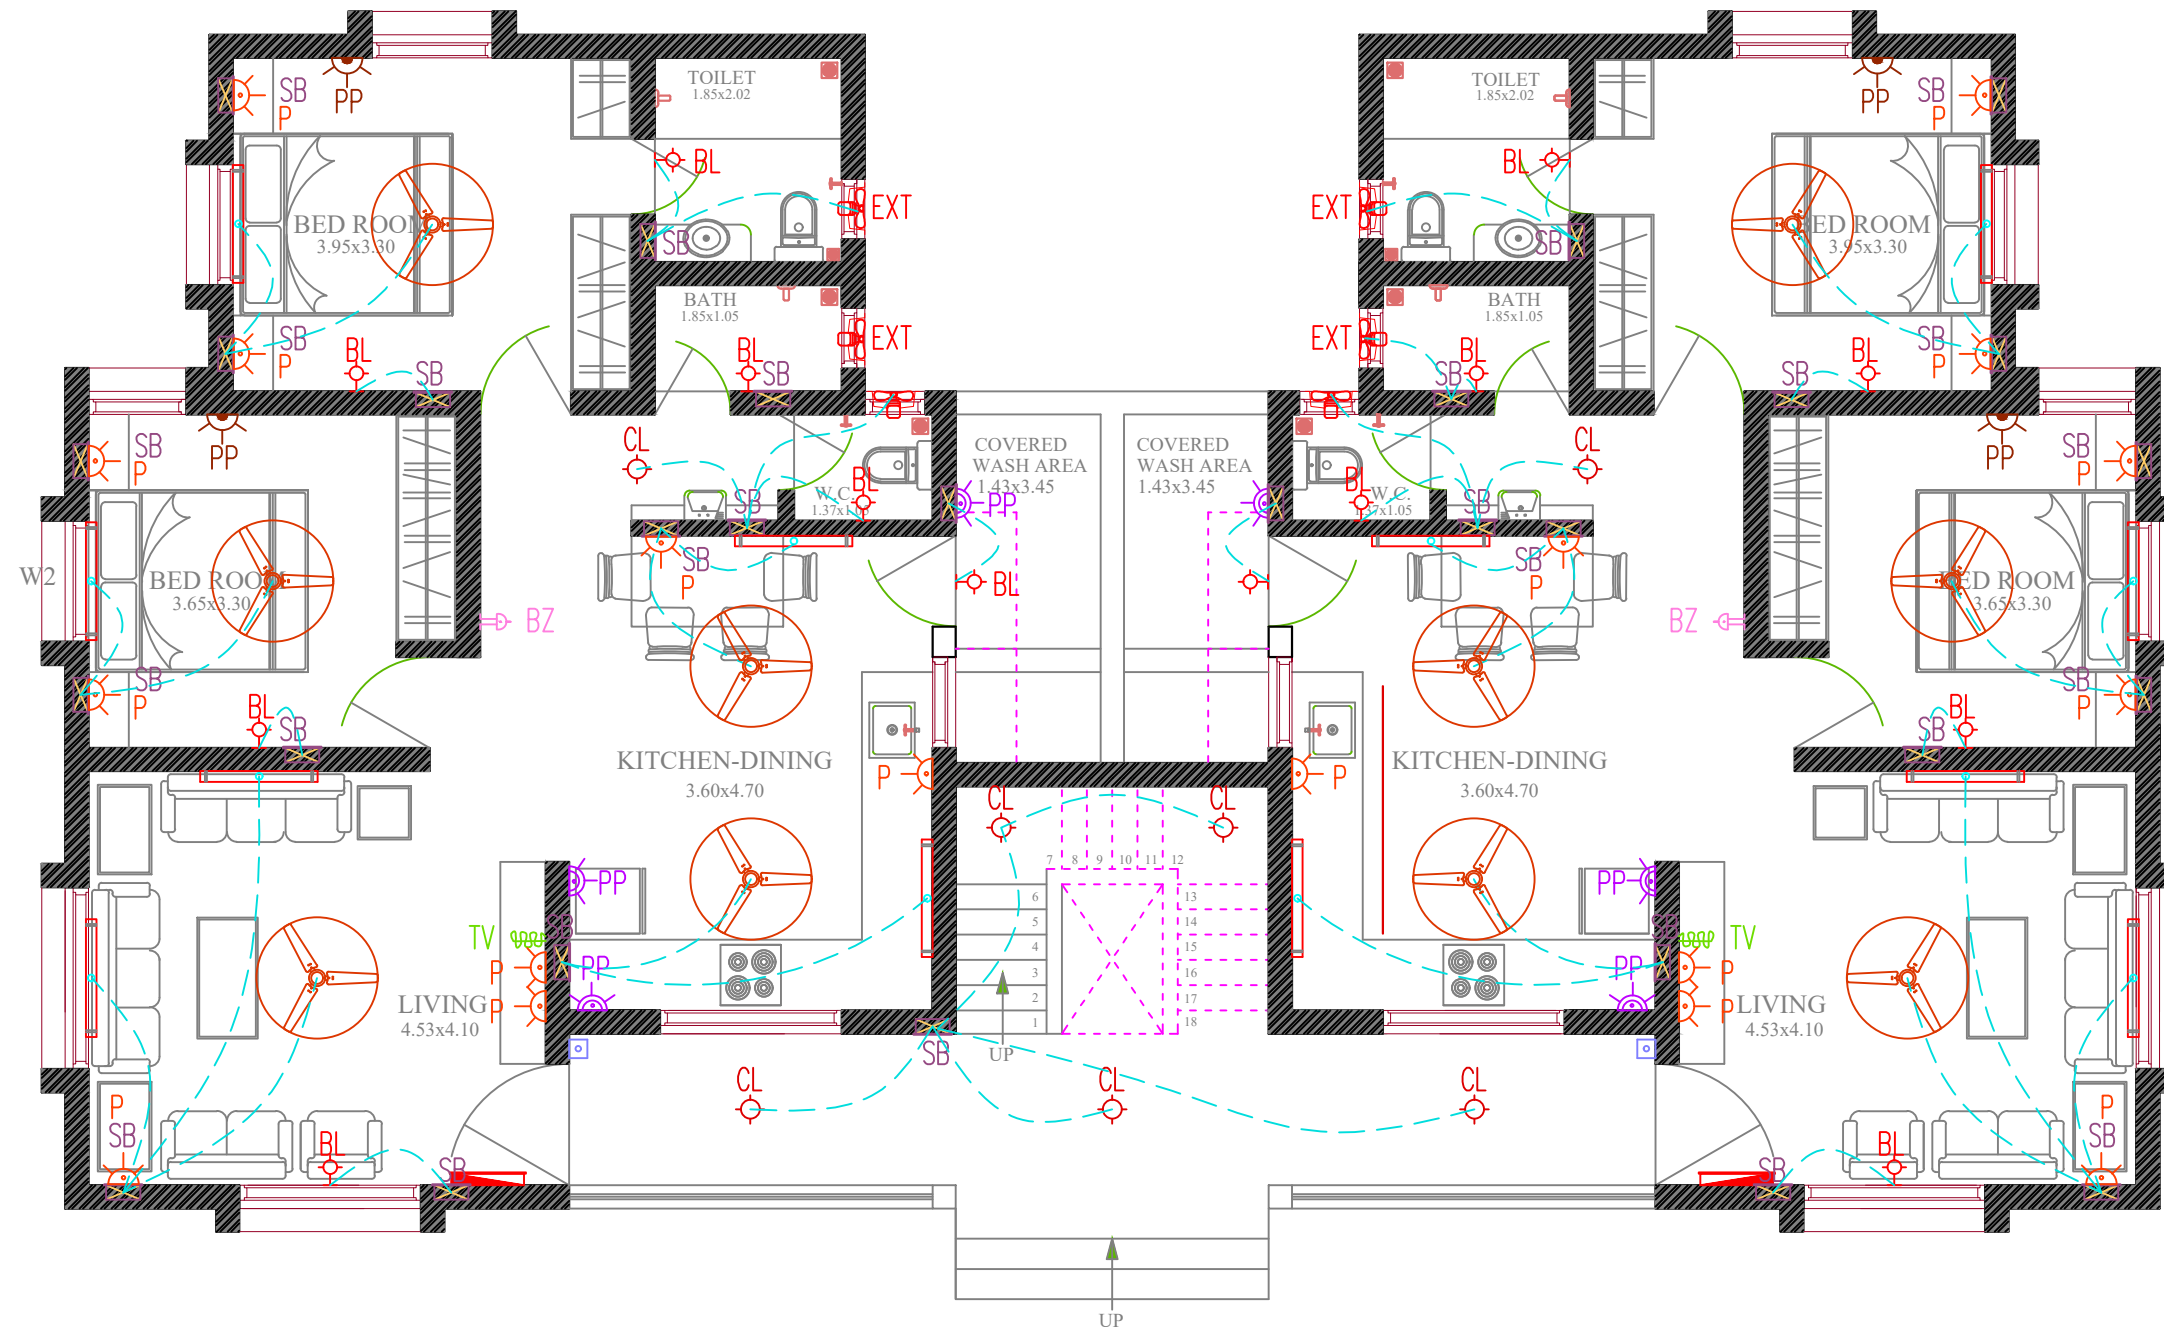

GROUND FLOOR PLAN

ELECTRICAL LEGEND:					
	T	TUBE LIGHT FIXTURE		TP	TELEPHONE POINT
	CL	CEILING LIGHT POINT		TV	TELEVISION POINT
	BL	BRACKET LIGHT POINT		PP	20A PLUG WITH 20A SWITCH
	SB	SWITCH BOARD		EXT	EXHAUST FAN
	F	FAN POINT		ML	MIRROR LIGHT
				BP	BELL PUSH SWITCH
				BZ	BELL BUZZER
	P	6A PLUG POINT WITH 6A SWITCH		PP	6/16A PLUG POINT WITH 16A SWITCH
	VDP	VIDEO DOOR PHONE			LIGHTING DISTRIBUTION BOARD

DRAWING NO.	02 / ELECTRICAL - TYPE - D1		
ARCHITECT	VISHESH CONSULTANTS		
SCALE	NTS	CHECKED BY	APURVA
DATE	16/03/2025		

GENERAL NOTES

1. THE ARCHITECT/ARCHITECTURAL CONSULTANT NEEDS TO BE NOTIFIED IN CASE OF ANY DISCREPANCY BETWEEN THE DRAWINGS AND THE CONDITION ON SITE.
2. FOR ALL SPECIALIST WORKS & DETAILS THE CONTRACTOR / SUB-CONTRACTOR ARE TO PROVIDE DETAILED SHOP DRAWINGS FOR ARCHITECT'S / ARCHITECTURAL CONSULTANT'S / ENGINEER'S APPROVAL PRIOR TO CONSTRUCTION.
3. THERE SHALL BE NO DEVIATION FROM THE APPROVED DRAWINGS WITHOUT PRIOR CONSENT OF THE ARCHITECT / ARCHITECTURAL CONSULTANT / ENGINEER.
4. THIS DRAWING SHOULD BE READ AND NOT MEASURED.
5. ALL DIMENSIONS ARE IN METERS AND LEVELS ARE IN METERS UNLESS STATED OTHERWISE.
6. ALL DRAWINGS MUST BE CROSS-REFERENCED IN CASE OF ANY DOUBT / DISCREPANCY.
7. TOC REPRESENTS TOP OF CONCRETE & FFL REPRESENTS FINISHED FLOOR LEVEL. ALL DIMENSIONS SHOWN IN THE DRAWINGS ARE STRUCTURAL / MASONRY DIMENSIONS.
8. ALL ARCHITECTURAL DRAWINGS MUST BE REFERRED IN COORDINATION WITH STRUCTURAL DRAWINGS.

AREA STATEMENT	
USABLE FLOOR SPACE AREA OF TYPE D1 SINGLE QUARTER ON GROUND FLOOR	74.20 SQ.MT
TOTAL BUILT UP AREA ON GROUND FLOOR	214.27 SQ.MT

DRAWING TITLE	NORTH
GROUND FLOOR PLAN	


PROJECT NAME
ELECTRICAL LAYOUT OF D1 TYPE (2nos) STAFF QUARTERS

CLIENT
ANAND AGRICULTURAL UNIVERSITY


This Drawing is the Property of **VISHESH CONSULTANTS** and it should not be used in full or part without their prior permission.

ARCHITECT
VISHESH CONSULTANTS
ARCHITECTURE, INTERIORS AND ENGINEERING CONSULTANCY
7, FIRST FLOOR, CLASSIC COMPLEX, PRODUCTIVITY ROAD, AKOTA, VADODARA M 3825050577

VISHESH CONSULTANTS

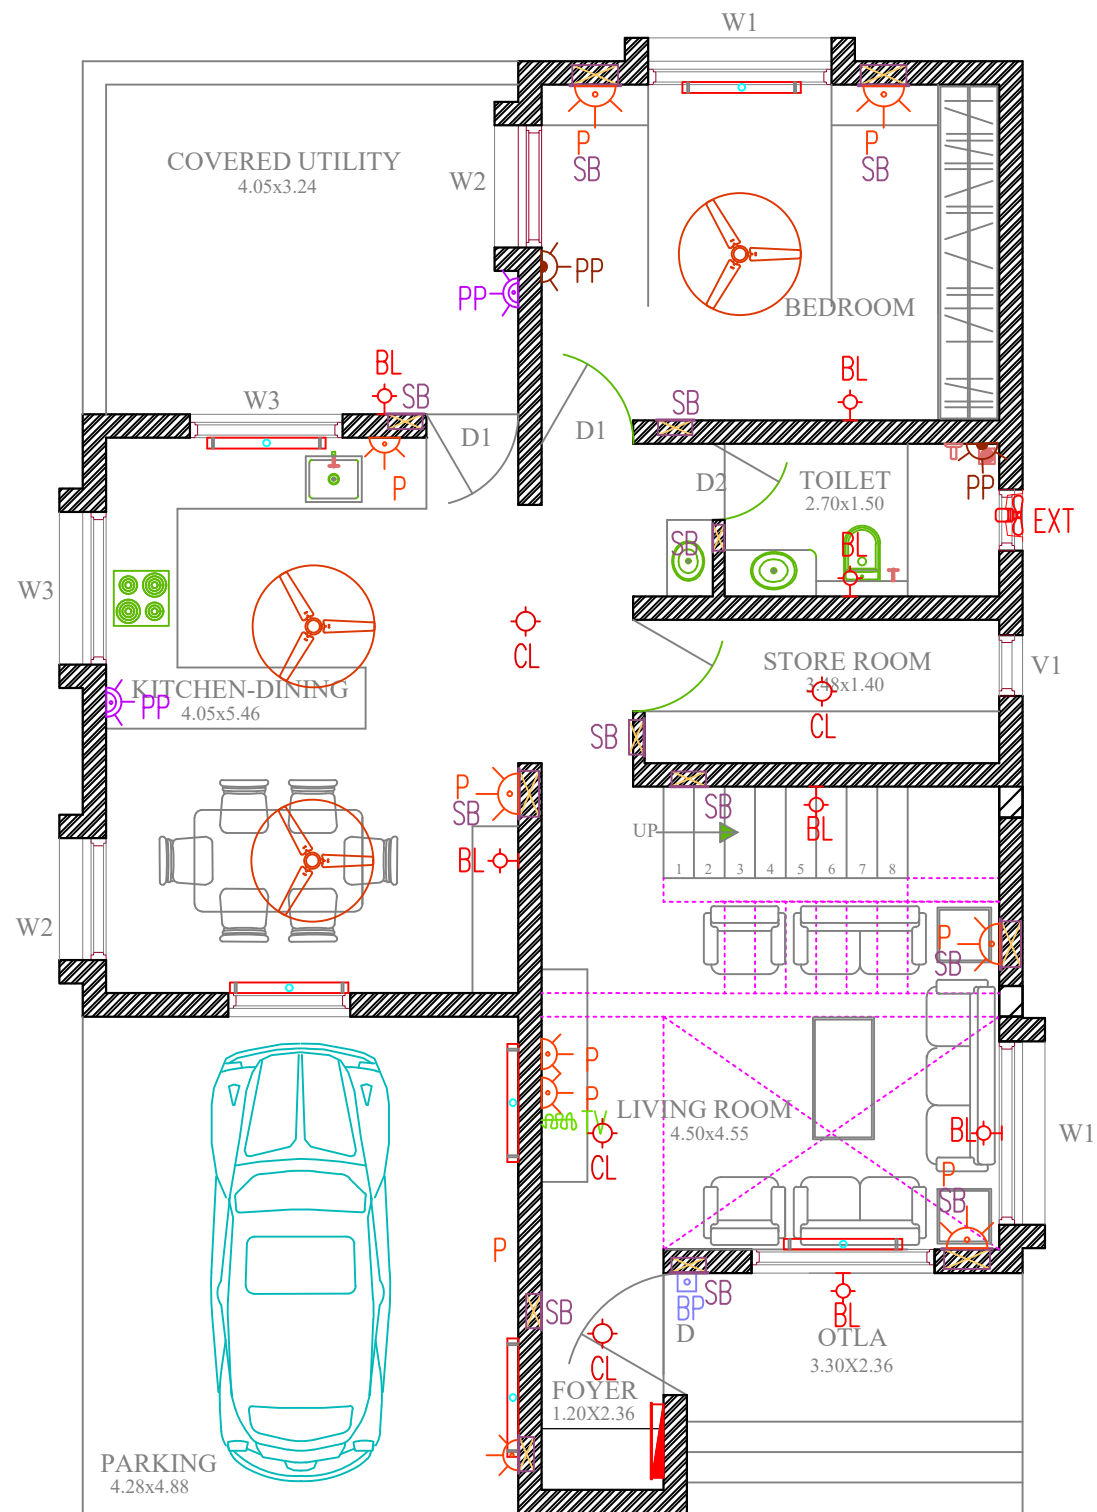

GROUND FLOOR PLAN

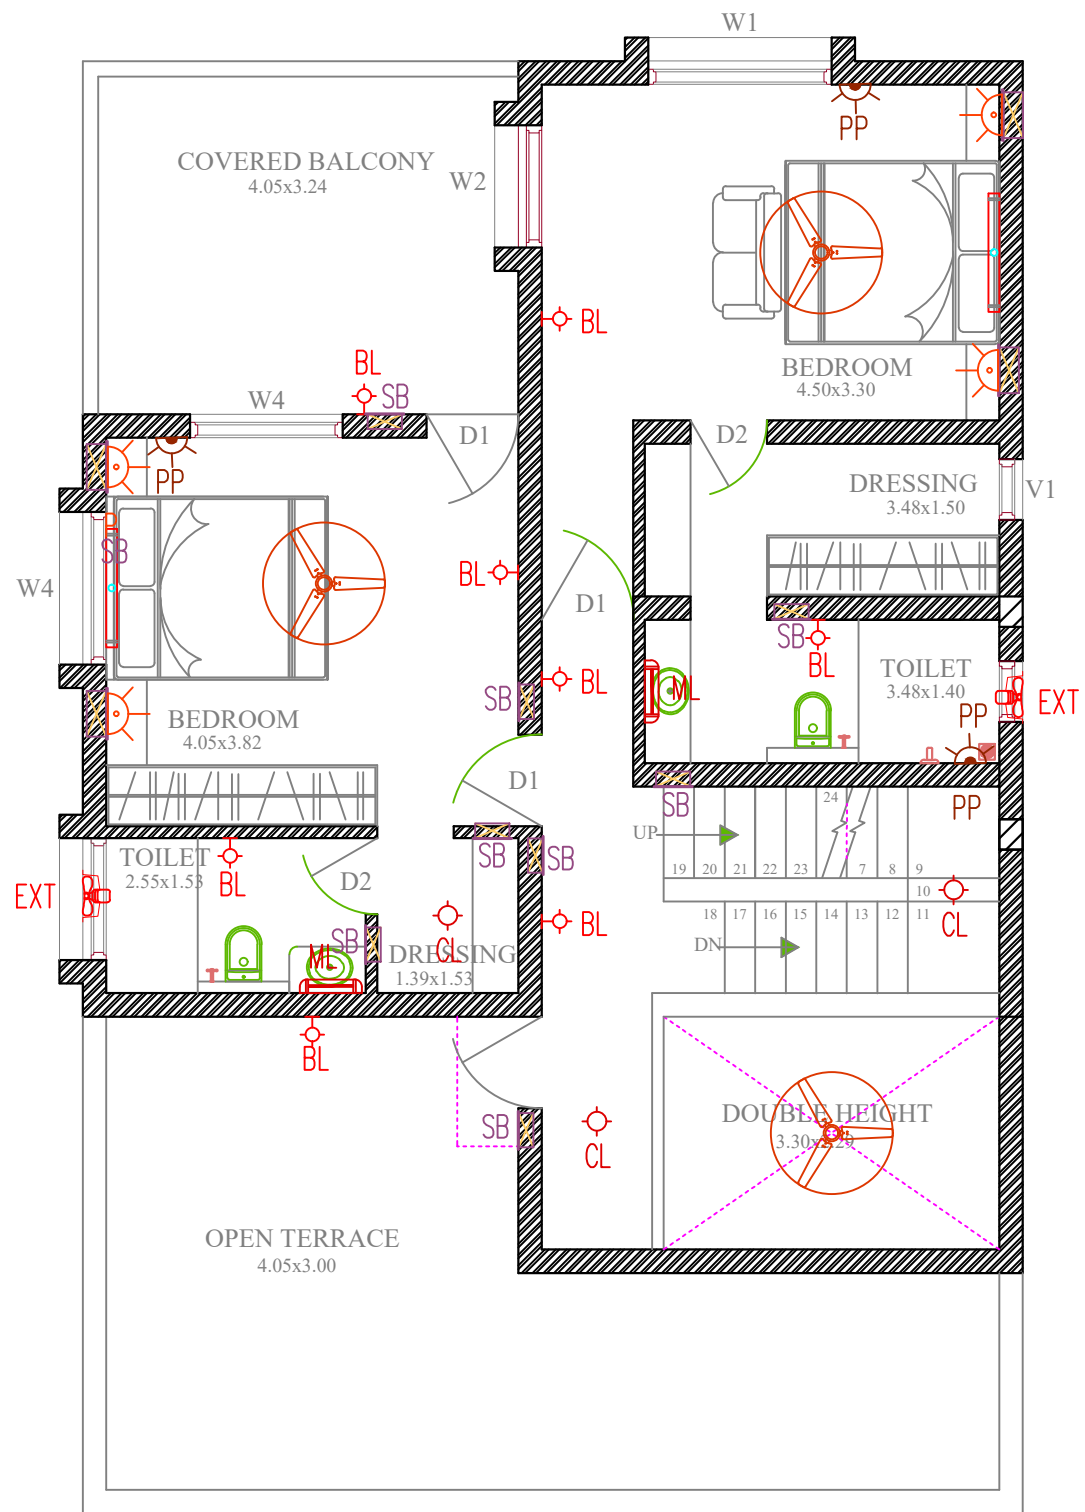

FIRST FLOOR PLAN

ELECTRICAL LEGEND:											
	T	TUBE LIGHT FIXTURE		TP	TELEPHONE POINT		P	6A PLUG POINT WITH 6A SWITCH		PP	6/16A PLUG POINT WITH 16A SWITCH
	CL	CEILING LIGHT POINT		TV	TELEVISION POINT		VDP	VIDEO DOOR PHONE			LIGHTING DISTRIBUTION BOARD
	F	FAN POINT		ML	MIRROR LIGHT		BL	BRACKET LIGHT POINT		PP	20A PLUG WITH 20A SWITCH
				BP	BELL PUSH SWITCH		SB	SWITCH BOARD		EXT	EXHAUST FAN
				BZ	BELL BUZZER						

DRAWING NO.	04 / ELECTRICAL - TYPE - E1		
ARCHITECT	VISHESH CONSULTANTS		
SCALE	NTS	CHECKED BY	NAINITA
DATE	21/05/2026		

GENERAL NOTES

1. THE ARCHITECT/ARCHITECTURAL CONSULTANT NEEDS TO BE NOTIFIED IN CASE OF ANY DISCREPANCY BETWEEN THE DRAWINGS AND THE CONDITION ON SITE.
2. FOR ALL SPECIALIST WORKS & DETAILS THE CONTRACTOR / SUB-CONTRACTOR ARE TO PROVIDE DETAILED SHOP DRAWINGS FOR ARCHITECT'S / ARCHITECTURAL CONSULTANT'S / ENGINEER'S APPROVAL PRIOR TO CONSTRUCTION.
3. THERE SHALL BE NO DEVIATION FROM THE APPROVED DRAWINGS WITHOUT PRIOR CONSENT OF THE ARCHITECT / ARCHITECTURAL CONSULTANT / ENGINEER.
4. THIS DRAWING SHOULD BE READ AND NOT MEASURED.
5. ALL DIMENSIONS ARE IN METERS AND LEVELS ARE IN METERS UNLESS STATED OTHERWISE.
6. ALL DRAWINGS MUST BE CROSS-REFERENCED IN CASE OF ANY DOUBT / DISCREPANCY.
7. TOC REPRESENTS TOP OF CONCRETE & FFL REPRESENTS FINISHED FLOOR LEVEL. ALL DIMENSIONS SHOWN IN THE DRAWINGS ARE STRUCTURAL / MASONRY DIMENSIONS.
8. ALL ARCHITECTURAL DRAWINGS MUST BE REFERRED IN COORDINATION WITH STRUCTURAL DRAWINGS.

AREA STATEMENT	
BUILT UP AREA ON GROUND FLOOR	131.85 SQ.MT
BUILT UP AREA ON FIRST FLOOR	90.38 SQ.MT
BUILT UP AREA ON SECOND FLOOR	12.35 SQ.MT
TOTAL BUILT UP AREA	234.58 SQ.MT

DRAWING TITLE	NORTH
GROUND AND FIRST FLOOR PLAN	

PROJECT NAME
ELECTRICAL LAYOUT OF E1 TYPE STAFF QUARTER

CLIENT
ANAND AGRICULTURAL UNIVERSITY

This Drawing is the Property of **VISHESH CONSULTANTS** and it should not be used in full or part without their prior permission.

ARCHITECT
VISHESH CONSULTANTS
ARCHITECTURE, INTERIORS AND ENGINEERING CONSULTANCY
7, FIRST FLOOR, CLASSIC COMPLEX, PRODUCTIVITY ROAD, AKOTA, VADODARA M 982505077

VISHESH CONSULTANTS