

ITEM NO. I-90 PVC
FLUTED & ITEM NO.
I-89 TRAP DOOR

ITEM NO. C-115
GYPSUM CEILING

BED ROOM
373 X 482

ITEM NO. C-116
CALCIUM
SILICATE CEILING

LEVEL +75MM

LEVEL +75MM

LEVEL +150MM

LEVEL +75MM


 







 


DELUX/BEDROOM
FALSE CEILING PLAN

C-51_800X800
VITRIFIED TILES


 



 
 
C-53_600X1200
ANTISKID TILE

DELUX/BEDROOM
FLOORING PLAN


 
ELECTRICAL LEGEND

	FAN POINT		SMOKE DETECTOR
	WALL LIGHT		RECESSED LIGHT
	HANGING LIGHT		CHANDLIER
	PROFILE LIGHT		EXHAUST FAN
	COB LIGHT		WALL FAN
	PANEL LIGHT		RECESSED LIGHT

FIRE FIGHTING PIPE LINE SCHEDULE

	150NB HYDRANT PIPE
	100 FIRE HYDRANT PIPE UNDER THE GROUND
	100 FIRE HYDRANT PIPE UNDER ON GROUND
	80NB SPRINKLER PIPE
	65NB SPRINKLER PIPE
	32NB SPRINKLER PIPE
	SPRINKLER

FLOORING LEGEND

	C-53_600X600 CERAMIC TILES (BATHROOM TILE)
	C-51_800X800 VITRIFIED TILES (ROOM & BALCONY)

PROJECT TITLE:

CIRCUIT HOUSE, SHAHIBAUG

DRAWING TITLE : **DELUX ROOM FALSE CEILING & FLOORING PLAN**

DRAWING NO. :

SCALE : **NTS**




SHEET : **2 of 3**

SHEET SIZE : **A3**


DATE : **05-02-2026**

REVISION


R0

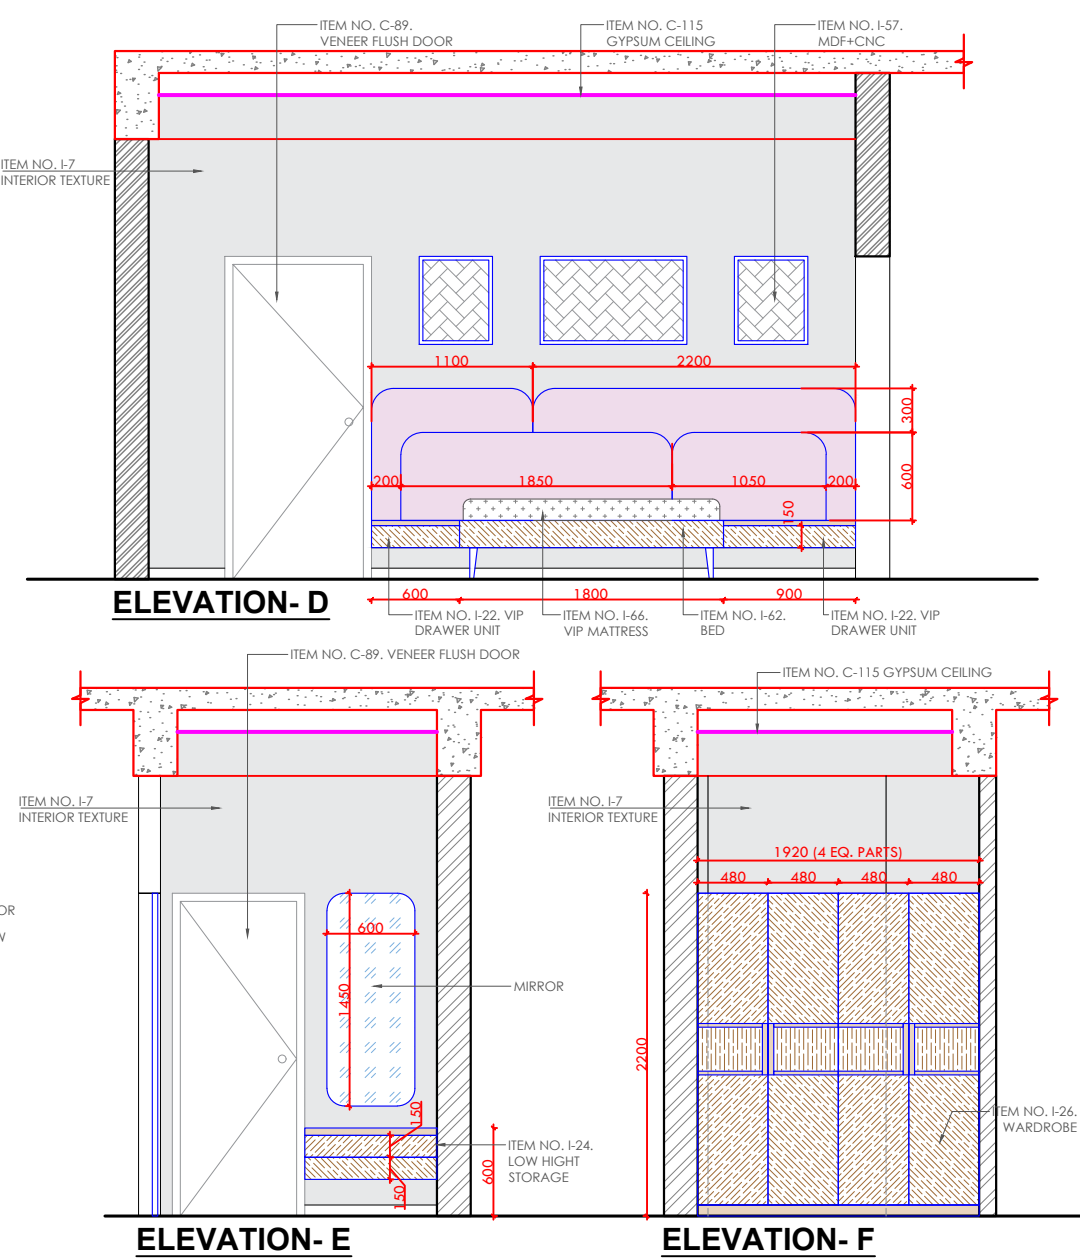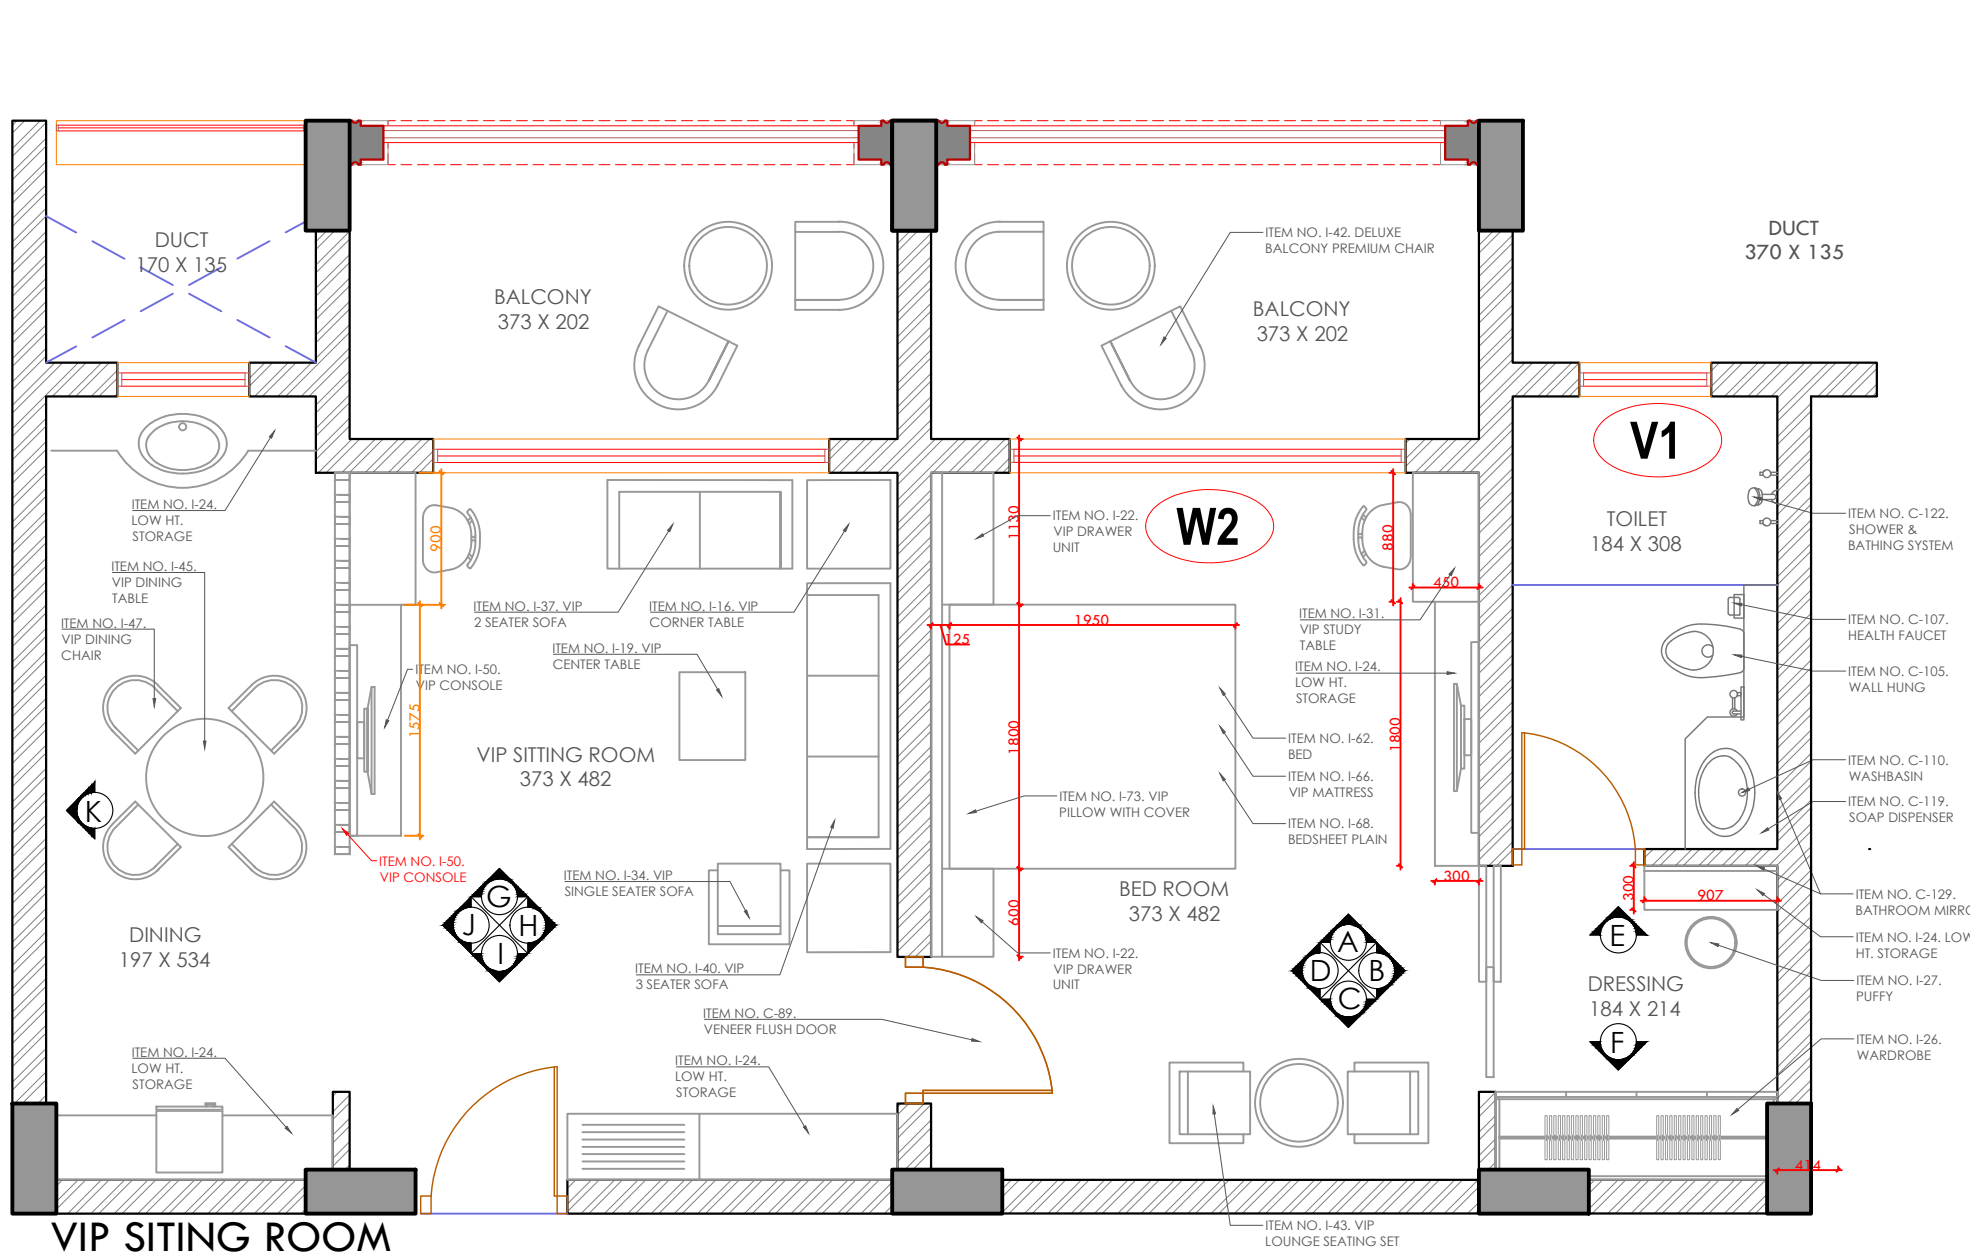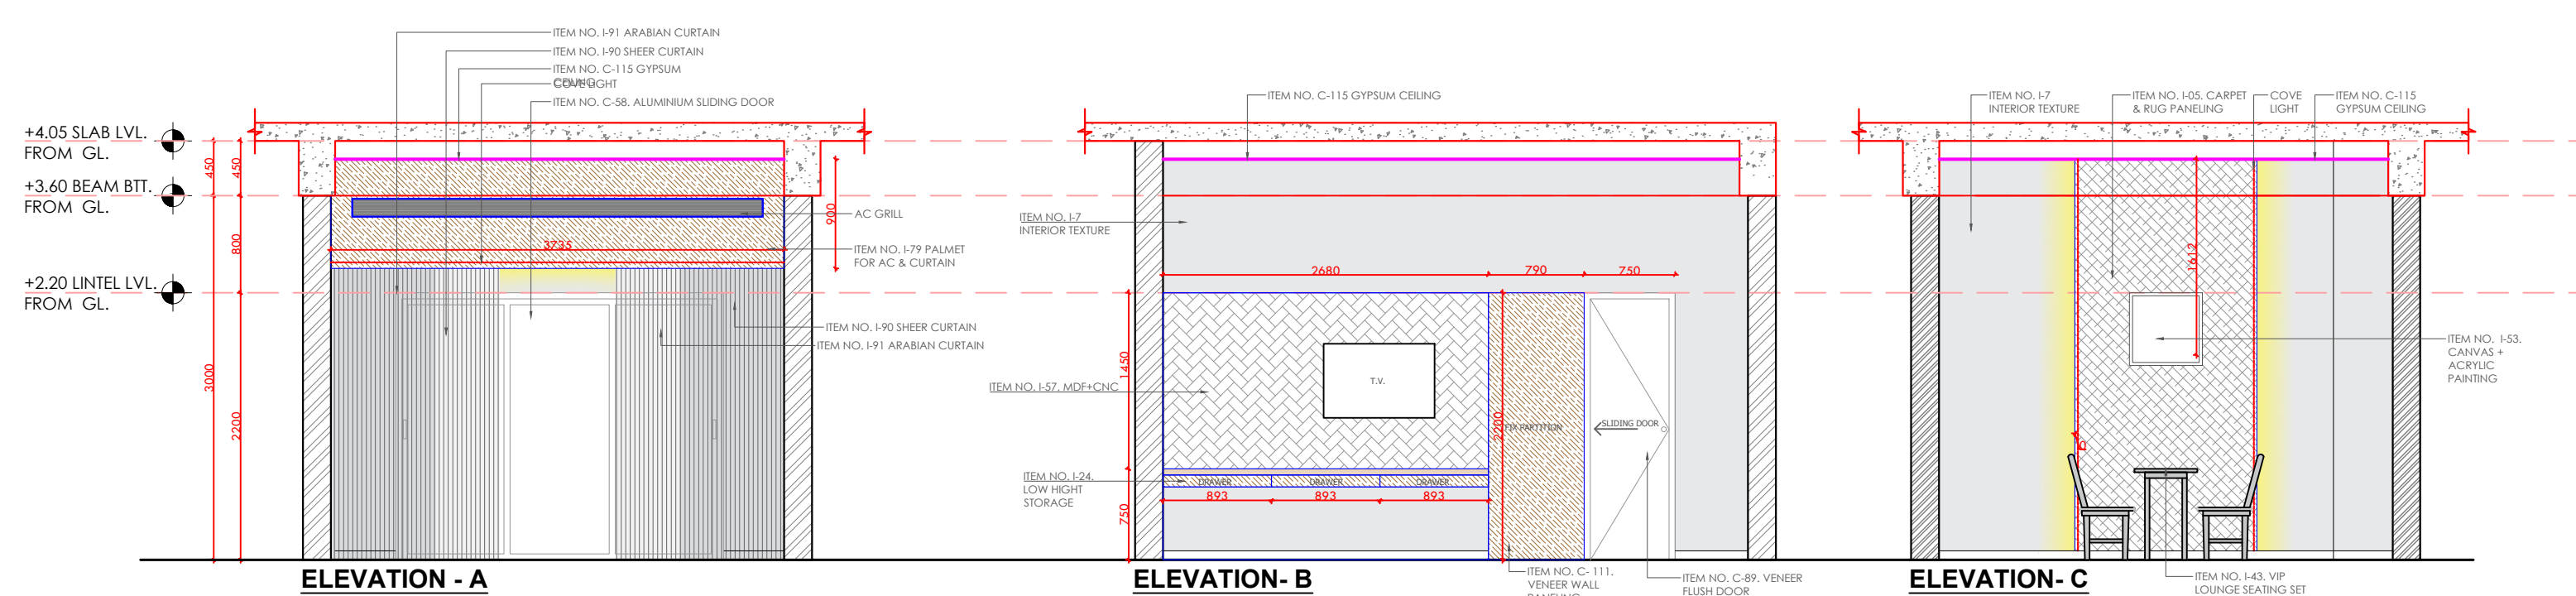




REV	DATE	BRIEF DESCRIPTION	Drawn by	Sign	Name	Designed by	Checked by	Approved by	PROJECT TITLE:	DRAWING TITLE :	DRAWING NO. :	SCALE :	SHEET :	SHEET SIZE :	DATE :	REVISION
									CIRCUIT HOUSE, SHAHIBAUG	VIP ROOM PLAN & ELEVATION		NTS	1 of 5	A3	05-02-2026	R0

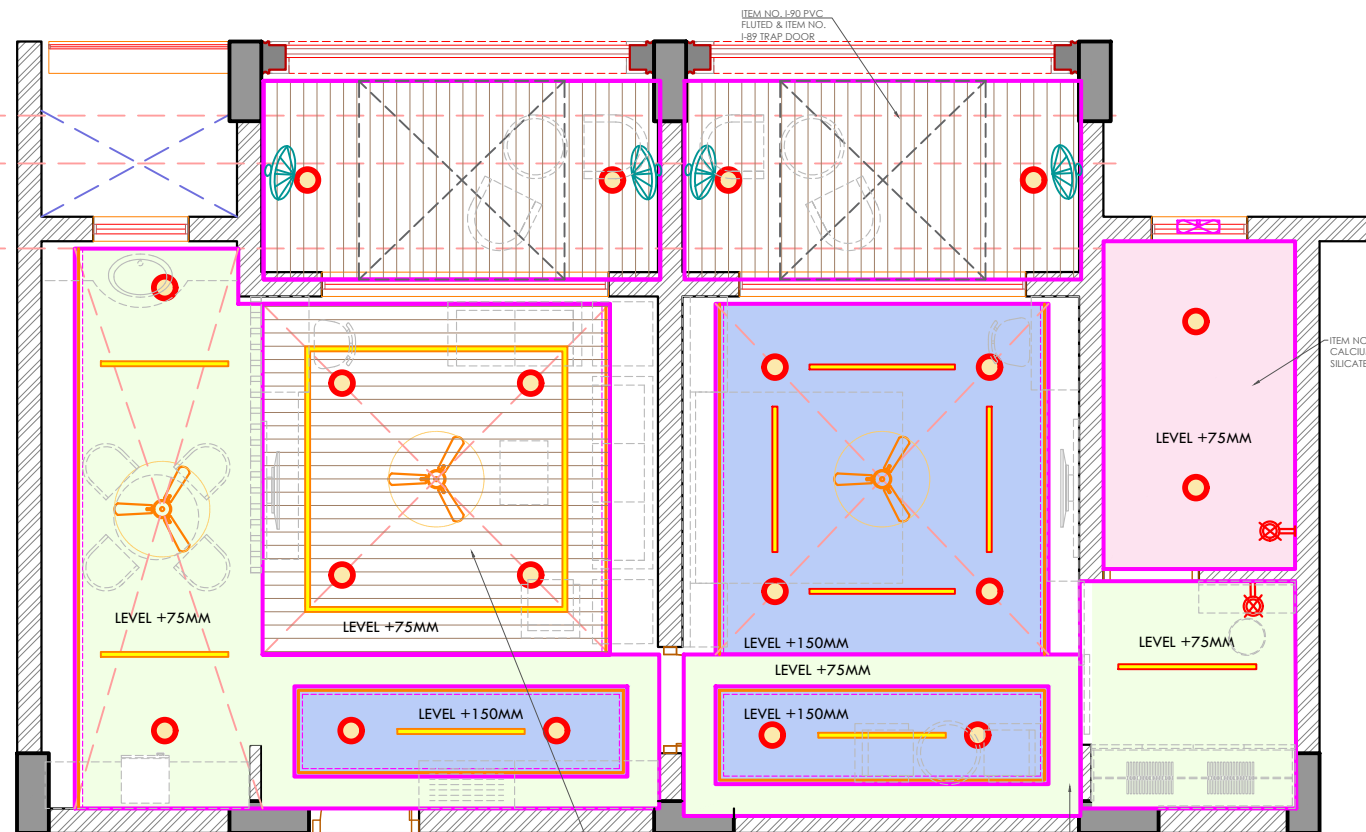







VIP SITING ROOM FALSE CEILING PLAN

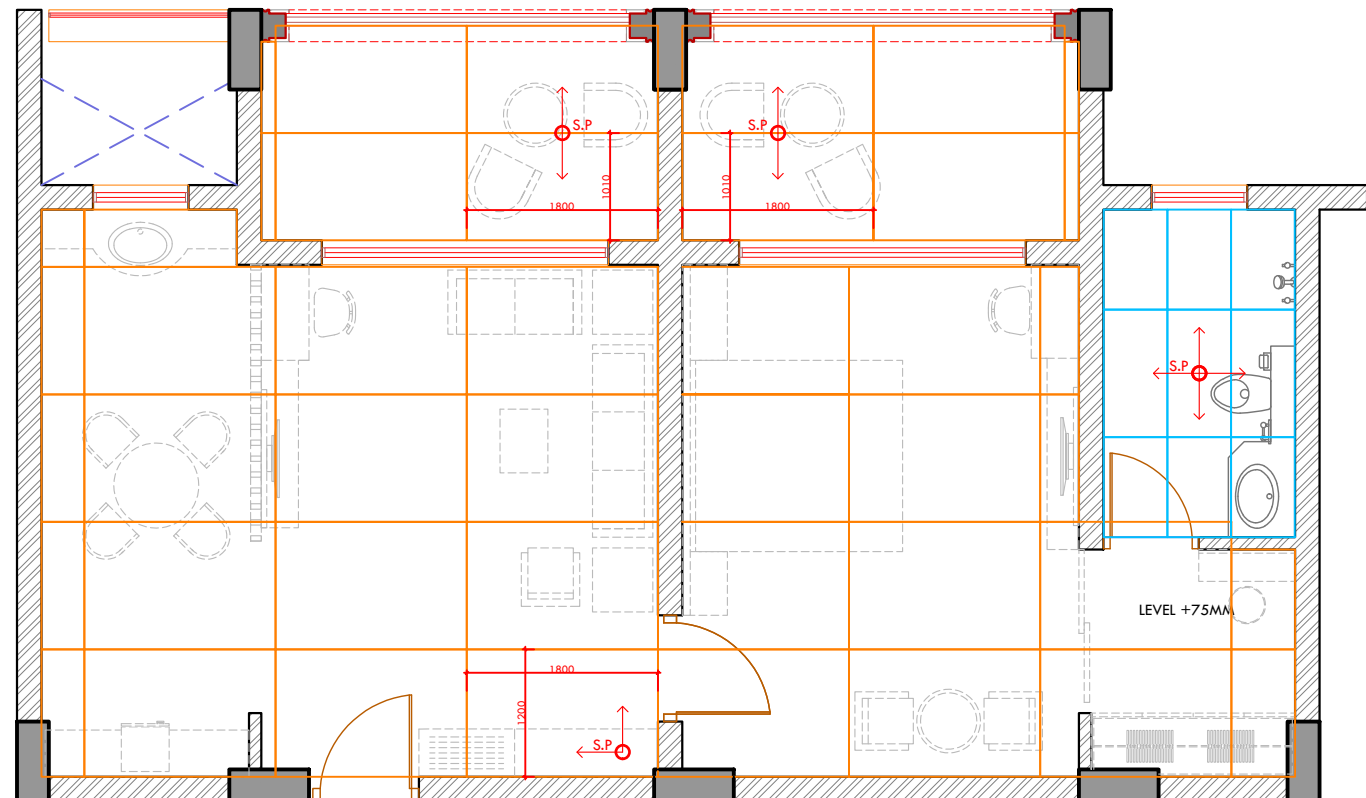

VIP SITING ROOM FLOORING PLAN

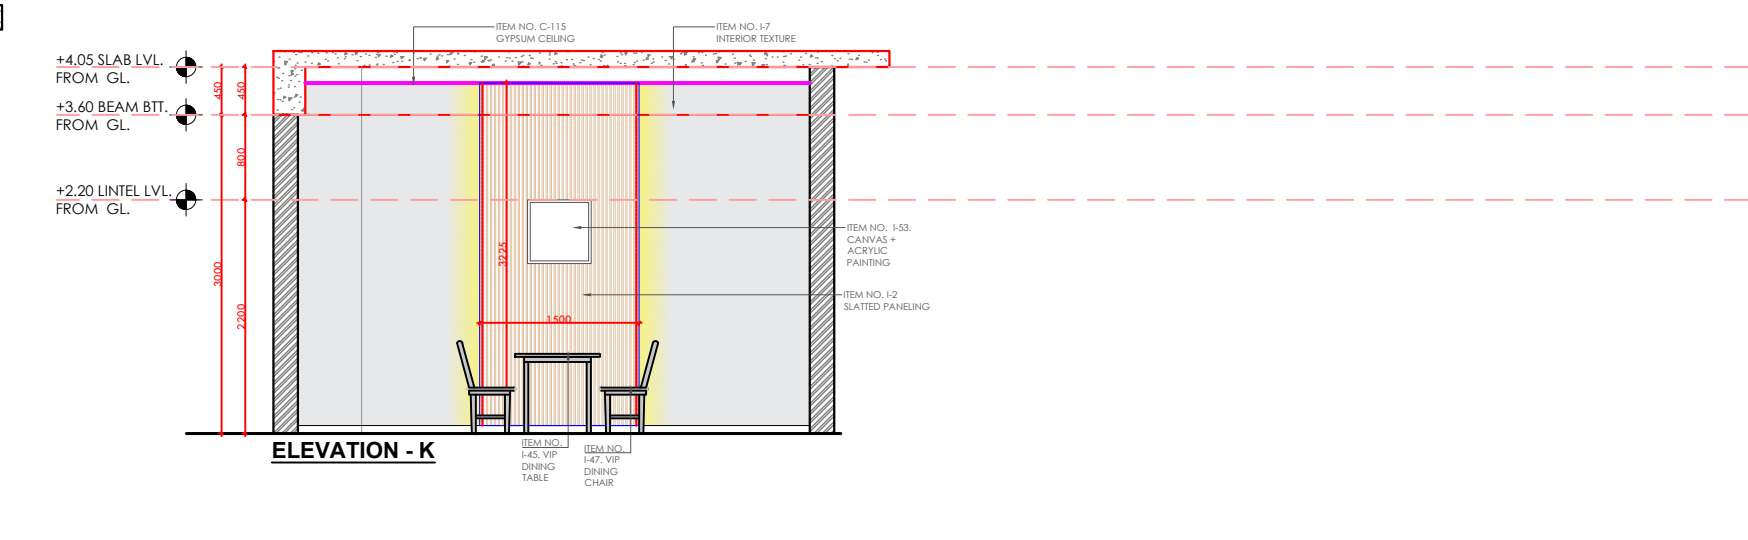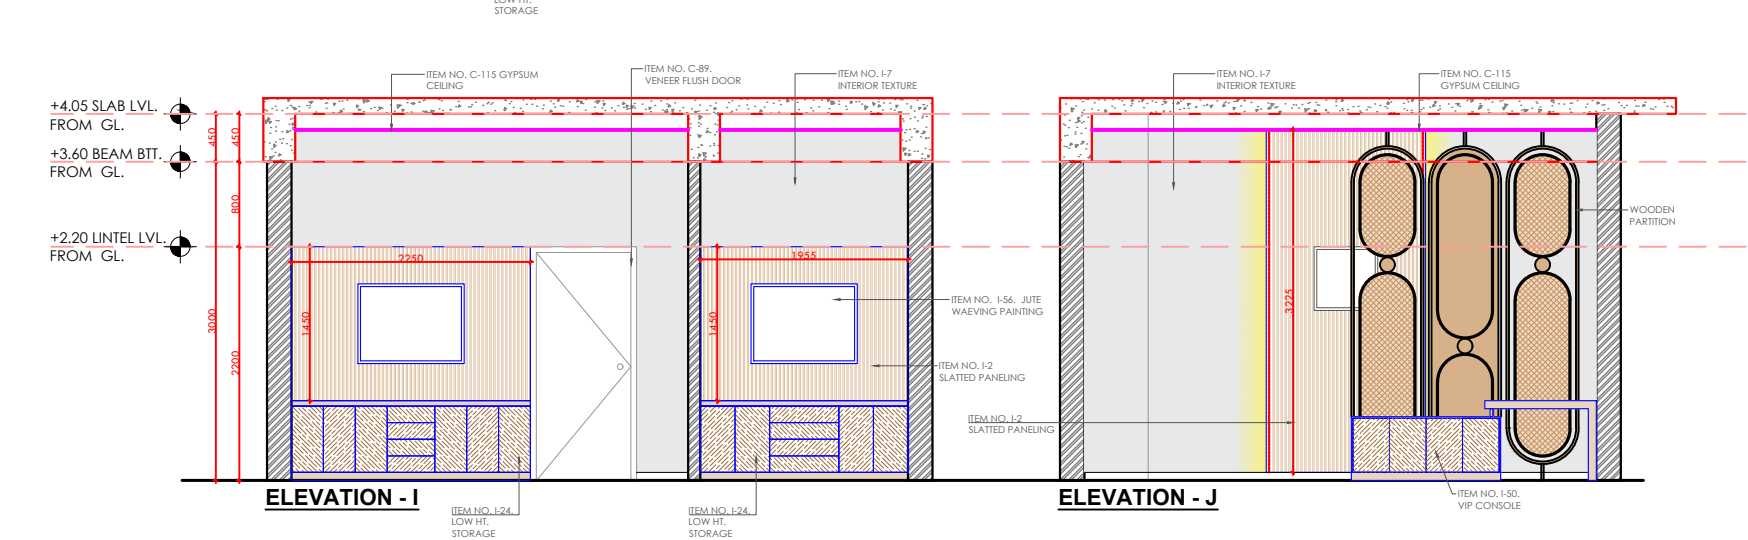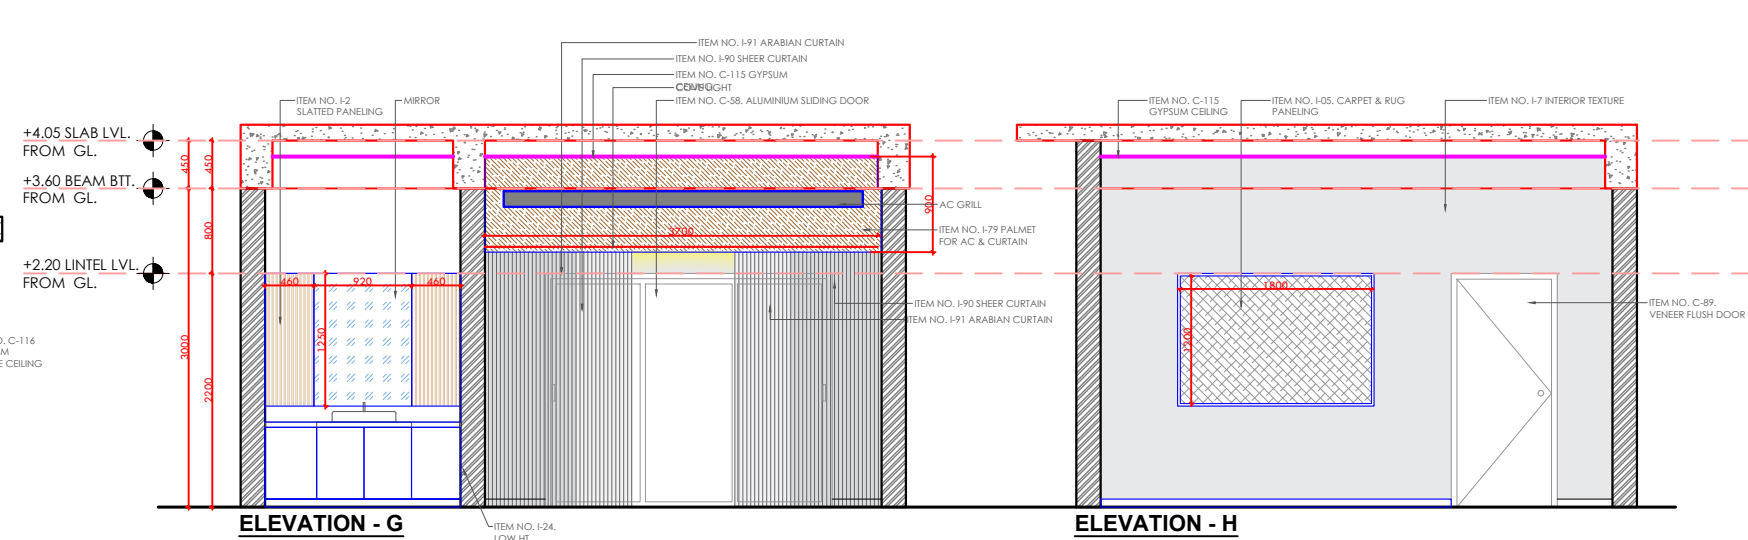

REV	DATE	BRIEF DESCRIPTION	Drawn by	Sign	Name	Designed by	Checked by	Approved by	PROJECT TITLE:	DRAWING TITLE :	DRAWING NO. :	SCALE :	SHEET :	SHEET SIZE :	DATE :	REVISION
									CIRCUIT HOUSE, SHAHIBAUG	VIP ROOM PLAN FALSE CEILING, FLOORING PLAN & ELEVATION		NTS	2 of 5	A3	05-02-2026	R0

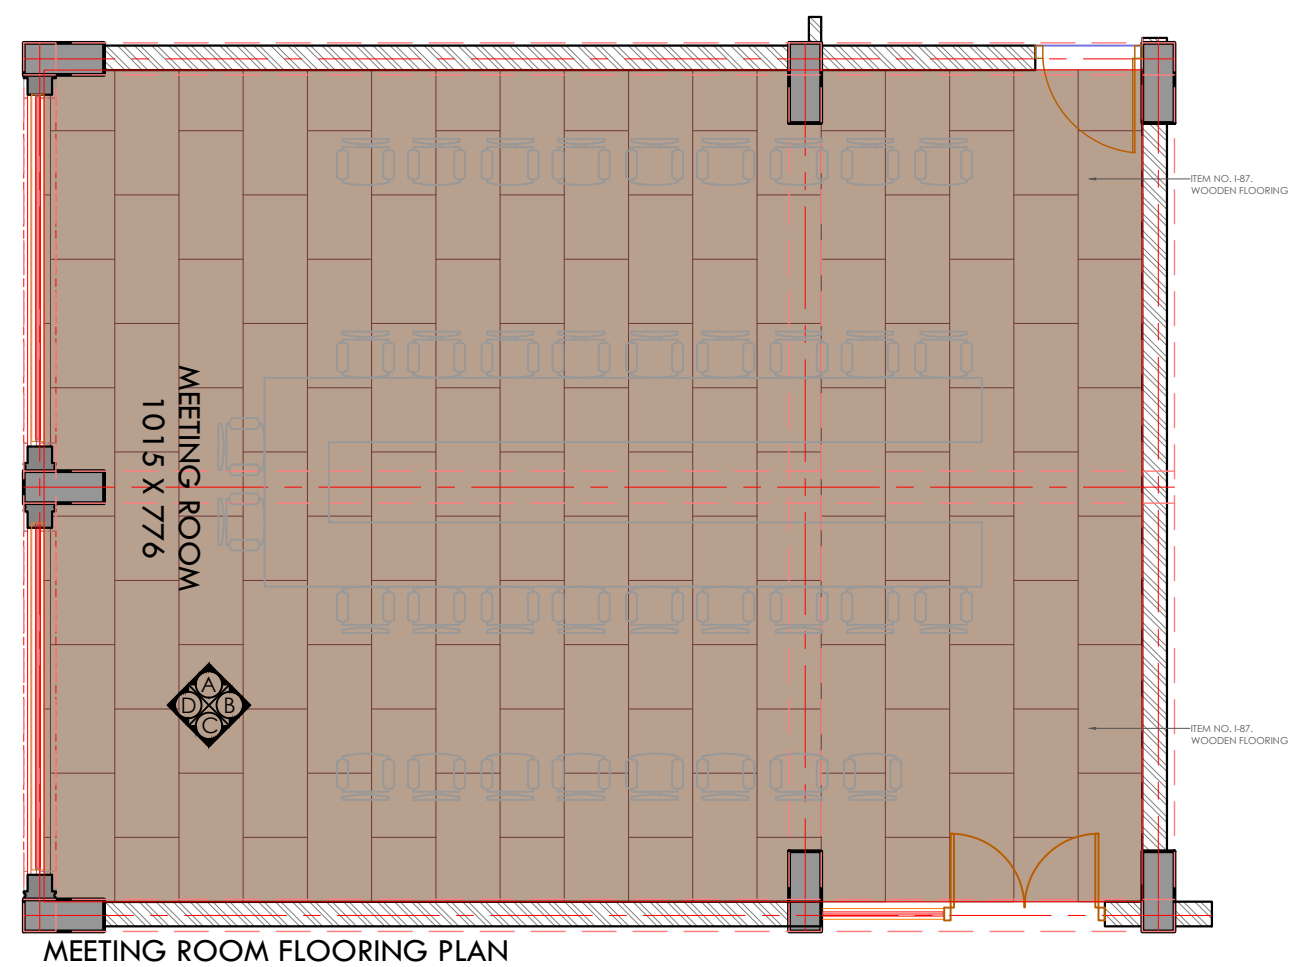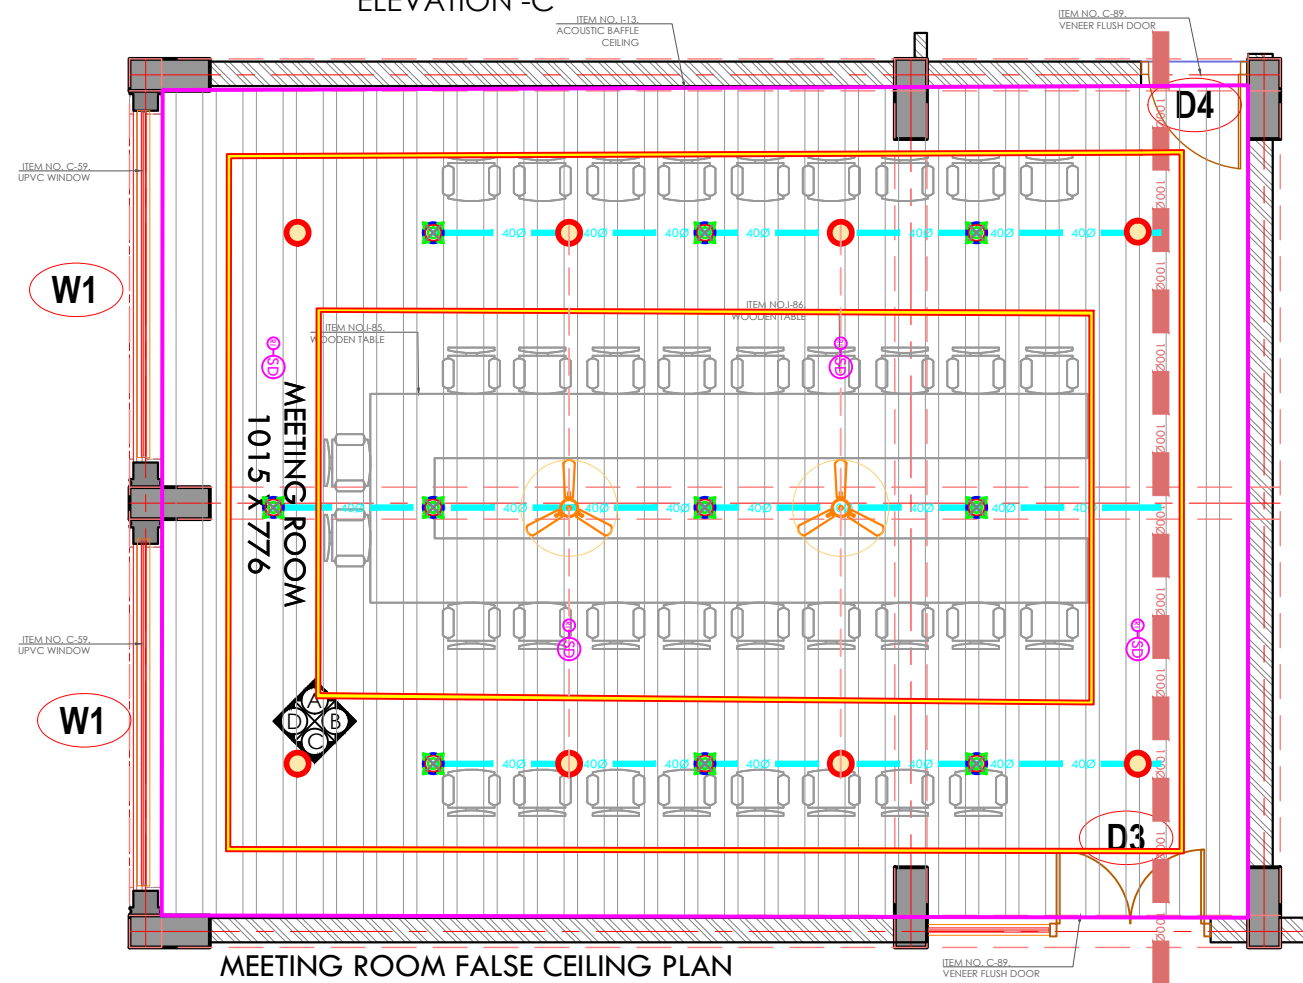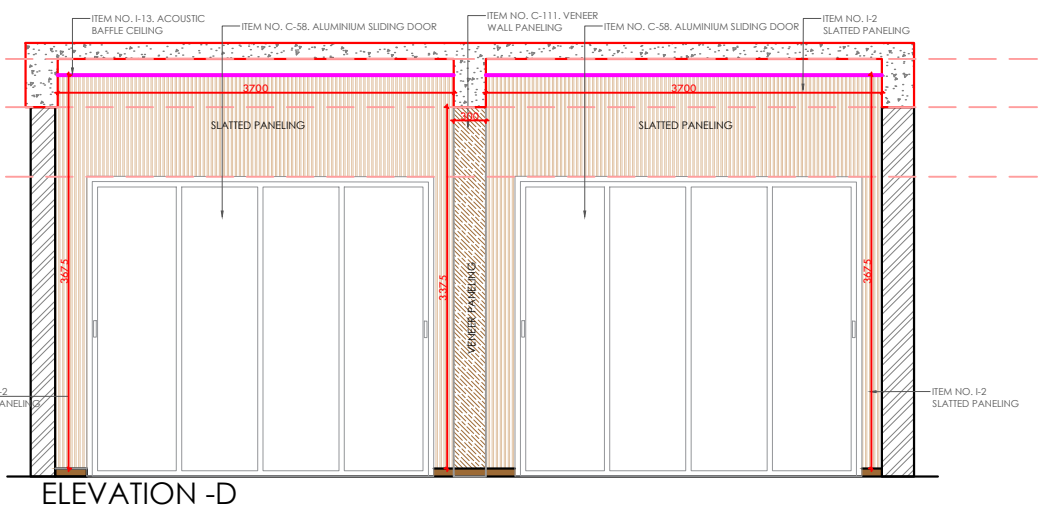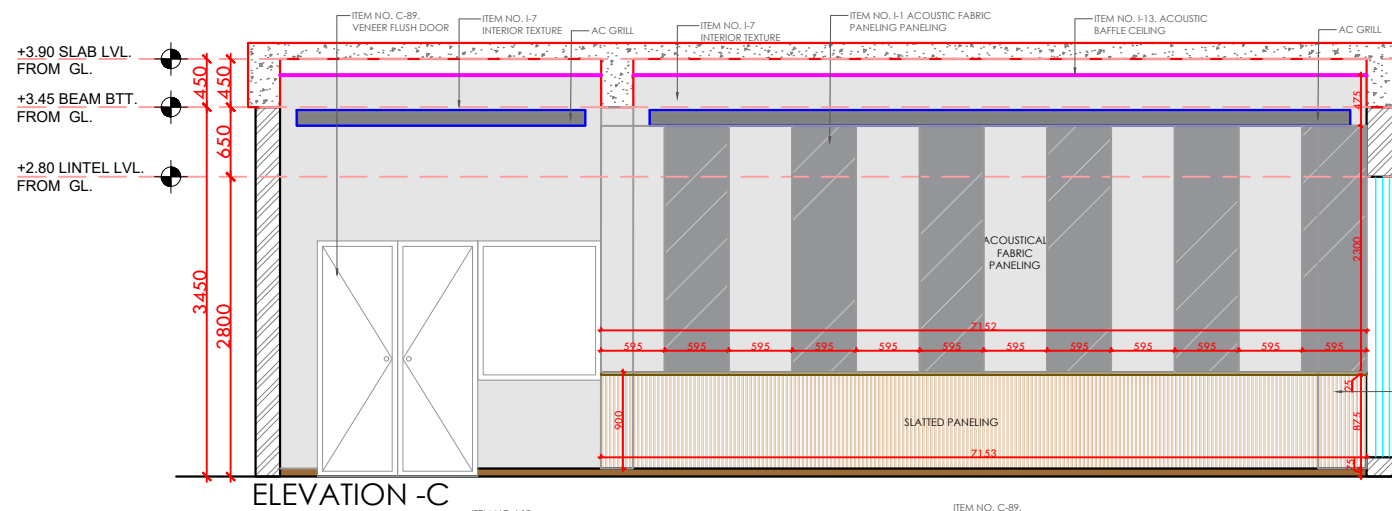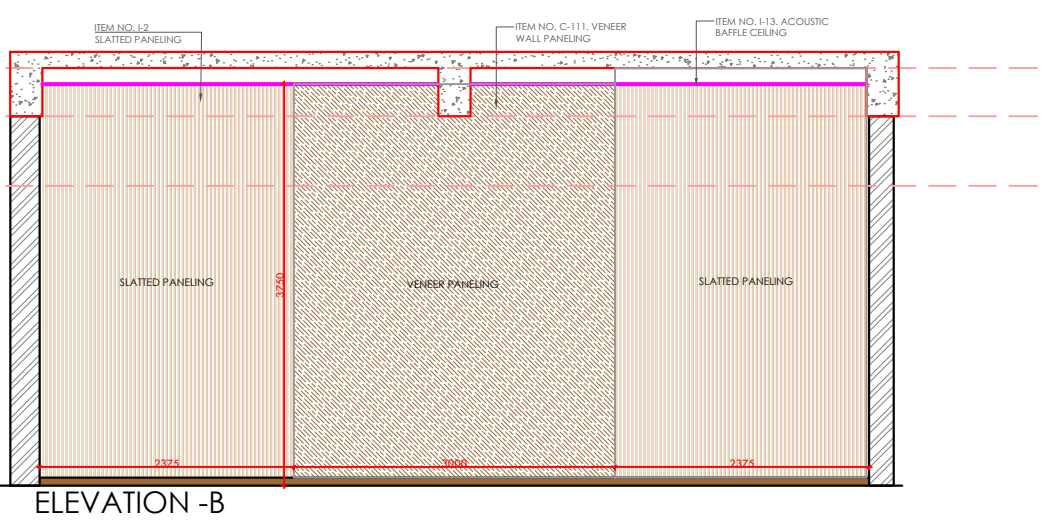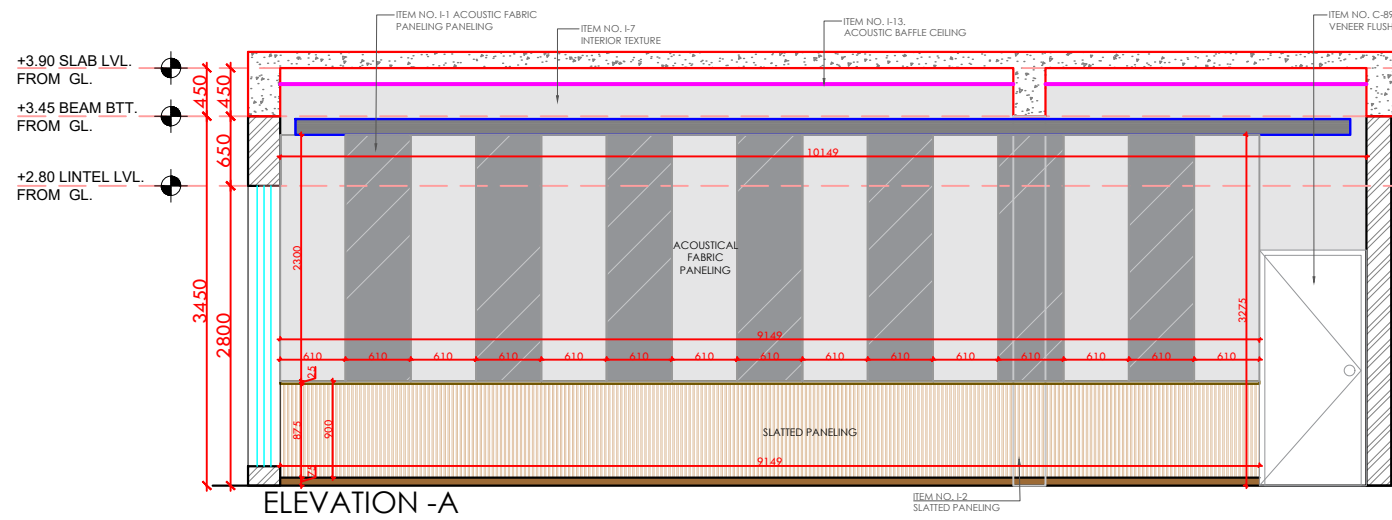

REV	DATE	BRIEF DESCRIPTION	Drawn by	Sign			
				Name			
				Designed by	Checked by	Approved by	

PROJECT TITLE:	CIRCUIT HOUSE, SHAHIBAUG
----------------	---------------------------------

DRAWING TITLE : **MEETING ROOM**

DRAWING NO. :

SCALE : NTS







SHEET : 1 of 3

SHEET SIZE : **A3**

DATE : 05-02-2026

REVISION

RO

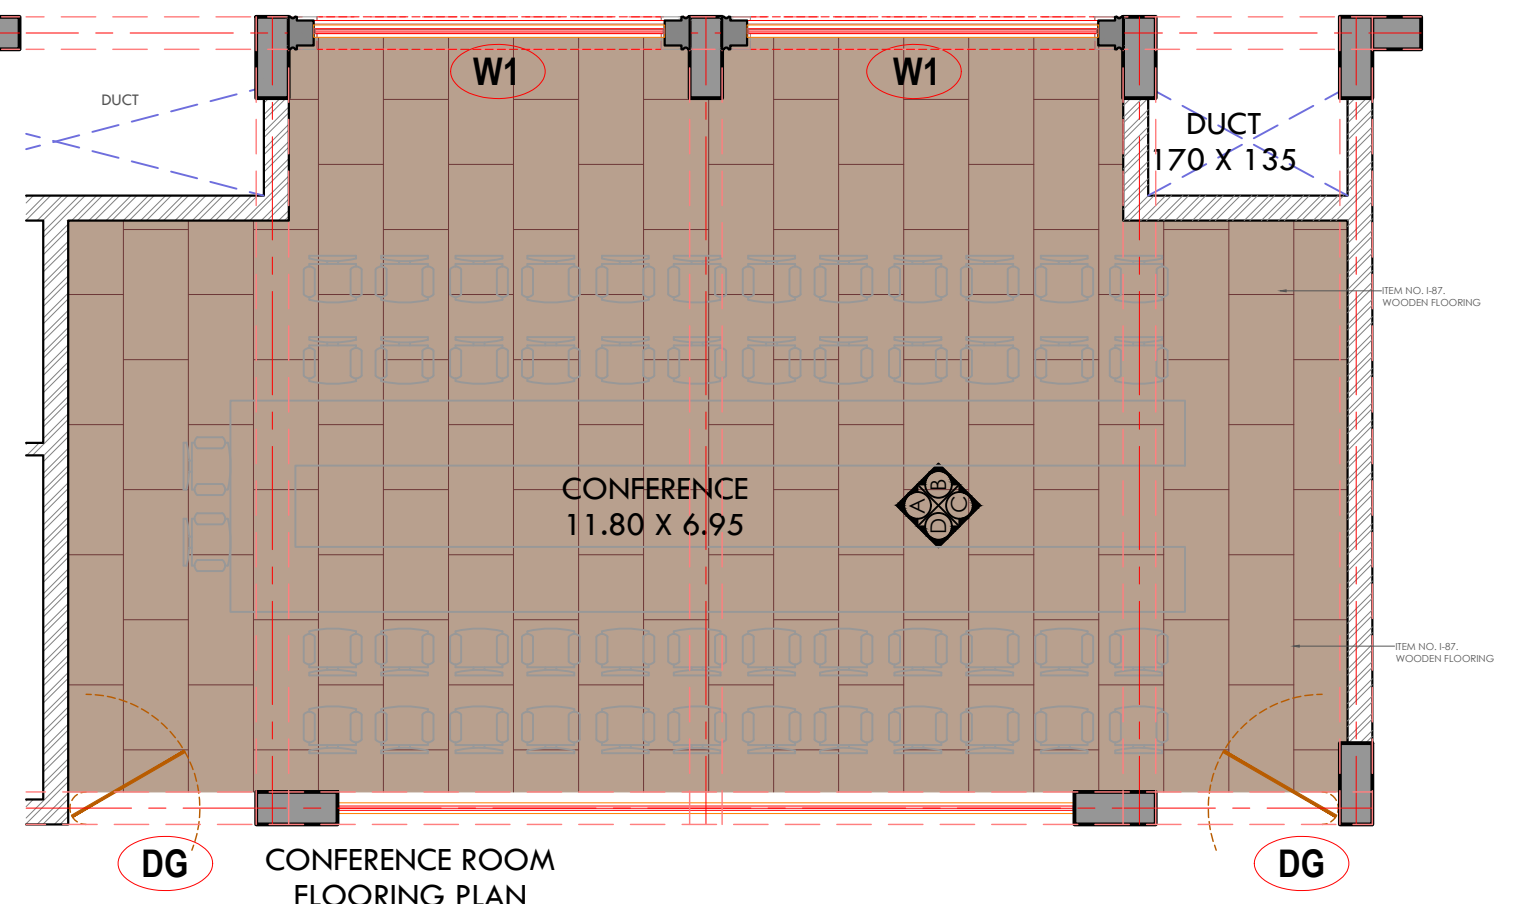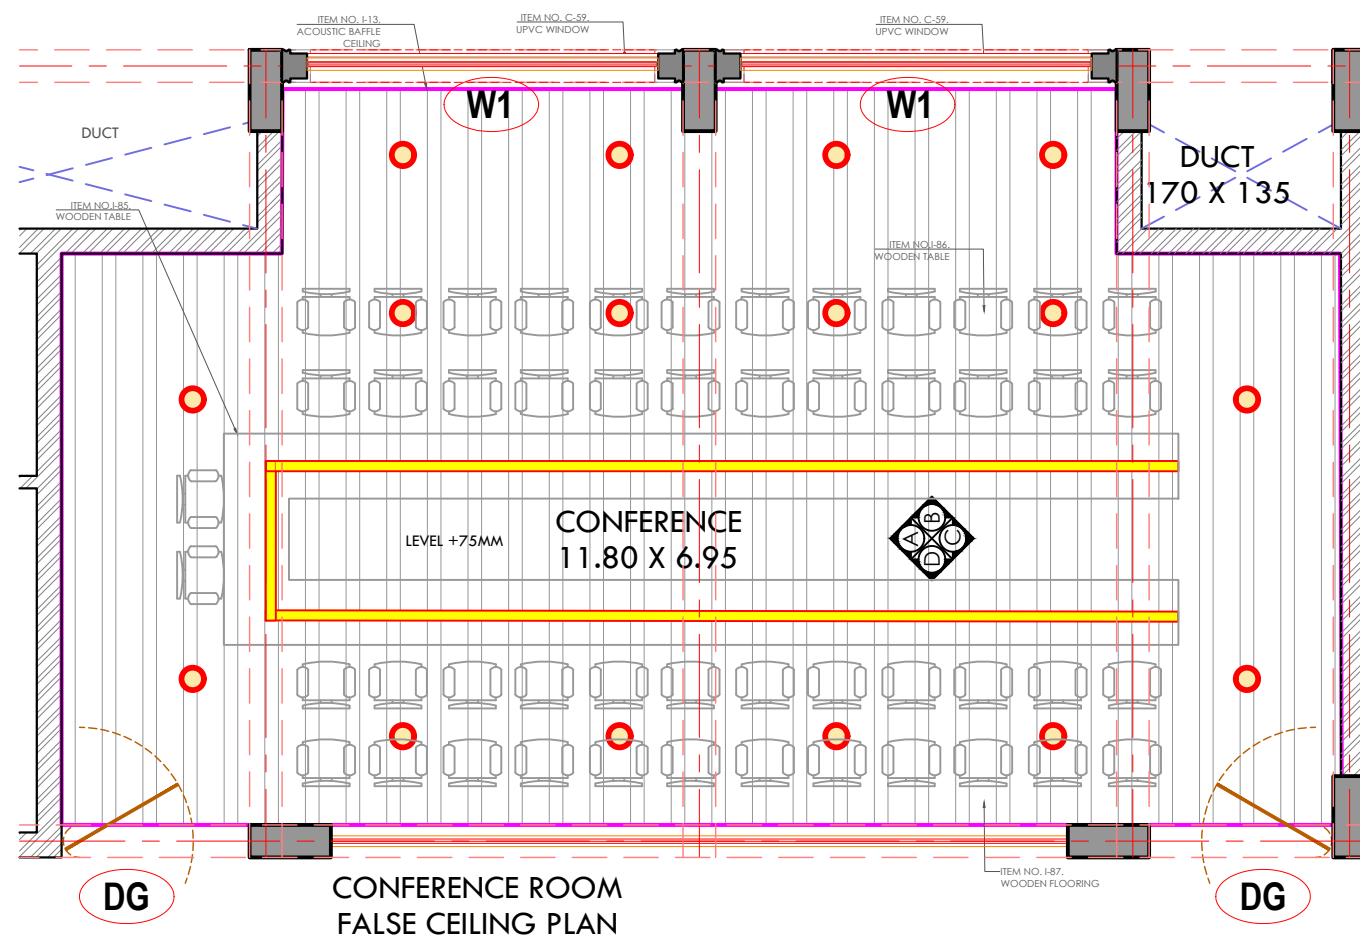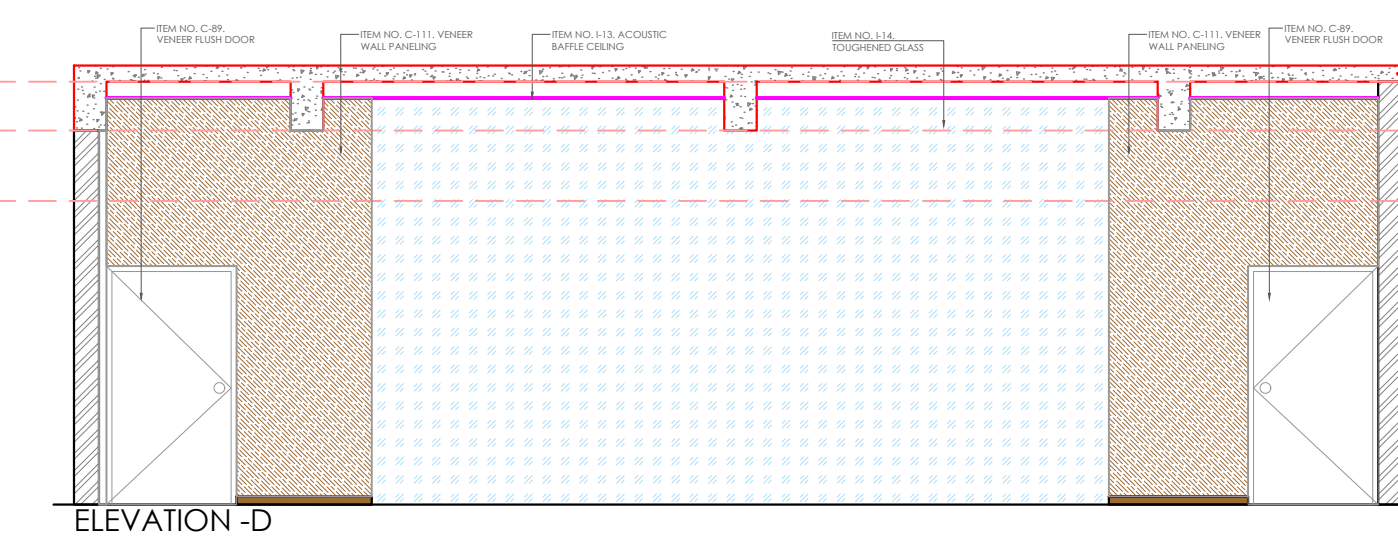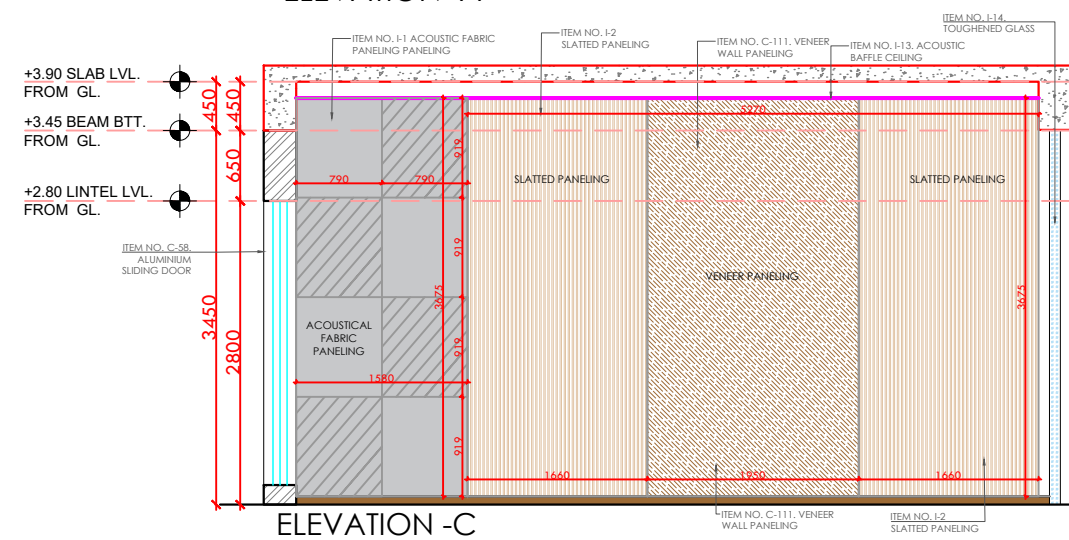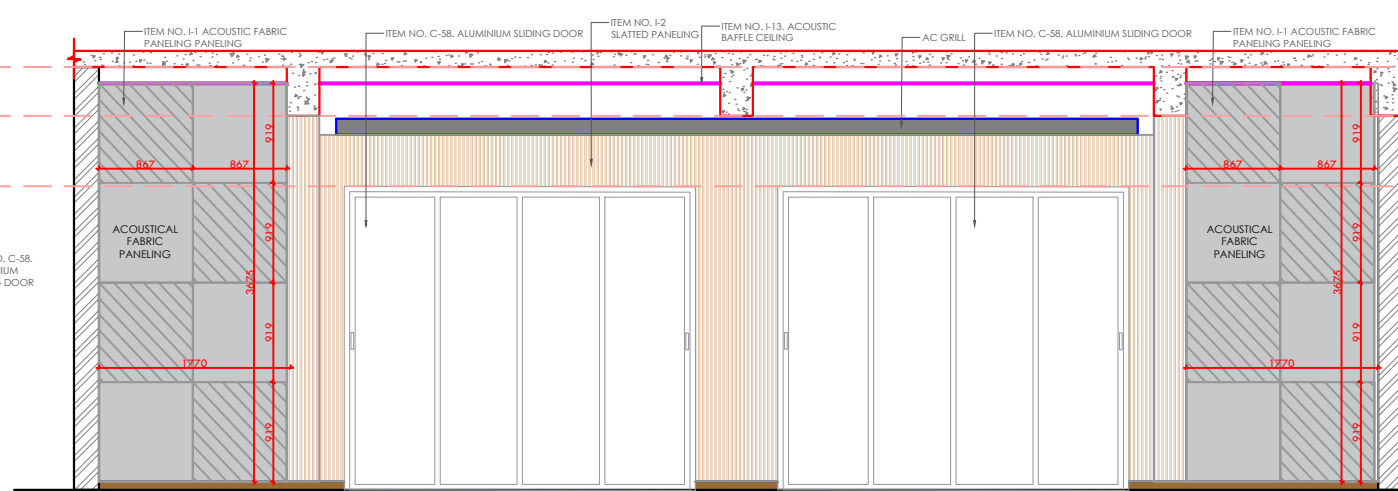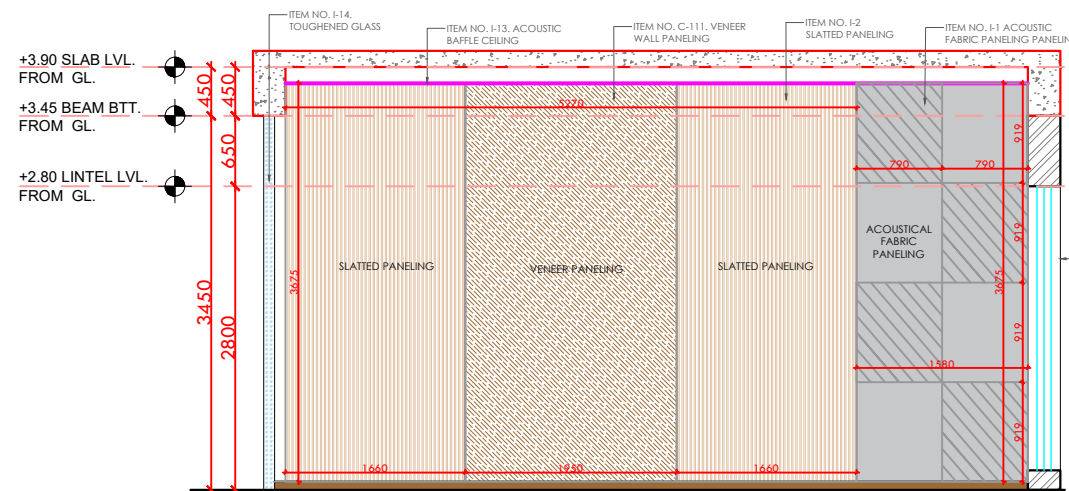

REV	DATE	BRIEF DESCRIPTION	Drawn by	Sign			
				Name			
				Designed by	Checked by	Approved by	

PROJECT TITLE:

CIRCUIT HOUSE, SHAHIBAUG

DRAWING TITLE : **CONFERENCE ROOM**

DRAWING NO. :

SCALE : **NTS**


SHEET : 1 of 3

SHEET SIZE :	A3
--------------	-----------







DATE : 05-02-2026

REVISION

R0

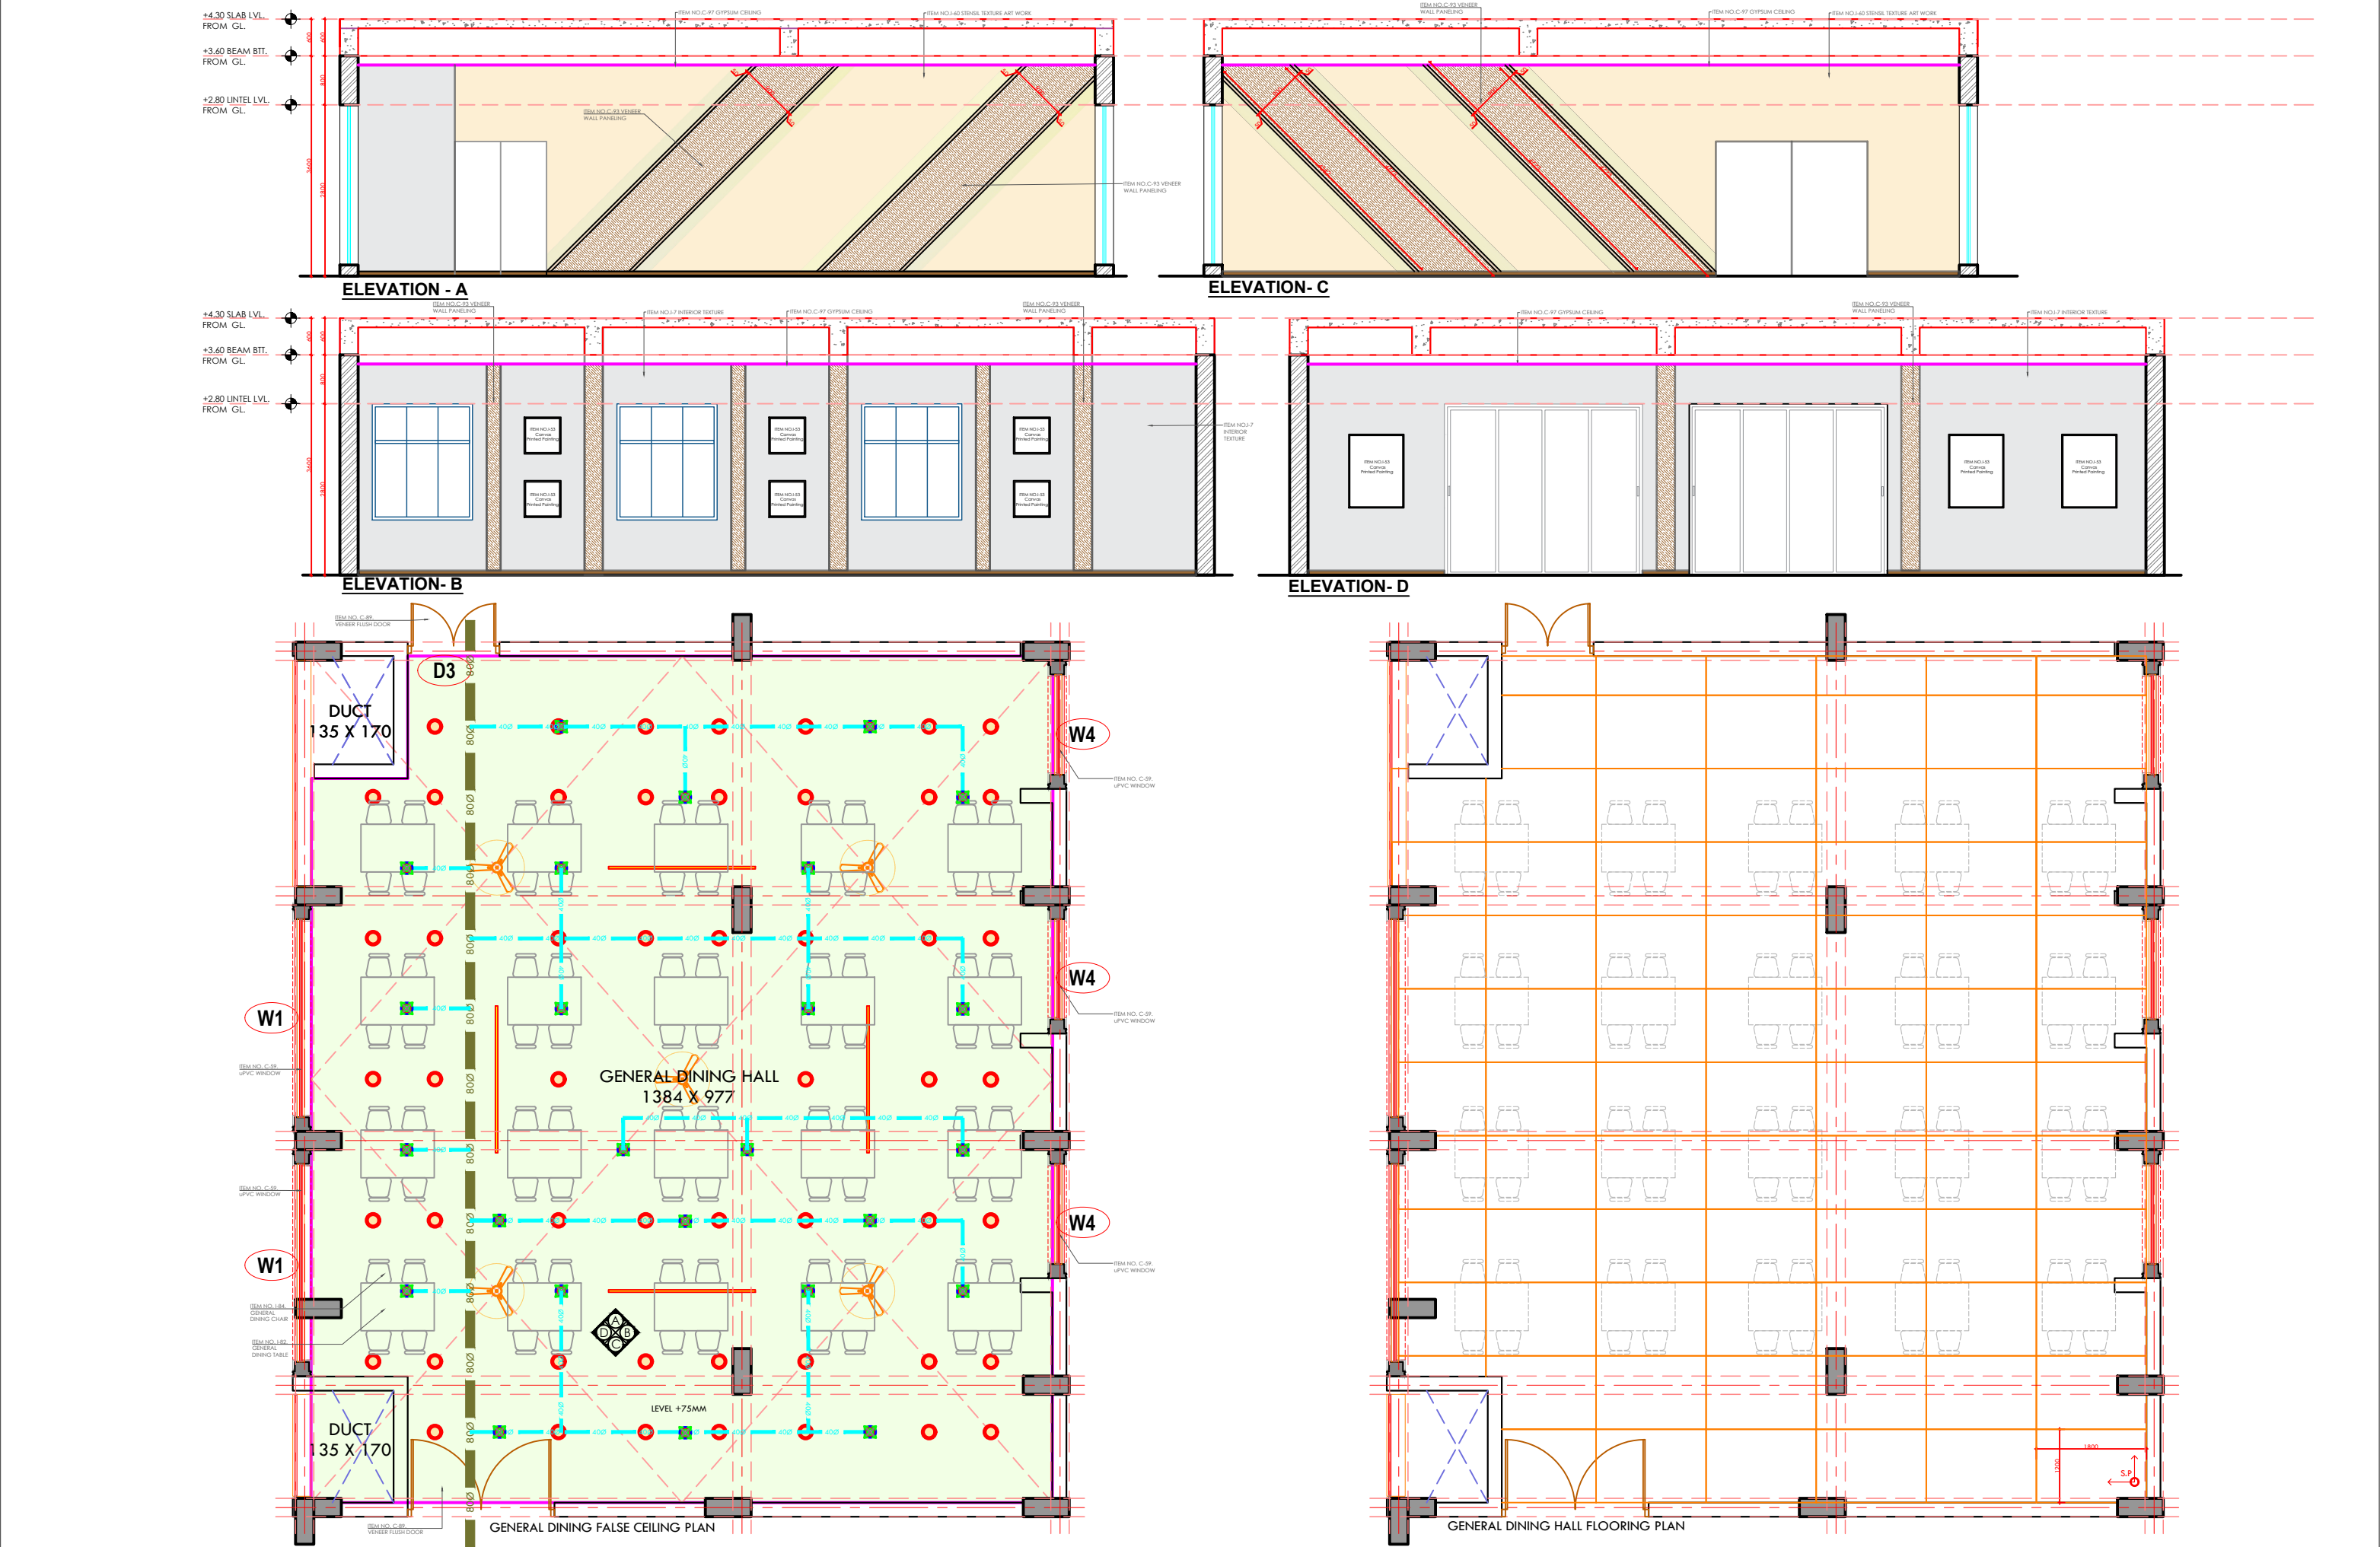

REV	DATE	BRIEF DESCRIPTION	Drawn by	Sign	Name	Designed by	Checked by	Approved by	PROJECT TITLE:	DRAWING TITLE :	DRAWING NO. :	SCALE :	SHEET :	SHEET SIZE :	DATE :	REVISION
									CIRCUIT HOUSE, SHAHIBAUG	GENERAL DINING HALL		NTS	1 of 2	A3	05-02-2026	R0

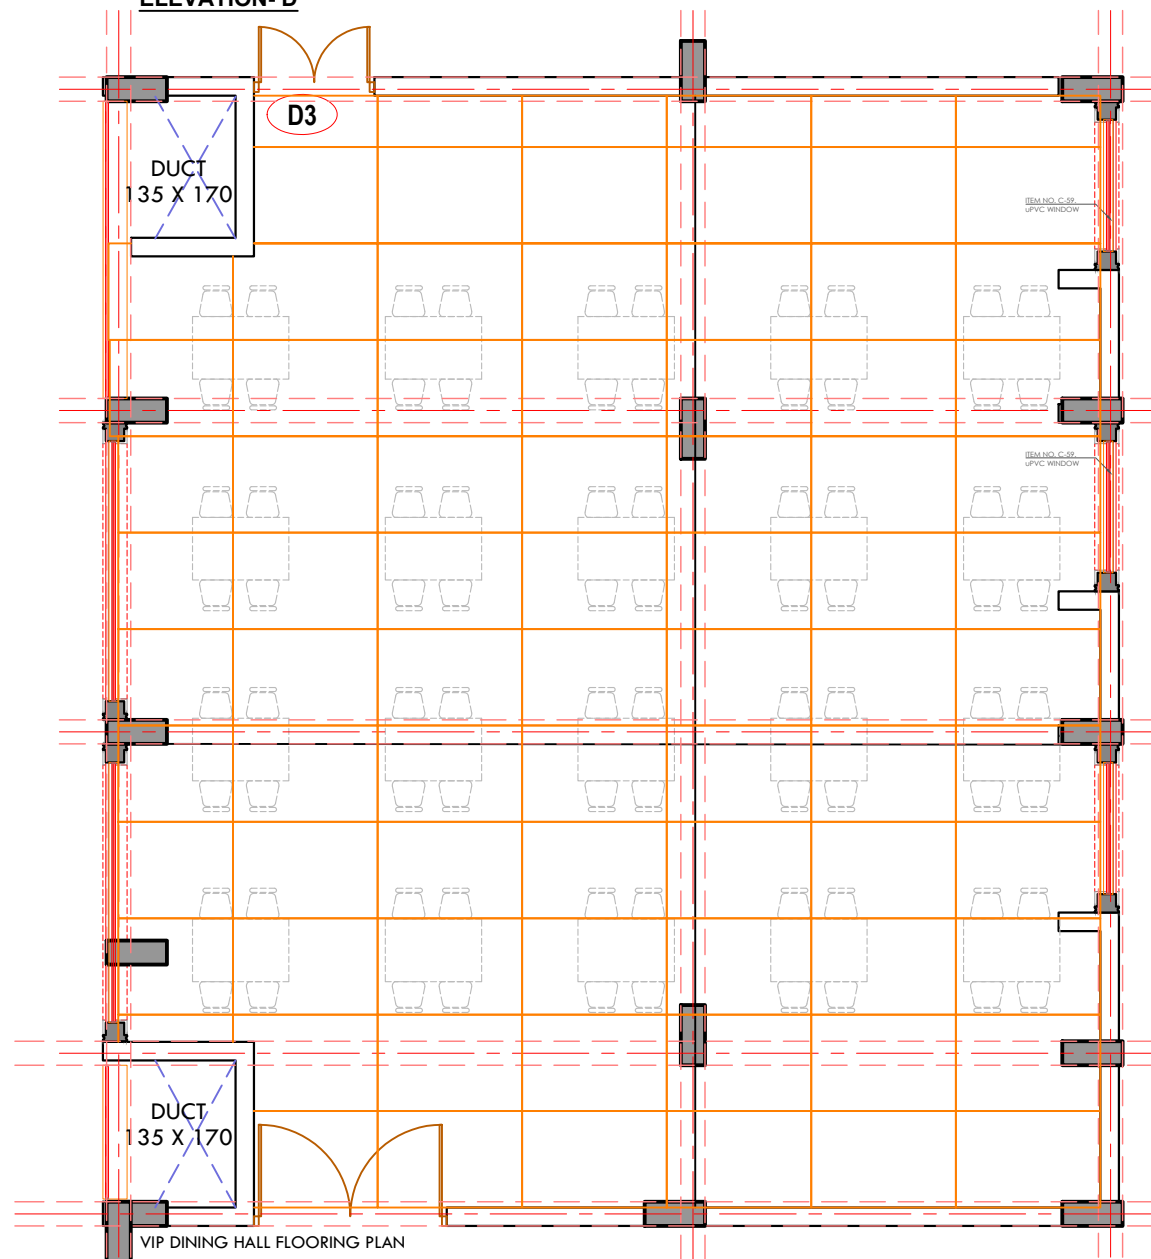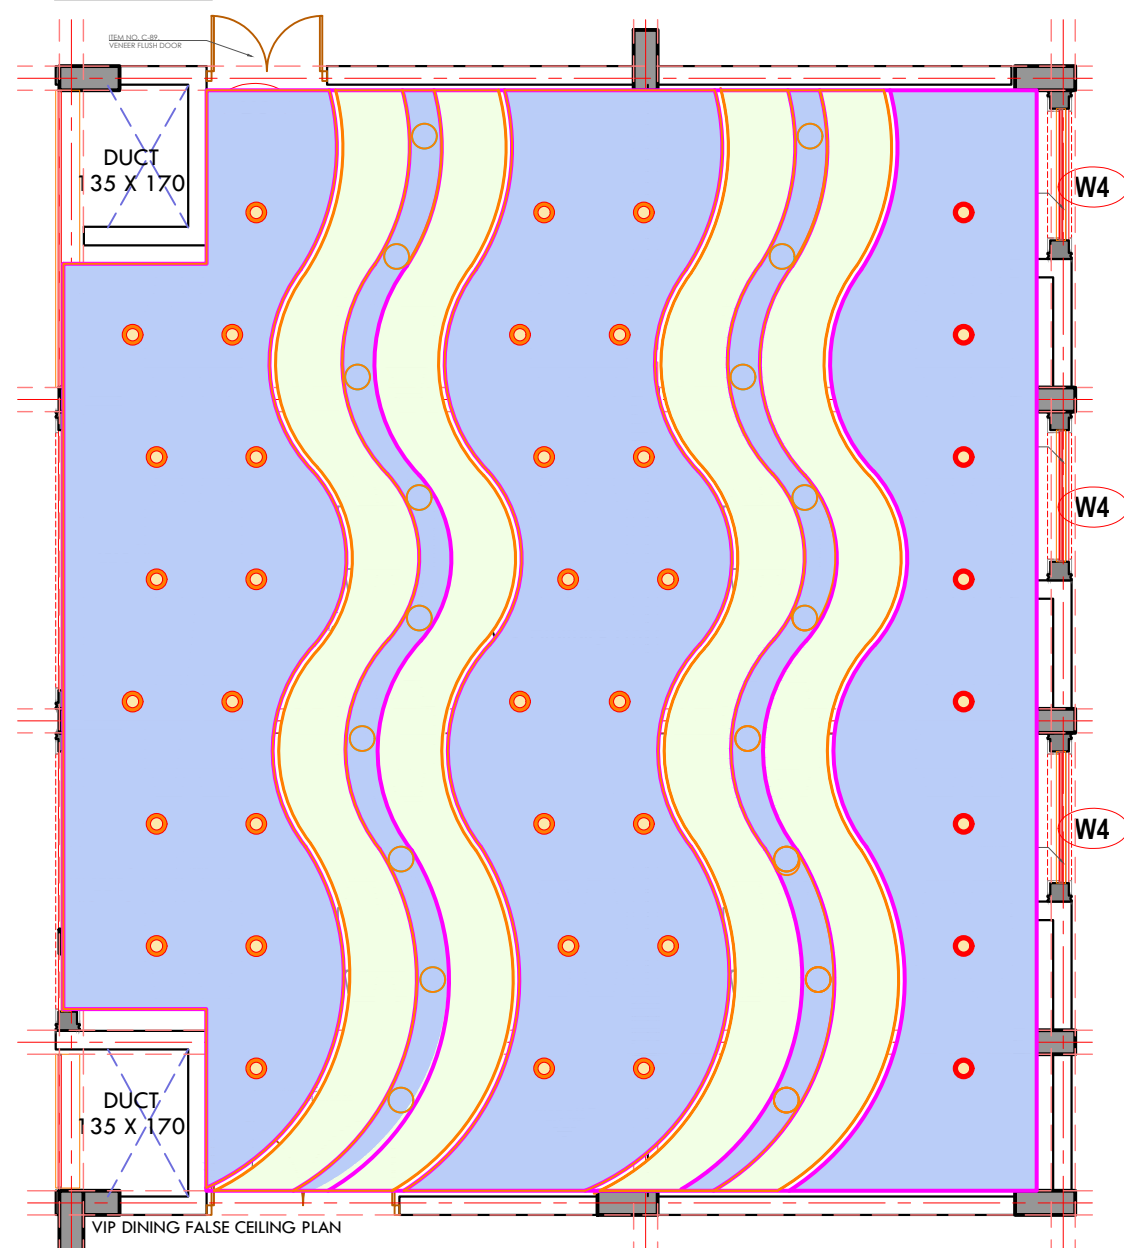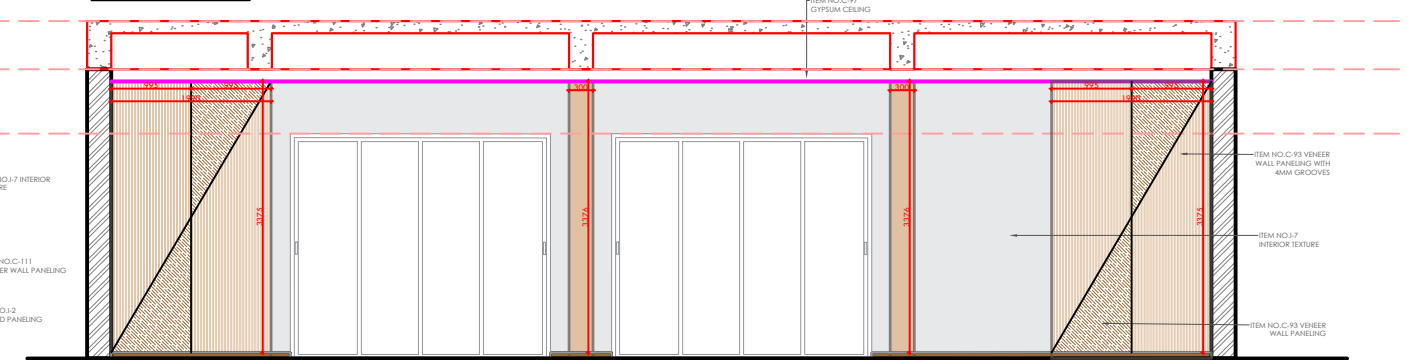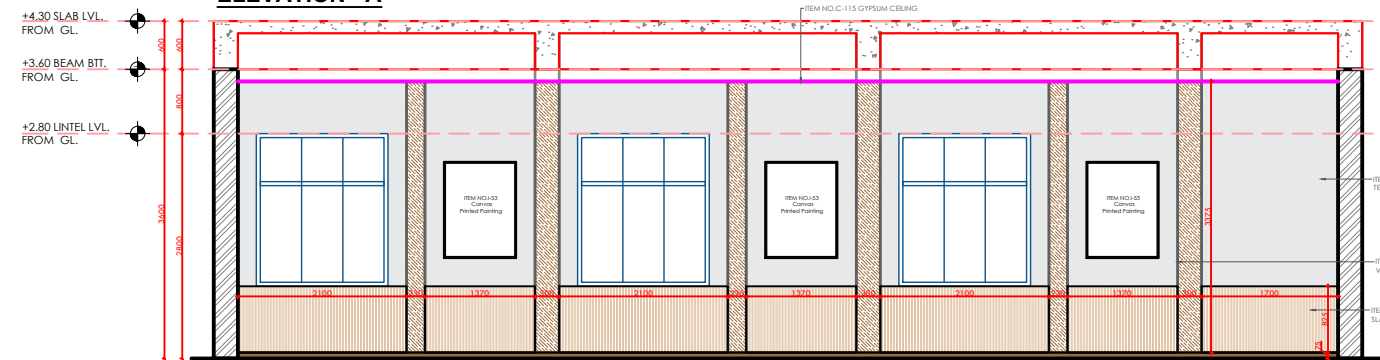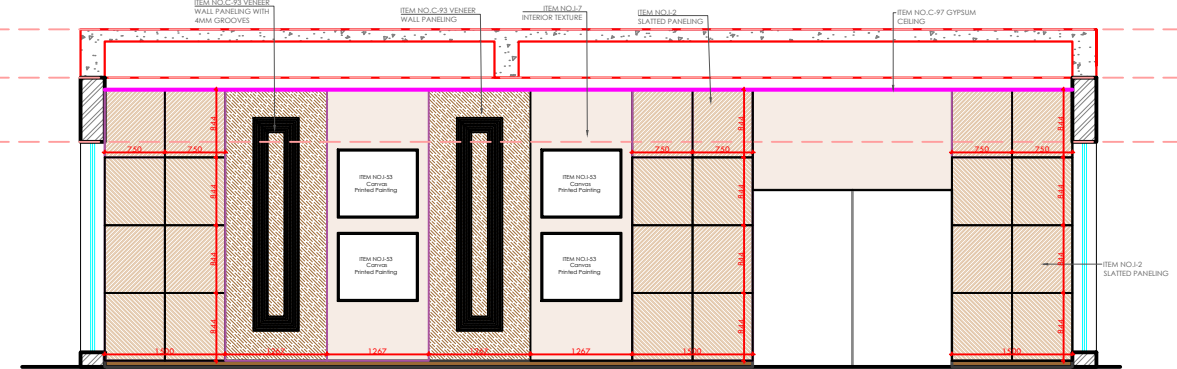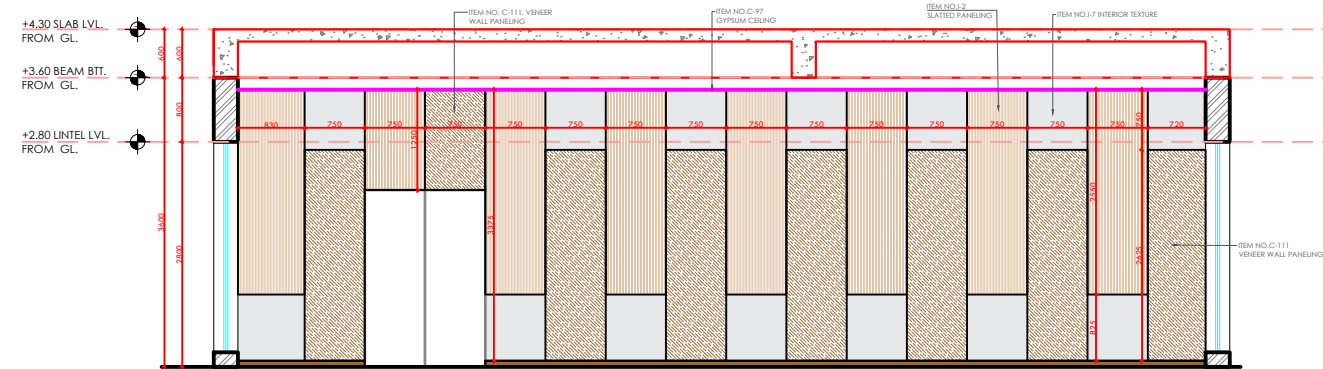

REV	DATE	BRIEF DESCRIPTION	Drawn by			
				Sign		
				Name		
				Designed by	Checked by	Approved by

PROJECT TITLE:
CIRCUIT HOUSE, SHAHIBAUG

DRAWING TITLE : **VIP DINING HALL**

DRAWING NO. :

SCALE : NTS



SHEET : 1 of 3

SHEET SIZE : A3

DATE : 05-02-2026







REVISION

RO

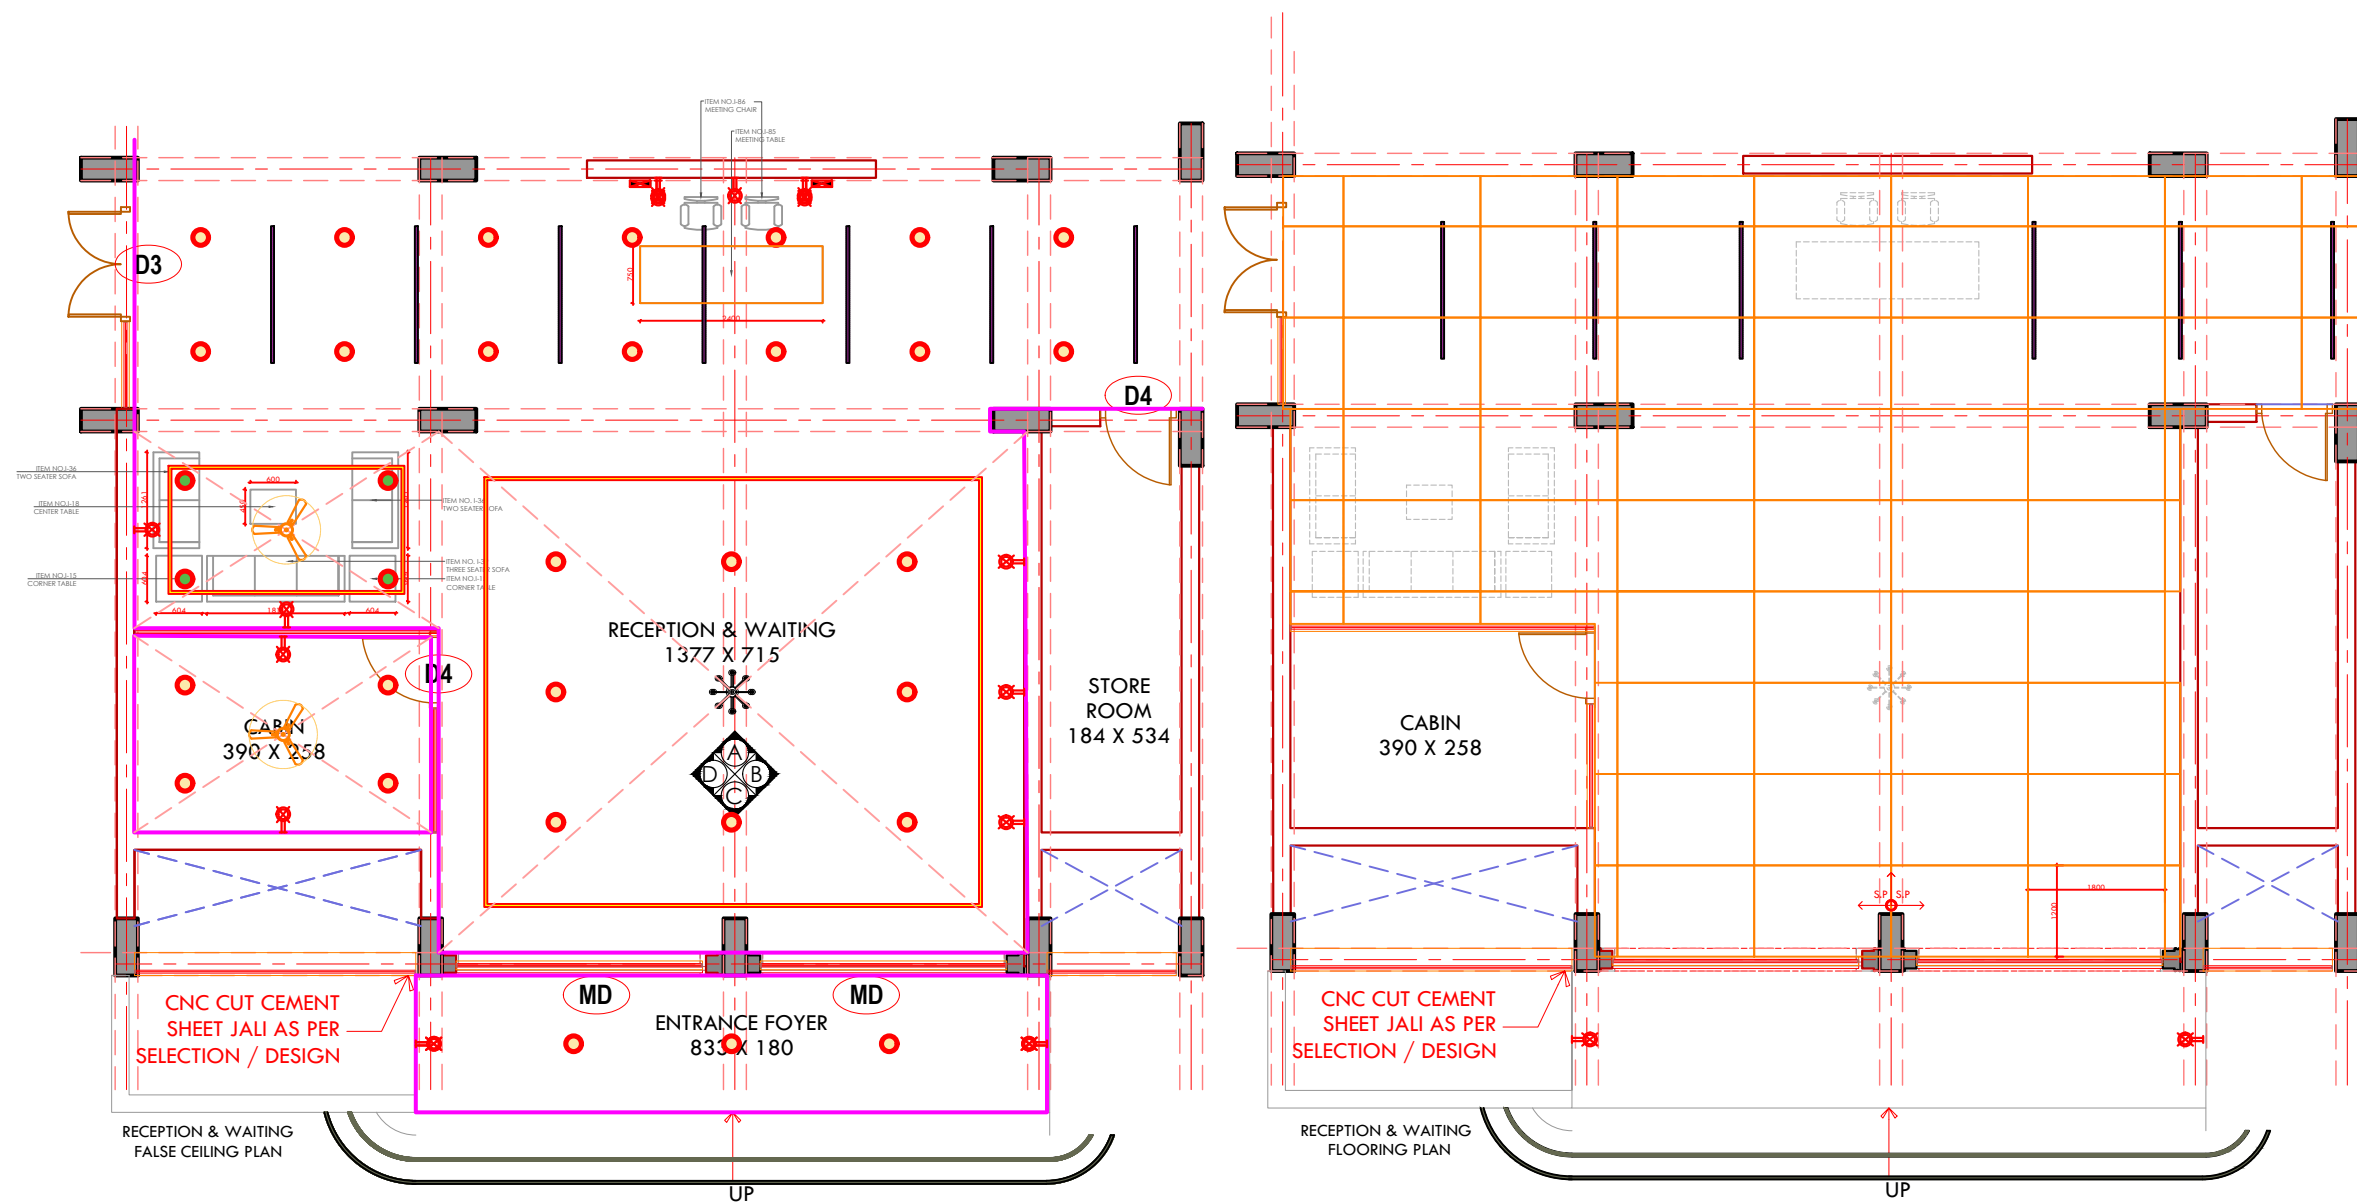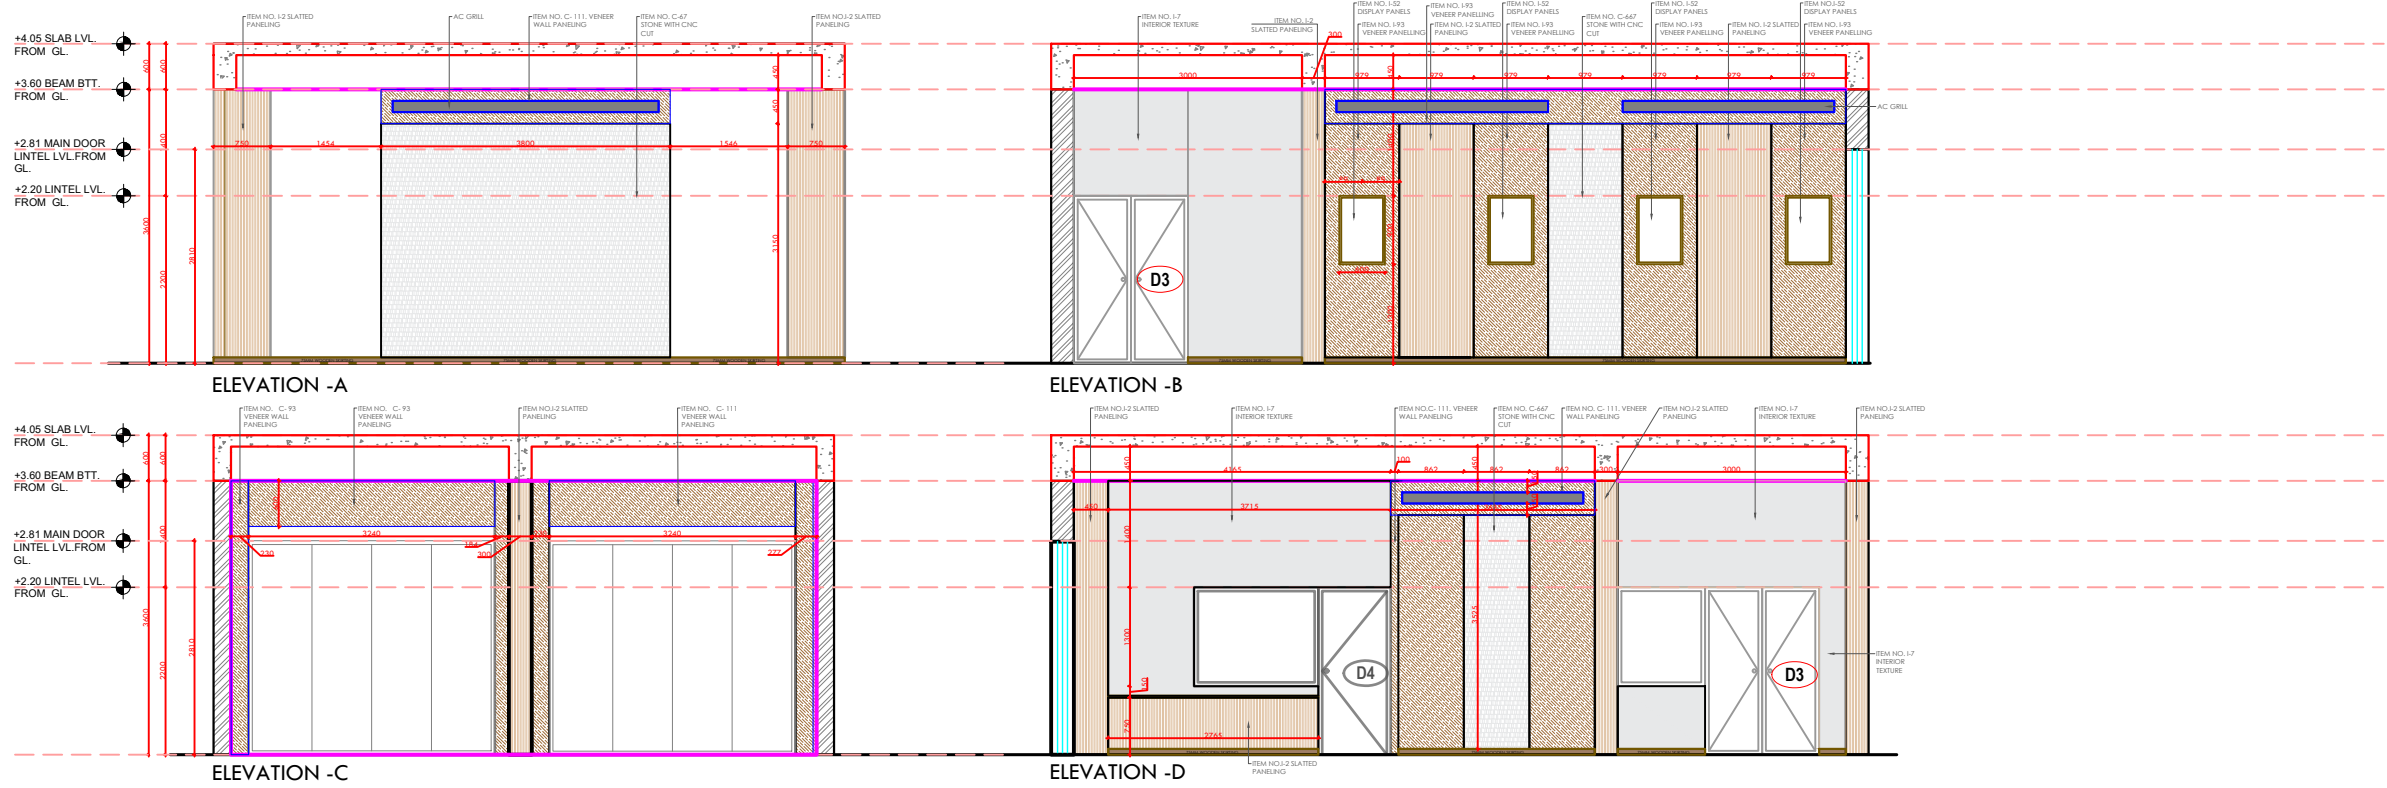

REV	DATE	BRIEF DESCRIPTION	Drawn by	Sign	Name	Designed by	Checked by	Approved by

PROJECT TITLE:	CIRCUIT HOUSE, SHAHIBAUG	REVISION
DRAWING TITLE :	RECEPTION & WAITING AREA	R0
DRAWING NO. :		
SCALE : NTS	SHEET : 1 of 2	DATE : 05-02-2026

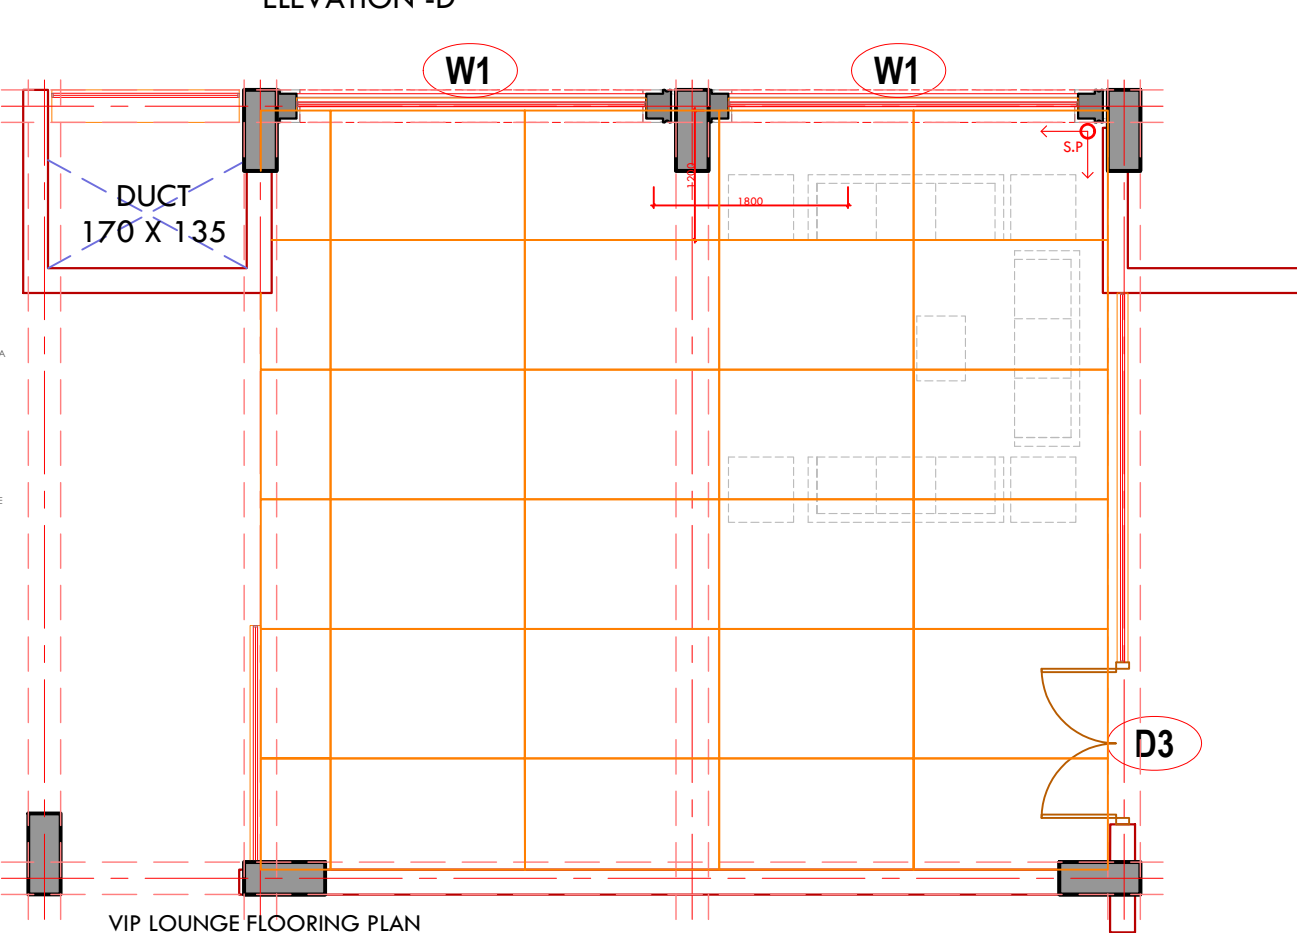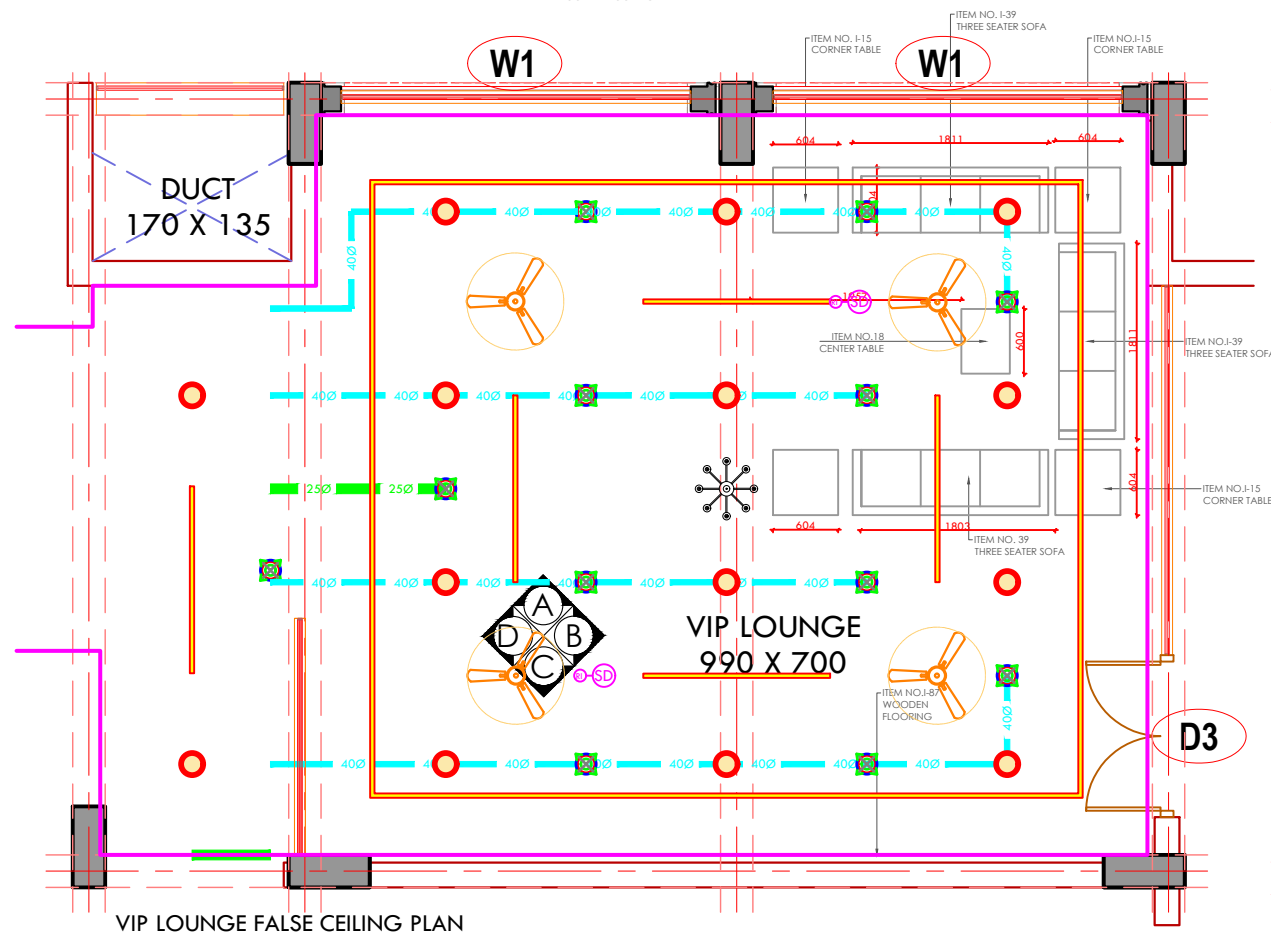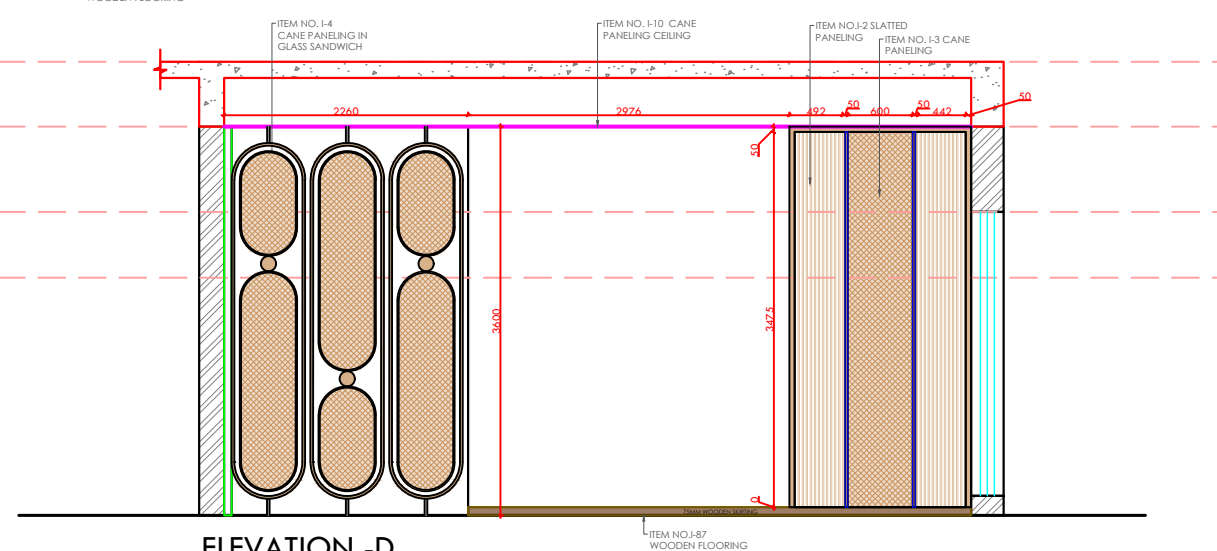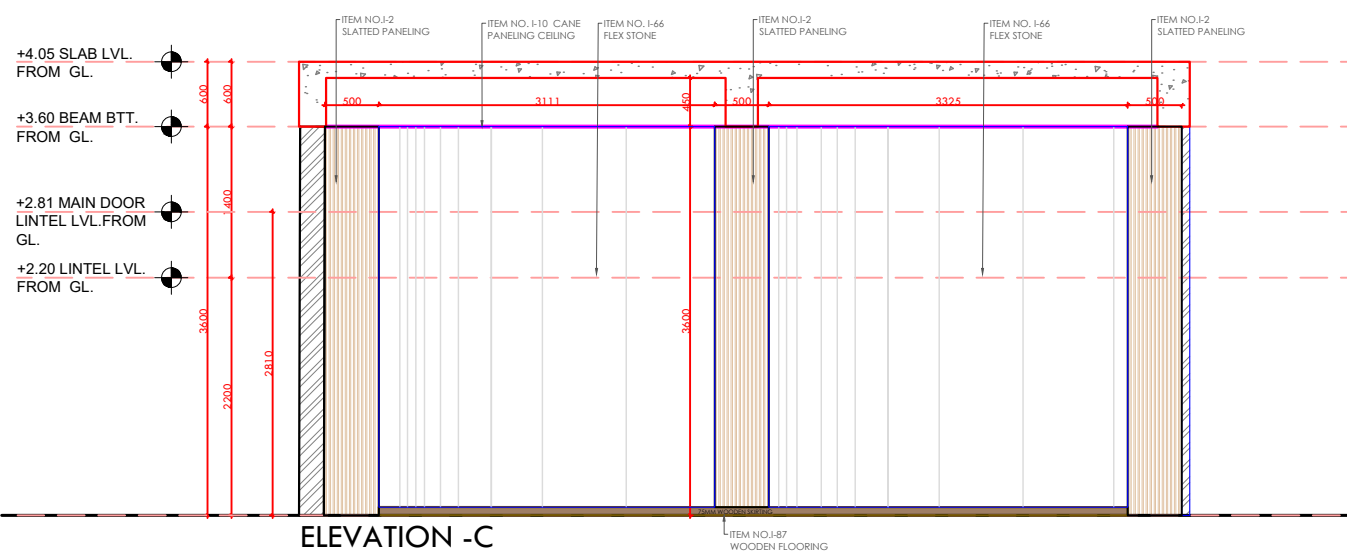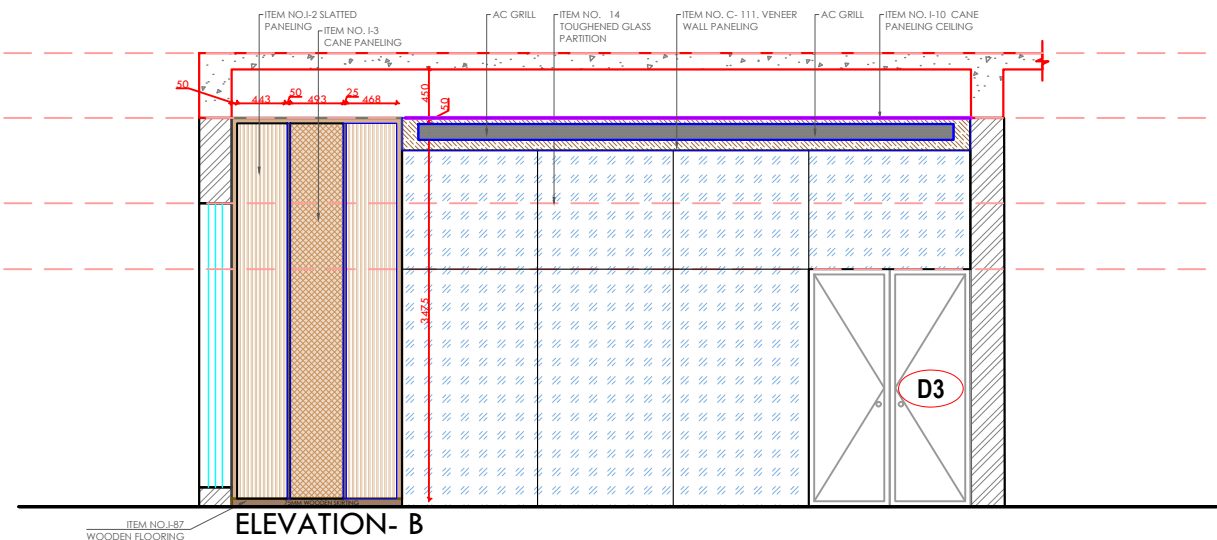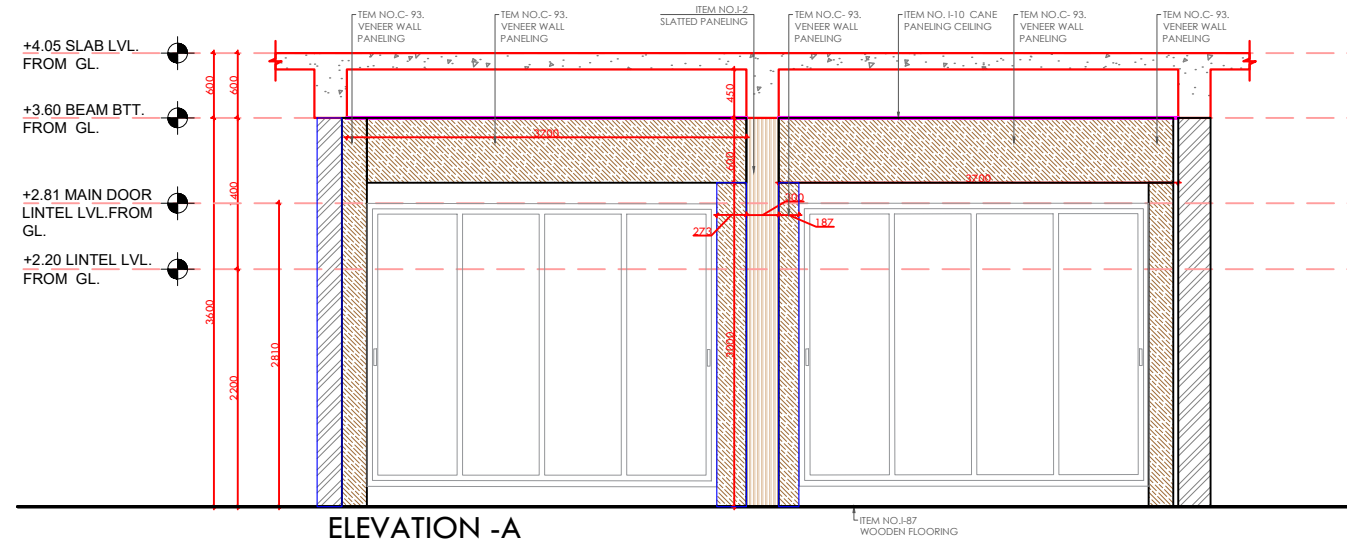

REV	DATE	BRIEF DESCRIPTION	Drawn by	Sign			
				Name			
				Designed by	Checked by	Approved by	

PROJECT TITLE:

CIRCUIT HOUSE, SHAHIBAUG

DRAWING TITLE : **VIP LOUNGE**

DRAWING NO. :

SCALE : NTS





SHEET : 1 of 3

SHEET SIZE :	A3
--------------	-----------




DATE : 05-02-2026

REVISION





R0

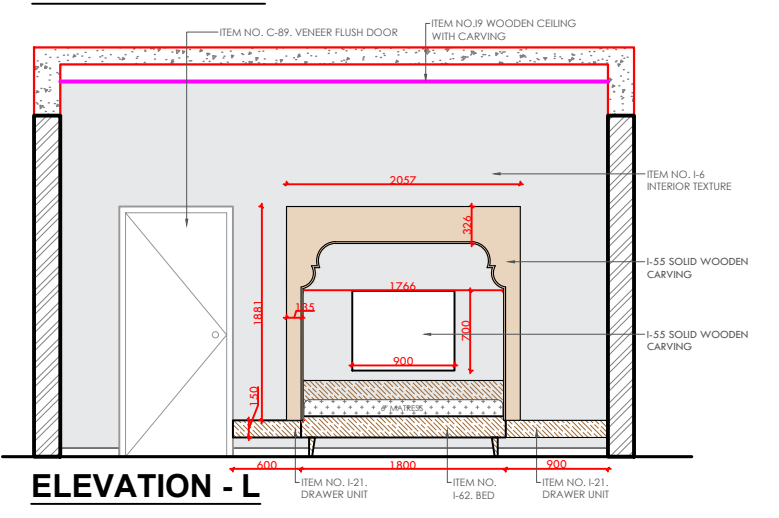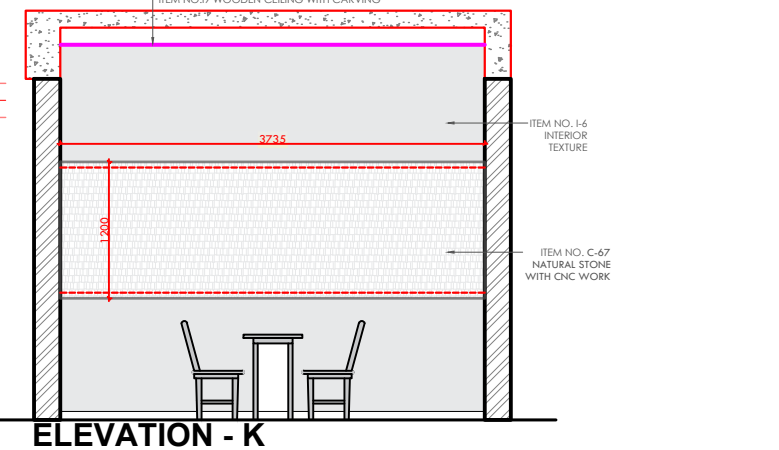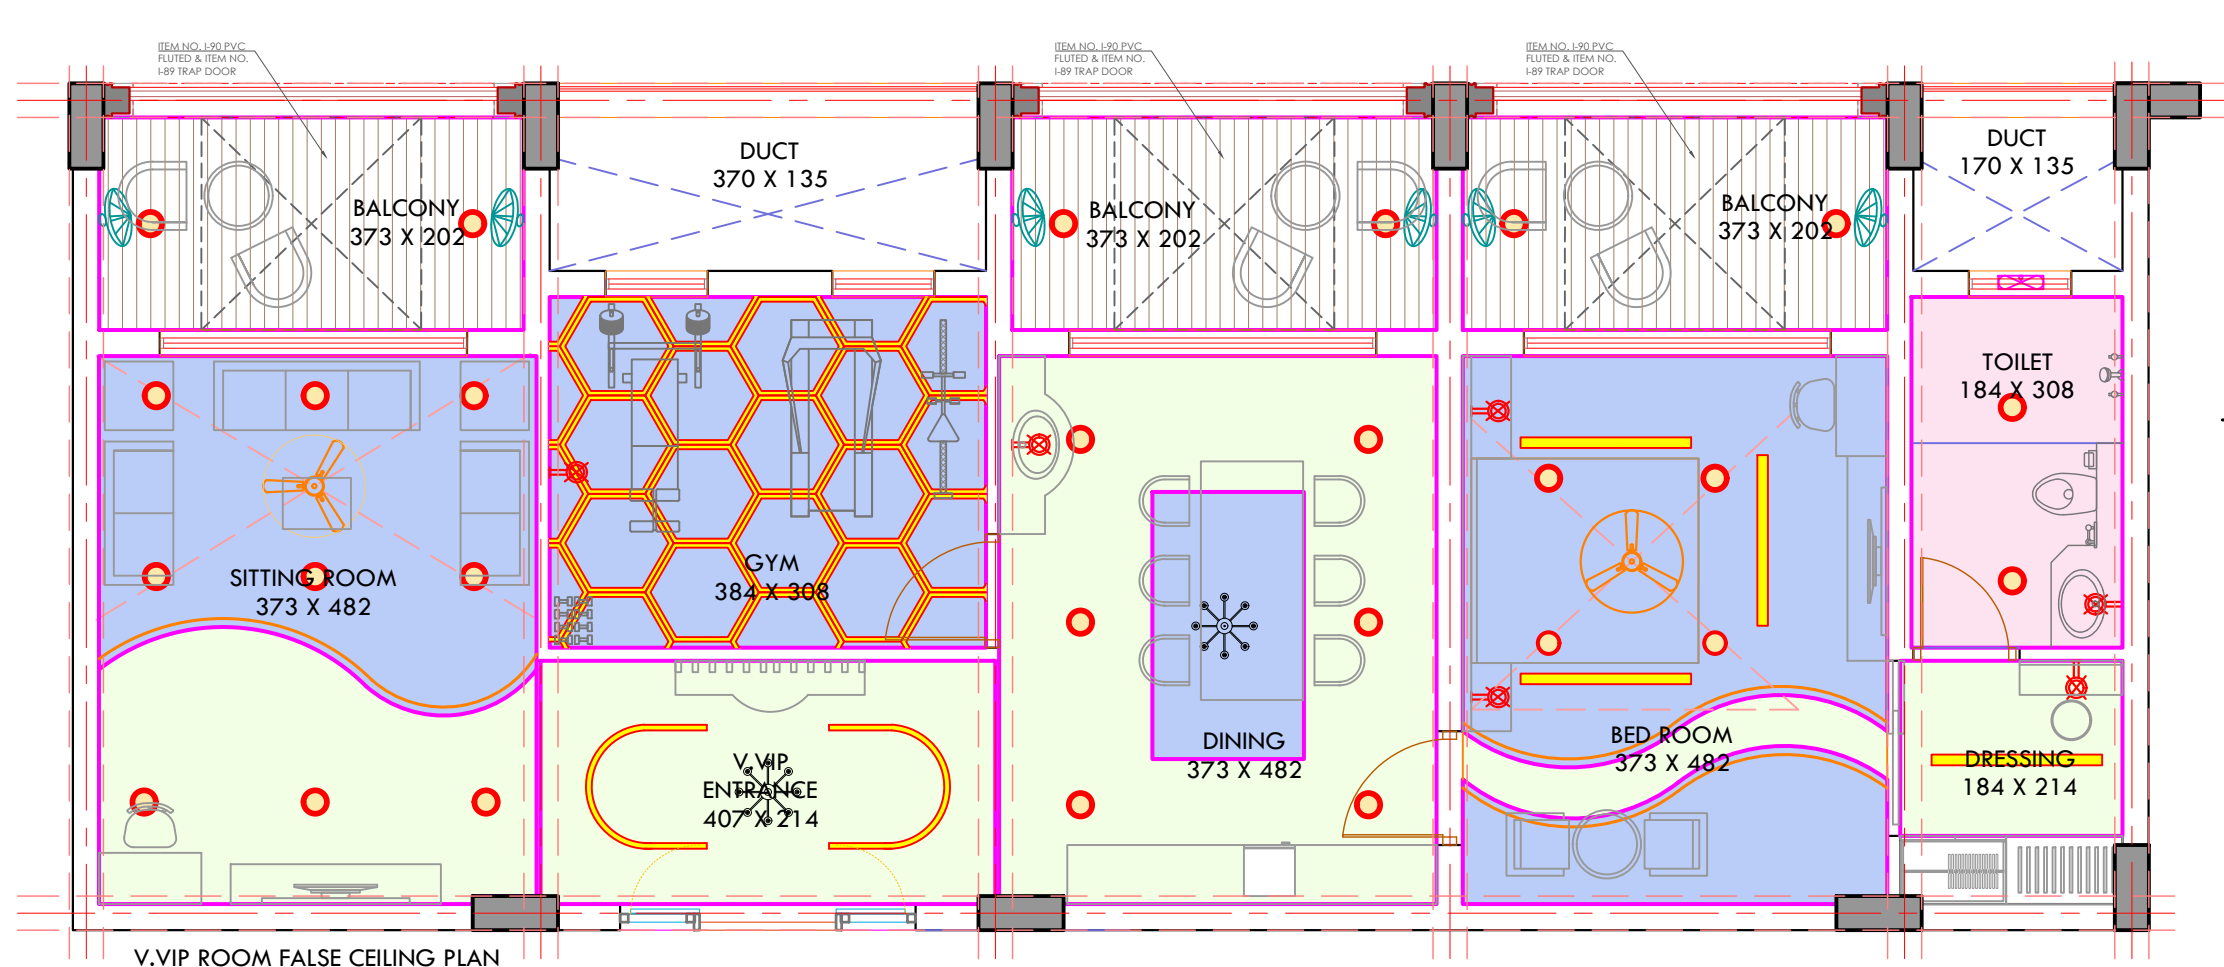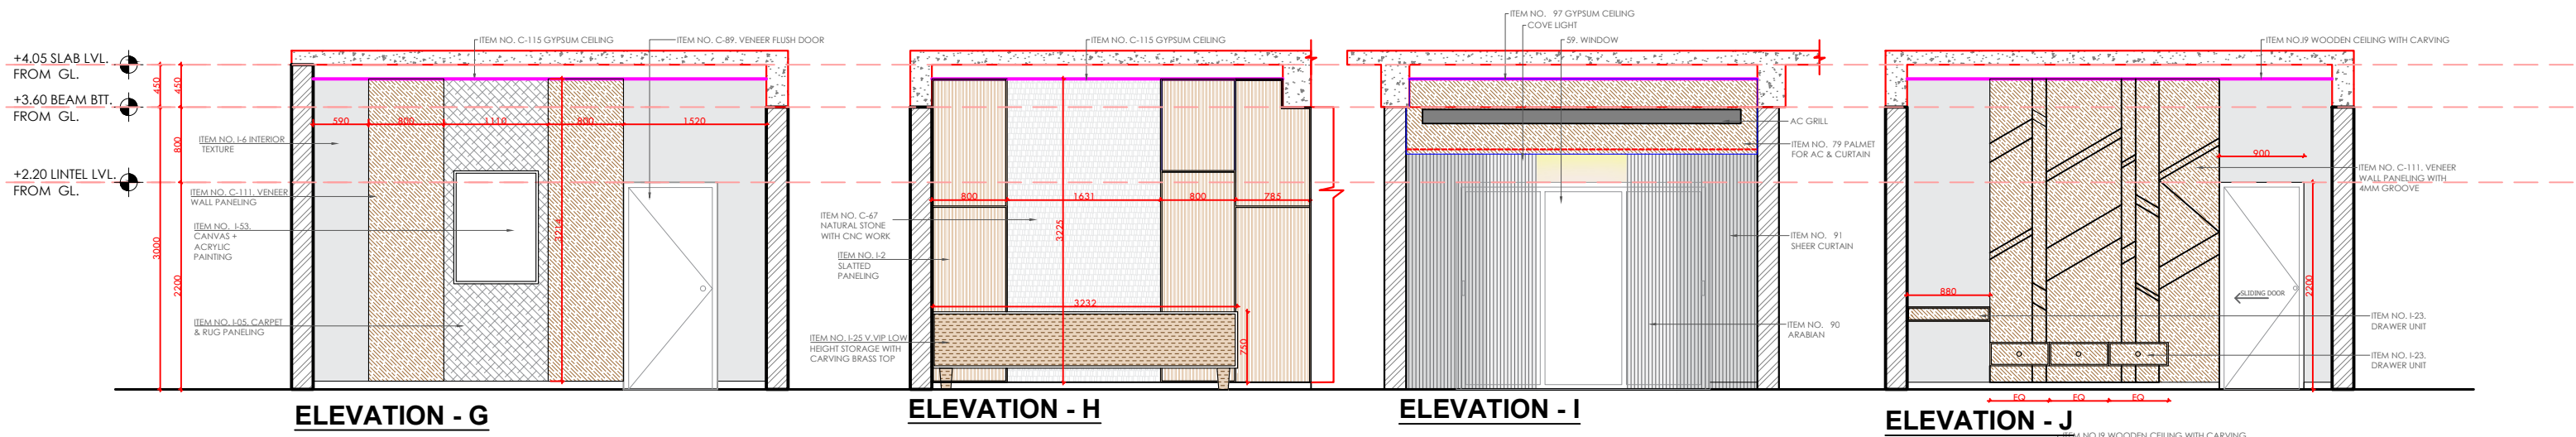


REV	DATE	BRIEF DESCRIPTION	Drawn by	Sign	Name	Designed by	Checked by	Approved by	PROJECT TITLE:	DRAWING TITLE :	DRAWING NO. :	SCALE :	SHEET :	SHEET SIZE :	DATE :	REVISION
									CIRCUIT HOUSE, SHAHIBAUG	V.VIP ROOM		NTS	1 of 5	A3	05-02-2026	R0

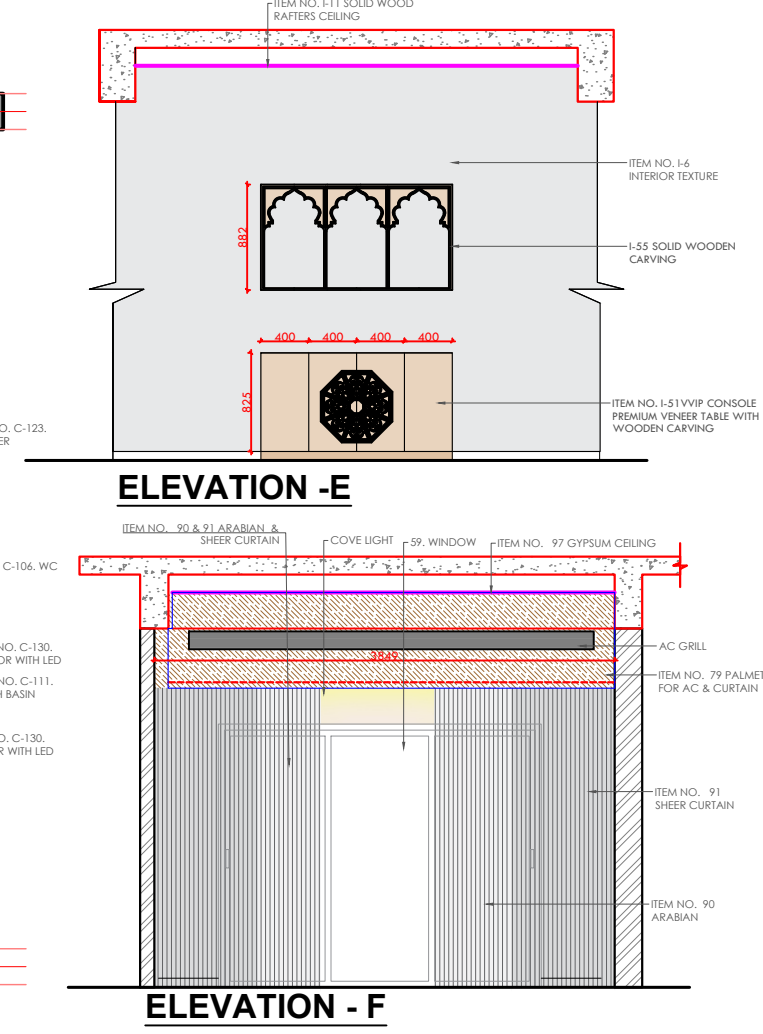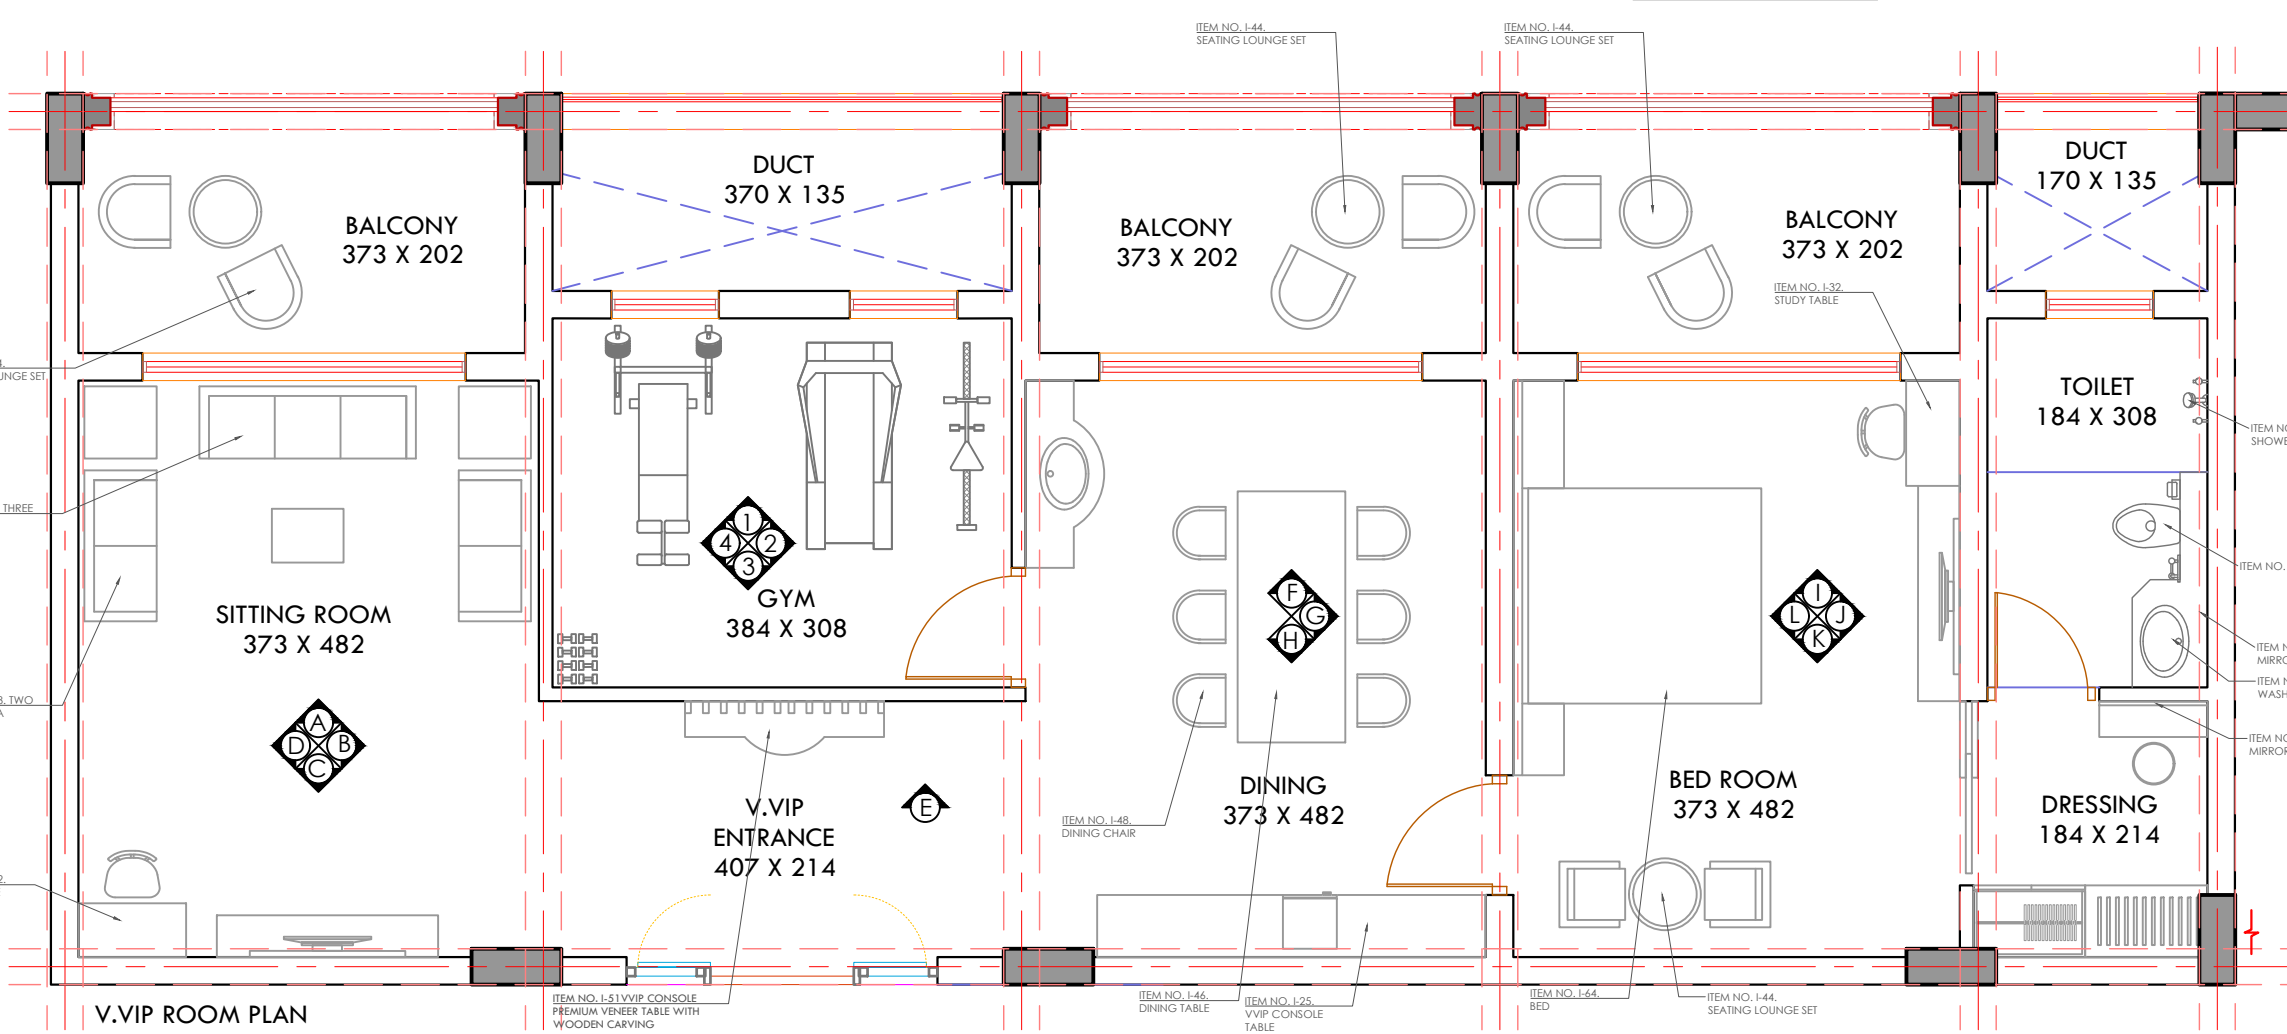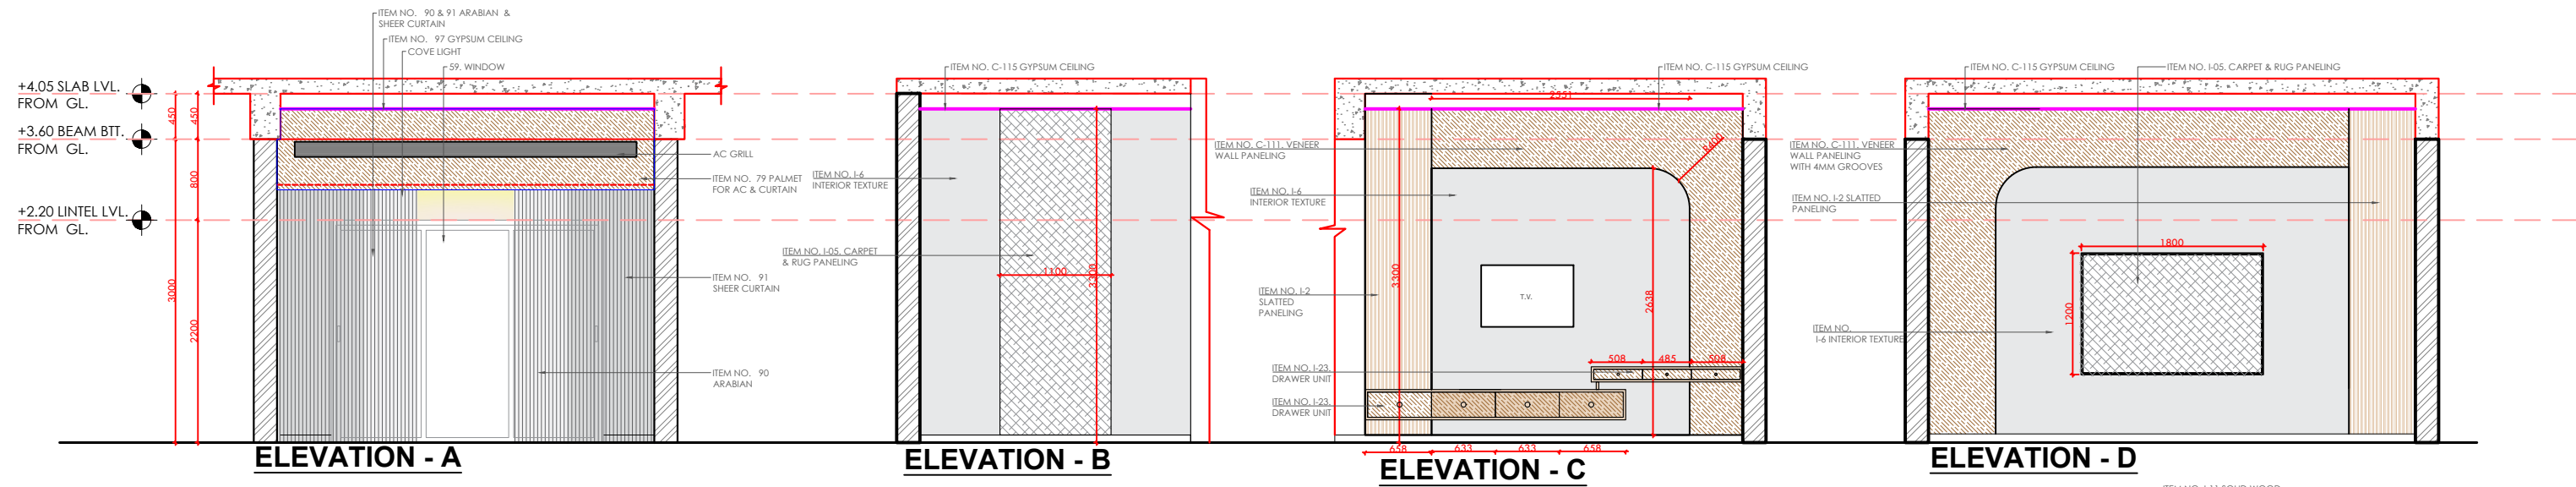




REV	DATE	BRIEF DESCRIPTION	Drawn by	Sign	Name	Designed by	Checked by	Approved by	PROJECT TITLE:	DRAWING TITLE:	DRAWING NO.:	SCALE:	SHEET:	SHEET SIZE:	DATE:	REVISION
									CIRCUIT HOUSE, SHAHIBAUG	V.VIP ROOM		NTS	2 of 5	A3	05-02-2026	R0

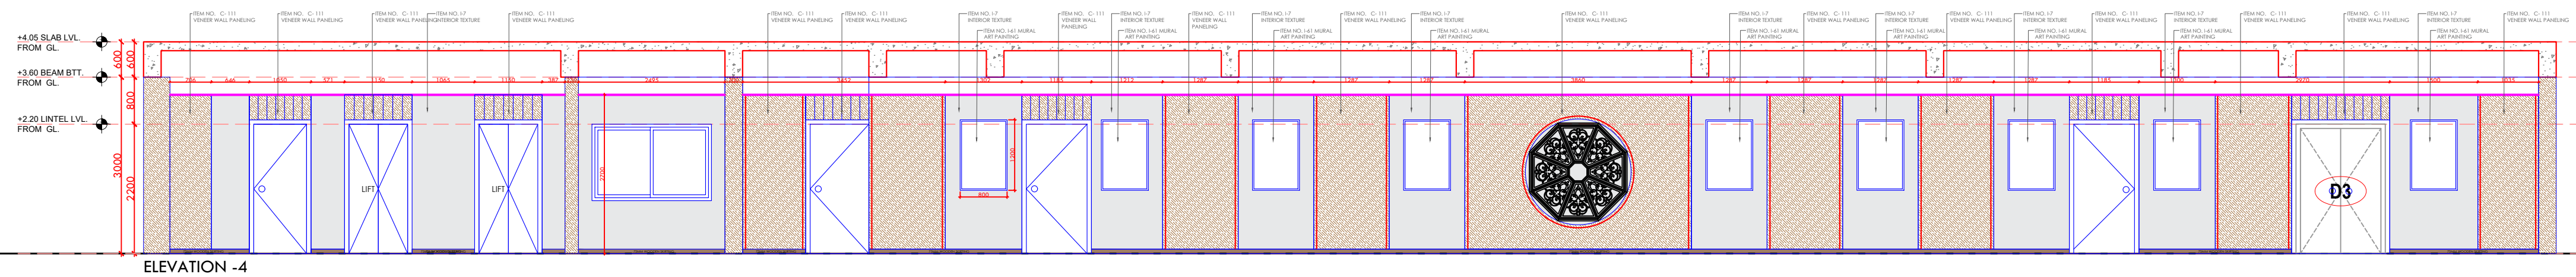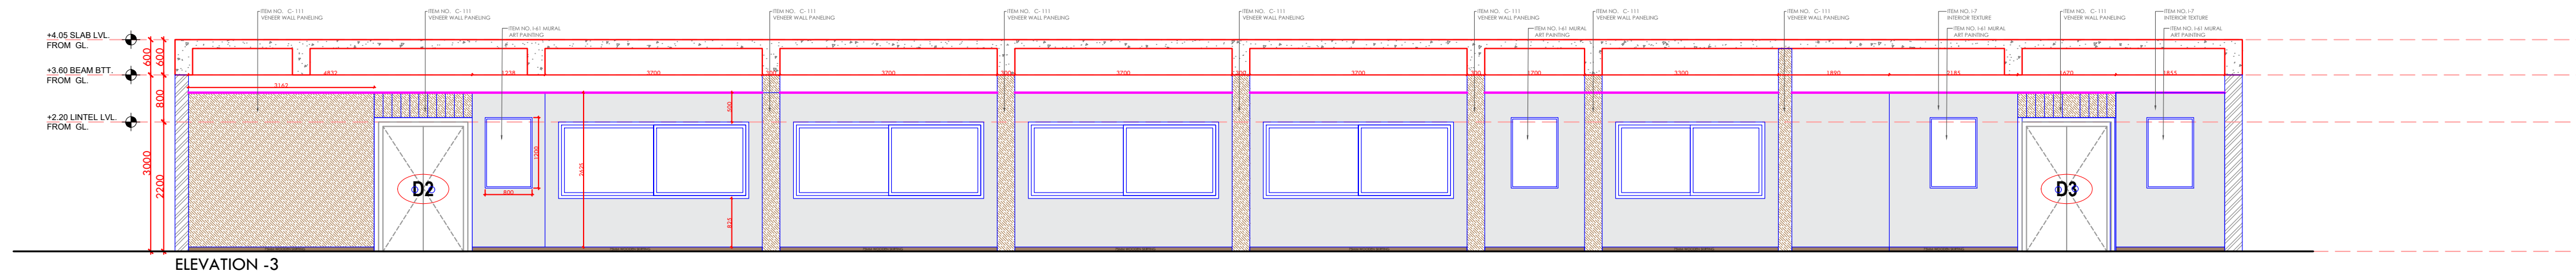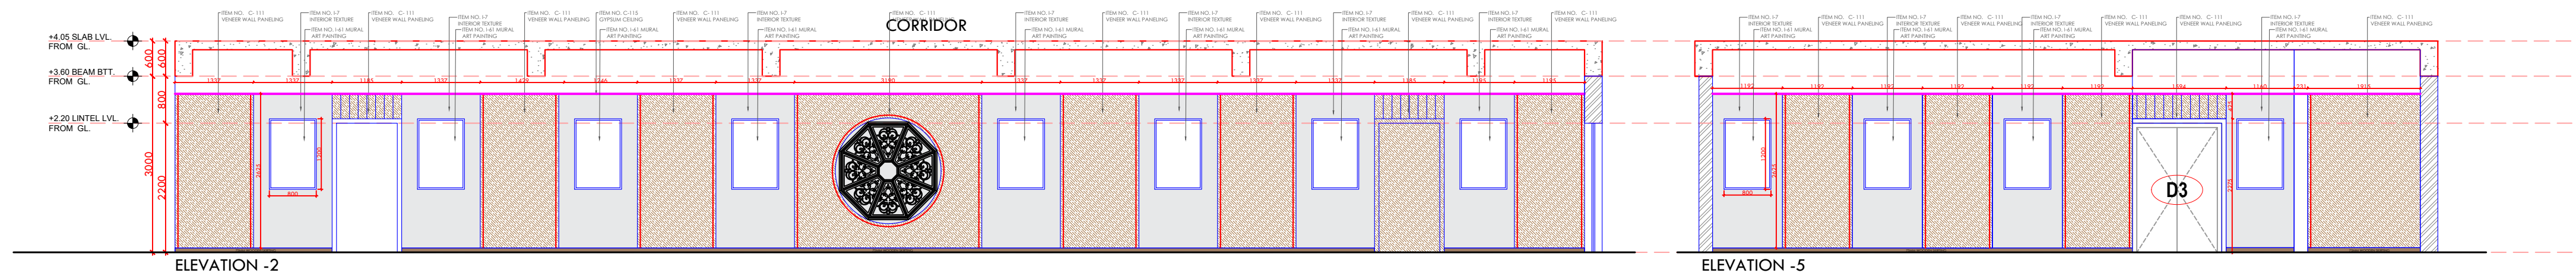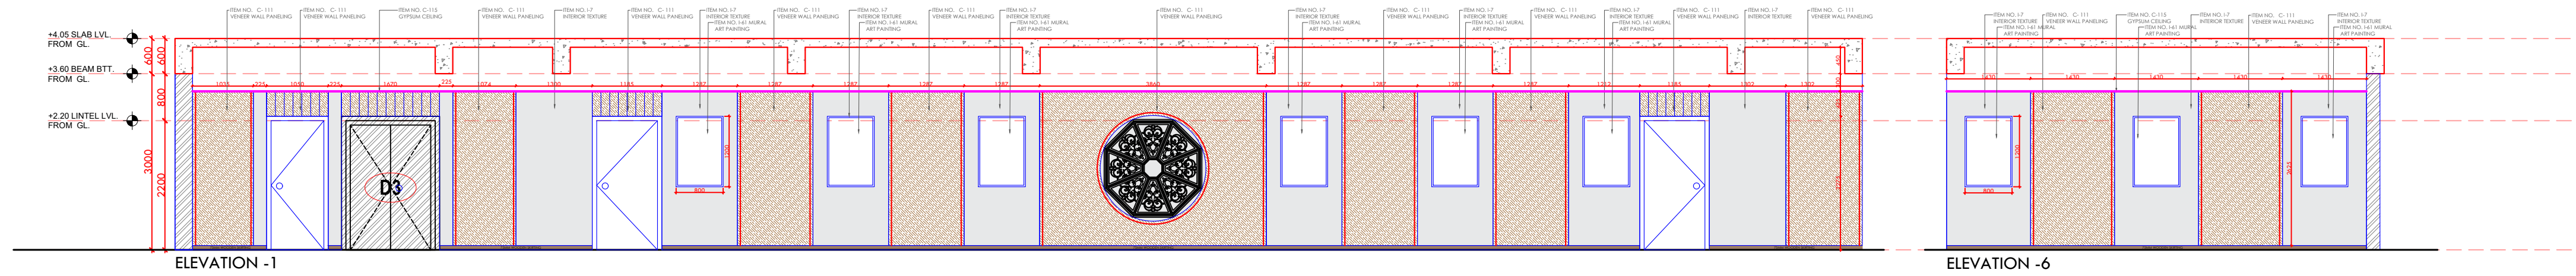

REV	DATE	BRIEF DESCRIPTION	Drawn by					PROJECT TITLE:				
				Sign				CIRCUIT HOUSE, SHAHIBAUG				
								DRAWING TITLE : V.VIP CORRIDOR				REVISION
								DRAWING NO. :				R0
				Name				SCALE : NTS	SHEET : 3 of 5	SHEET SIZE : A3	DATE : 05-02-2026	
				Designed by	Checked by	Approved by						

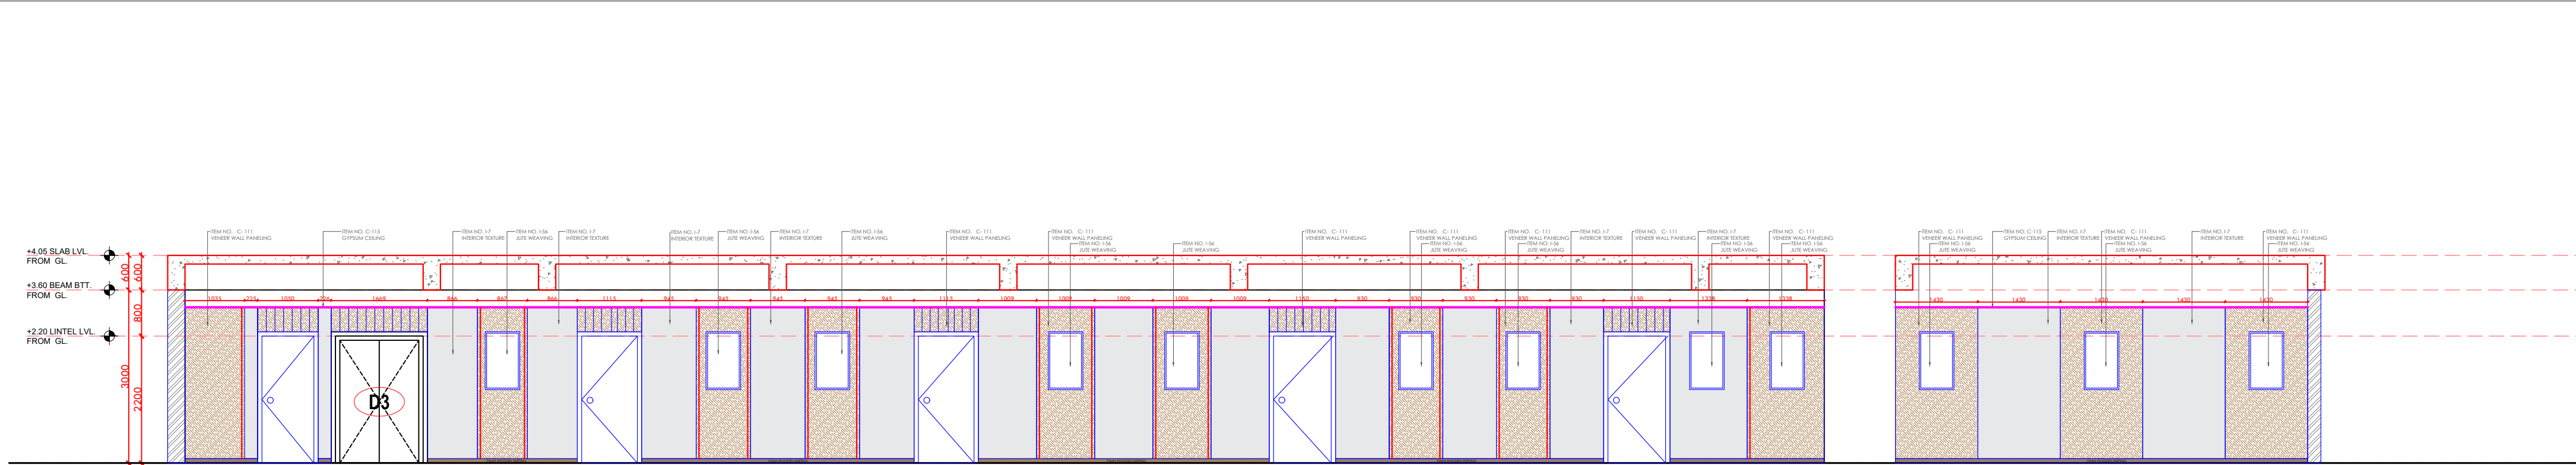

CORRIDOR

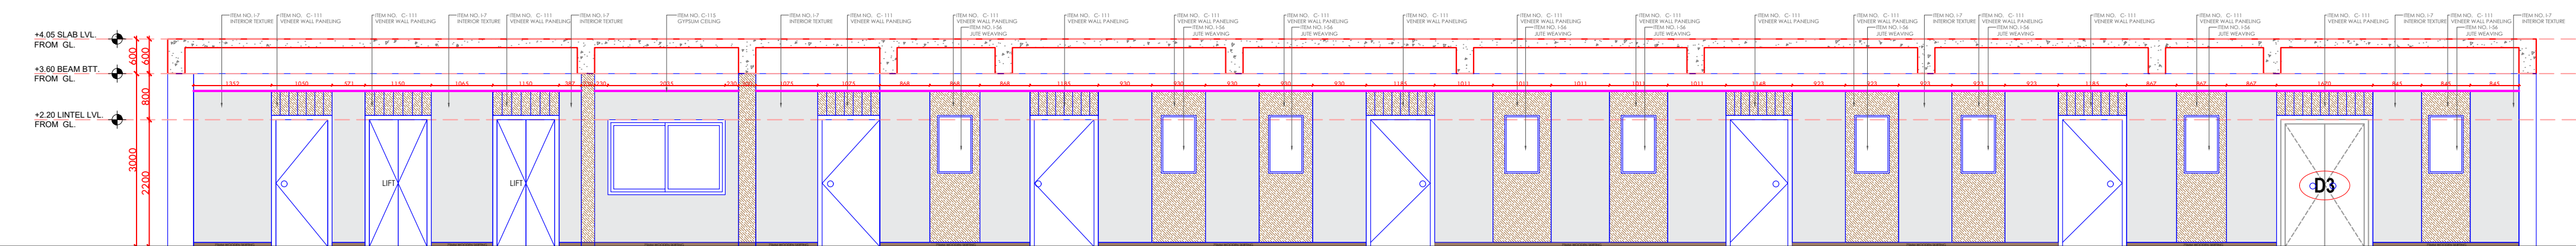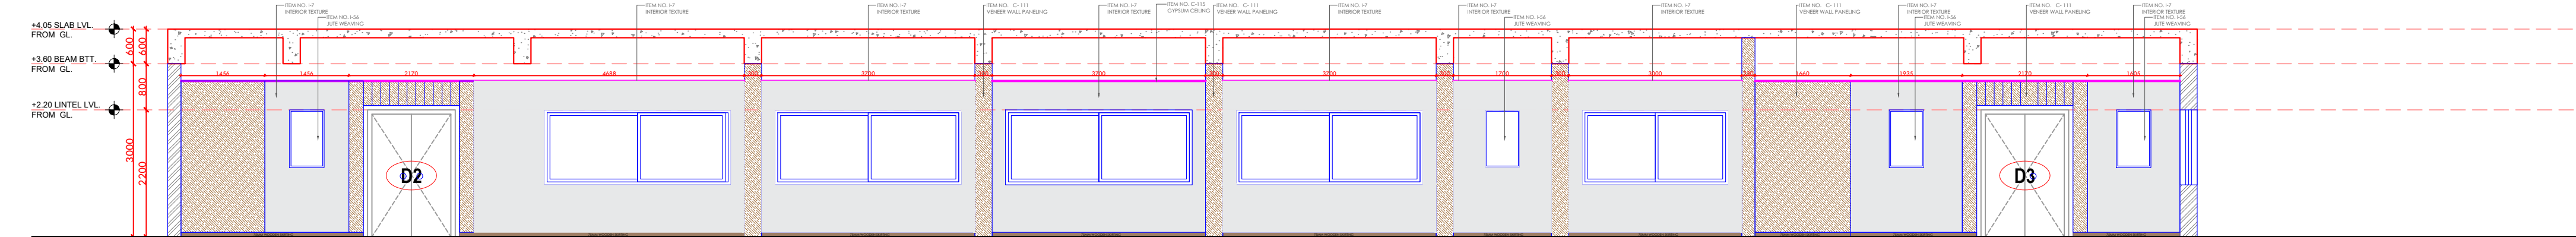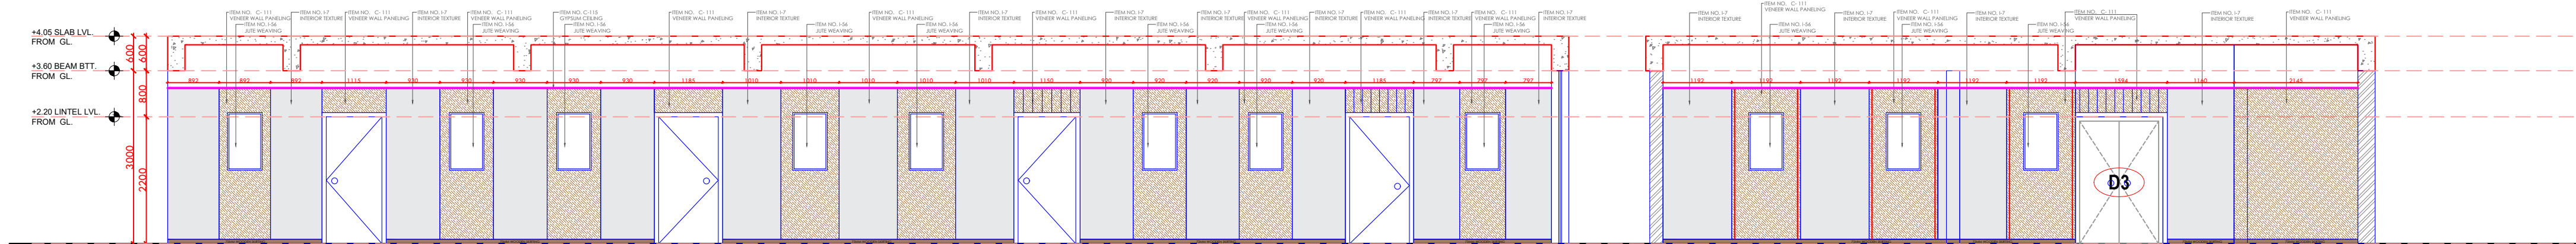

REV	DATE	BRIEF DESCRIPTION	Drawn by					PROJECT TITLE:				
				Sign				CIRCUIT HOUSE, SHAHIBAUG				
								DRAWING TITLE : VIP CORRIDOOR				REVISION
								DRAWING NO. :				R0
					Name			SCALE : NTS	SHEET : 3 of 5	SHEET SIZE : A3	DATE : 05-02-2026	
					Designed by	Checked by	Approved by					



PROJECT TITLE:			
CIRCUIT HOUSE, SHAHIBAUG			
DRAWING TITLE : DELUX CORRIDOOR			REVISION RO
DRAWING NO. :			
SCALE : NTS	SHEET : 3 of 5	SHEET SIZE : A3	
		DATE : 05-02-2026	